
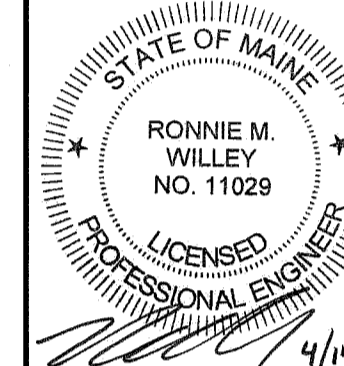
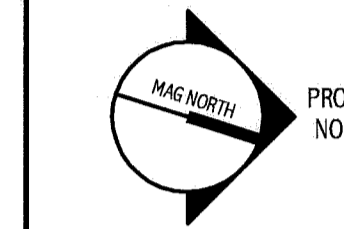


144 Fore Street/P.O. Box 618
 Portland, Maine 04104
 tel. (207) 772-9846
 fax. (207) 772-1070
 www.smrfic.com

ARCHITECTURE
 ENGINEERING
 PLANNING
 INTERIOR DESIGN
 COMMISSIONING

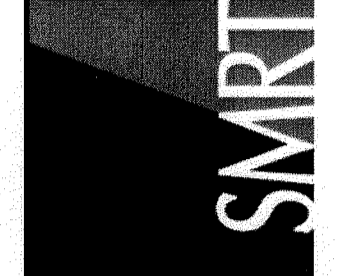

UNIVERSITY OF SOUTHERN MAINE
 SIMULATION LABORATORY
 PORTLAND, MAINE

ISSUED FOR BIDDING & CONSTRUCTION
 4-15-11

REV	DATE	DESCRIPTION
0	4-15-11	ISSUED FOR BIDDING, PERMITS & CONSTRUCTION

GRAPHIC SCALE: 0" = 1"
 SCALE: NOT TO SCALE
 PROJECT MANAGER: SLB
 JC/DRAWN BY: BAL
 A/E OF RECORD: RMW
 CAD FILE: PL601-10150
 PROJECT NO: 10150-00
 DATE: 4-15-11
 SHEET TITLE: SCHEDULES
 SHEET No. PL601
 © COPYRIGHT 2010 SMRF INC.

SHOCK ABSORBER SCHEDULE

TYPE	FIXTURE UNIT RATING	BASIS OF DESIGN	
		MANUF.	FIGURE NO.
'A'	1-10	ZURN	100
'B'	12-32	ZURN	200

FIXTURE CONNECTION SCHEDULE

FIXTURE	CW	HW	WASTE	VENT	NOTES
SINK	1/2"	1/2"	1-1/2"	1-1/2"	1

NOTES: 1. PROVIDE SHOCK ABSORBER W/ ISOLATION VALVE, ACCESSIBLE.

PLUMBING PUMP SCHEDULE

TAG	LOCATION	SERVICE	GPM	HD (FT.)	ELECTRICAL DATA				TYPICAL UNIT MFG & MODEL NO.	NOTES
					HP	RPM	VOLTS	PH		
CP-1	NURSE	CONDENSATE DRAINAGE	2	10	1/10	-	115	1	ASPEN PUMPS "MINI BLANC"	1
CP-2	MEDS	CONDENSATE DRAINAGE	2	10	1/10	-	115	1	ASPEN PUMPS "MINI BLANC"	1

NOTES:

PLUMBING SPECIALTIES SCHEDULE


TAG	APPLICATION	TYPICAL UNIT MFG & MODEL NO.	DESCRIPTION	NOTES
EE-A	EMERGENCY EYE/FACE WASH MIXING VALVE	LEONARD #TA-300-CP-IT-TOP	FAIL COLD, 10 PSIG MAX. DROP AT 4 GPM FLOWING, CHROME PLATED, TOP INLETS, INLET THERMOMETERS.	1
EE-B	EMERGENCY EYE/FACE WASH	GUARDIAN #G1774	DECK MOUNTED "AUTO FLOW", 90 DEGREE SWIVEL EYEWASH, STAY OPEN VALVE.	1

NOTES: 1. PROVIDE "EMERGENCY EYEWASH" SIGN.


PLUMBING FIXTURE SCHEDULE

TAG	DESCRIPTION	FIXTURE	FAUCET/DRAIN	TRIM	SUPPORT	NOTES
SK-A	SURFACE MOUNT SINK - ADA	INTEGRAL WITH CASE WORK	CHICAGO FAUCET MODEL 201-AGN8AE29-317CP, DRAIN AND OFFSET TAILPIECE, CHROME, PLATED FINISHES.	MCGUIRE ANGLE STOPS, P-TRAP, ESCUTCHEONS AND RISERS - CHROME PLATED	INTEGRAL	1
SK-B	SINK - ADA	JUST MODEL # SL-ADA-2019	CHICAGO FAUCET MODEL 201-AGN8AE29-317CP, JUST #J-35-FS DRAIN AND OFFSET TAILPIECE, CHROME, PLATED FINISHES.	MCGUIRE ANGLE STOPS, P-TRAP, ESCUTCHEONS AND RISERS - CHROME PLATED		
SK-C	SINK - ADA	JUST MODEL # SLX-1921	CHICAGO FAUCET MODEL 201-AGN8AE29-317CP, JUST #J-35-FS DRAIN AND OFFSET TAILPIECE, CHROME, PLATED FINISHES.	MCGUIRE ANGLE STOPS, P-TRAP, ESCUTCHEONS AND RISERS - CHROME PLATED		


NOTES: 1. INSULATE EXPOSED PIPING - TRUEBRO #102G.

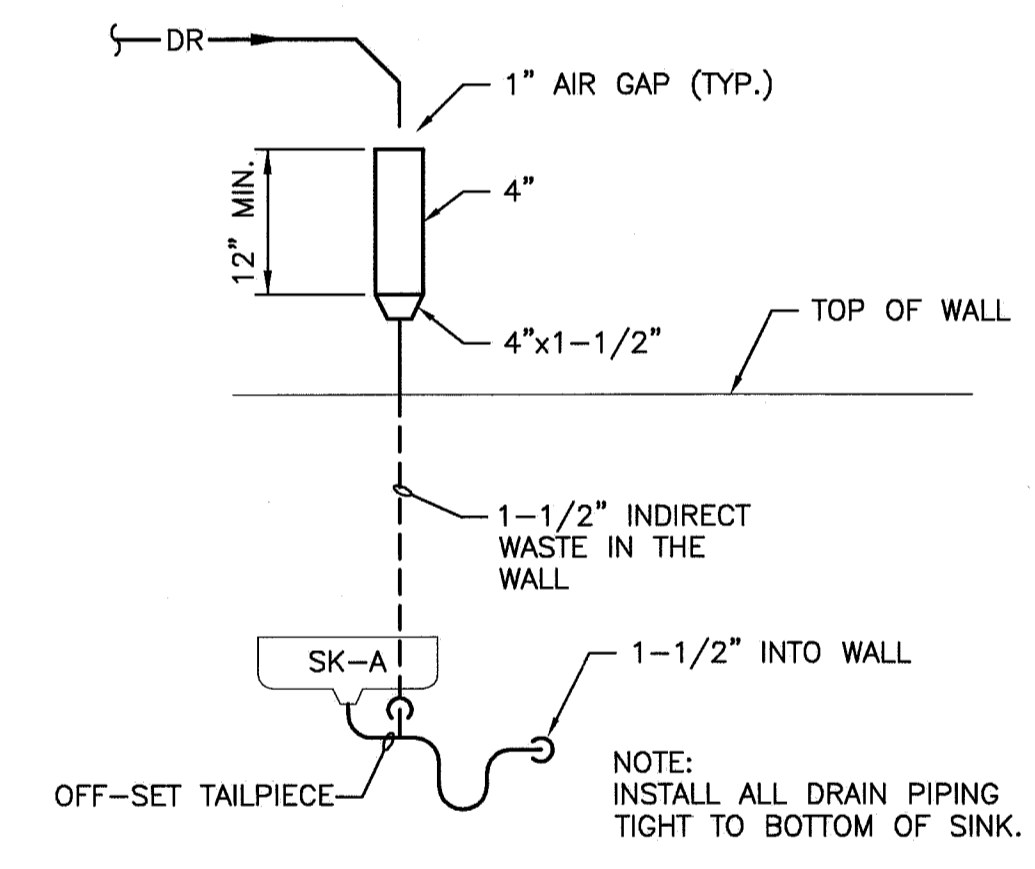

D1 INDIRECT WASTE CONNECTION
 NOT TO SCALE

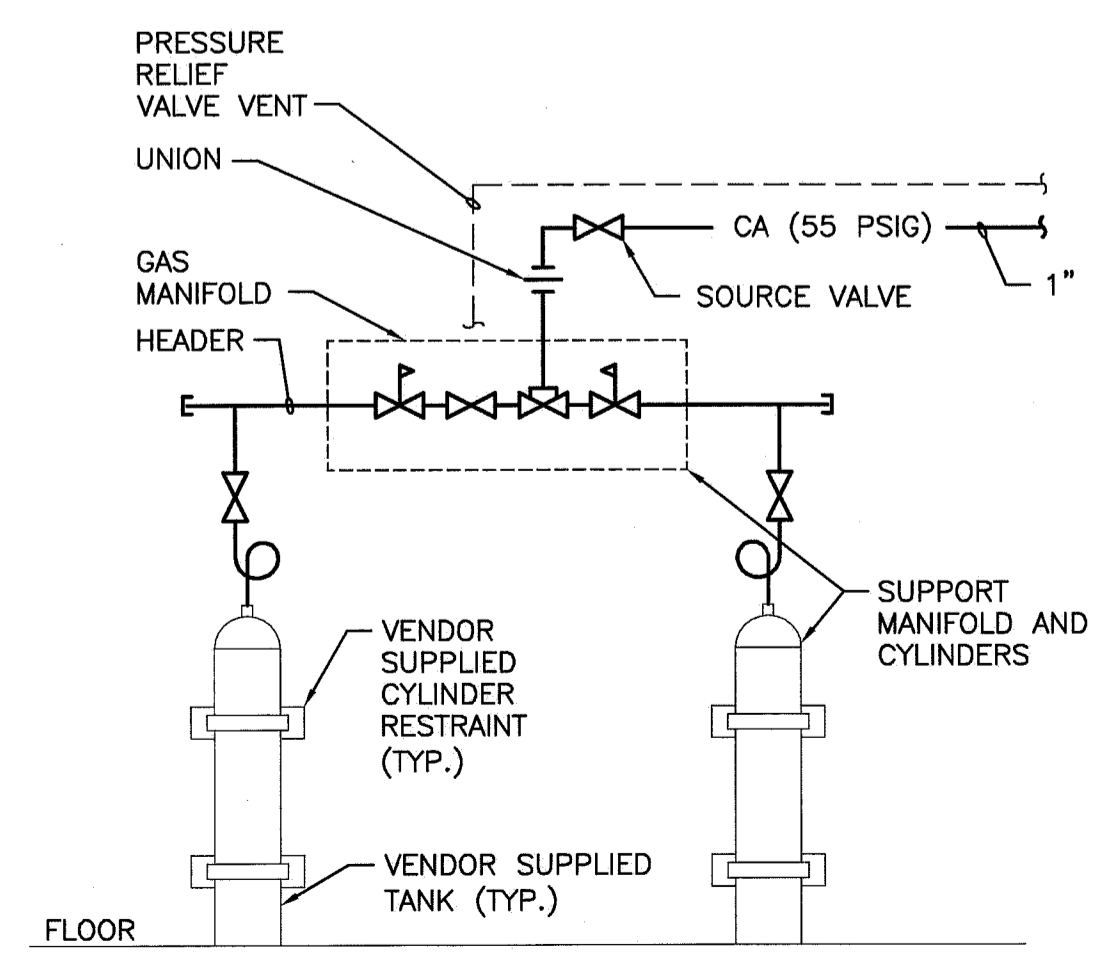

A1 CA CYLINDER DETAIL
 NOT TO SCALE

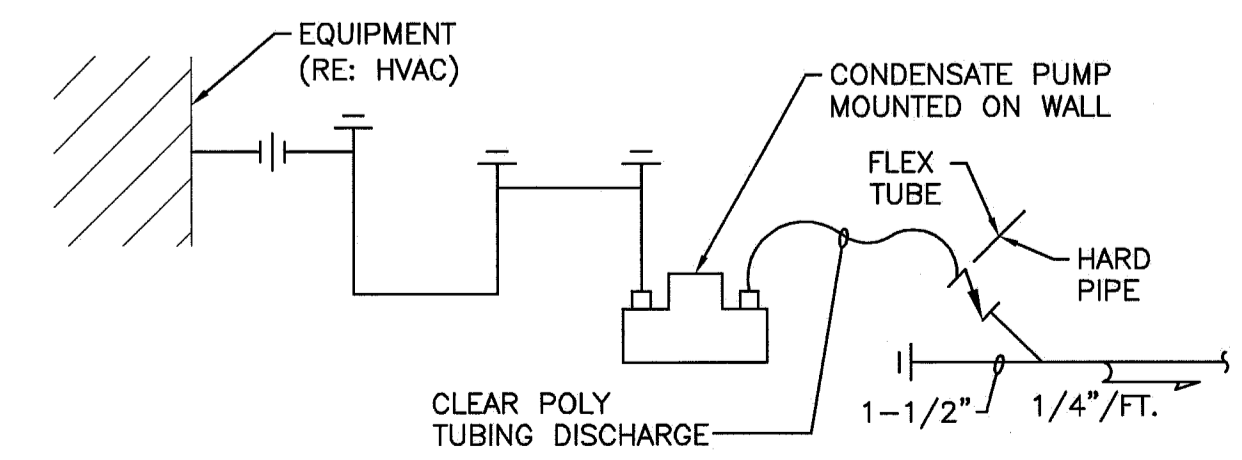

A4 CONDENSATE PUMP DETAIL
 NOT TO SCALE