



NOTES:

- SEE SHEET E-001 FOR LEGEND AND GENERAL NOTES.
- WHERE SWITCHES AND MOTION SENSORS ARE SHOWN IN THE SAME ROOM, THE SWITCHES ENABLE THE MOTION SENSORS.


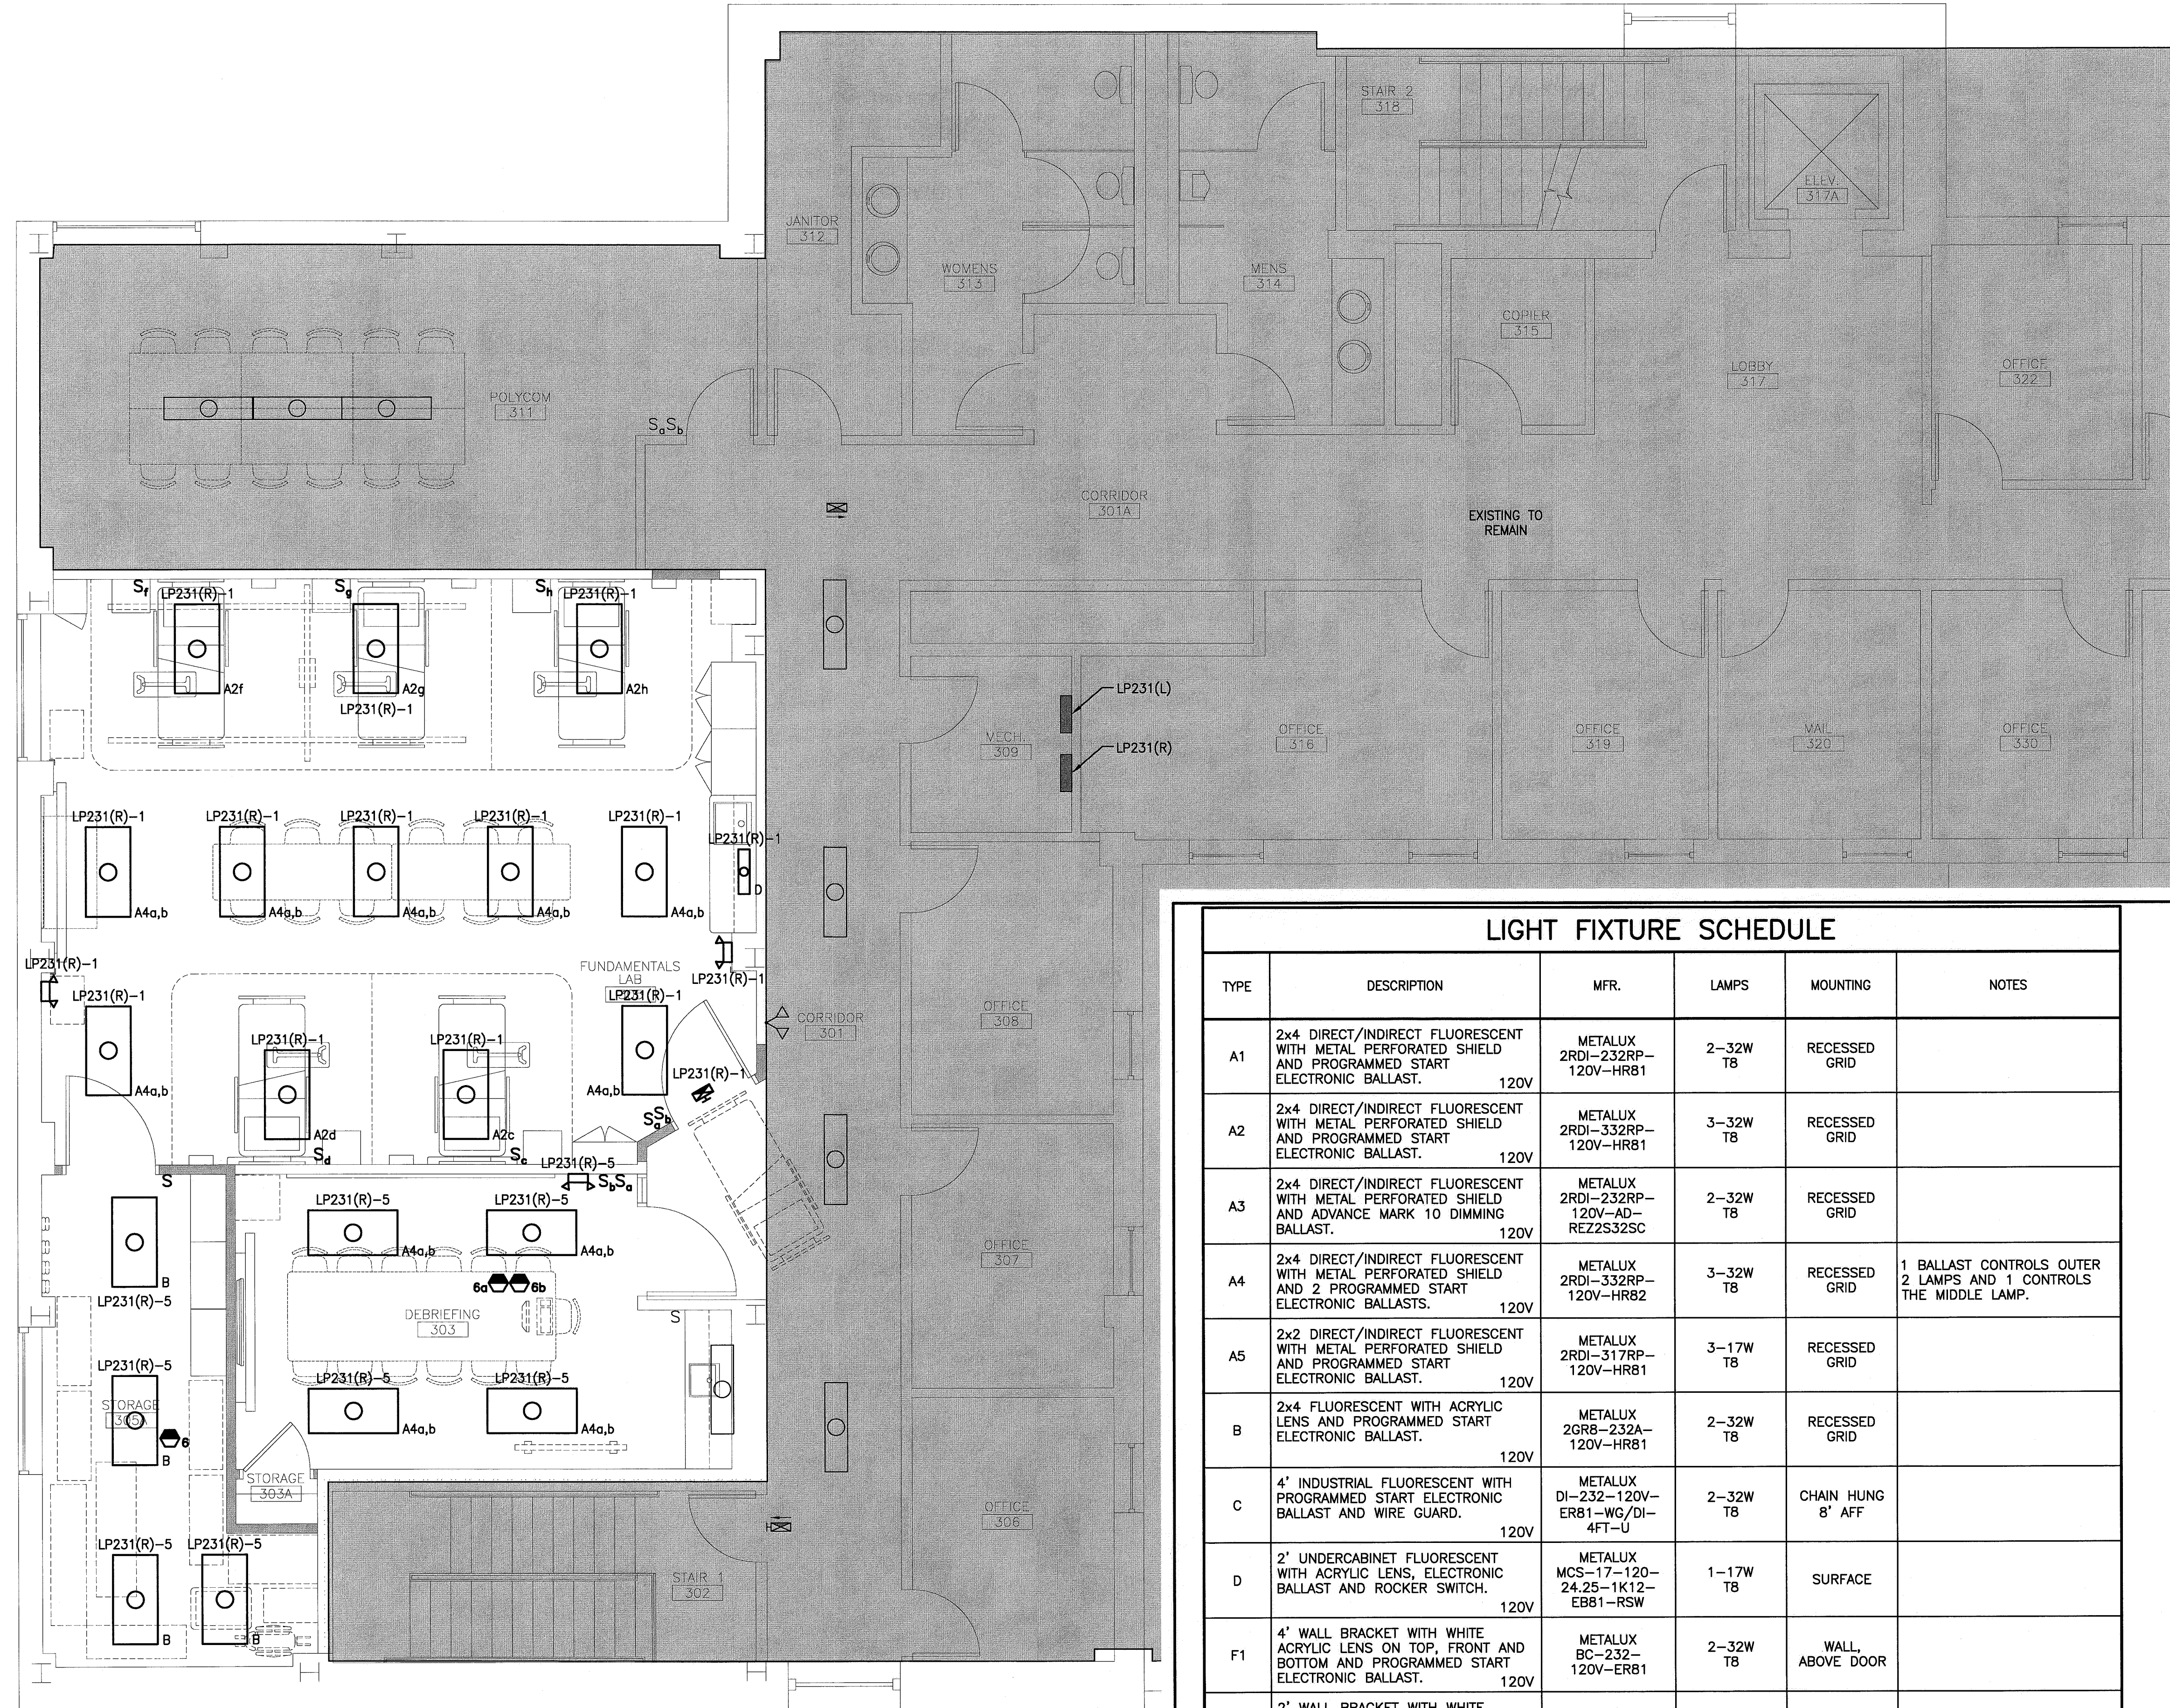


LIGHT FIXTURE SCHEDULE					
TYPE	DESCRIPTION	MFR.	LAMPS	MOUNTING	NOTES
A1	2x4 DIRECT/INDIRECT FLUORESCENT WITH METAL PERFORATED SHIELD AND PROGRAMMED START ELECTRONIC BALLAST. 120V	METALUX 2RDI-232RP-120V-HR81	2-32W T8	RECESSED GRID	
A2	2x4 DIRECT/INDIRECT FLUORESCENT WITH METAL PERFORATED SHIELD AND PROGRAMMED START ELECTRONIC BALLAST. 120V	METALUX 2RDI-332RP-120V-HR81	3-32W T8	RECESSED GRID	
A3	2x4 DIRECT/INDIRECT FLUORESCENT WITH METAL PERFORATED SHIELD AND ADVANCE MARK 10 DIMMING BALLAST. 120V	METALUX 2RDI-232RP-120V-AD-REZ2S32SC	2-32W T8	RECESSED GRID	
A4	2x4 DIRECT/INDIRECT FLUORESCENT WITH METAL PERFORATED SHIELD AND 2 PROGRAMMED START ELECTRONIC BALLASTS. 120V	METALUX 2RDI-332RP-120V-HR82	3-32W T8	RECESSED GRID	1 BALLAST CONTROLS OUTER 2 LAMPS AND 1 CONTROLS THE MIDDLE LAMP.
A5	2x2 DIRECT/INDIRECT FLUORESCENT WITH METAL PERFORATED SHIELD AND PROGRAMMED START ELECTRONIC BALLAST. 120V	METALUX 2RDI-317RP-120V-HR81	3-17W T8	RECESSED GRID	
B	2x4 FLUORESCENT WITH ACRYLIC LENS AND PROGRAMMED START ELECTRONIC BALLAST. 120V	METALUX 2GR8-232A-120V-HR81	2-32W T8	RECESSED GRID	
C	4' INDUSTRIAL FLUORESCENT WITH PROGRAMMED START ELECTRONIC BALLAST AND WIRE GUARD. 120V	METALUX DI-232-120V-ER81-WG/DI-4FT-U	2-32W T8	CHAIN HUNG 8' AFF	
D	2' UNDERCABINET FLUORESCENT WITH ACRYLIC LENS, ELECTRONIC BALLAST AND ROCKER SWITCH. 120V	METALUX MCS-17-120-24.25-1K12-EB81-RSW	1-17W T8	SURFACE	
F1	4' WALL BRACKET WITH WHITE ACRYLIC LENS ON TOP, FRONT AND BOTTOM AND PROGRAMMED START ELECTRONIC BALLAST. 120V	METALUX BC-232-120V-ER81	2-32W T8	WALL, ABOVE DOOR	
F2	2' WALL BRACKET WITH WHITE ACRYLIC LENS ON TOP, FRONT AND BOTTOM AND PROGRAMMED START ELECTRONIC BALLAST. 120V	METALUX BC-217-120V-ER81	2-17W T8	WALL, ABOVE DOOR	
☒	EMERGENCY EXIT SIGN WITH POLYCARBONATE HOUSING, GREEN LED LETTERS, NICKEL CADMIUM BATTERY, AND SELF DIAGNOSTICS/SELF TESTING ELECTRONICS. 120V	SURE-LITES LPX7-SD-G	LED	WALL, CEILING	
☒	EMERGENCY LIGHTING BATTERY UNIT WITH 2 ADJUSTABLE HEADS, WHITE HOUSING, MAINTENANCE-FREE LEAD-CALCIUM BATTERY AND SELF DIAGNOSTICS/SELF TESTING ELECTRONICS. 120V	SURE-LITES CHEL1SD	2-12W 6 VOLTS MR16	WALL	

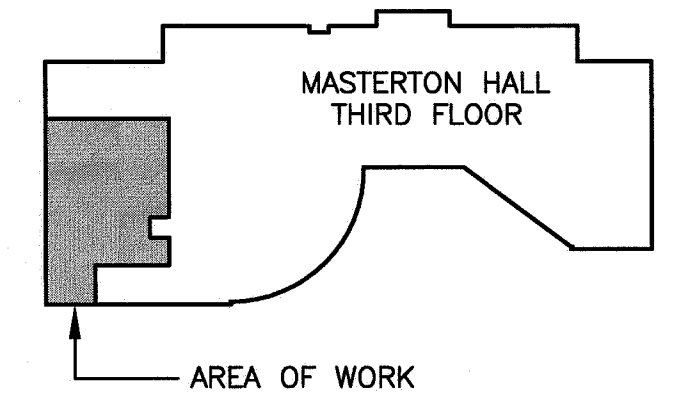

144 Fore Street/P.O. Box 618
Portland, Maine 04104
Tel. (207) 772-3846
Fax. (207) 772-1070
www.smrtinc.com

ARCHITECTURE
ENGINEERING
PLANNING
INTERIOR DESIGN
COMMISSIONING

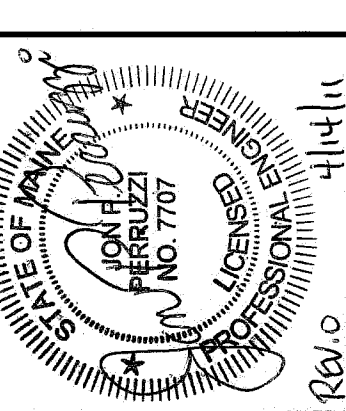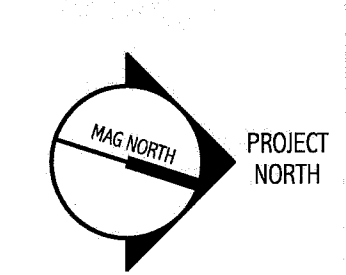

UNIVERSITY OF SOUTHERN MAINE
SIMULATION LABORATORY
PORTLAND, MAINE

ISSUED FOR BIDDING & CONSTRUCTION
4-15-11

CURRENT ISSUE STATUS:

REV	DESCRIPTION	DATE
0	ISSUED FOR BIDDING, PERMITTING & CONSTRUCTION	4-15-11

GRAPHIC SCALE:
0" = 1"

SCALE: 1/4" = 1'-0"
PROJECT MANAGER: SLB
JC/DRAWN BY: CDS
A/E OF RECORD: JFP
CAD FILE: EL102-10150
PROJECT NO: 10150-00
DATE: 4-15-11

SHEET TITLE:
THIRD FLOOR LIGHTING PLAN

SHEET No.
EL102

A1 THIRD FLOOR PLAN
1/4" = 1'-0"

A14 KEY PLAN
NTS *