


- NOTES:**
- SEE SHEET E-001 FOR LEGEND AND GENERAL NOTES.
 - CABLE TRAY (WIRE BASKET TYPE) 6" WIDE UNLESS OTHERWISE NOTED. INSTALL ABOVE CEILING.
 - CONDUIT SLEEVE ABOVE CEILING. QUANTITY AND SIZE AS NOTED. INSTALL ABOVE CEILING. SLEEVES THAT PROJECT INTO/OUT OF CORRIDORS SHALL BE 3M FIRE BARRIER PASS THROUGH DEVICES OR APPROVED EQUAL.



- KEYED NOTES:**
- INSTALL 6" ABOVE COUNTER.
 - INSTALL 42" AFF TO CENTER.
 - INSTALL 72" AFF TO CENTER.
 - INSTALL 84" AFF TO CENTER.
 - PROVIDE RECESSED BOX IN WALL, 48" AFF 1" CONDUIT FROM BOX TO ABOVE ACCESSIBLE CEILING.
 - PROVIDE RECESSED BOX IN WALL, 18" AFF, BEHIND THE LINK BOX LOCATION AND (1) 2" CONDUIT FROM THE BOX TO ABOVE ACCESSIBLE CEILING AND (1) 2" CONDUIT FROM THIS SAME BOX TO A BOX LOCATED BEHIND THE PATIENT BED AT 6" AFF. SEE KEYNOTE 7 FOR PATIENT BED BOX LOCATION. PROVIDE GROMMETTED OPENINGS IN BOTH BOXES; ONE 4" DIAMETER OPENING IN THE BOX NEAR THE LINK BOX AND ONE 2" DIAMETER OPENING IN THE PATIENT BED BOX LOCATION.
 - PROVIDE RECESSED BOX IN WALL, CENTERED ON BED LOCATION, 6" AFF. REFER TO KEY NOTE 6 FOR CONDUIT AND BOX OPENING REQUIREMENTS.
 - PROVIDE RECESSED BOX IN WALL, 5'-0" AFF BEHIND THE MONITOR AND (1) 2" CONDUIT FROM THE BOX TO ABOVE ACCESSIBLE CEILING. PROVIDE 2" GROMMETTED OPENING IN BOX.
 - INSTALL 60" AFF TO CENTER.
 - INSTALL 96" AFF TO CENTER.
 - PROVIDE BOX IN WALL ABOVE DOOR FOR NURSE CALL DOME LIGHT.
 - INSTALL 42" AFF. COORDINATE WITH OWNER FURNISHED FLIP DOWN PC.
 - CEILING MOUNTED.

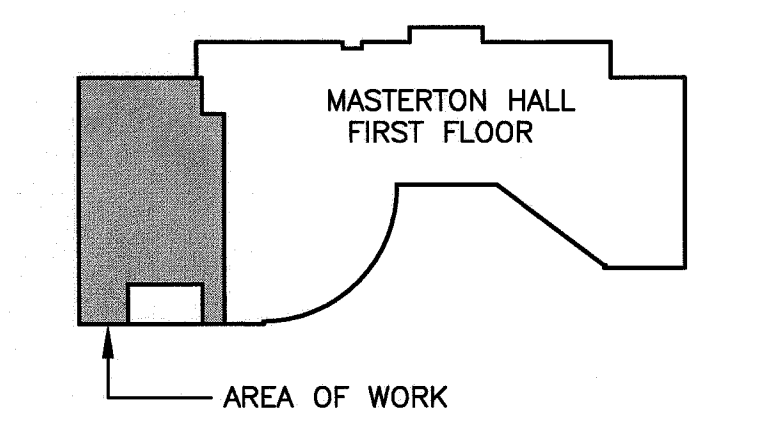

144 Fore Street/P.O. Box 618
 Portland, Maine 04104
 tel. (207) 779-9846
 fax. (207) 779-1070
 www.smartinc.com

ARCHITECTURE
 ENGINEERING
 PLANNING
 INTERIOR DESIGN
 COMMISSIONING

SMART

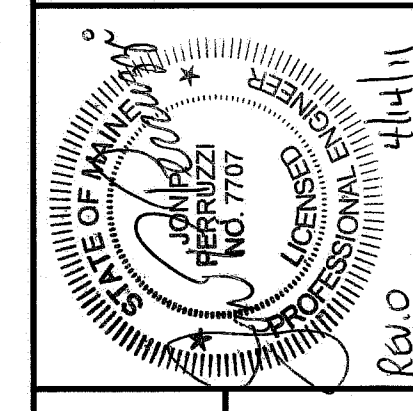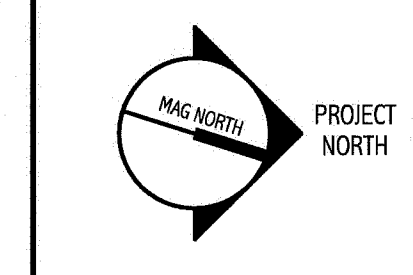

UNIVERSITY OF SOUTHERN MAINE
 SIMULATION LABORATORY
 PORTLAND, MAINE

ISSUED FOR BIDDING & CONSTRUCTION
 4-15-11

CURRENT ISSUE STATUS:

REV	DESCRIPTION	DATE
0	ISSUED FOR BIDDING, PERMITTING & CONSTRUCTION	4-15-11

GRAPHIC SCALE:
 0" 1"

SCALE: 1/4" = 1'-0"

PROJECT MANAGER: SLB
 JC/DRAWN BY: CDS
 A/E OF RECORD: JPB
 CAD FILE: EY101-10150
 PROJECT NO: 10150-00
 DATE: 4-15-11
 SHEET TITLE:

FIRST FLOOR
 SYSTEMS PLAN

SHEET No.
EY101
 © COPYRIGHT 2009 SMART INC.

A1 FIRST FLOOR PLAN

1/4" = 1'-0"

A14 KEY PLAN

NTS *