

UNIVERSITY OF SOUTHERN MAINE

SCIENCE BUILDING C WING CYBER SECURITY LAB FIT-UP PROJECT 2013-007

PORTLAND, MAINE

ARCHITECTURE
ENGINEERING
PLANNING
INTERIOR DESIGN
COMMISSIONING

144 Fore Street/P.O. Box 618
Portland, Maine 04104
tel. (207) 772-3846
fax. (207) 772-1070
www.smrinc.com



USM SCIENCE BUILDING C WING
CYBER SECURITY LAB FIT-UP
PROJECT 2013-007
PORTLAND, MAINE

DRAWING LIST:

GENERAL

- GI001 TITLE SHEET
- GI002 GENERAL INFORMATION
- GI003 PARTITION TYPES
- GI004 PARTITION TYPES

ARCHITECTURAL

- A-001 MATERIAL SPECIFICATIONS
- A-002 MATERIAL SPECIFICATIONS
- A-003 MATERIAL SPECIFICATIONS
- A-004 MATERIAL SPECIFICATIONS
- AD101 REMOVALS PLAN
- AE101 FLOOR PLAN
- AE102 REFLECTED CEILING PLAN
- AE601 FINISH SCHEDULE
- AE602 DOOR SCHEDULE & ELEVATIONS
- AE611 DETAILS

MECHANICAL



- M-001 LEGENDS AND ABBREVIATIONS
- M-002 MECHANICAL SPECIFICATIONS
- M-003 MECHANICAL SPECIFICATIONS
- MD101 MECHANICAL DEMOLITION PLAN
- MH101 MECHANICAL HVAC PLAN
- MP101 MECHANICAL PIPING PLAN

MECHANICAL CONT.

- M-501 MECHANICAL DETAILS
- M-502 MECHANICAL DETAILS
- M-503 MECHANICAL DETAILS
- M-601 SCHEDULES
- M-651 SEQUENCE OF OPERATION

ELECTRICAL

- E-001 LEGEND AND GENERAL NOTES
- ED101 ELECTRICAL DEMOLITION PLAN
- EG101 CABLE TRAY AND GROUNDING PLAN
- EP101 POWER PLAN
- EP401 ENLARGED POWER PLAN
- EL101 LIGHTING PLAN
- EL601 LIGHT FIXTURE SCHEDULE
- EY101 SYSTEMS PLAN

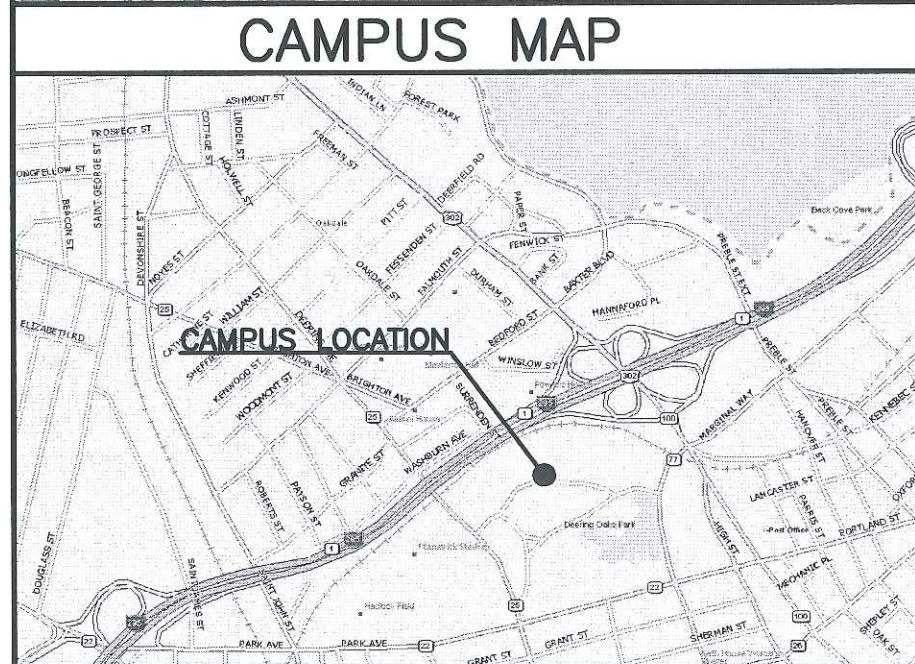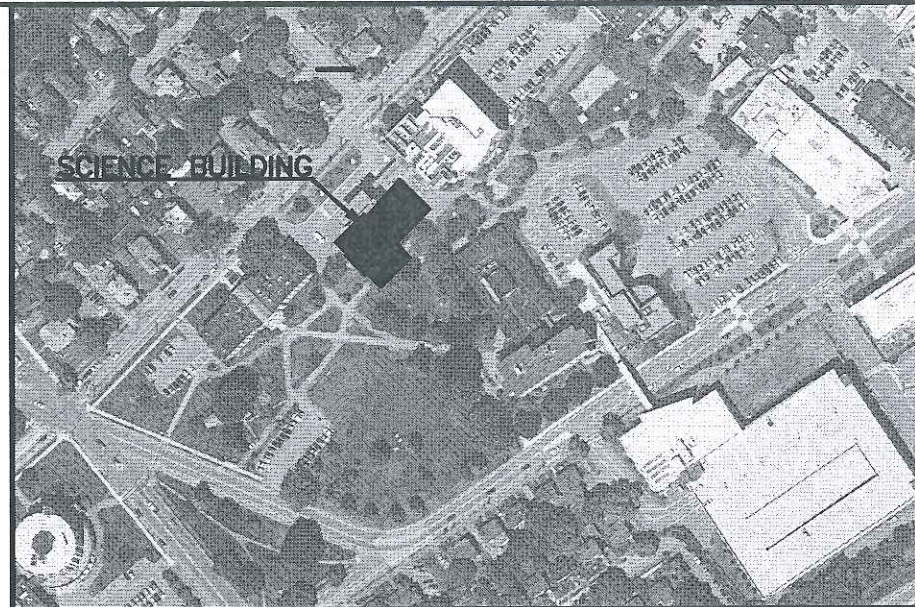

NOTES:

1. RE: GI002 FOR GENERAL NOTES, SYMBOL LEGEND, ABBREVIATIONS, & SCHEDULE OF ALTERNATES.

ISSUED FOR PERMITTING AND CONSTRUCTION
12-20-13

CURRENT ISSUE STATUS:

REV	DESCRIPTION	DATE
0	ISSUED FOR PERMITTING AND CONSTRUCTION	12-20-13

SCALE: NOT TO SCALE

PROJECT MANAGER: SLB

JC/DRAWN BY: MLE

A/E OF RECORD: SLB

CAD FILE: GI001-12014-02

PROJECT NO: 12014-02

DATE: 12-20-13

SHEET TITLE:
TITLE SHEET

SHEET No. **GI001**

© COPYRIGHT 2012 SMRT INC.

