


OWNER/REVIEW	DATE
NAME	

NO.	02/20/14	CONSTRUCTION
NO.		DATE
ISSUE FOR		DESCRIPTION
		- CLOSED CHANGE

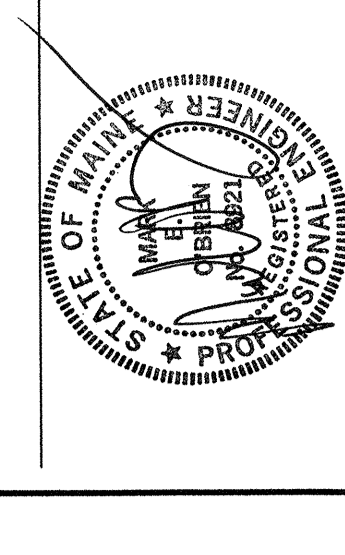

THIRD & FOURTH FLOOR PLANS

SCALE: 1/8" = 1'-0"



DRAWN BY: J.M.C.F.V.

CHECKED BY: PROJ. ARCH. ENGR. E.A.P.P.E.H.

PROJ. MGR. S.C.H.


JOB NO. 03040.00

© SPYMER, MANN LUCKE ASSOCIATES, INC. 2013

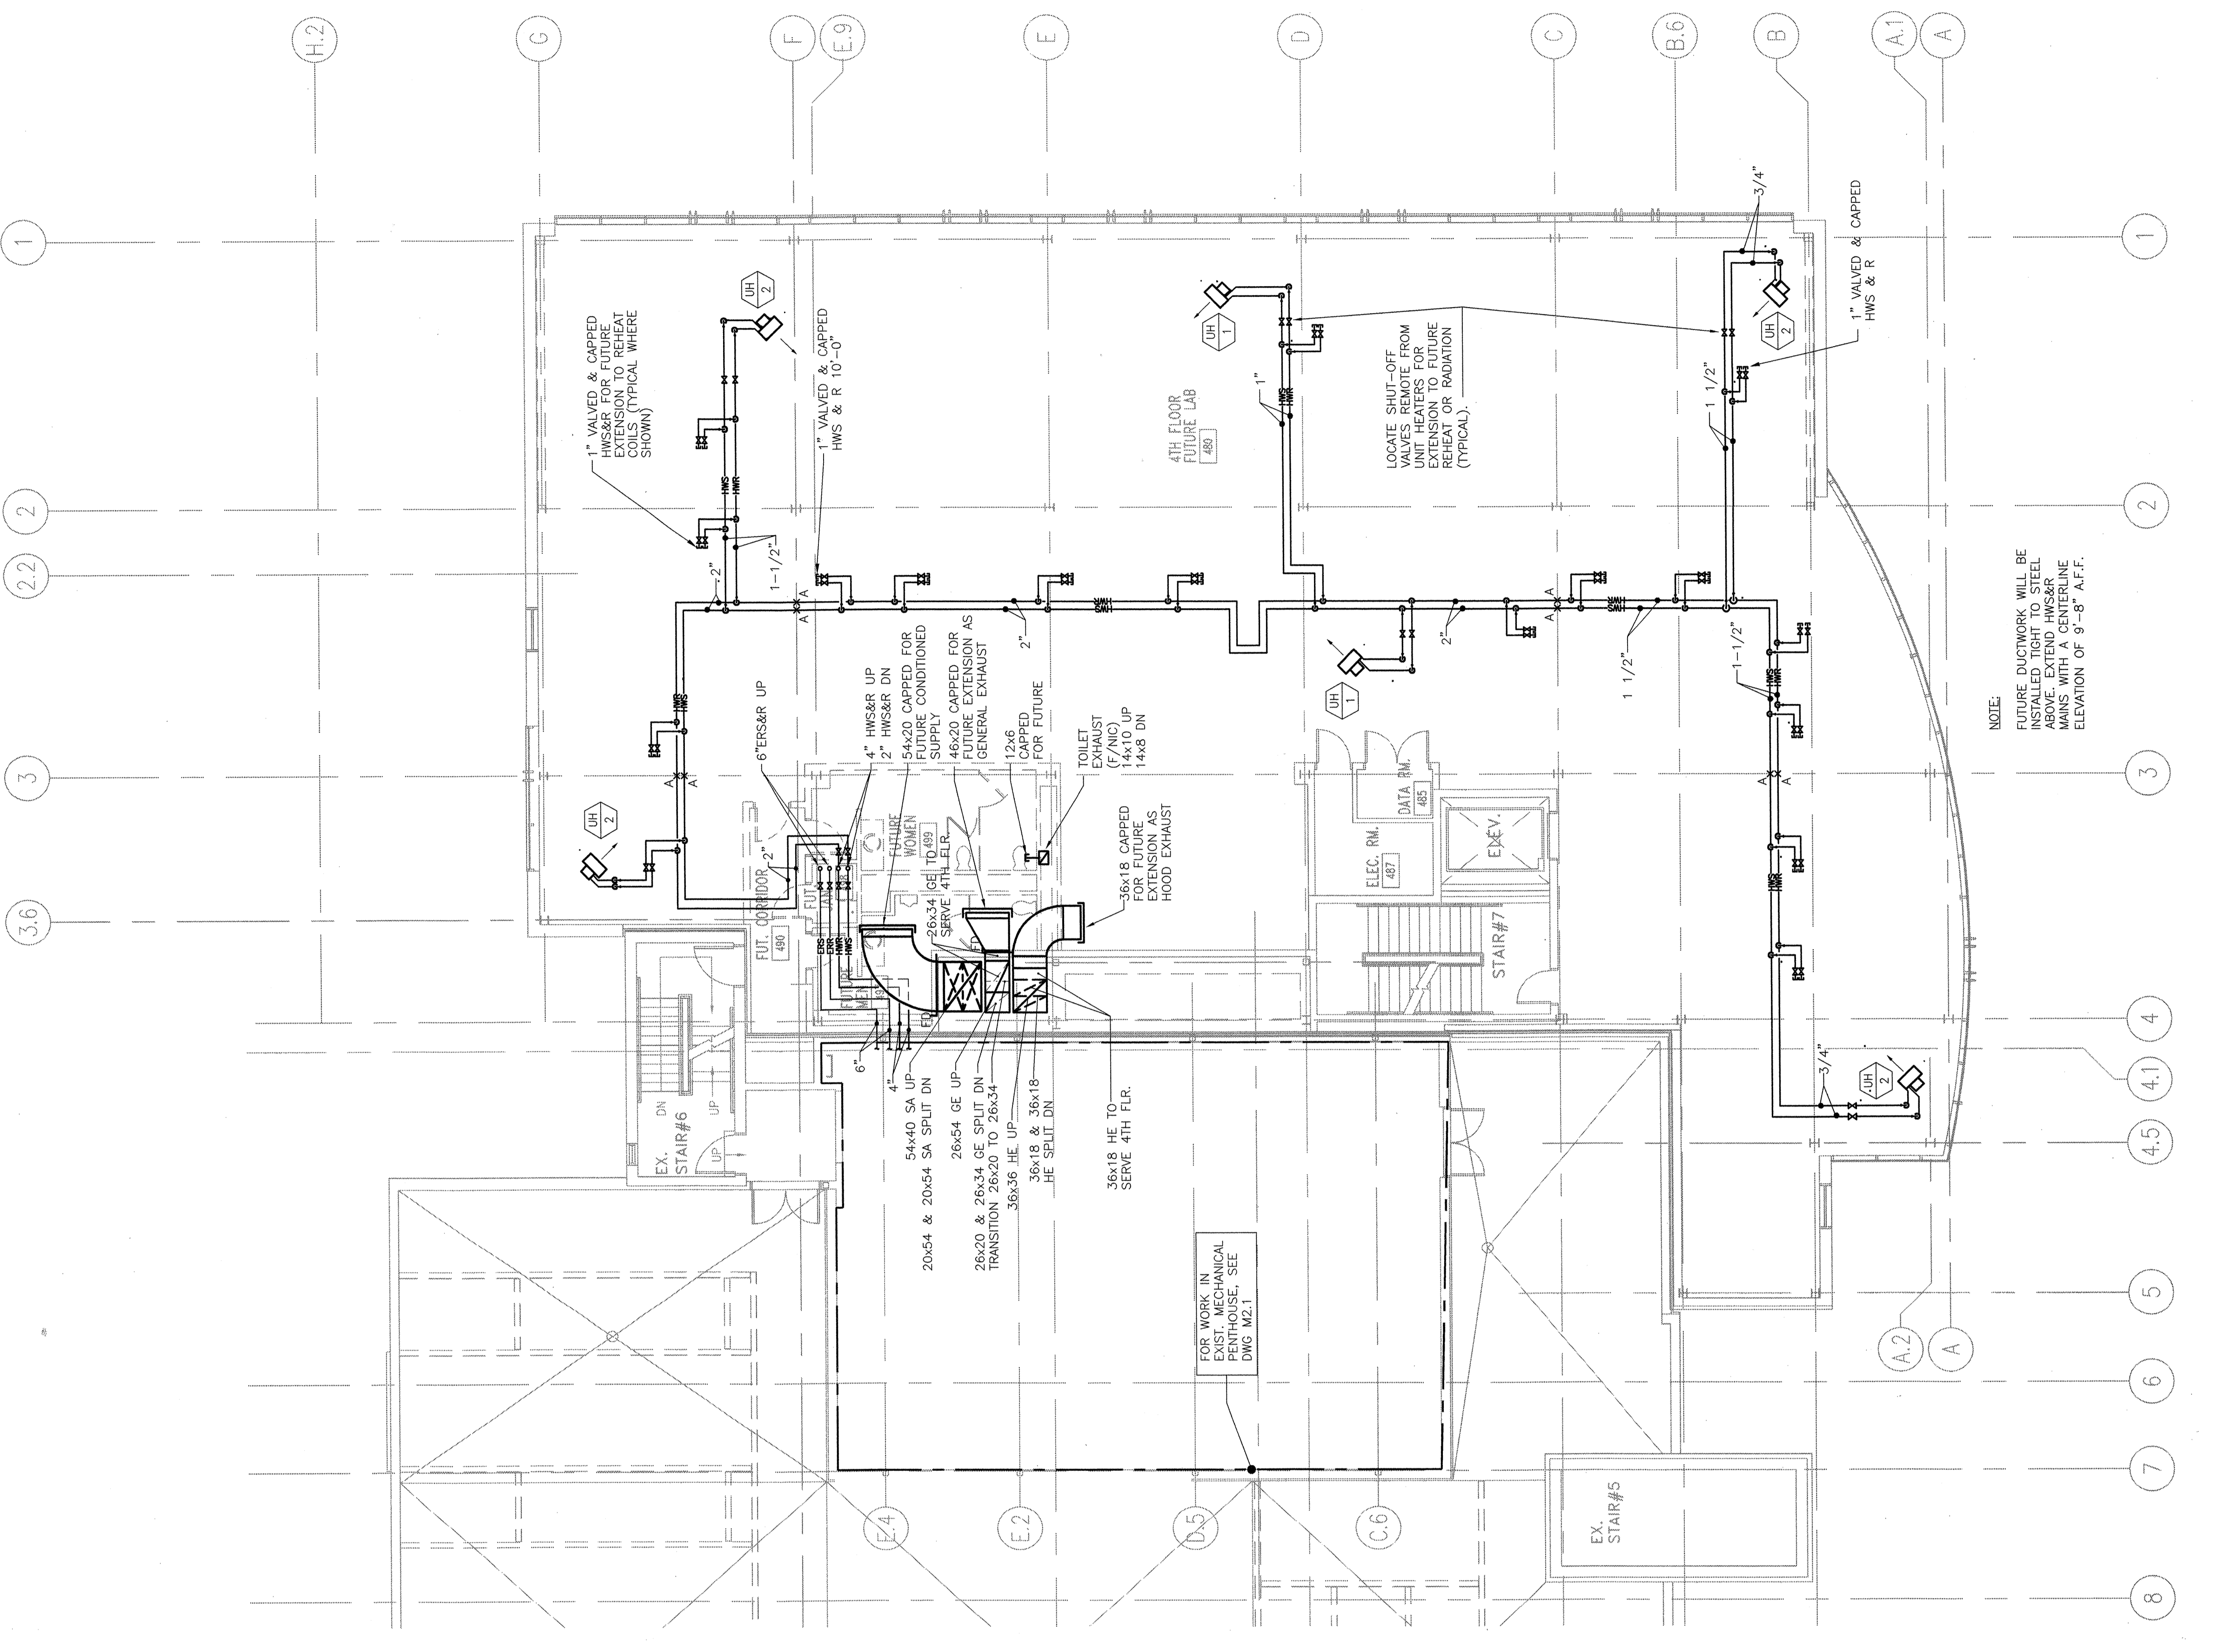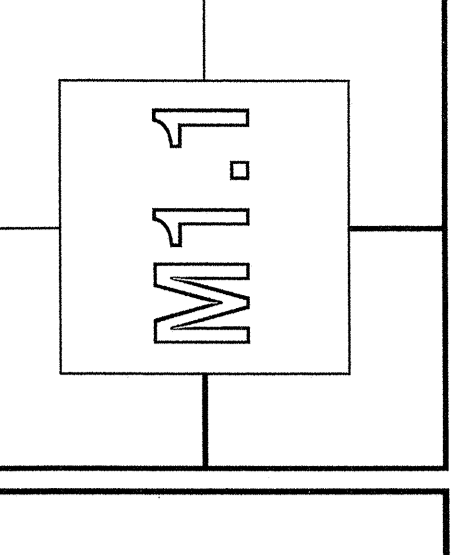

NOTE:
 FUTURE NETWORK WILL BE
 INSTALLED TO RISE TO STEEL
 ABOVE. EXTEND HWS&R
 MAINS WITH A CENTERLINE
 ELEVATION OF 9'-8" A.F.F.

2. FOURTH FLOOR PLAN
 W.S. 1/8" = 1'-0"

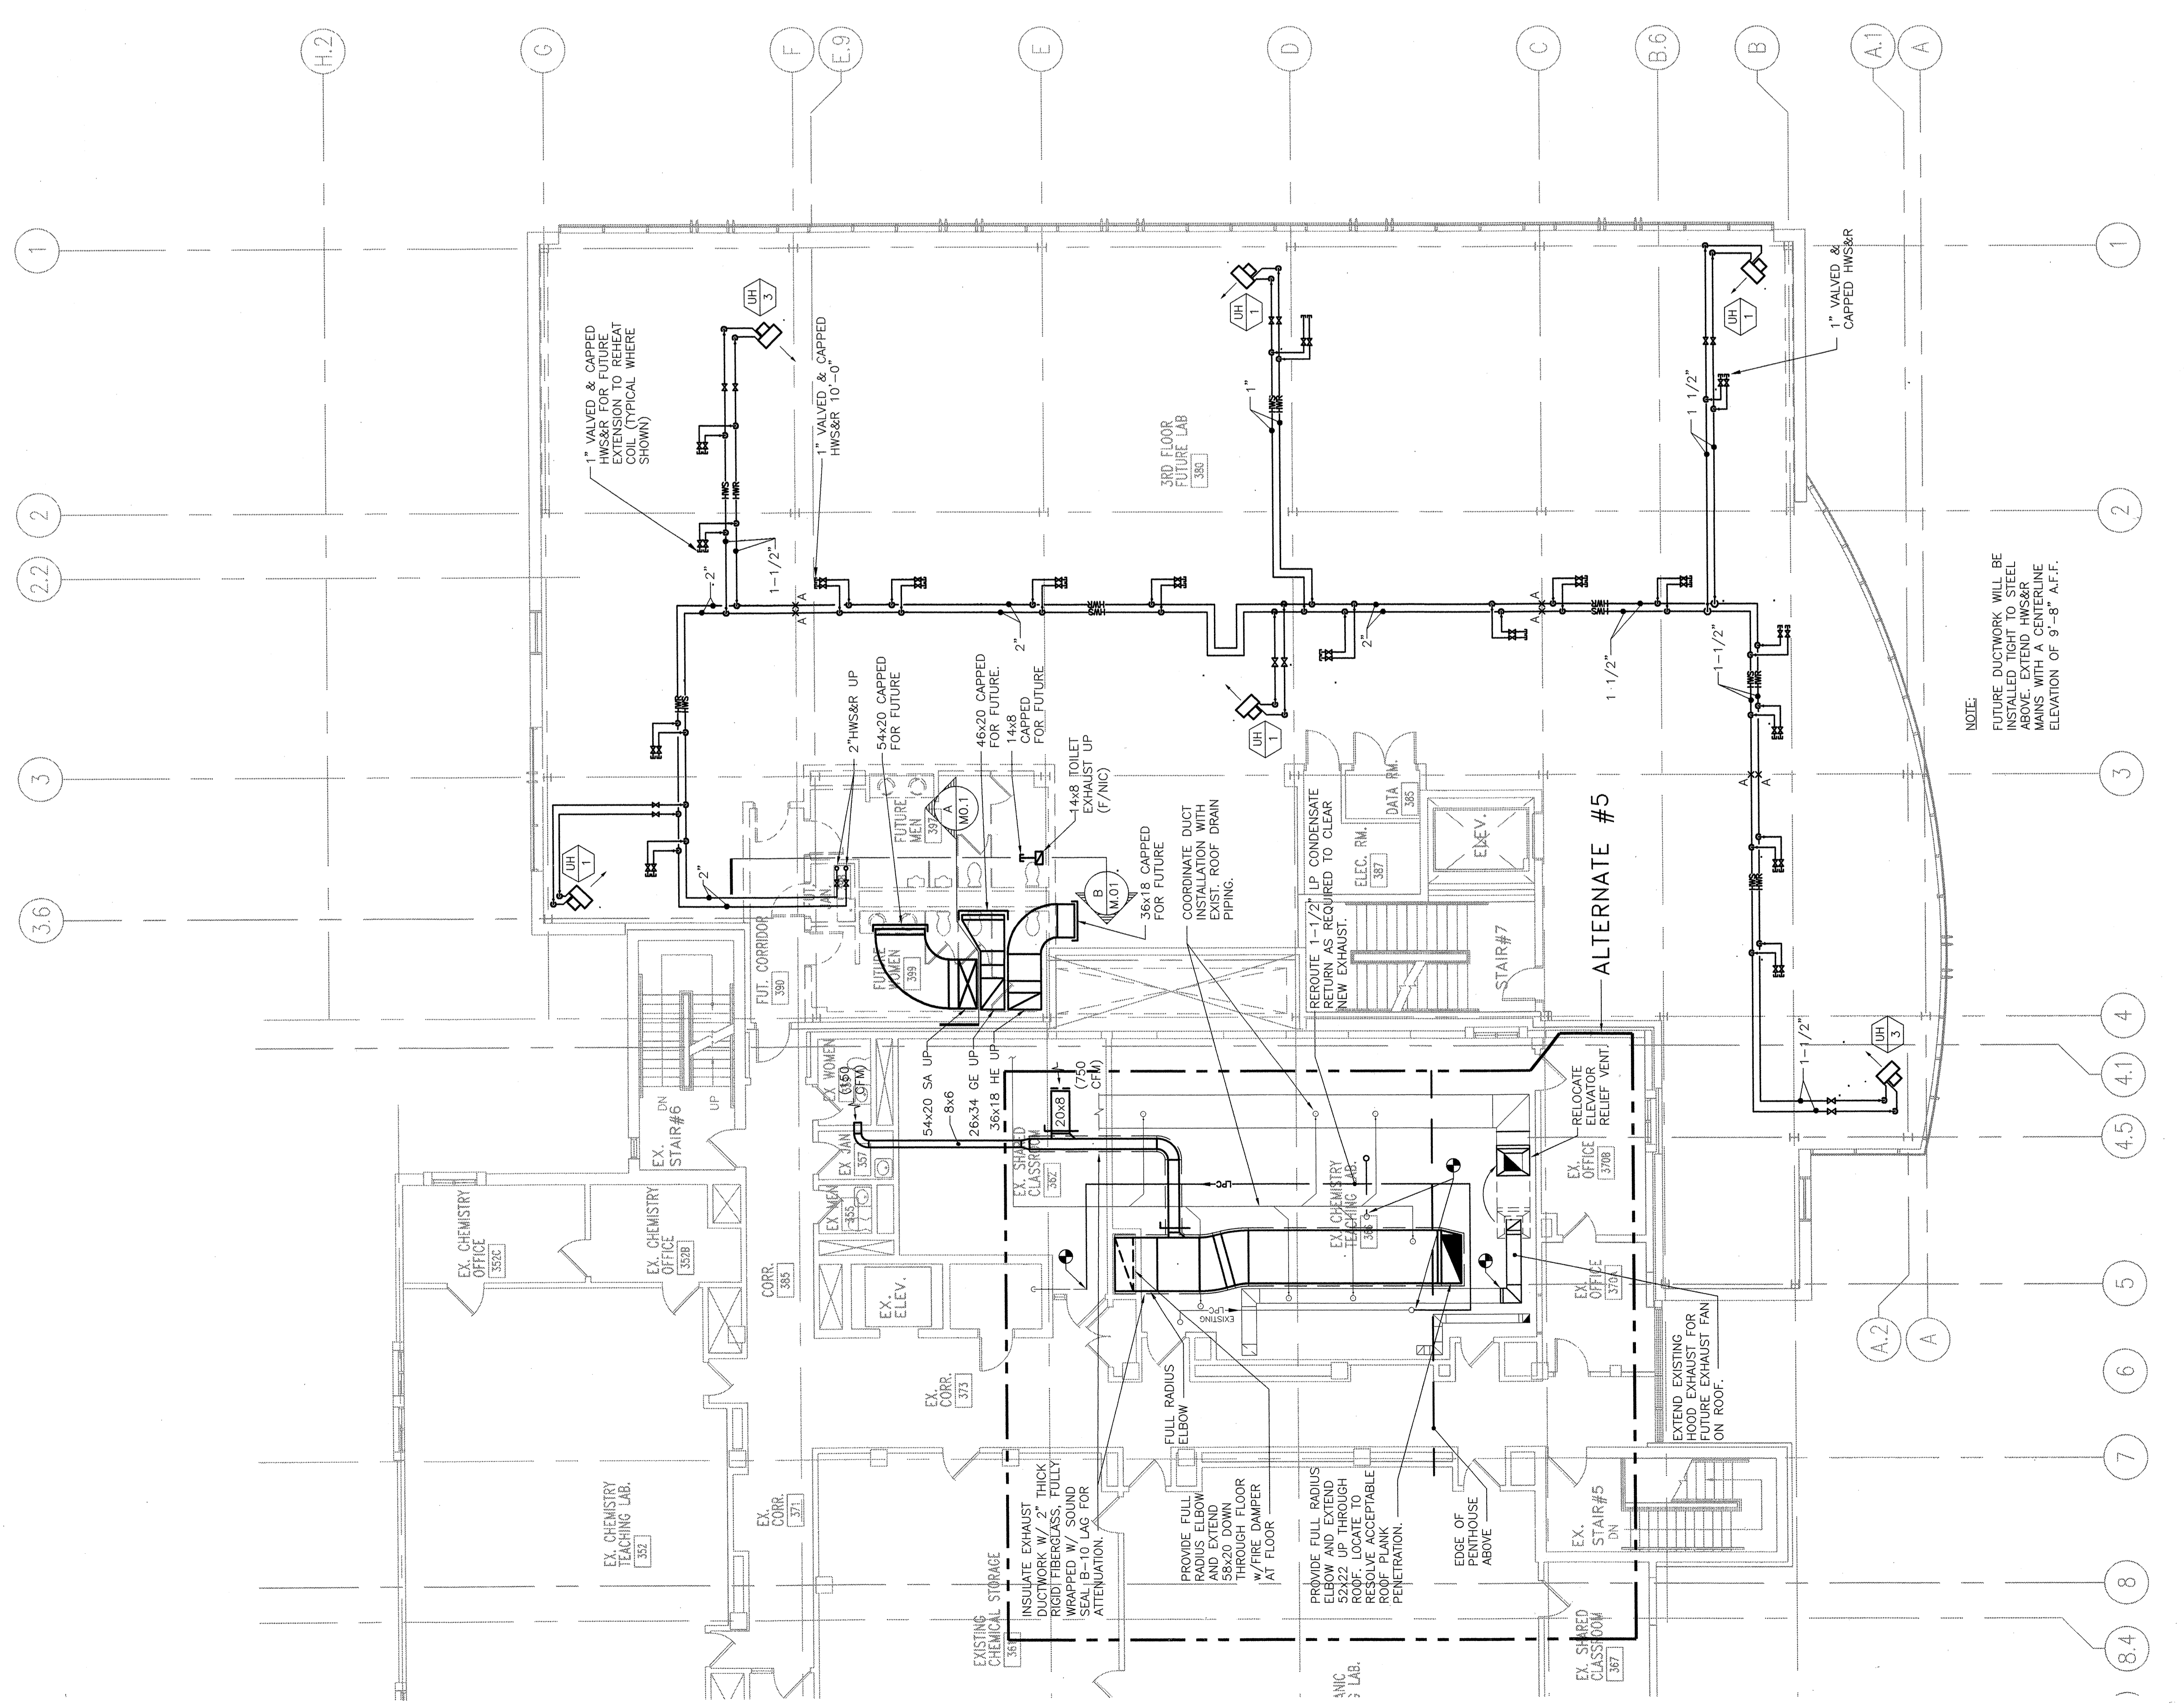

NOTE:
 FUTURE DUCTWORK WILL BE
 INSTALLED TO RISE TO STEEL
 ABOVE. EXTEND HWS&R
 MAINS WITH A CENTERLINE
 ELEVATION OF 9'-8" A.F.F.

1. THIRD FLOOR PLAN
 W.S. 1/8" = 1'-0"