


OWNER REVIEW	DATE
NAME	




NO.	DATE	DESCRIPTION
0	02/20/04	CONSTRUCTION
1		
2		
3		
4		
5		
6		
7		
8		
9		
10		
11		
12		
13		
14		
15		
16		
17		
18		
19		
20		
21		
22		
23		
24		
25		
26		
27		
28		
29		
30		

UNIVERSITY OF
 SOUTHERN MAINE
 SCIENCE BUILDING EXPANSION
 70 Blanchard Street
 Portland, Maine

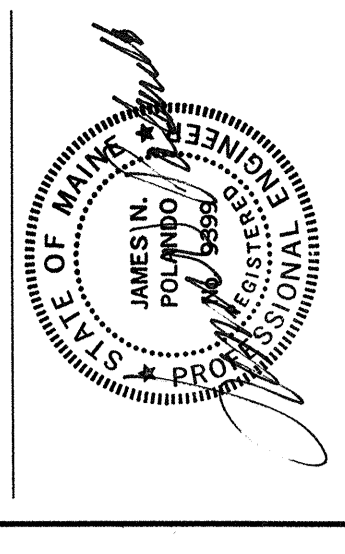

**FIFTH FLOOR
 AND ROOF
 PLANS**

SCALE	AS SHOWN
DRAWN BY	TCW
CHECKED BY	TCW
PROJ. ARCH. / ENGR.	LGL/JP
PROJ. MGR.	RCH
JOB NO.	03544.00
DATE	02/20/04

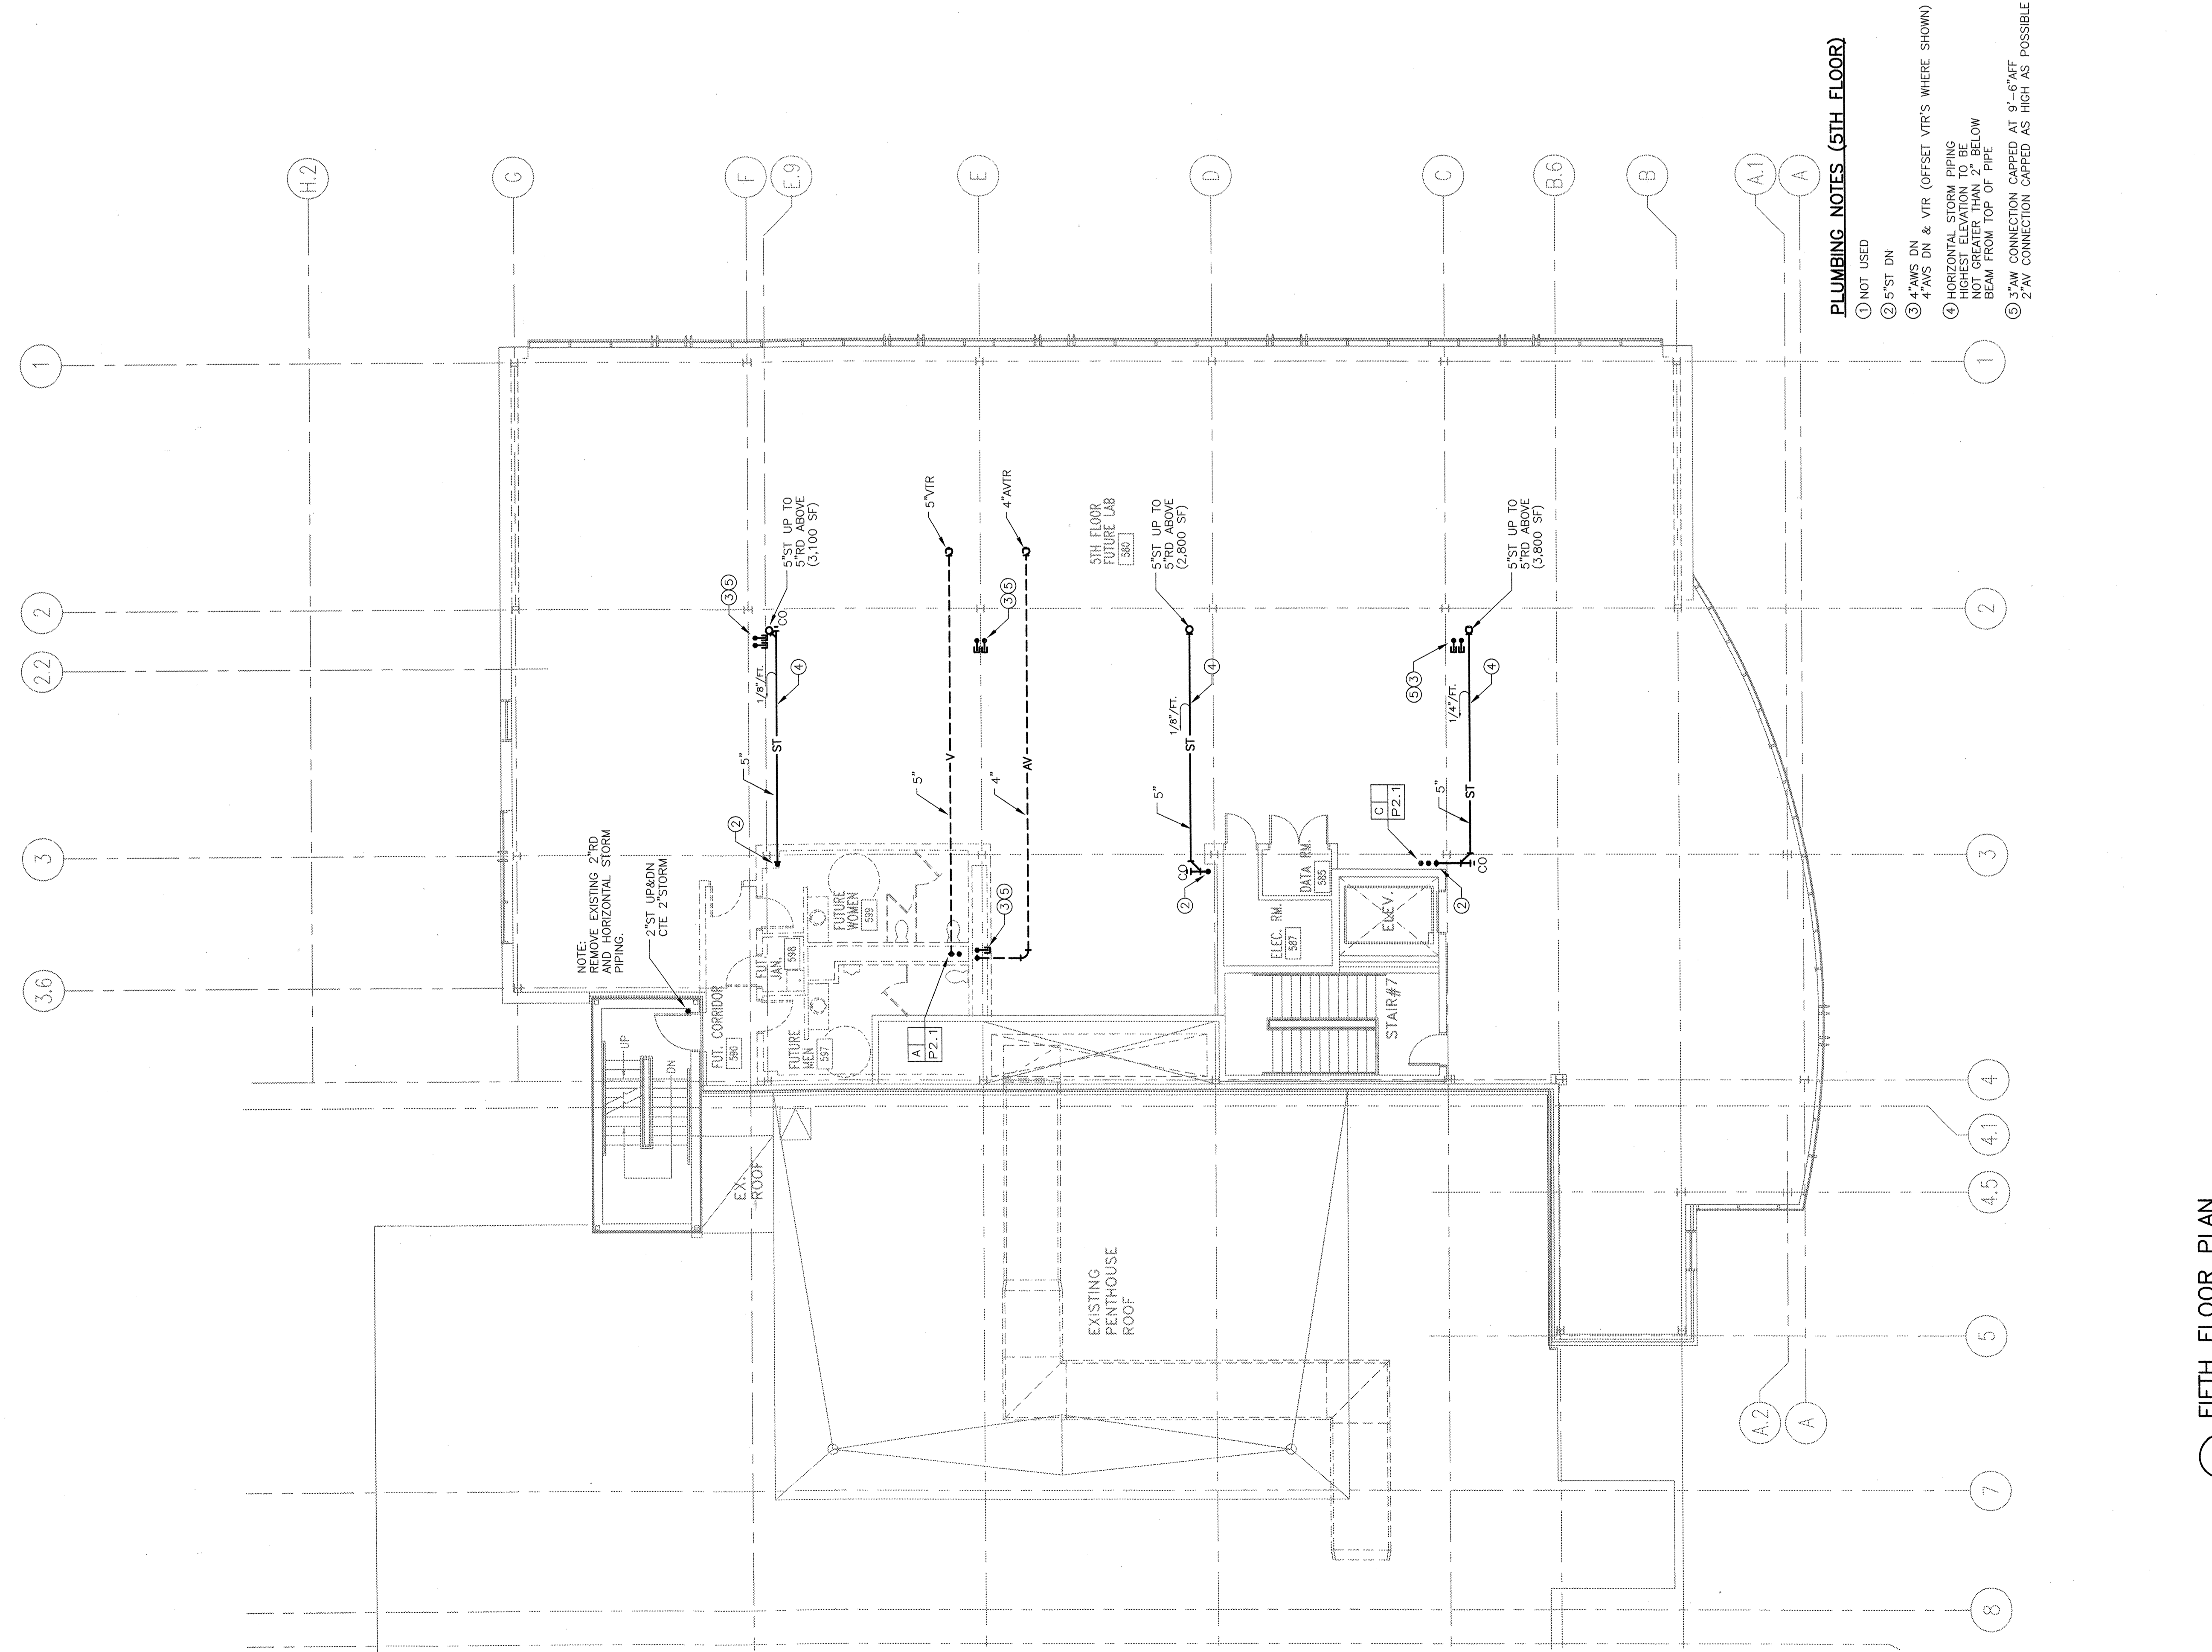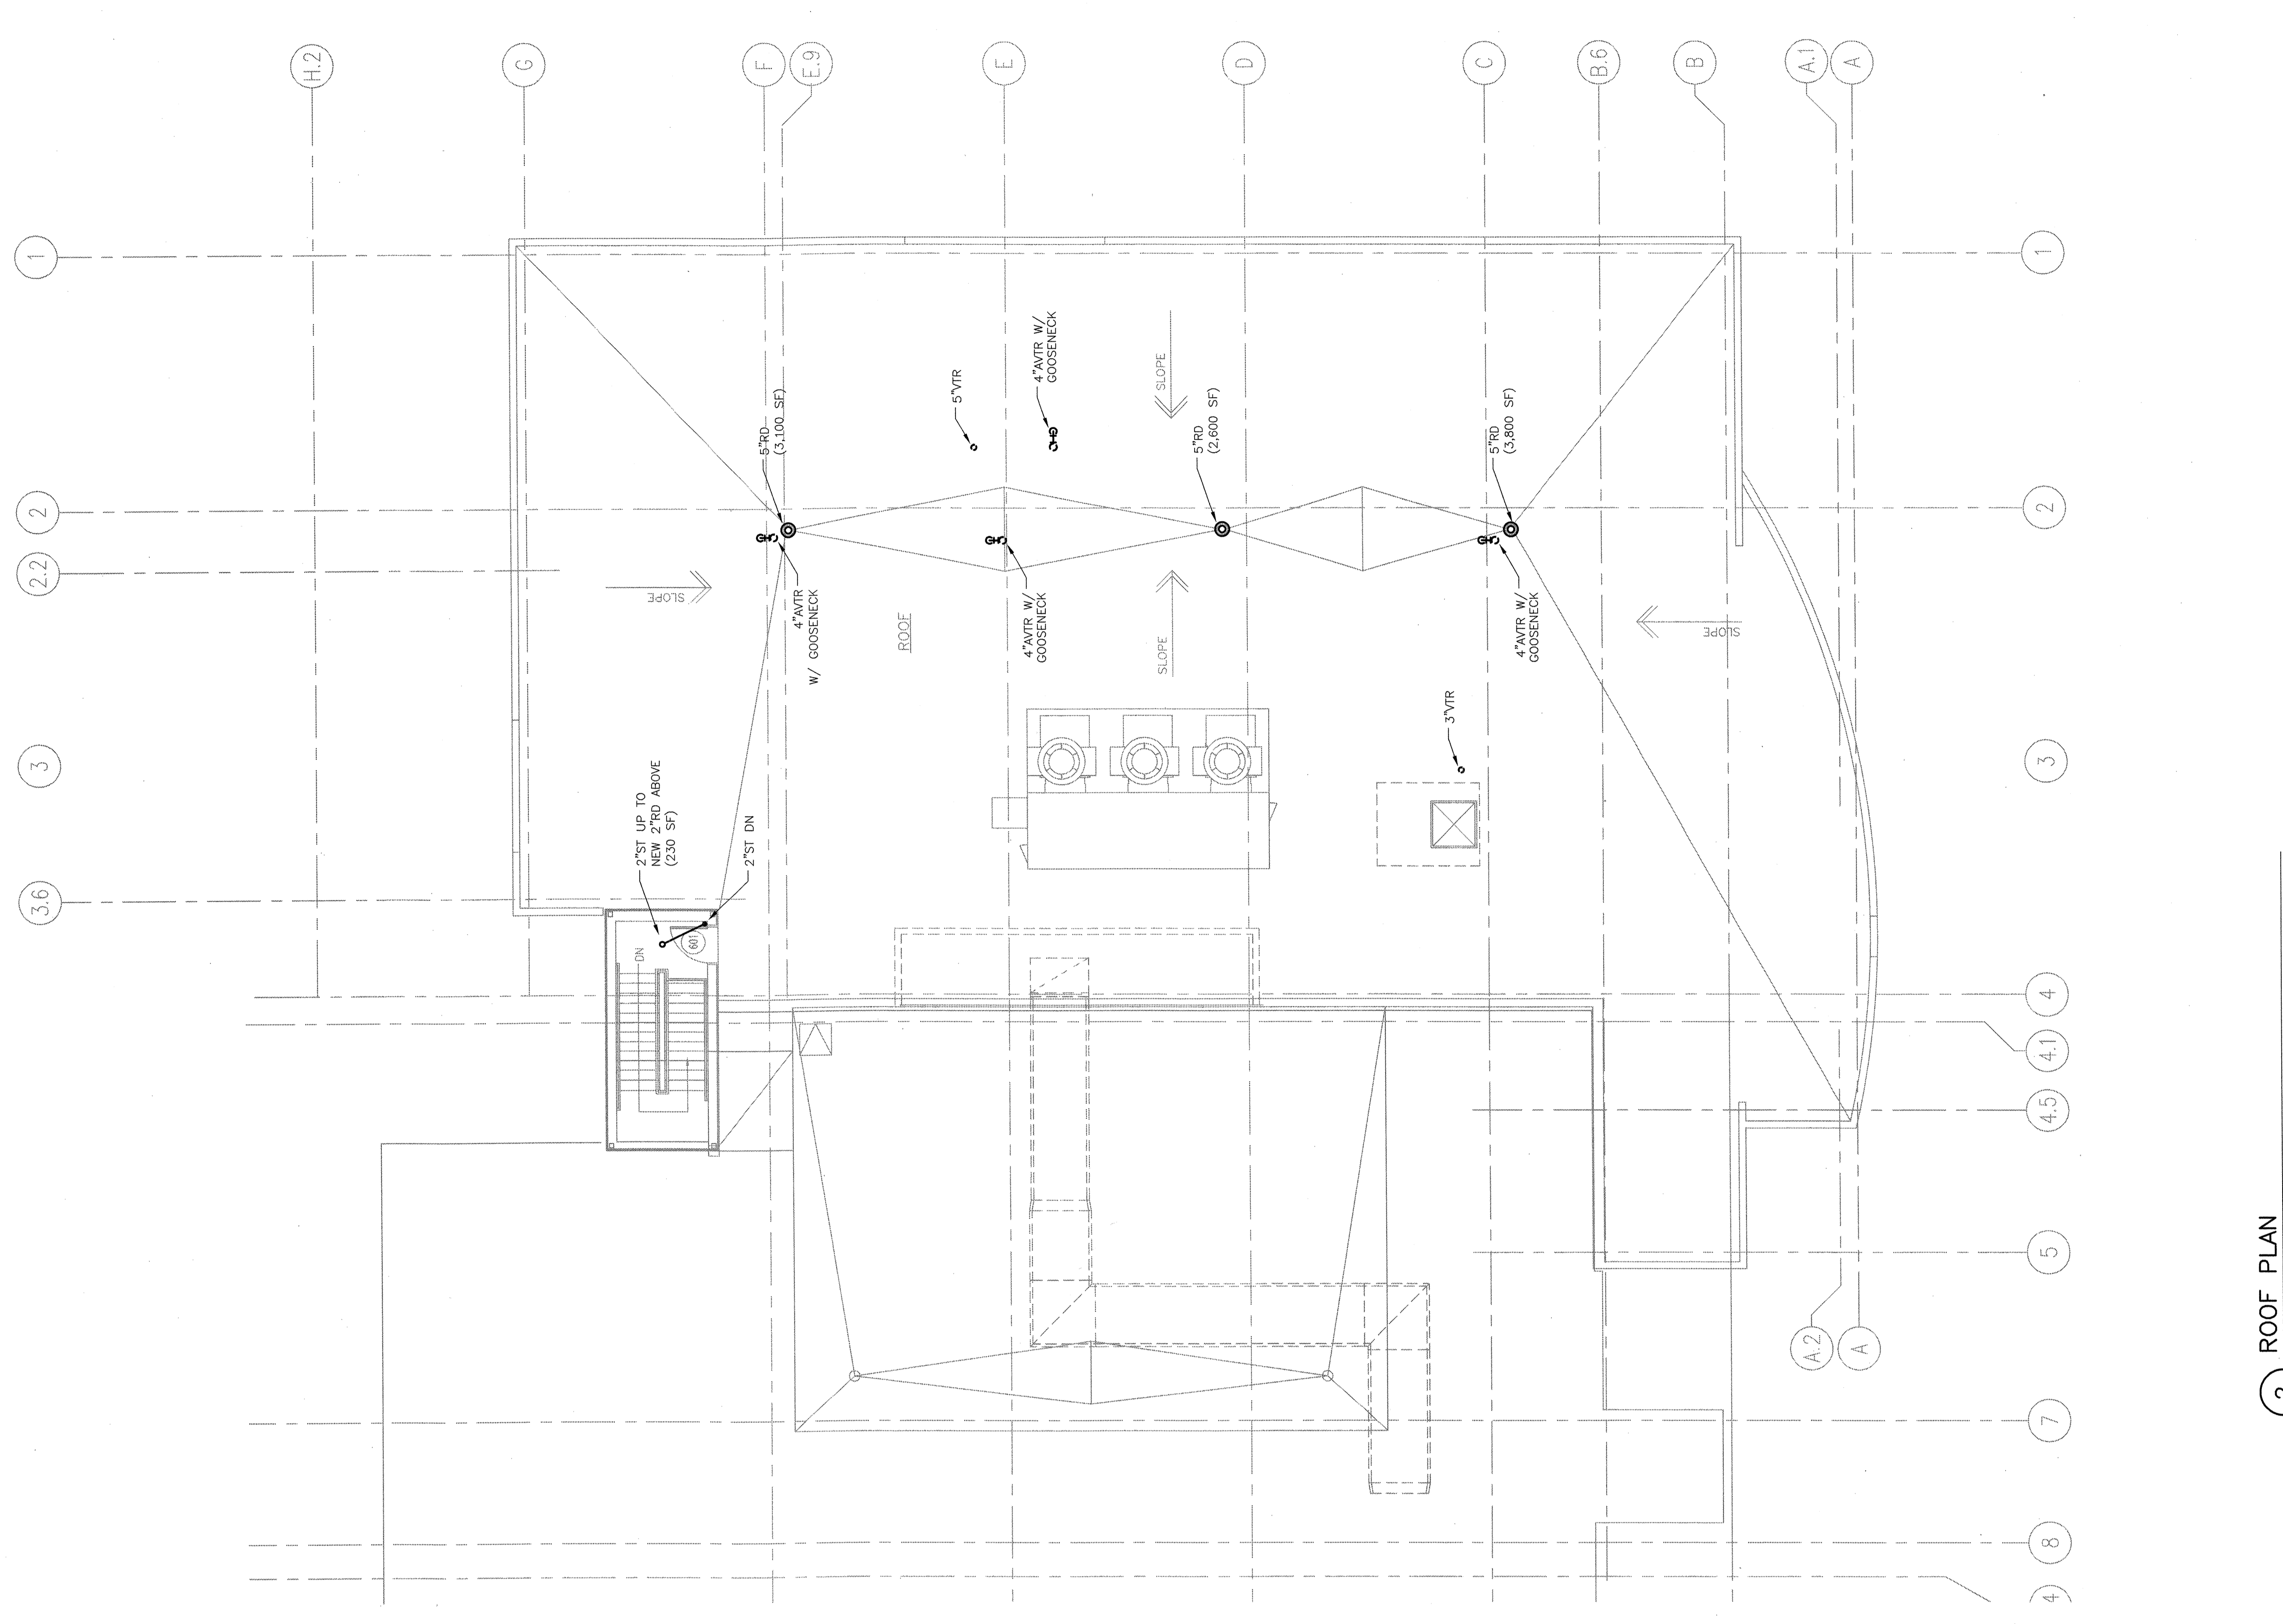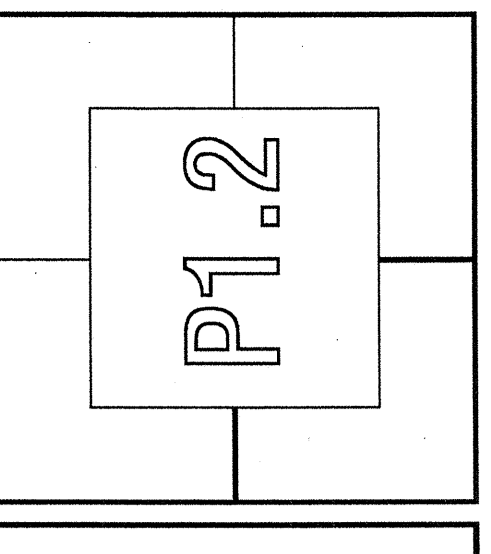

- PLUMBING NOTES (5TH FLOOR)**
- ① NOT USED
 - ② 5" ST DN
 - ③ 4" WS DN & VTR (OFFSET VTR'S WHERE SHOWN)
 - ④ HORIZONTAL STORM PIPING NOT TO EXCEED 1/4" BELOW BEAM FROM TOP OF PIPE
 - ⑤ 3" AV CONNECTION CAPPED AT 9'-6" RT
 - ⑥ 2" AV CONNECTION CAPPED AS HIGH AS POSSIBLE

2 ROOF PLAN
 SCALE: 1/8"=1'-0"

1 FIFTH FLOOR PLAN
 SCALE: 1/8"=1'-0"