
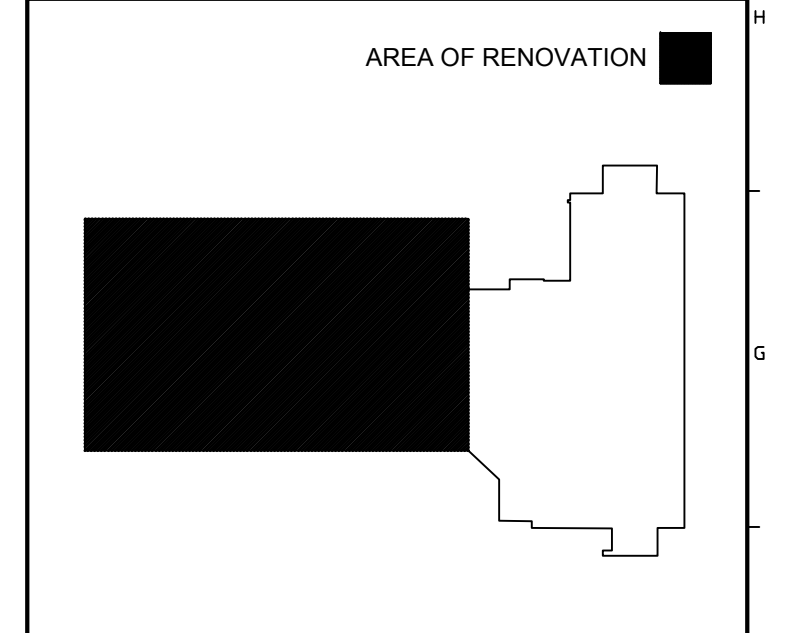


6/13/2013 9:43 AM I:\3801-3900\384210 USM FIRE ALARM SYSTEM UPGRADES\DESIGN\DWGS\BLDG\LUTHER BONNEY 6P002\BONNEY LUTHER FIRE ALARM UPGRADES\SHEETS\3842.13-FA102B SECOND FLOOR FIRE ALARM PLAN - SEG B.DWG KYLE MAHAR

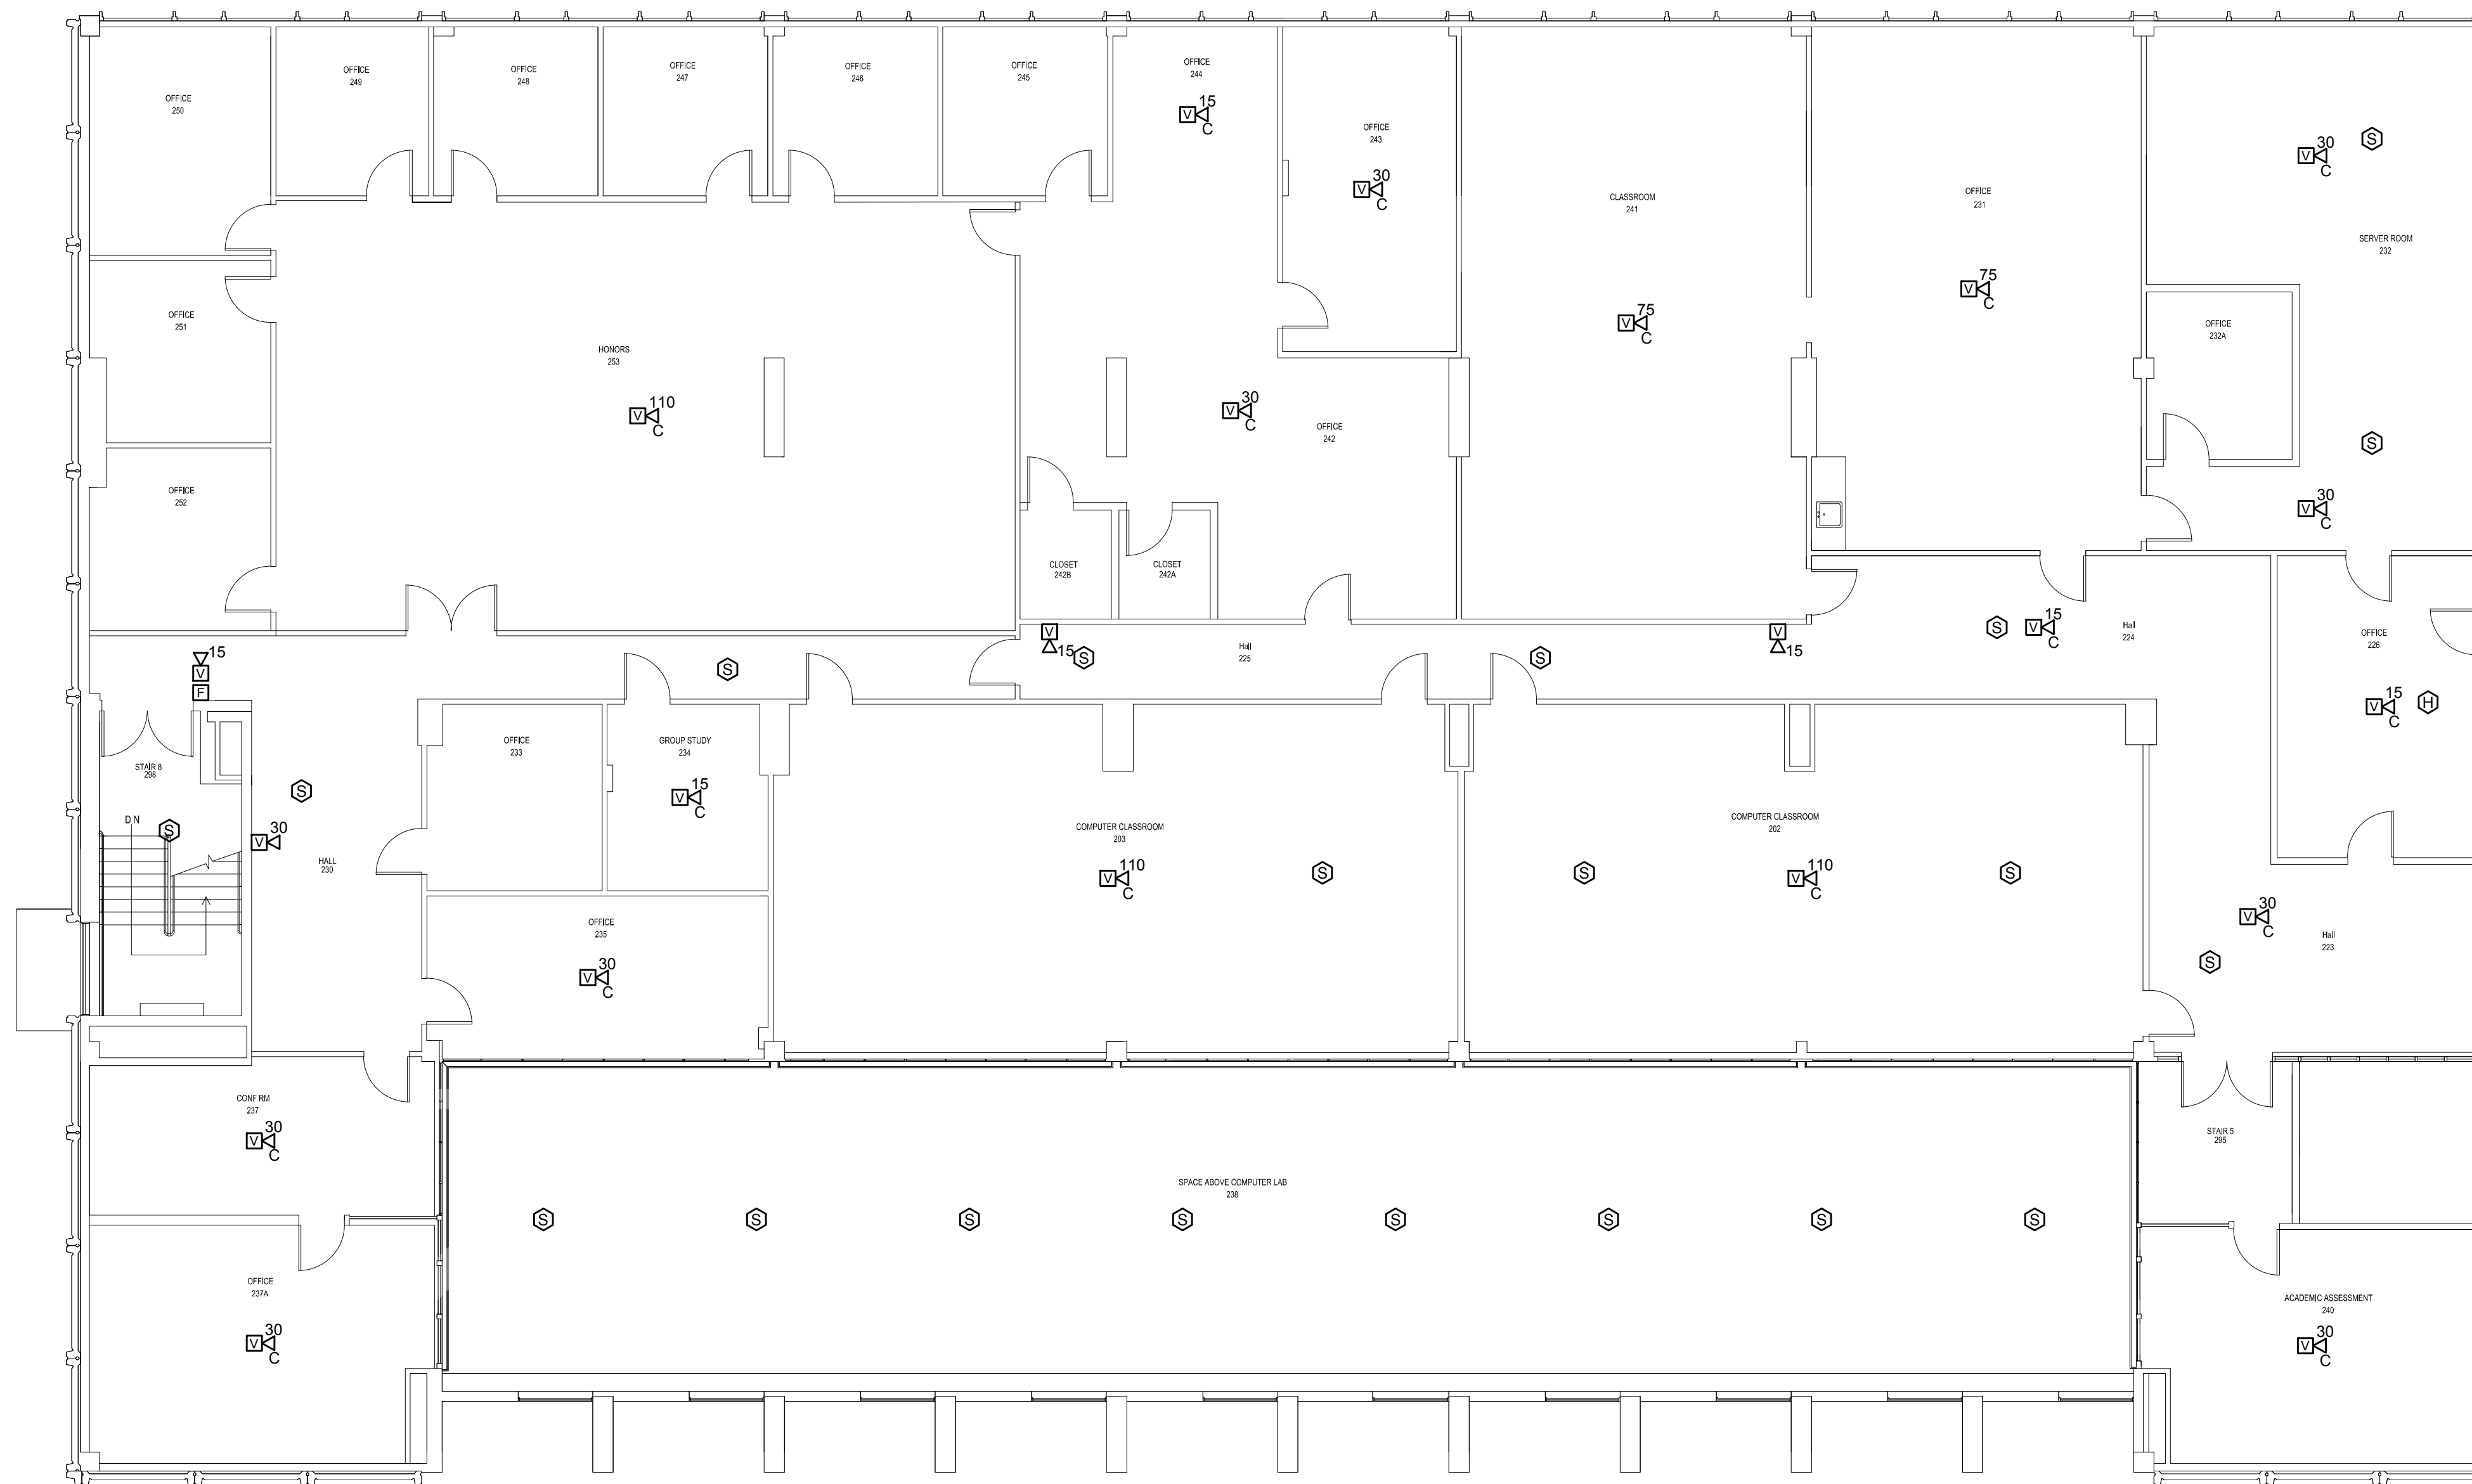

KEY PLAN

0	CONSTRUCTION DOCUMENTS	05.10.13
REV.	DESCRIPTION	DATE

CONSTRUCTION DOCUMENTS
05.10.13

CURRENT ISSUE STATUS:

PROJECT NORTH

P.C. 10.13

WBRC
ARCHITECTS • ENGINEERS
www.wbrcae.com
BANGOR, MAINE 207-947-4511
PORTLAND, MAINE 207-628-4511
SARASOTA, FLORIDA 941-556-0757

LUTHER BONNEY FIRE ALARM UPGRADES

PROJECT: PORTLAND, MAINE

SECOND FLOOR FIRE ALARM PLAN - SEG B

SHEET TITLE:	3842.13 - FA102B	
WBRC CAD FILE:	3842.13	
PROJECT No.	3842.13	GRAPHIC SCALE: 0" = 1"
SCALE:	AS NOTED	
PM:	SJL	SHEET No.
DRAWN BY:	KRM	FA102B
A/E OF RECORD:	SJL	

A1 **SECOND FLOOR FIRE ALARM PLAN - SEG B**

1/8" = 1'-0"