
 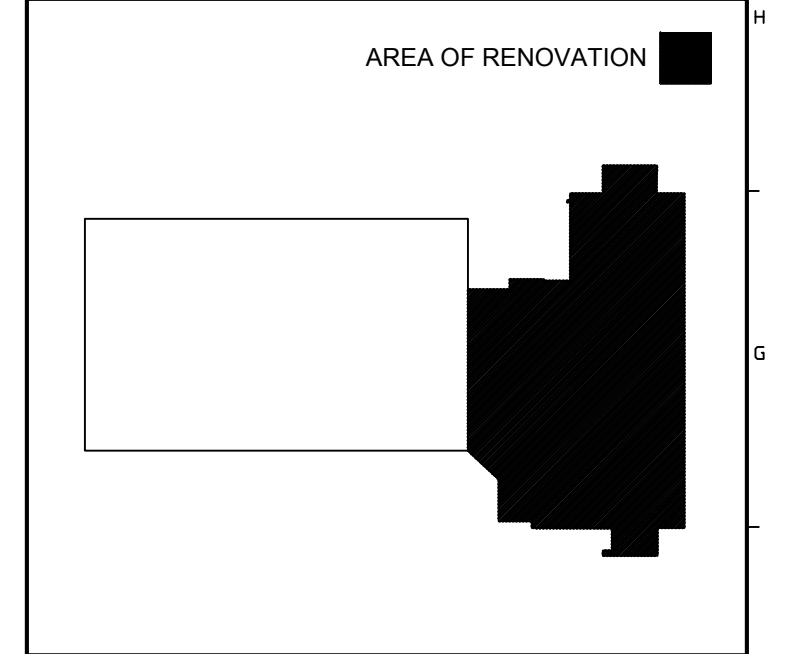



6/3/2013 9:52 AM I:\3801-3900\384210 USM FIRE ALARM SYSTEM UPGRADES\DESIGN\DWGS\BLDG\LUTHER BONNEY LUTHER FIRE ALARM UPGRADES\SHEETS\3842.13-FA104 FOURTH FLOOR FIRE ALARM PLAN.DWG KYLE MAHAR

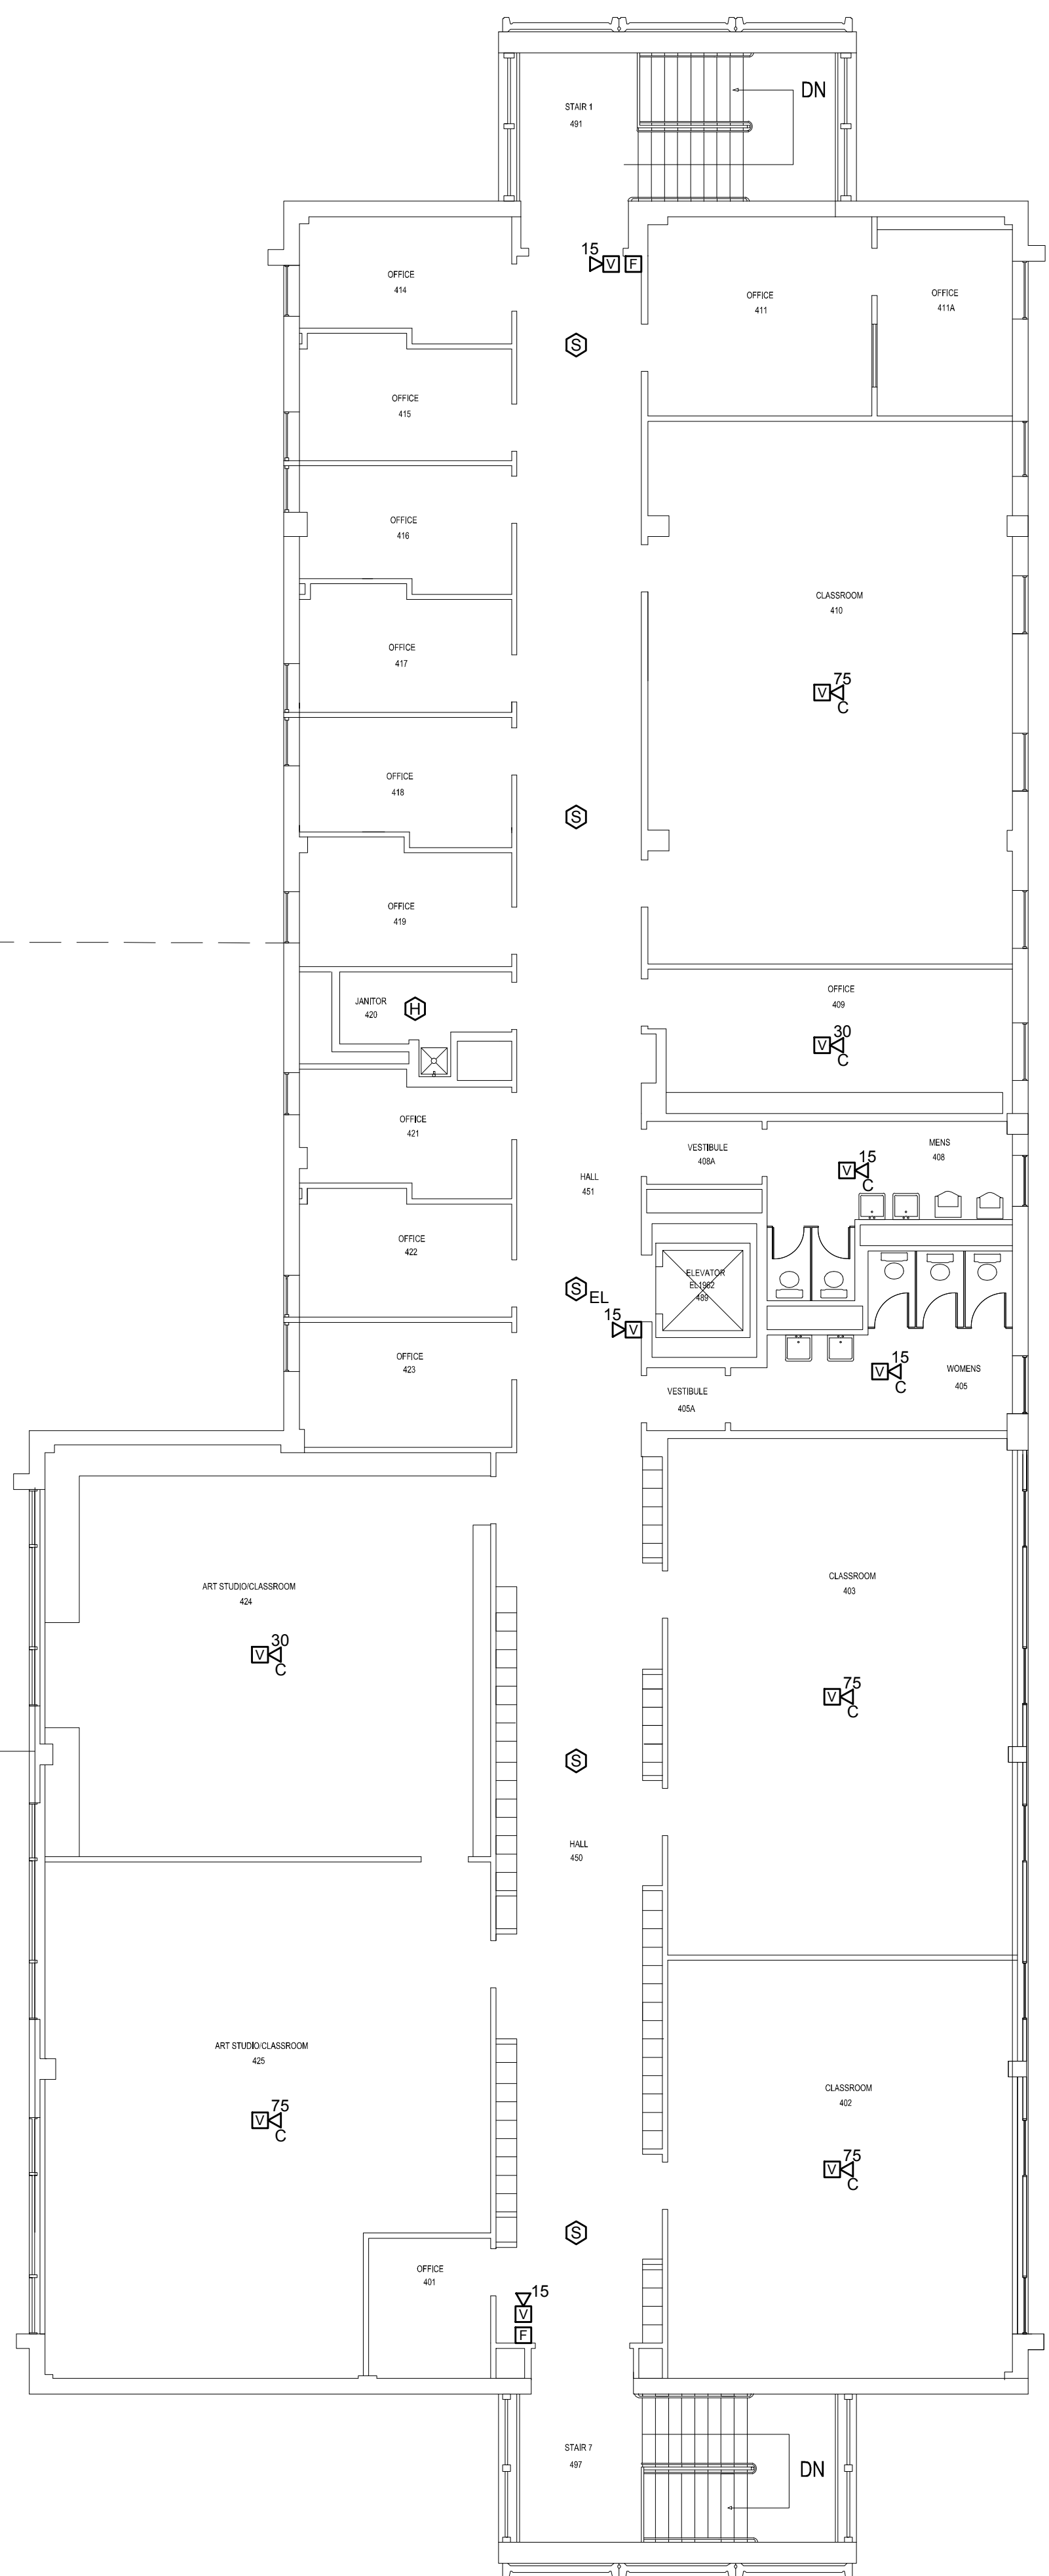

KEY PLAN

0	CONSTRUCTION DOCUMENTS	05.10.13
REV.	DESCRIPTION	DATE

CONSTRUCTION DOCUMENTS
05.10.13

CURRENT ISSUE STATUS:

PROJECT NORTH

P.C. ID. 13

WBRC
ARCHITECTS • ENGINEERS
WWW.WBRCAE.COM
BANGOR, MAINE 207-947-4511
PORTLAND, MAINE 207-626-4511
SARASOTA, FLORIDA 941-556-0757

LUTHER BONNEY FIRE ALARM UPGRADES

PROJECT: PORTLAND, MAINE
FOURTH FLOOR FIRE ALARM PLAN

SHEET TITLE:

WBRC CAD FILE:	3842.13 - FA104
PROJECT No.:	3842.13
SCALE:	AS NOTED
PM:	SJL
DRAWN BY:	KRM
A/E OF RECORD:	SJL

GRAPHIC SCALE: 0" = 1'
SHEET No. **FA104**

A1	FOURTH FLOOR FIRE ALARM PLAN
1/8" = 1'-0"	--