 




6/3/2013 9:47 AM I:\3801-3900\384210 USM FIRE ALARM SYSTEM UPGRADES\DESIGN\DWGS\LUTHER BONNEY BLDG\LUTHER BONNEY FIRE ALARM UPGRADES\SHEETS\3842.13-FA105 FIFTH FLOOR FIRE ALARM PLAN.DWG KYLE MAHAR

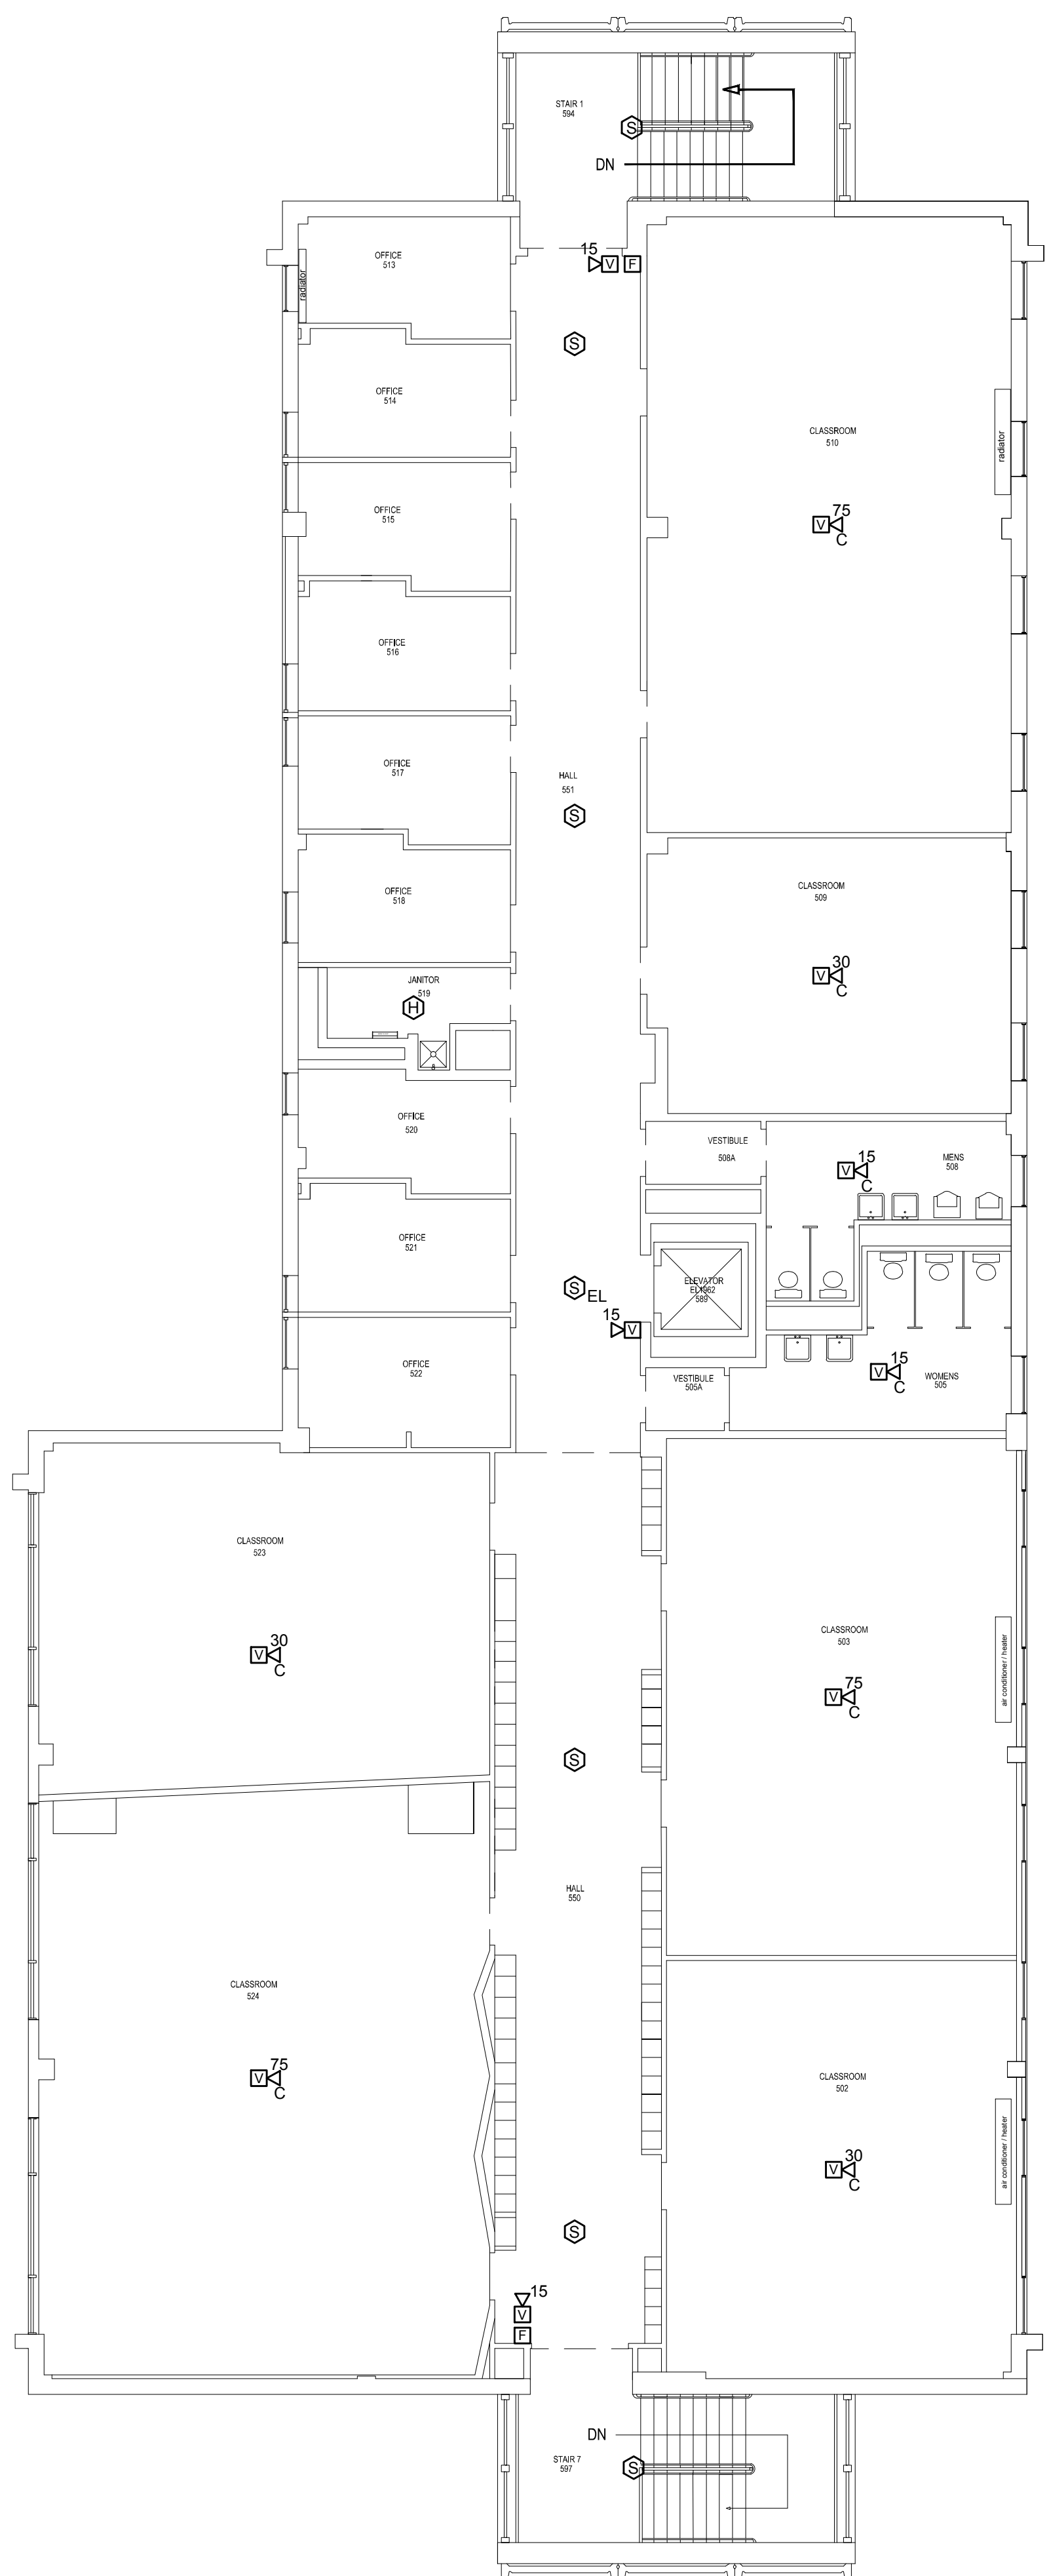

A1	FIFTH FLOOR FIRE ALARM PLAN
1/8" = 1'-0"	--

AREA OF RENOVATION

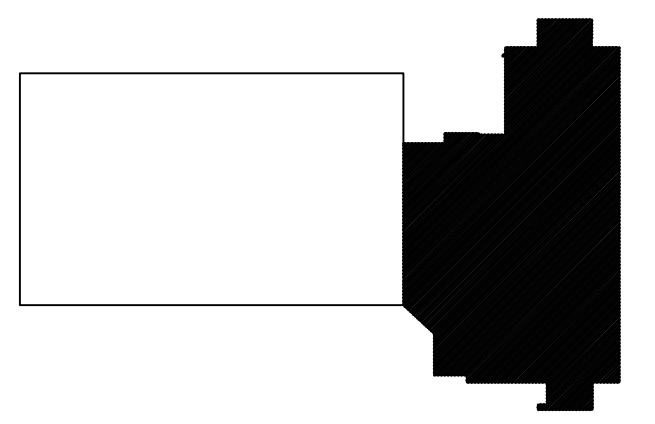

KEY PLAN

0	CONSTRUCTION DOCUMENTS	05.10.13
REV.	DESCRIPTION	DATE

CONSTRUCTION DOCUMENTS
05.10.13

CURRENT ISSUE STATUS:

PROJECT NORTH

P.C. ID. 13

WBRC
ARCHITECTS • ENGINEERS
WWW.WBRCAE.COM
BANGOR, MAINE 207-947-4511
PORTLAND, MAINE 207-626-4511
SARASOTA, FLORIDA 941-556-0757

LUTHER BONNEY FIRE ALARM UPGRADES
PROJECT: PORTLAND, MAINE

FIFTH FLOOR FIRE ALARM PLAN

SHEET TITLE:	3842.13 - FA105	
WBRC CAD FILE:	3842.13	GRAPHIC SCALE: 0" = 1'
PROJECT No.:	AS NOTED	
SCALE:	SJL	SHEET No.
PM:	KRM	FA105
DRAWN BY:	SJL	© COPYRIGHT 2013 WBRC
A/E OF RECORD:		