


6/3/2013 9:58 AM I:\3801-3900\384210 USM FIRE ALARM SYSTEM UPGRADES\DESIGN\DWGS\BLDG\PAYSON SMITH FIRE ALARM UPGRADES\SHEETS\3842.12-FA102 SECOND FLOOR FIRE ALARM PLAN.DWG KYLE MAHAR

HAZARDOUS MATERIALS NOTES:
 ① HAZARDOUS MATERIALS HAVE BEEN IDENTIFIED AND ENCAPSULATED AT PIPE INSULATION IN AND AROUND THIS SPACE. CONTRACTOR SHALL AVOID DISTURBING THIS MATERIAL.

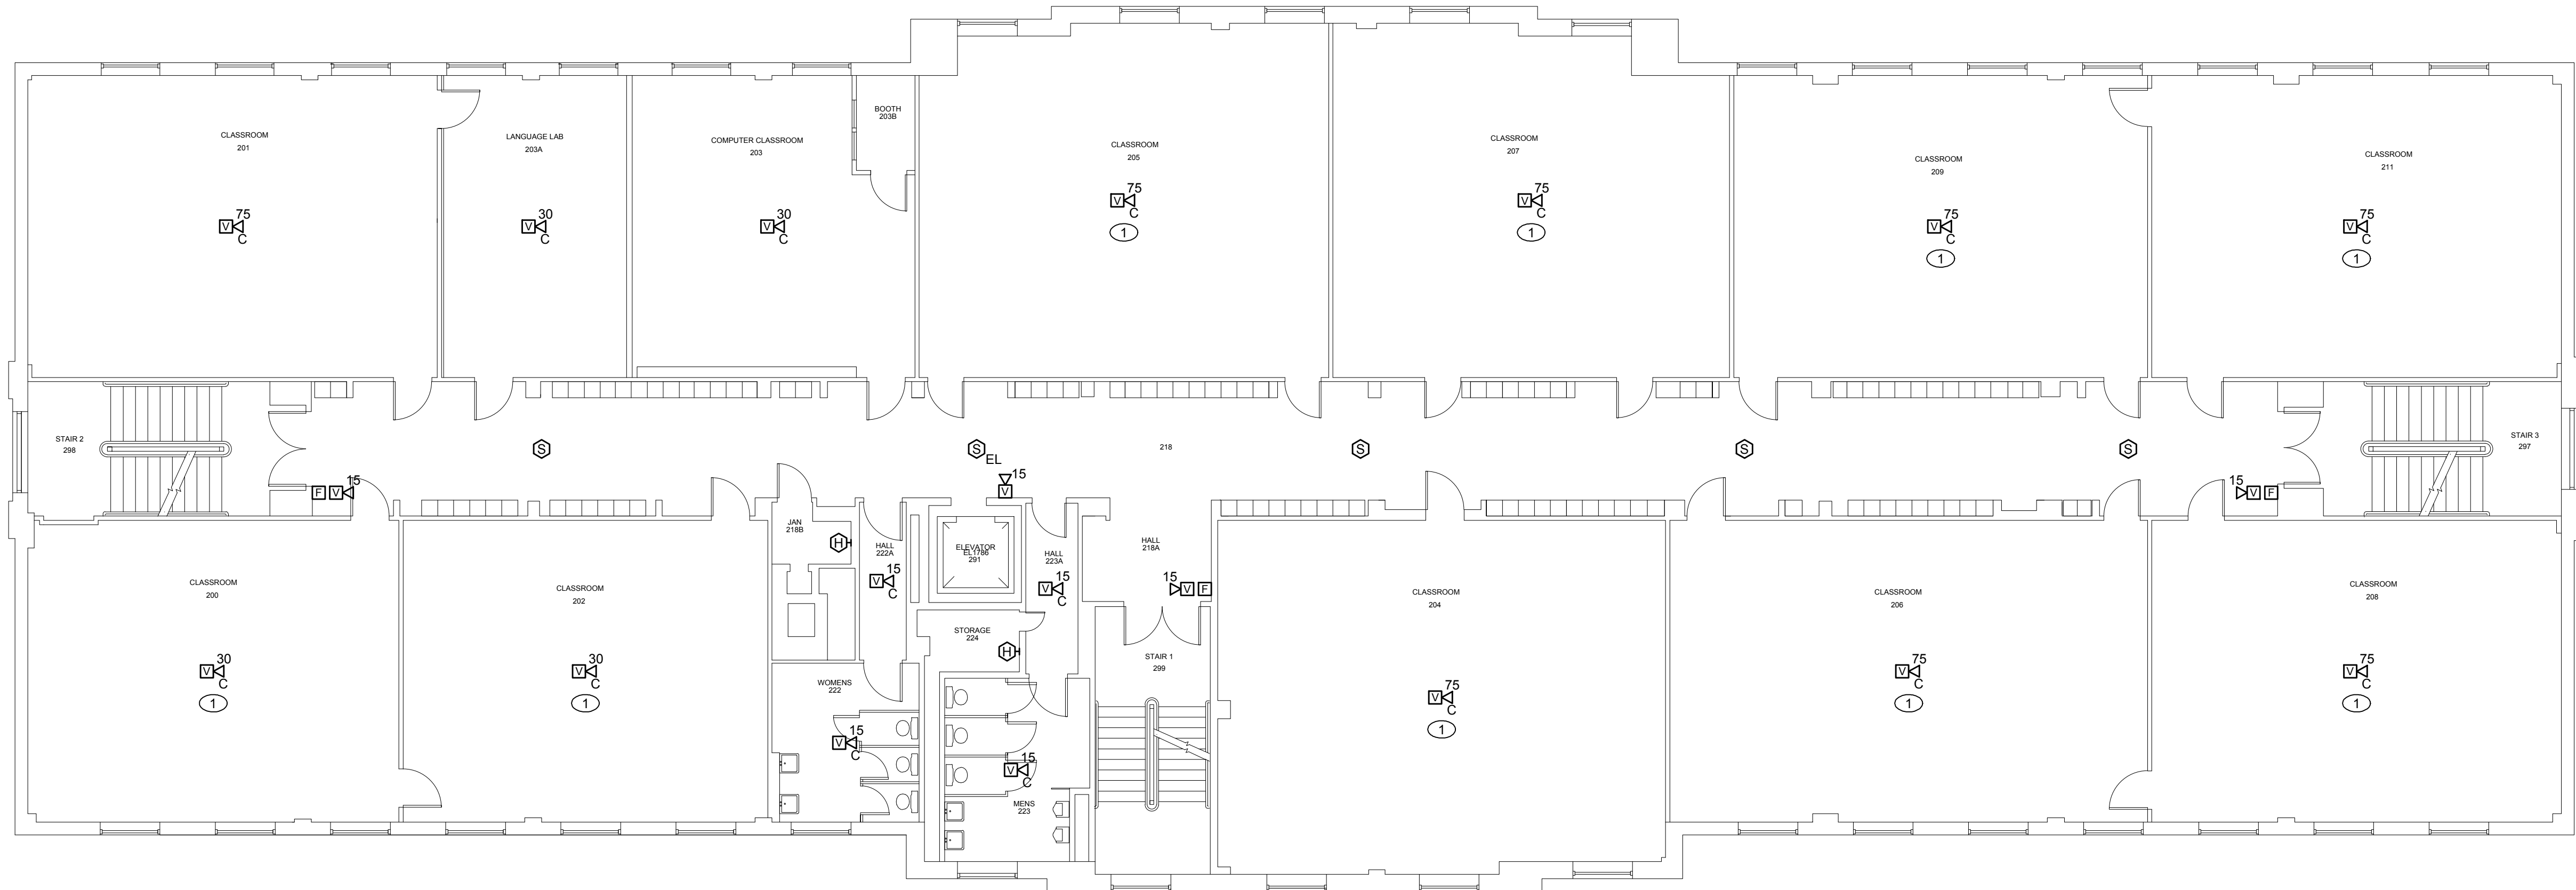

0	CONSTRUCTION DOCUMENTS	05.10.13
REV.	DESCRIPTION	DATE

CONSTRUCTION DOCUMENTS
 05.10.13

CURRENT ISSUE STATUS:

PROJECT NORTH

STATE OF MAINE
 STEPHANIE LAPLANT
 No. 10272
 LICENSED PROFESSIONAL ENGINEER

WBRC
 ARCHITECTS • ENGINEERS
 www.wbrcae.com
 BANGOR, MAINE 207-947-4511
 PORTLAND, MAINE 207-638-4511
 SARASOTA, FLORIDA 941-556-0737

PAYSON SMITH FIRE ALARM UPGRADES

PROJECT: PORTLAND, MAINE

SECOND FLOOR FIRE ALARM PLAN

SHEET TITLE:

WBRC CAD FILE:	3842.12 - FA102
PROJECT No.:	3842.12
SCALE:	AS NOTED
PM:	SJL
DRAWN BY:	KRM
A/E OF RECORD:	SJL

GRAPHIC SCALE: 0" = 1"
 SHEET No. **FA102**

A1 SECOND FLOOR FIRE ALARM PLAN

1/8" = 1'-0"