

- 1. RELOCATE RESEARCH OVERSIGHT / LAB LOCATION. PROVIDE NECESSARY SERVICES FOR INSTALLATION.
- 2. PROVIDE FILL OUT WORK SURFACE IN OVERSIGHT AT 28' A.F.F.
- 3. RELOCATE NECESSARY SERVICES FOR RESEARCH OVERSIGHT FROM FIRST FLOOR TO THIS LOCATION. PROVIDE NECESSARY SERVICES FOR OVERSIGHT.
- 4. TEMPORARY LOCATION OF RELOCATED ICE MACHINE (LA-M18). PROVIDE MEP SERVICES IN THIS LOCATION FOR OVERSIGHT.
- 5. OVERSIGHT AND FINISHES N.I.C. (NOT IN CONTRACT). PROVIDE NECESSARY SERVICES FOR OVERSIGHT TO MECHANICAL, ELECTRICAL AND PLUMBING DMS FOR EXHIBIT OF MEP WORK.
- 6. OVERSIGHT, EQUIPMENT AND FINISHES N.I.C. (NOT IN CONTRACT). PROVIDE NECESSARY SERVICES FOR OVERSIGHT TO MECHANICAL, ELECTRICAL AND PLUMBING DMS FOR EXHIBIT OF MEP WORK.

FOURTH FLOOR PLAN - PART A

SCALE: 1/4" = 1'-0"

DRAWN BY: AJT/GAK

CHECKED BY: PROJ. ARCH / ENGR. LTD.

PROJ. NO.: R04

JOB NO.: 03049110

OWNER: SYMMES MAINTIN & MCKEE ASSOCIATES, INC. 2014

RESEARCH WING PHASE III FIT-OUT

UNIVERSITY OF SOUTHERN MAINE
 79 FALMOUTH STREET
 PORTLAND, MAINE

NO. DATE DESCRIPTION

ISSUE LOG

△ = GROUND CHANGE

04.21.06 ISSUED FOR CONSTRUCTION

05.03.06 SCOPE REVISION

03.22.06 100% DC REVIEW

B 03.16.06 PROGRESS PRINT

A 03.08.06 80% PROGRESS PRINT

OWNER REVIEW DATE

DATE

DATE


DATE

DATE

DATE

DATE

DATE

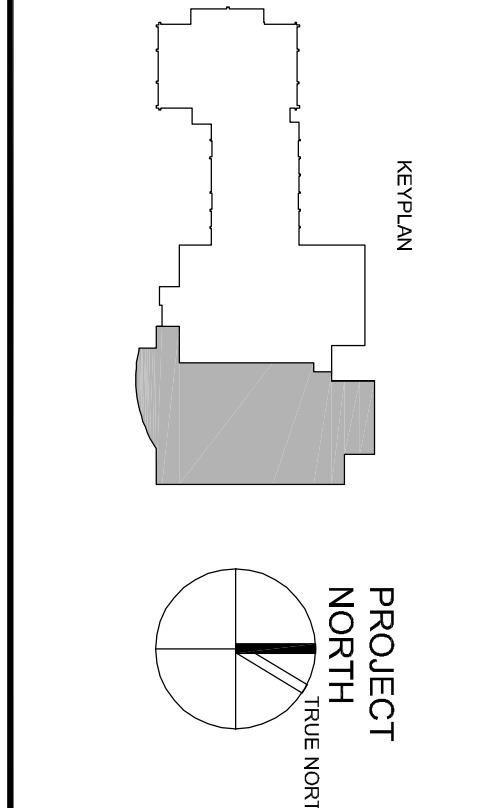

A1.042