

DRAWING ISSUE LOG

LEGEND	
●	ISSUED WITH THIS PACKAGE
○	PREVIOUSLY ISSUED AND NOT ISSUED

DATE	DESIGN REVIEW PACKAGE
03.08.06	80% PROGRESS PRINT
03.16.06	PROGRESS PRINT
03.22.06	100% OC REVIEW
05.03.06	SCOPE REVISIONS
06.21.06	ISSUED FOR CONSTRUCTION

NO.	DRAWING NAME	ISSUED
GS.01	COVER AND DRAWING ISSUE LOG	○ ○ ○ ○ ●

ARCHITECTURAL

AA.01	ABBREVIATIONS, SYMBOLS, DOOR AND WALL TYPES	○ ○ ○ ○ ●
AA.02	BUILDING CODE DESIGN SUMMARY	○ ○ ○ ○ ●
AA.01	BASEMENT AND FIRST FLOOR PARTIAL PLANS	○ ○ ○ ○ ●
AA.02	2ND FLOOR PLAN PART A	○ ○ ○ ○ ●
AA.03	2ND FLOOR PLAN PART B	○ ○ ○ ○ ●
AA.04	4TH FLOOR PLAN PART A	○ ○ ○ ○ ●
AA.04B	4TH FLOOR PLAN PART B	○ ○ ○ ○ ●
AA.05A	5TH FLOOR PLAN PART A	○ ○ ○ ○ ●
AA.05B	5TH FLOOR PLAN PART B	○ ○ ○ ○ ●
AA.06	ROOF FLOORS	○ ○ ○ ○ ●
AA.06B	ROOF PLAN, ELEVATIONS AND DETAILS	○ ○ ○ ○ ●
AA.01	TOILET ROOM PLANS AND ELEVATIONS	○ ○ ○ ○ ●
AA.02A	SECOND FLOOR REFLECTED CEILING PLAN PART A	○ ○ ○ ○ ●
AA.02B	SECOND FLOOR REFLECTED CEILING PLAN PART B	○ ○ ○ ○ ●
AA.04A	4TH FLOOR REFLECTED CEILING PLAN PART A	○ ○ ○ ○ ●
AA.04B	4TH FLOOR REFLECTED CEILING PLAN PART B	○ ○ ○ ○ ●
AA.05A	5TH FLOOR REFLECTED CEILING PLAN PART A	○ ○ ○ ○ ●
AA.05B	5TH FLOOR REFLECTED CEILING PLAN PART B	○ ○ ○ ○ ●
AA.01	INTERIOR ELEVATIONS	○ ○ ○ ○ ●
AA.02	INTERIOR ELEVATIONS	○ ○ ○ ○ ●
AZ.03	INTERIOR ELEVATIONS AND CASEWORK DETAILS	○ ○ ○ ○ ●
AZ.04	INTERIOR DETAILS	○ ○ ○ ○ ●
AT.02	FINISHES PLAN— SECOND FLOOR	○ ○ ○ ○ ●
AT.04	FINISHES PLAN— FOURTH FLOOR	○ ○ ○ ○ ●
AT.05	FINISHES PLAN— FIFTH FLOOR	○ ○ ○ ○ ●

STRUCTURAL

ST.01	1ST FLOOR FLOOR FINISHING PLAN	○ ○ ○ ○ ●
ST.01	NEW FIFTH FLOOR FINISHING PLAN	○ ○ ○ ○ ●
ST.01	NEW ROOF FINISHING PLAN	○ ○ ○ ○ ●

FIRE PROTECTION

FP.01	LEGEND, NOTES AND DETAILS	○ ○ ○ ○ ●
FP.02A	SECOND FLOOR PLAN— PART A	○ ○ ○ ○ ●
FP.02B	SECOND FLOOR PLAN— PART B	○ ○ ○ ○ ●
FP.03A	THIRD FLOOR PLAN— PART A	○ ○ ○ ○ ●
FP.03B	THIRD FLOOR PLAN— PART B	○ ○ ○ ○ ●
FP.04A	FOURTH FLOOR PLAN— PART A	○ ○ ○ ○ ●
FP.04B	FOURTH FLOOR PLAN— PART B	○ ○ ○ ○ ●
FP.05A	FIFTH FLOOR PLAN— PART A	○ ○ ○ ○ ●
FP.05B	FIFTH FLOOR PLAN— PART B	○ ○ ○ ○ ●

PLUMBING

PO.01	LEGEND AND NOTES	○ ○ ○ ○ ●
PO.02	SCHEDULES	○ ○ ○ ○ ●
PI.02A	SECOND FLOOR PLAN— PART A	○ ○ ○ ○ ●
PI.02B	SECOND FLOOR PLAN— PART B	○ ○ ○ ○ ●
PI.03A	THIRD FLOOR PLAN— PART A	○ ○ ○ ○ ●
PI.03B	THIRD FLOOR PLAN— PART B	○ ○ ○ ○ ●
PI.04A	FOURTH FLOOR PLAN— PART A	○ ○ ○ ○ ●
PI.04B	FOURTH FLOOR PLAN— PART B	○ ○ ○ ○ ●
PI.05A	FIFTH FLOOR PLAN— PART A	○ ○ ○ ○ ●
PI.05B	FIFTH FLOOR PLAN— PART B	○ ○ ○ ○ ●
PI.01	DOMESTIC WATER RISER DIAGRAM	○ ○ ○ ○ ●
PI.02	WASTE & VENT RISER DIAGRAM	○ ○ ○ ○ ●
PI.03	PROCESS FLOW DIAGRAM NO. 1	○ ○ ○ ○ ●
PI.04	PROCESS FLOW DIAGRAM NO. 2	○ ○ ○ ○ ●
PI.01	DETAIL SHEET NO. 1	○ ○ ○ ○ ●
PI.02	DETAIL SHEET NO. 2	○ ○ ○ ○ ●

MECHANICAL

MO.01	LEGEND	○ ○ ○ ○ ●
MO.02	SCHEDULE SHEET 1 OF 2	○ ○ ○ ○ ●
MO.03	SCHEDULE SHEET 2 OF 2	○ ○ ○ ○ ●
MO.02A	SECOND FLOOR DEMOLITION PLAN— PART A	○ ○ ○ ○ ●
MO.02B	SECOND FLOOR DEMOLITION PLAN— PART B	○ ○ ○ ○ ●
MO.03A	3RD FLOOR DEMOLITION PLAN— PART A	○ ○ ○ ○ ●
MO.03B	3RD FLOOR DEMOLITION PLAN— PART B	○ ○ ○ ○ ●
MO.04A	4TH FLOOR PLAN PART A	○ ○ ○ ○ ●
MO.04B	4TH FLOOR PLAN PART B	○ ○ ○ ○ ●
MO.05A	5TH FLOOR PLAN PART A	○ ○ ○ ○ ●
MO.05B	5TH FLOOR PLAN PART B	○ ○ ○ ○ ●
MO.06	ROOF PLAN	○ ○ ○ ○ ●
MO.07	BASEMENT PART PLAN	○ ○ ○ ○ ●
MO.08	CONTROL DIAGRAM	○ ○ ○ ○ ●
MO.09	CONTROL DIAGRAM	○ ○ ○ ○ ●
MO.10	SECTION SHEET	○ ○ ○ ○ ●
MO.11	DETAILS	○ ○ ○ ○ ●
MO.12	DETAILS	○ ○ ○ ○ ●
MO.13	DETAILS	○ ○ ○ ○ ●
MO.14	DETAILS	○ ○ ○ ○ ●

ELECTRICAL

EO.01	LEGEND AND FIXTURE SCHEDULE	○ ○ ○ ○ ●
EO.02	SECOND FLOOR— DEMOLITION PLAN	○ ○ ○ ○ ●
EO.03	3RD FLOOR— DEMOLITION PLAN	○ ○ ○ ○ ●
EO.04	4TH FLOOR POWER PLAN PART A	○ ○ ○ ○ ●
EO.04B	4TH FLOOR POWER PLAN PART B	○ ○ ○ ○ ●
EO.05	5TH FLOOR POWER PLAN	○ ○ ○ ○ ●
EO.06	BASEMENT, ROOF AND PENHOUSE PART PLANS	○ ○ ○ ○ ●
EO.02	SECOND FLOOR LIGHTING PLAN	○ ○ ○ ○ ●
EO.04A	4TH FLOOR LIGHTING PLAN PART A	○ ○ ○ ○ ●
EO.04B	4TH FLOOR LIGHTING PLAN PART B	○ ○ ○ ○ ●
EO.05	5TH FLOOR LIGHTING PLAN	○ ○ ○ ○ ●
EO.01	ONE-LINE DIAGRAM	○ ○ ○ ○ ●
EO.01	DETAILS	○ ○ ○ ○ ●
EO.02	DETAILS	○ ○ ○ ○ ●
EO.03	DETAILS	○ ○ ○ ○ ●
EO.04	DETAILS	○ ○ ○ ○ ●
EO.01	PANEL BOARD SCHEDULES	○ ○ ○ ○ ●

# UNIVERSITY OF SOUTHERN MAINE

## RESEARCH WING PHASE III FIT-OUT


### FLOORS 2, 4 AND 5

70 FALMOUTH STREET, PORTLAND, ME

ISSUED FOR CONSTRUCTION

JUNE 21, 2006

SMMMA NUMBER 03049.10

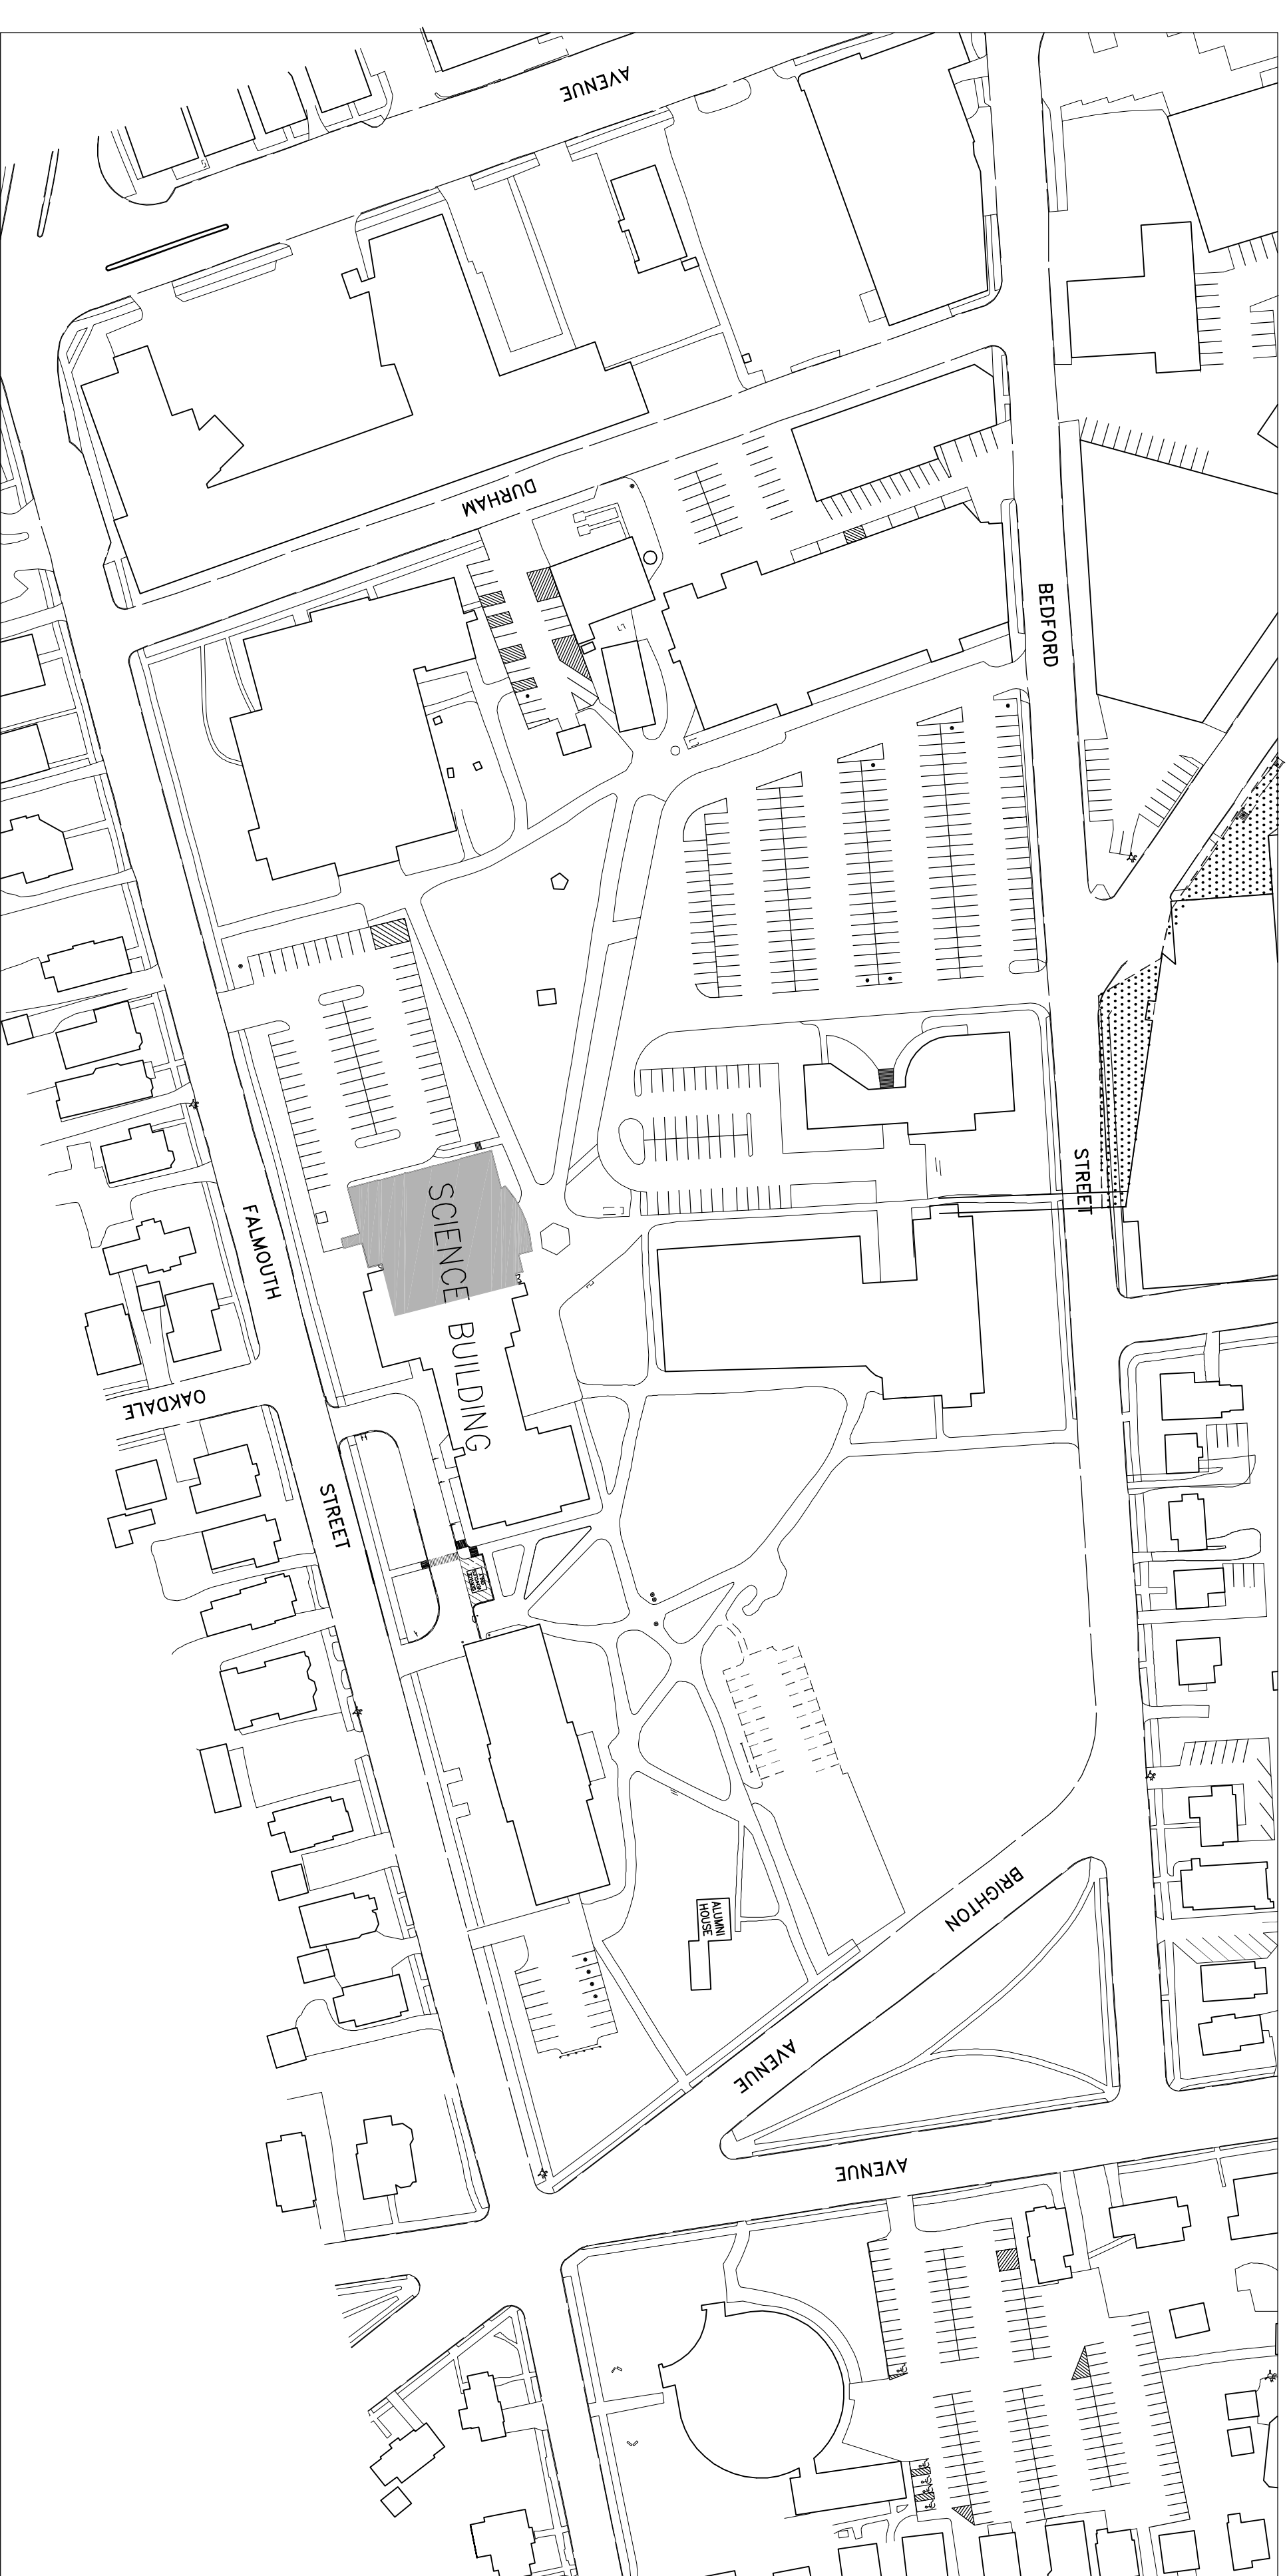

CAMPUS MAP



STEWART MAINI & MCKEE ASSOCIATES

1000 Massachusetts Avenue  
Cambridge, Massachusetts 02138