
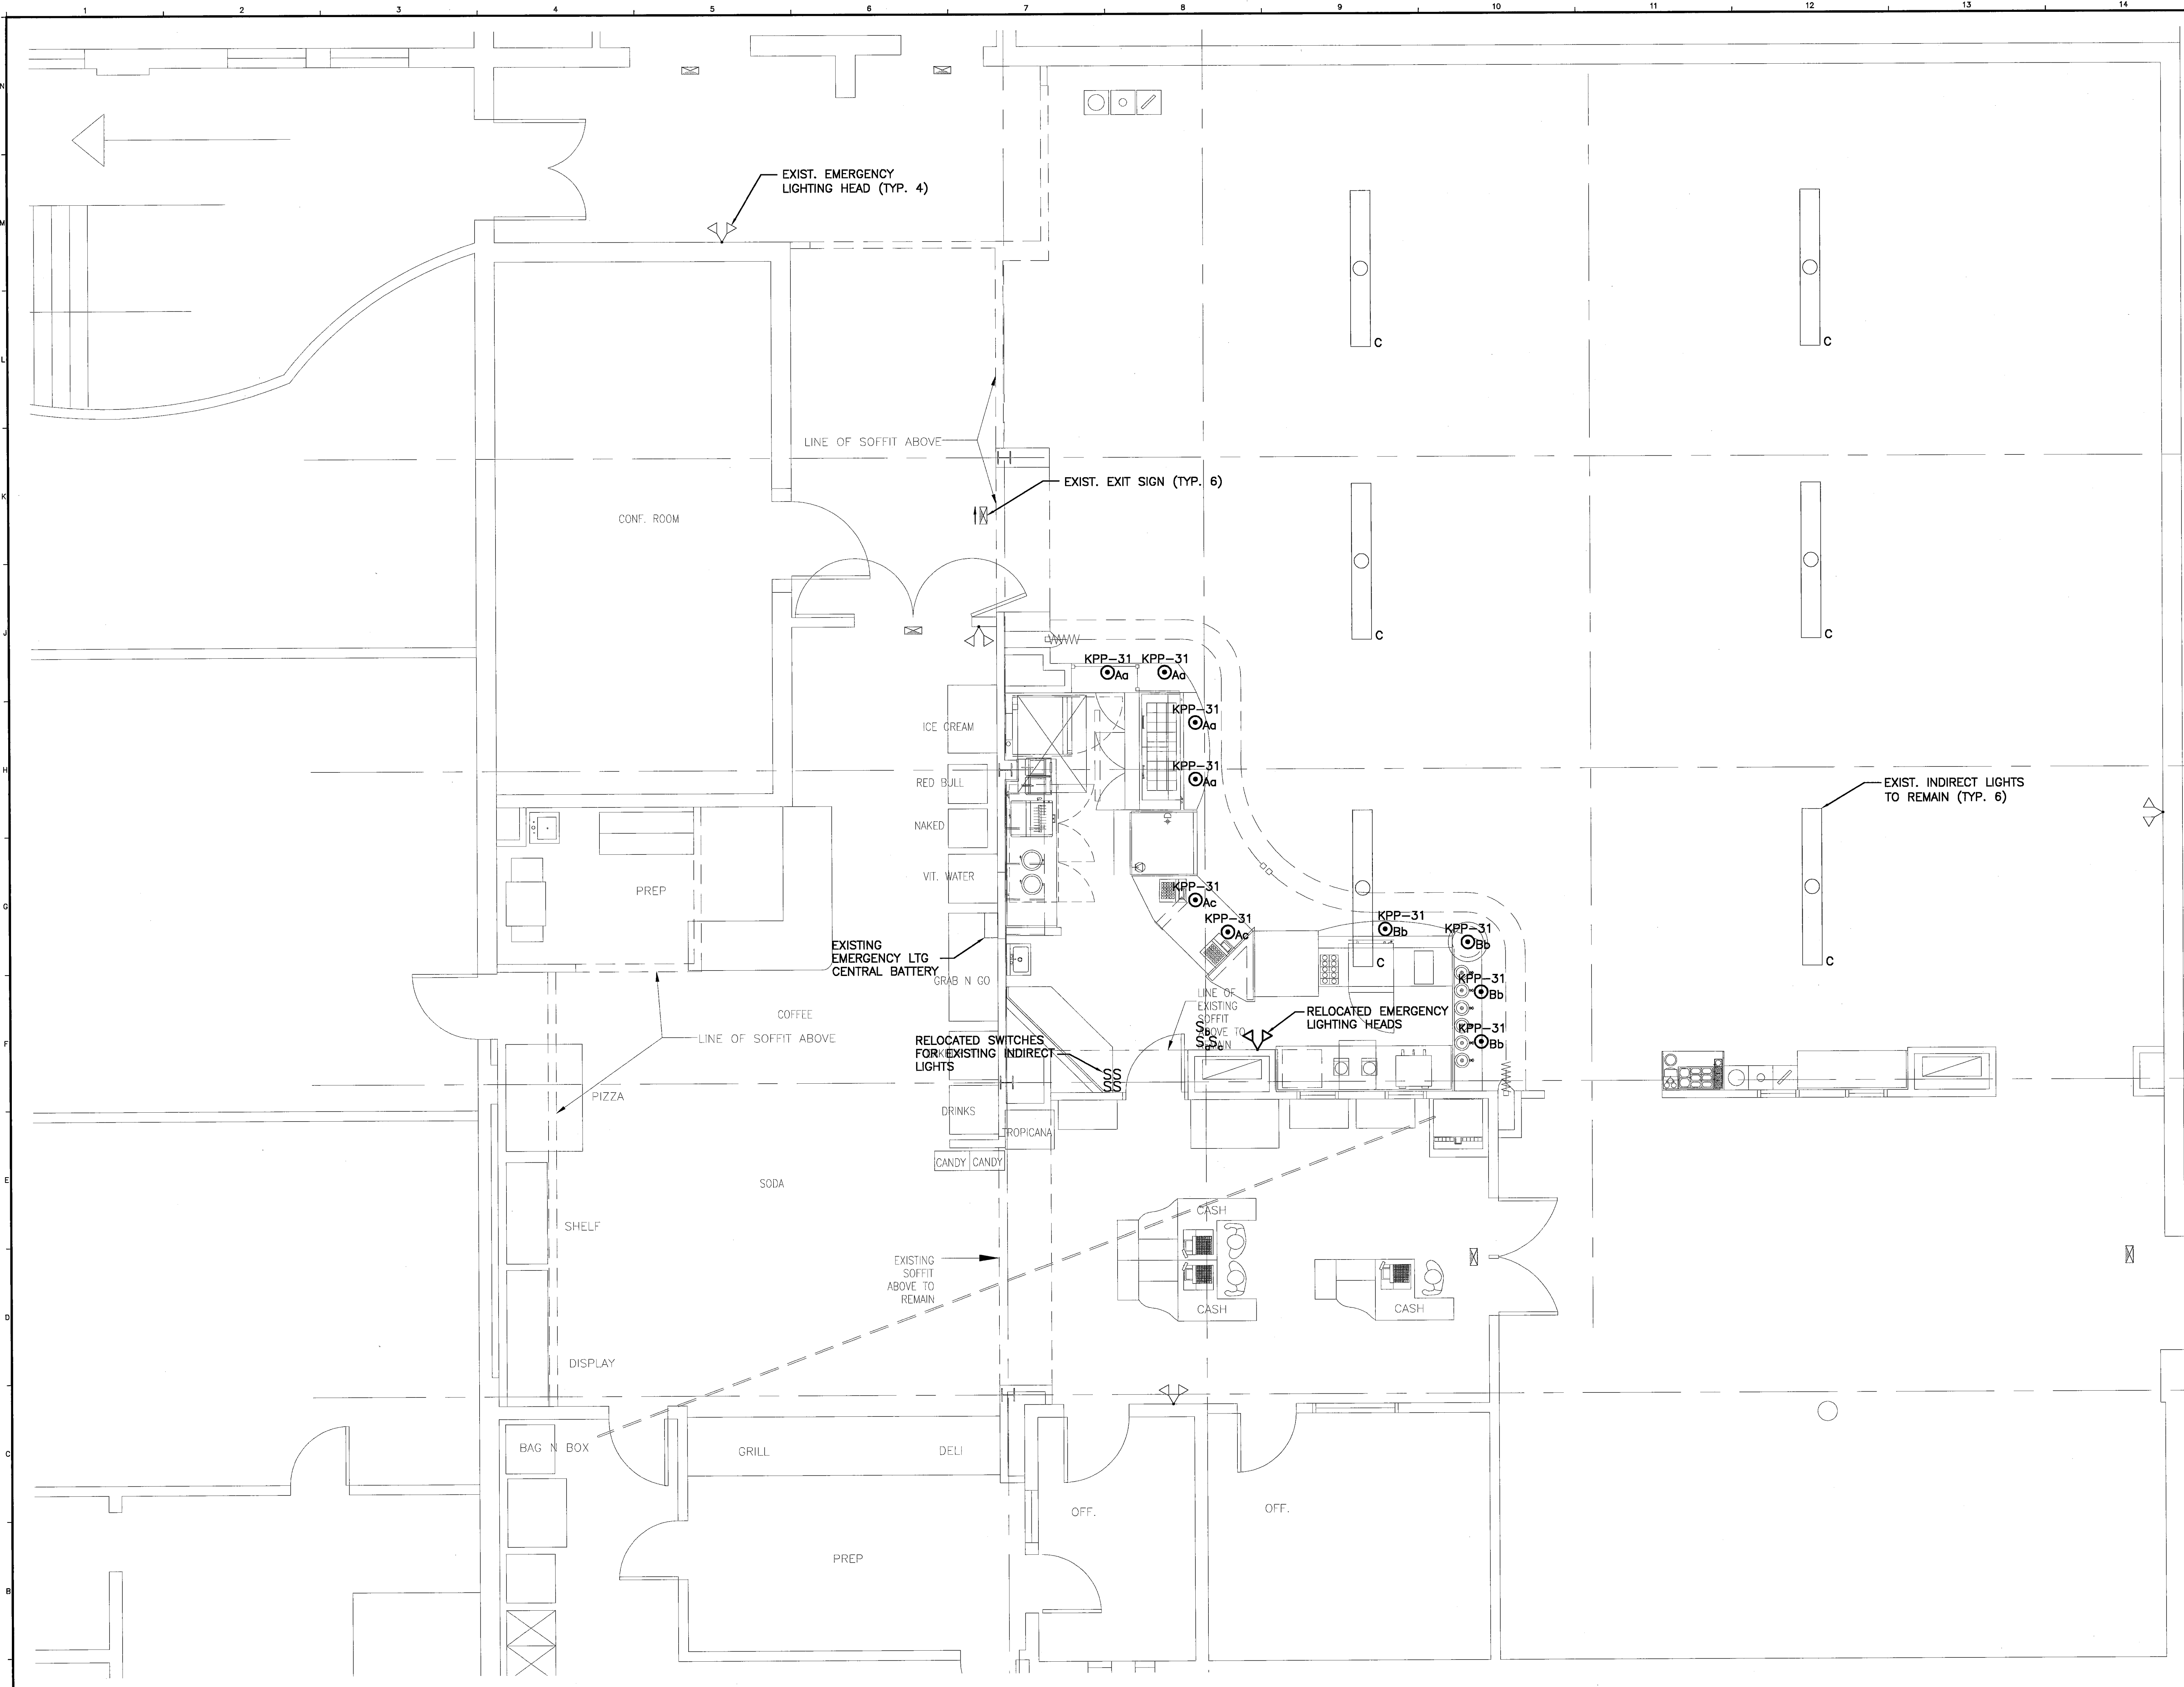


NOTE:
 1. SEE SHEET E-001 FOR LEGEND AND GENERAL NOTES.
 2. SEE SHEET EP101 FOR LOCATION OF PANELBOARD KPP.

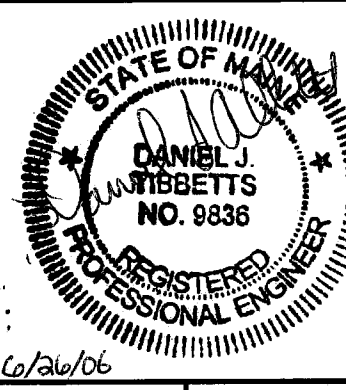

UNIVERSITY OF MAINE
 KITCHEN RENOVATIONS
 PORTLAND & GORHAM CAMPUS
 PROJECT TITLE:
 CURRENT ISSUE STATUS:
ISSUED FOR CONSTRUCTION
6-23-06

| REV | DESCRIPTION | DATE |
|-----|-------------------------|---------|
| 0 | ISSUED FOR CONSTRUCTION | 6-23-06 |

GRAPHIC SCALE:
 0" 1"

SCALE: AS NOTED
 PROJECT MANAGER: DJT
 JC/DRAWN BY: LAM
 A/E OF RECORD: DJT
 CAD FILE: EL101-06107
 PROJECT NO: 06107
 DATE: 6-23-06

SHEET TITLE:
WOODBURY COMMON LIGHTING PLAN

A1 FLOOR PLAN

1/4"=1'-0"