


Project Title

**UNIVERSITY OF MAINE SYSTEM  
DATA CENTER UPGRADES**


Portland, Maine

HA Project No. 09533

Key Plan

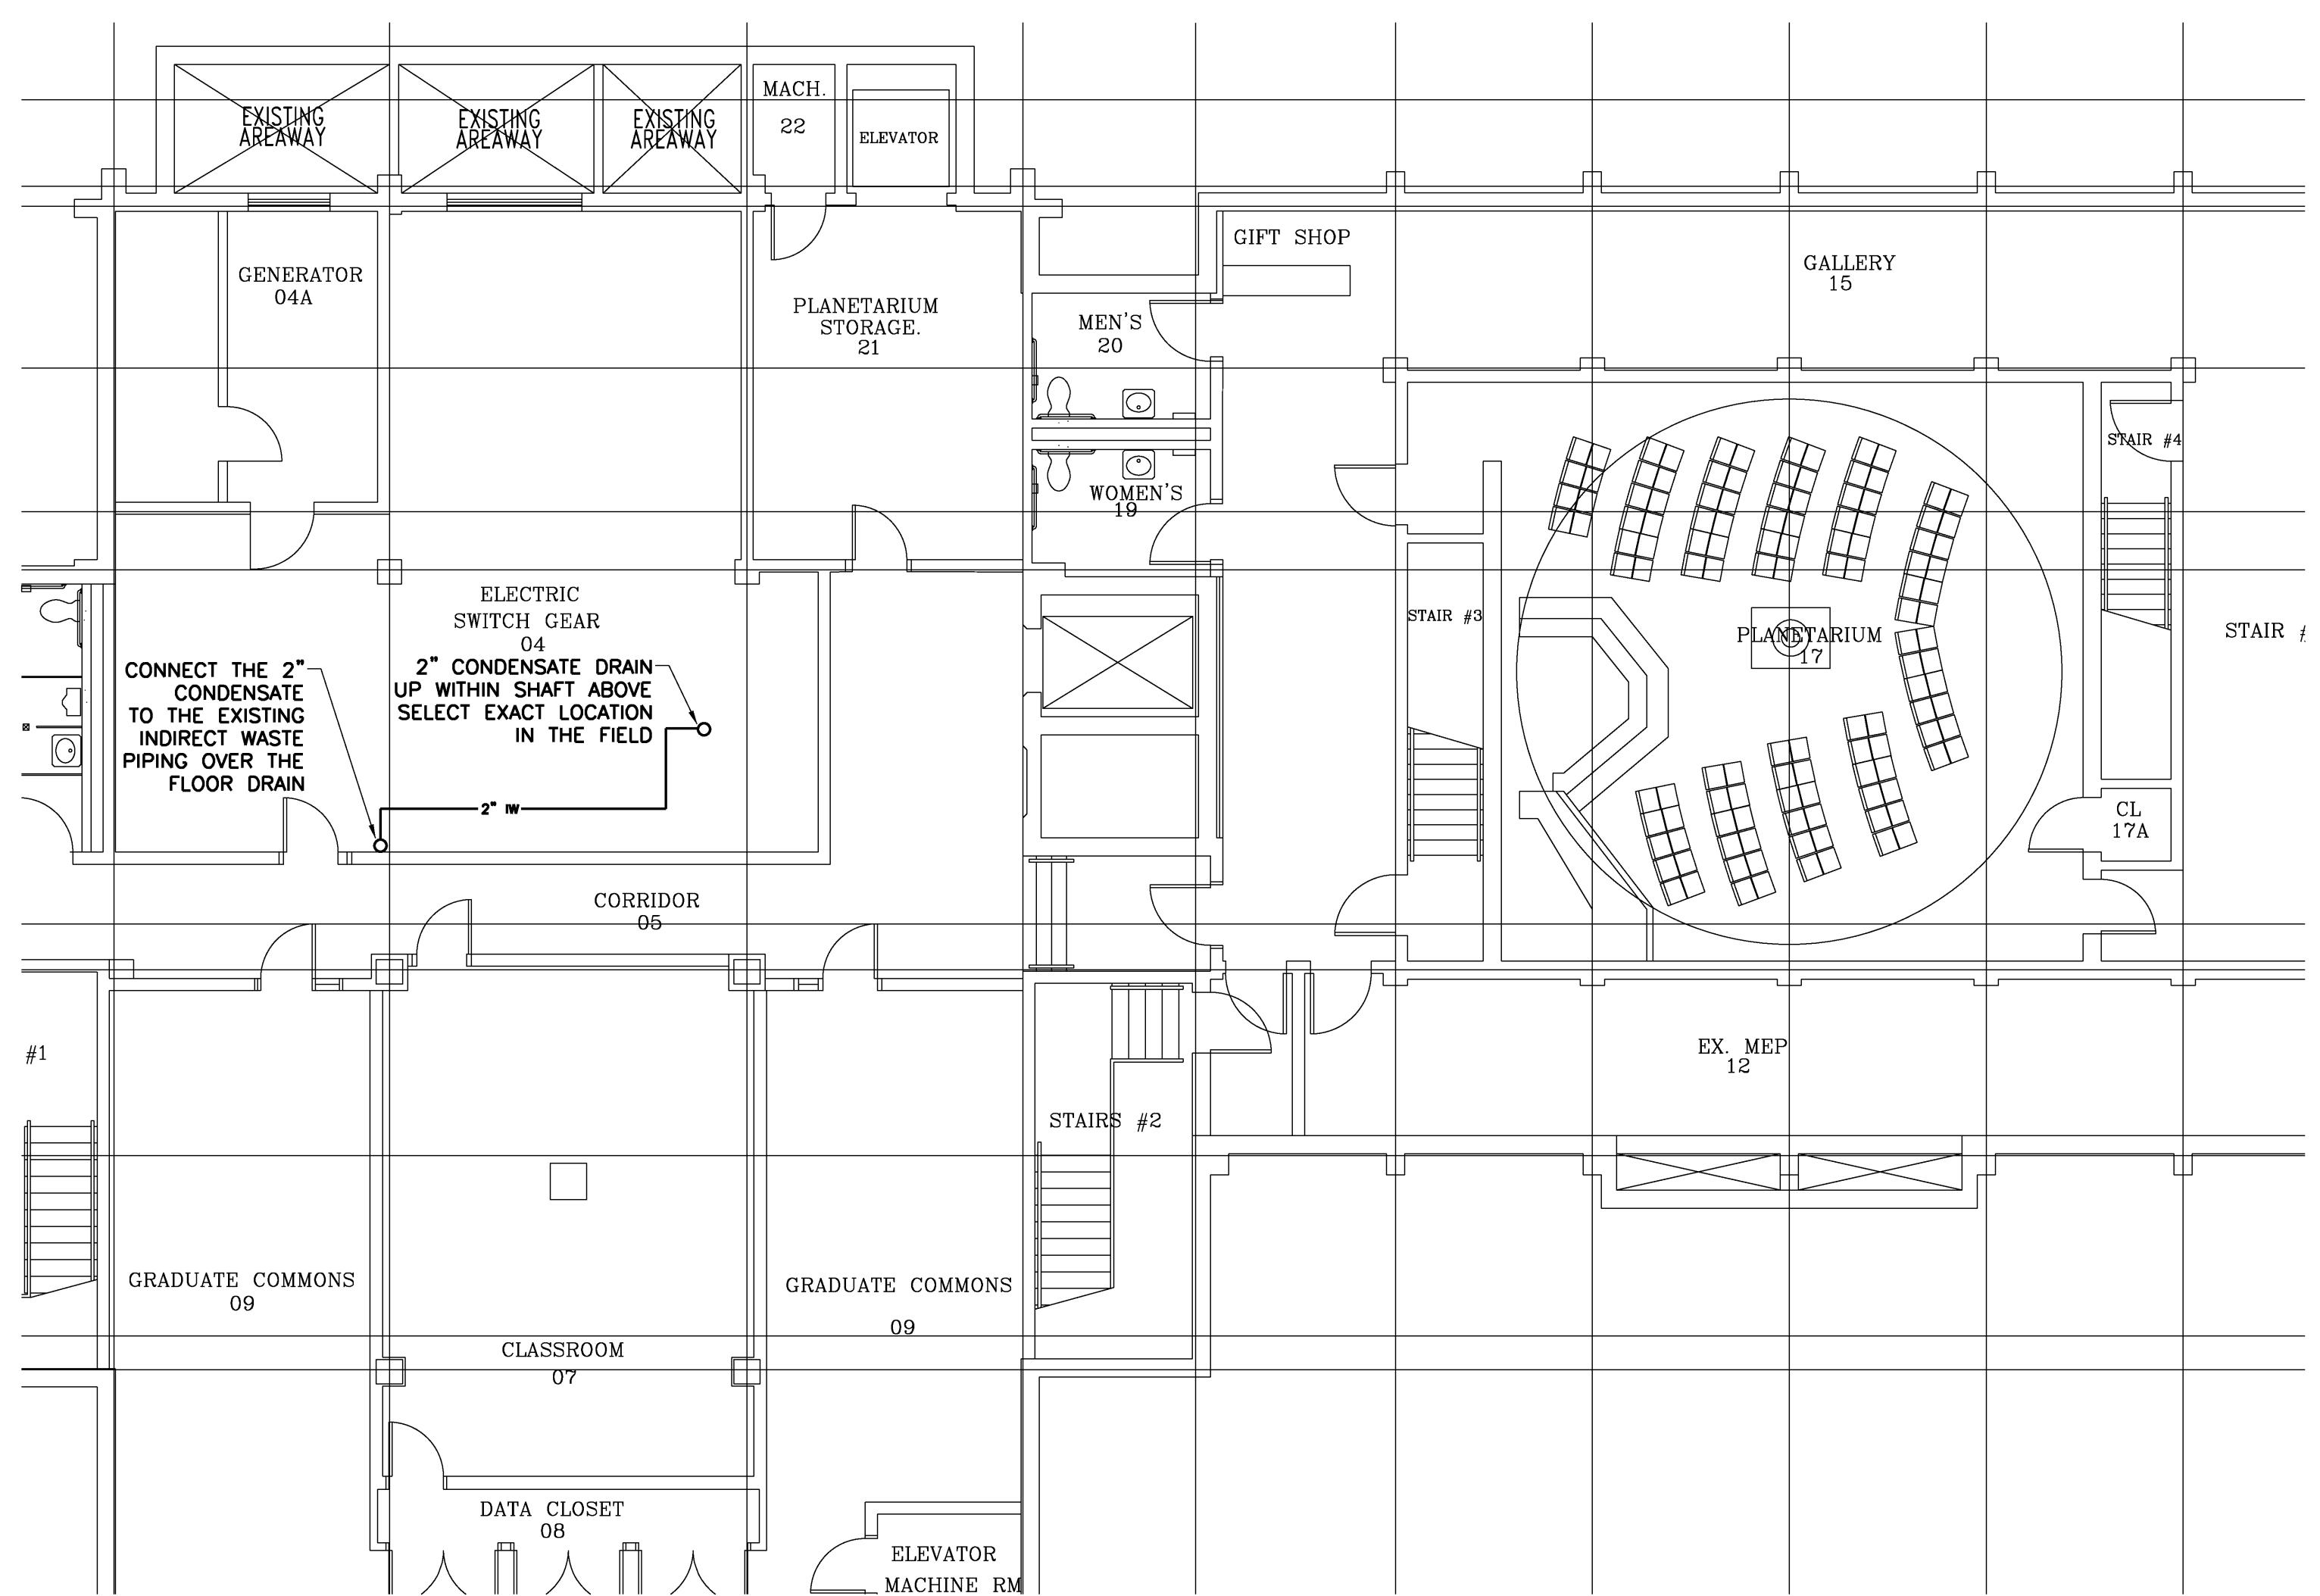

**GROUND FLOOR PLAN**  
1/8" = 1'-0" 0 4' 8' 12' REF: NA **A2**

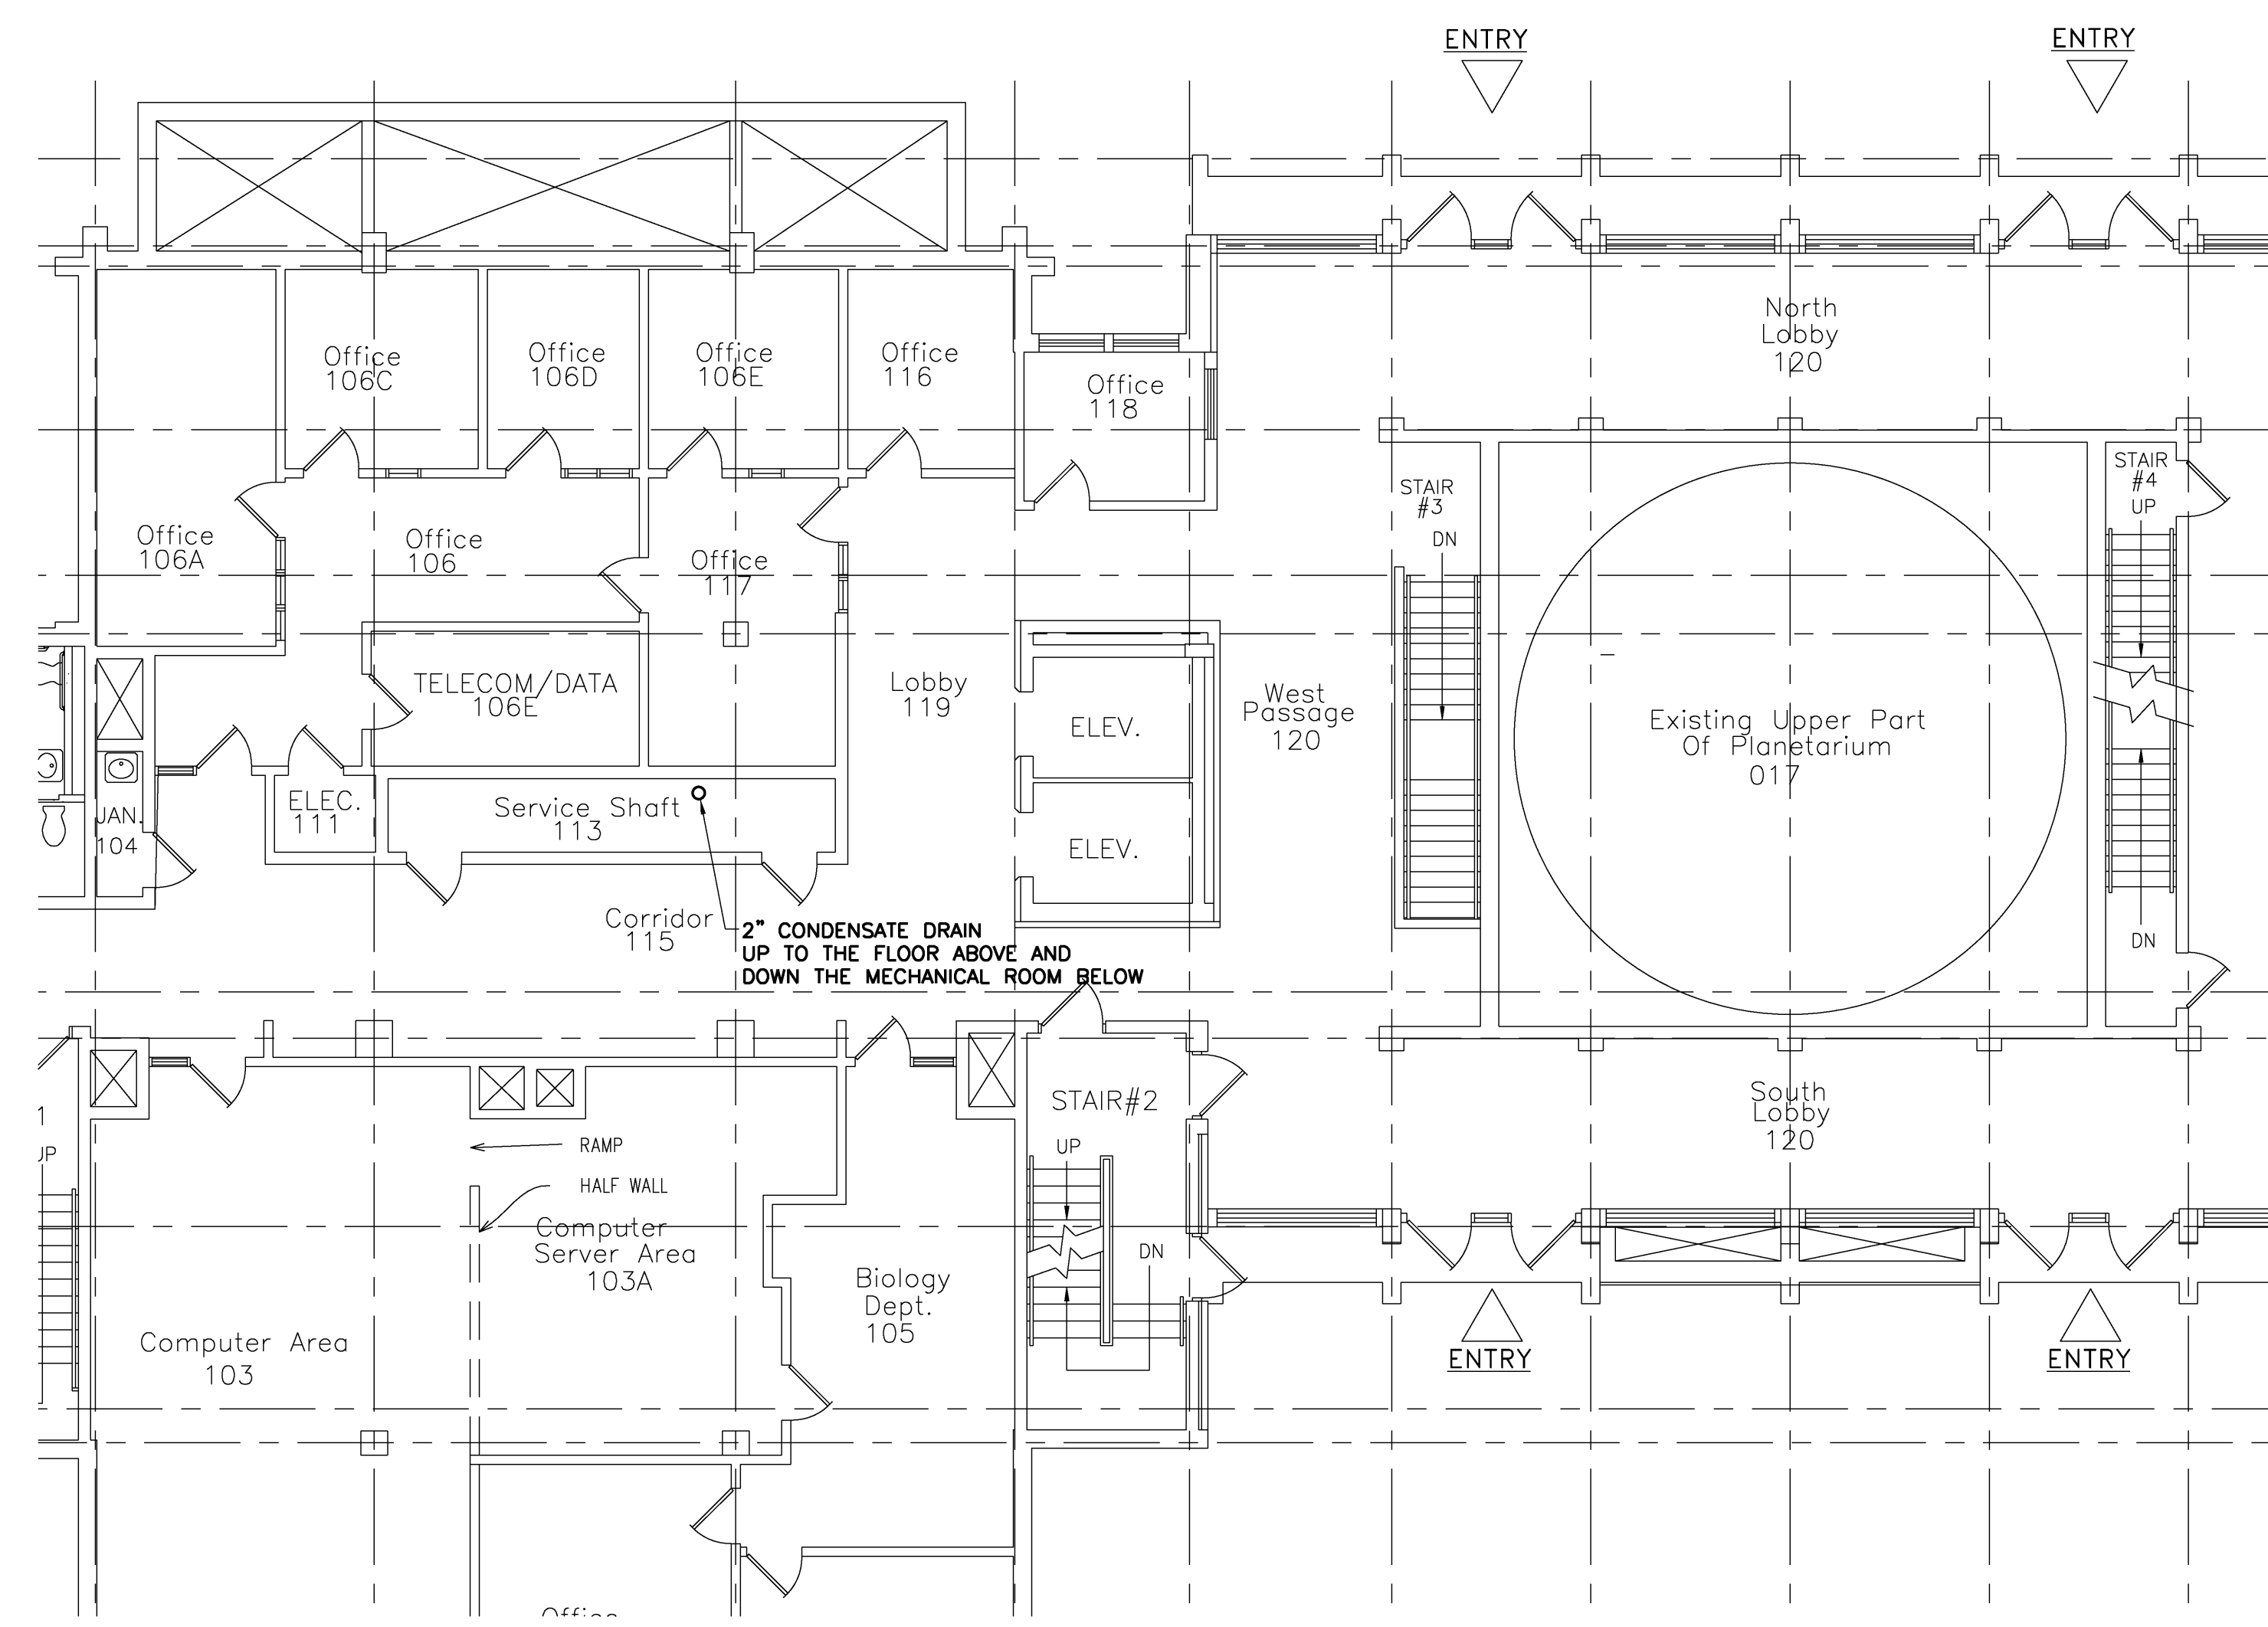

**FIRST FLOOR PLAN**  
1/8" = 1'-0" 0 4' 8' 12' REF: NA **A1**

Issue Dates	Description	
05-09-2011	ISSUED FOR BID	
04-05-2011	ISSUED FOR 100% REVIEW	
01-24-2011	ISSUED FOR 75% REVIEW	
Mark	Date	Description

Drawing Status

Drawing Title

**GROUND AND FIRST FLOOR PLANS**

PA / PE: CG Drawn By: ROM

Drawing Number

**P10.1**