


Project Title

**UNIVERSITY OF MAINE SYSTEM  
DATA CENTER  
UPGRADES**

Portland, Maine

HA Project No. 09533

Key Plan

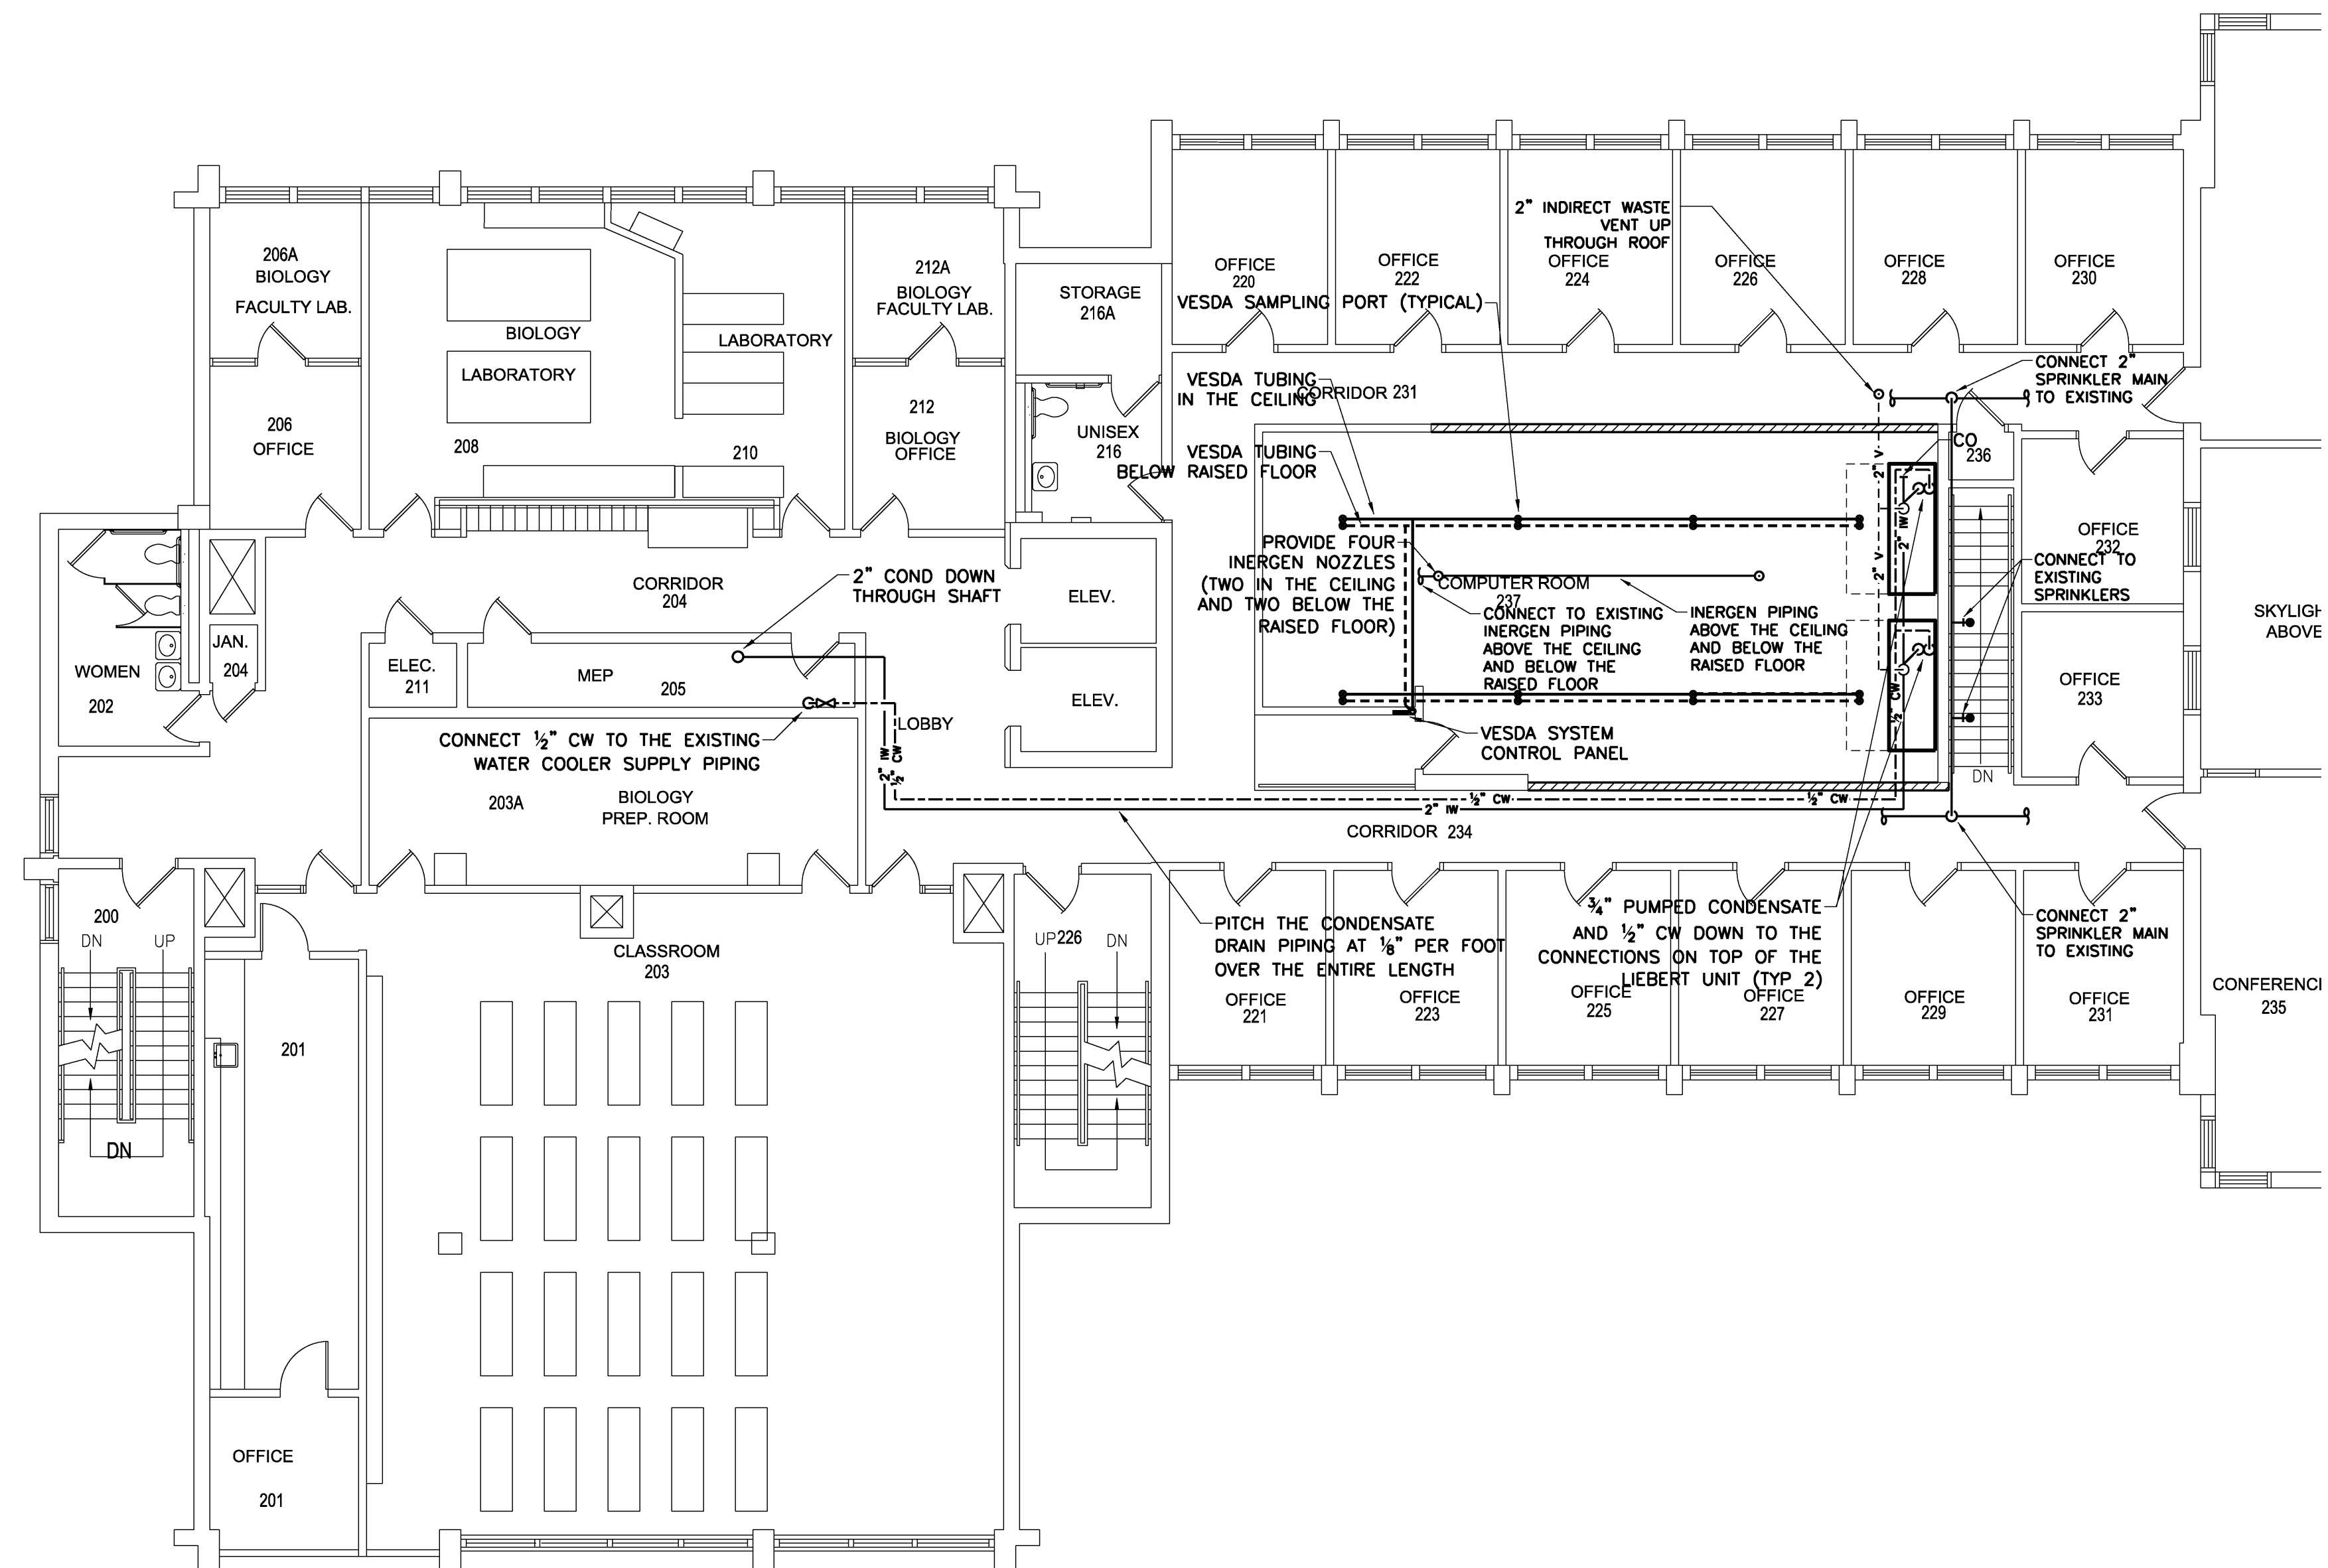

Mark	Date	Description
	05-09-2011	ISSUED FOR BID
	04-05-2011	ISSUED FOR 100% REVIEW
	01-24-2011	ISSUED FOR 75% REVIEW
Issue Dates		

Drawing Status

Drawing Title

**SECOND FLOOR PLAN**

PA / PE: CG      Drawn By: ROM

Drawing Number

**P10.2**