



Project Title
**UNIVERSITY OF SOUTHERN MAINE
SCIENCE BUILDING
GENERATOR
REPLACEMENT**
Portland, Maine

NA Project No. 10633

Key Plan

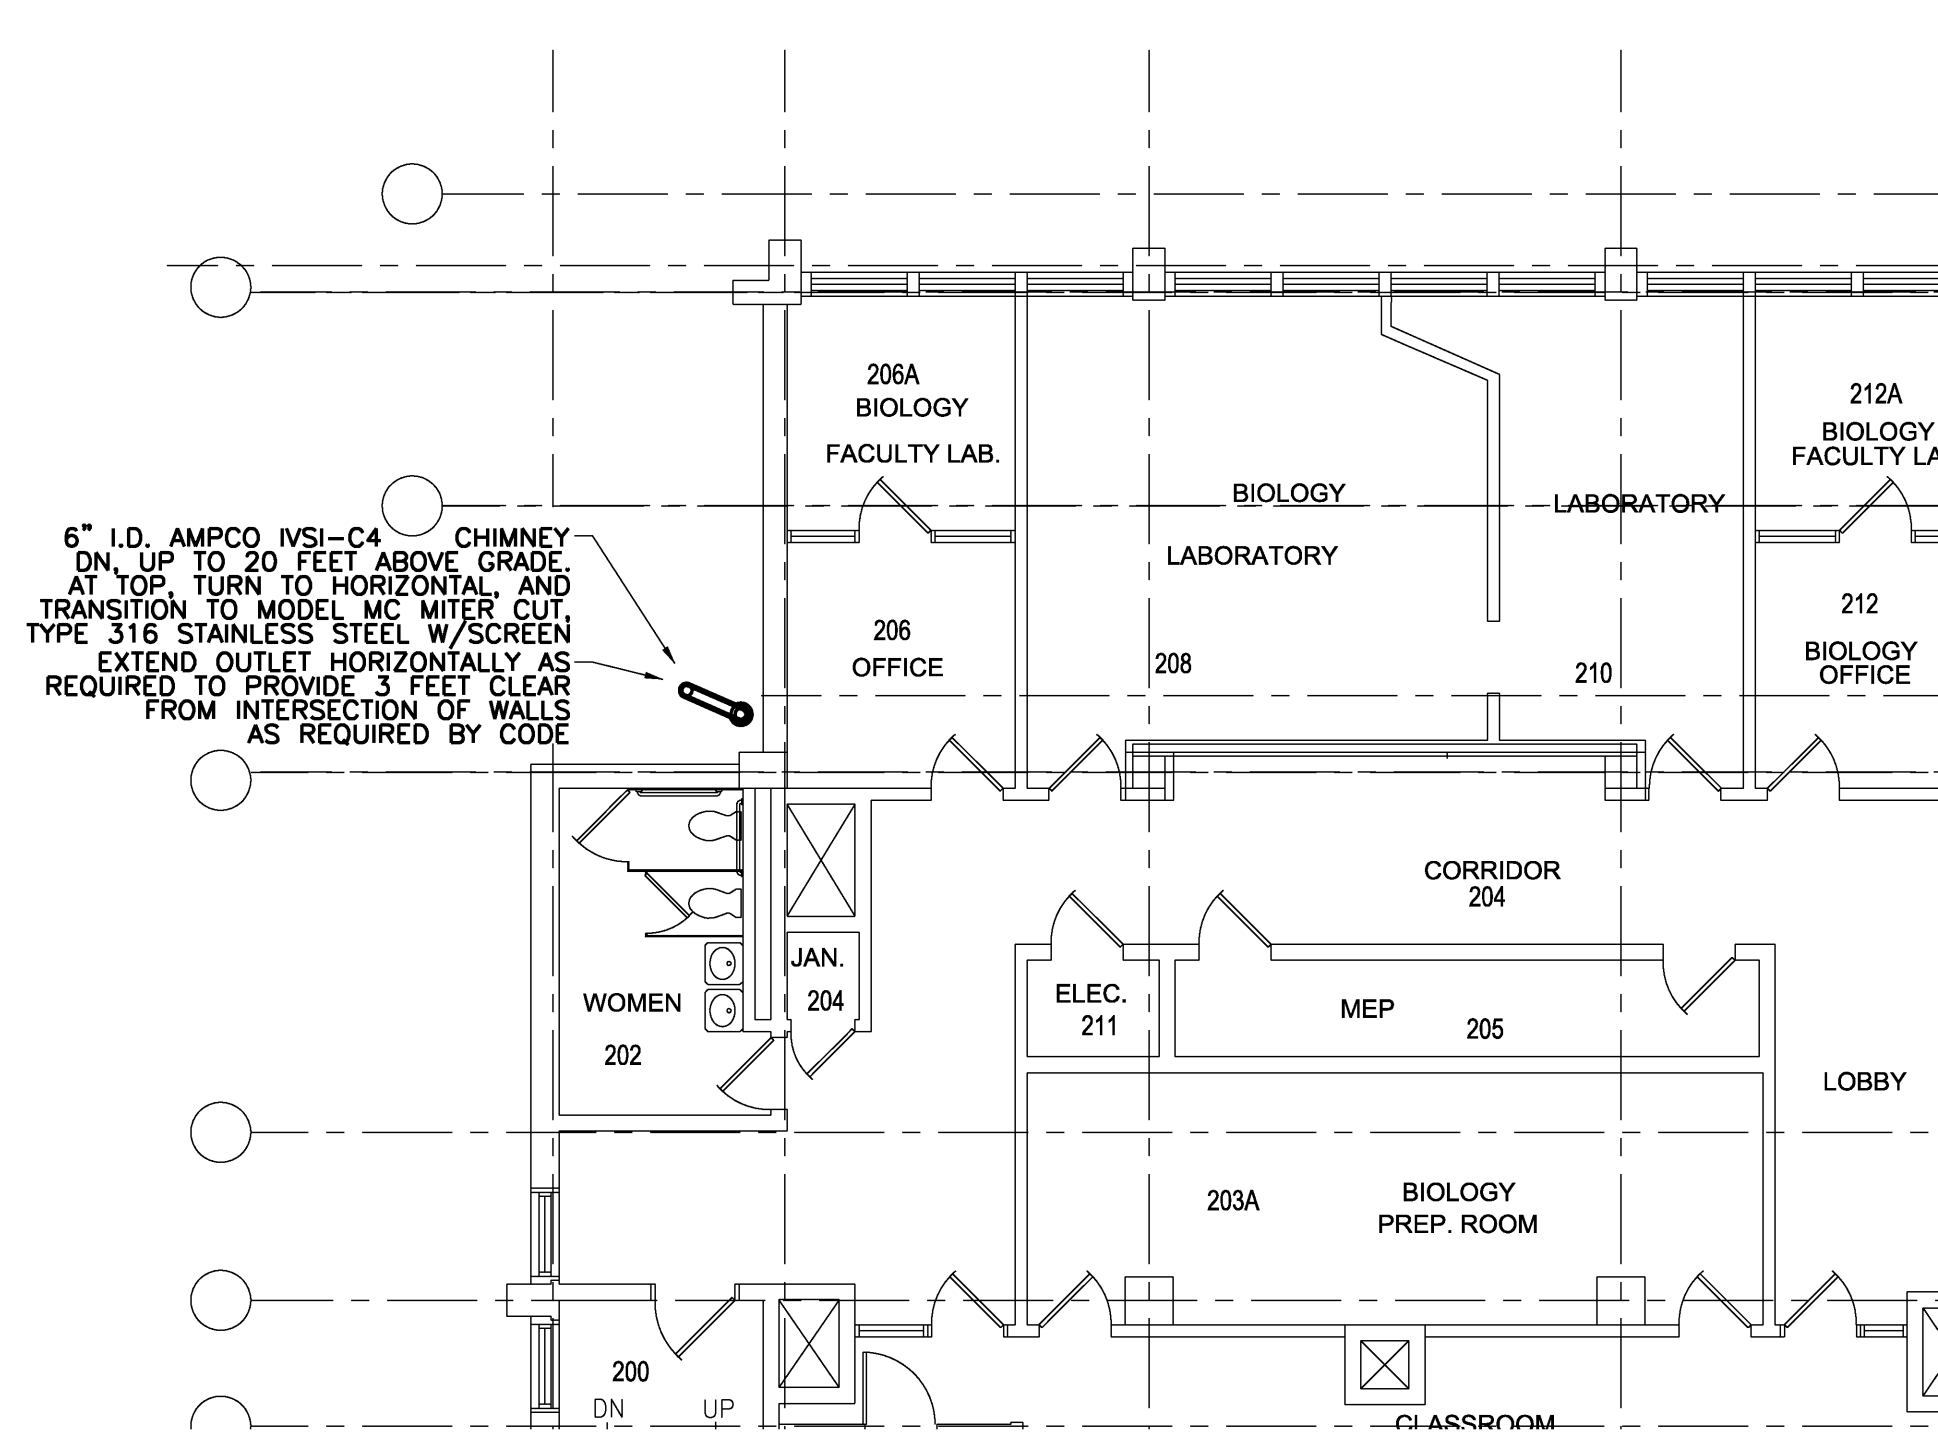


SECOND FLOOR PLAN
1/8" = 1'-0" REF: NA **B2**

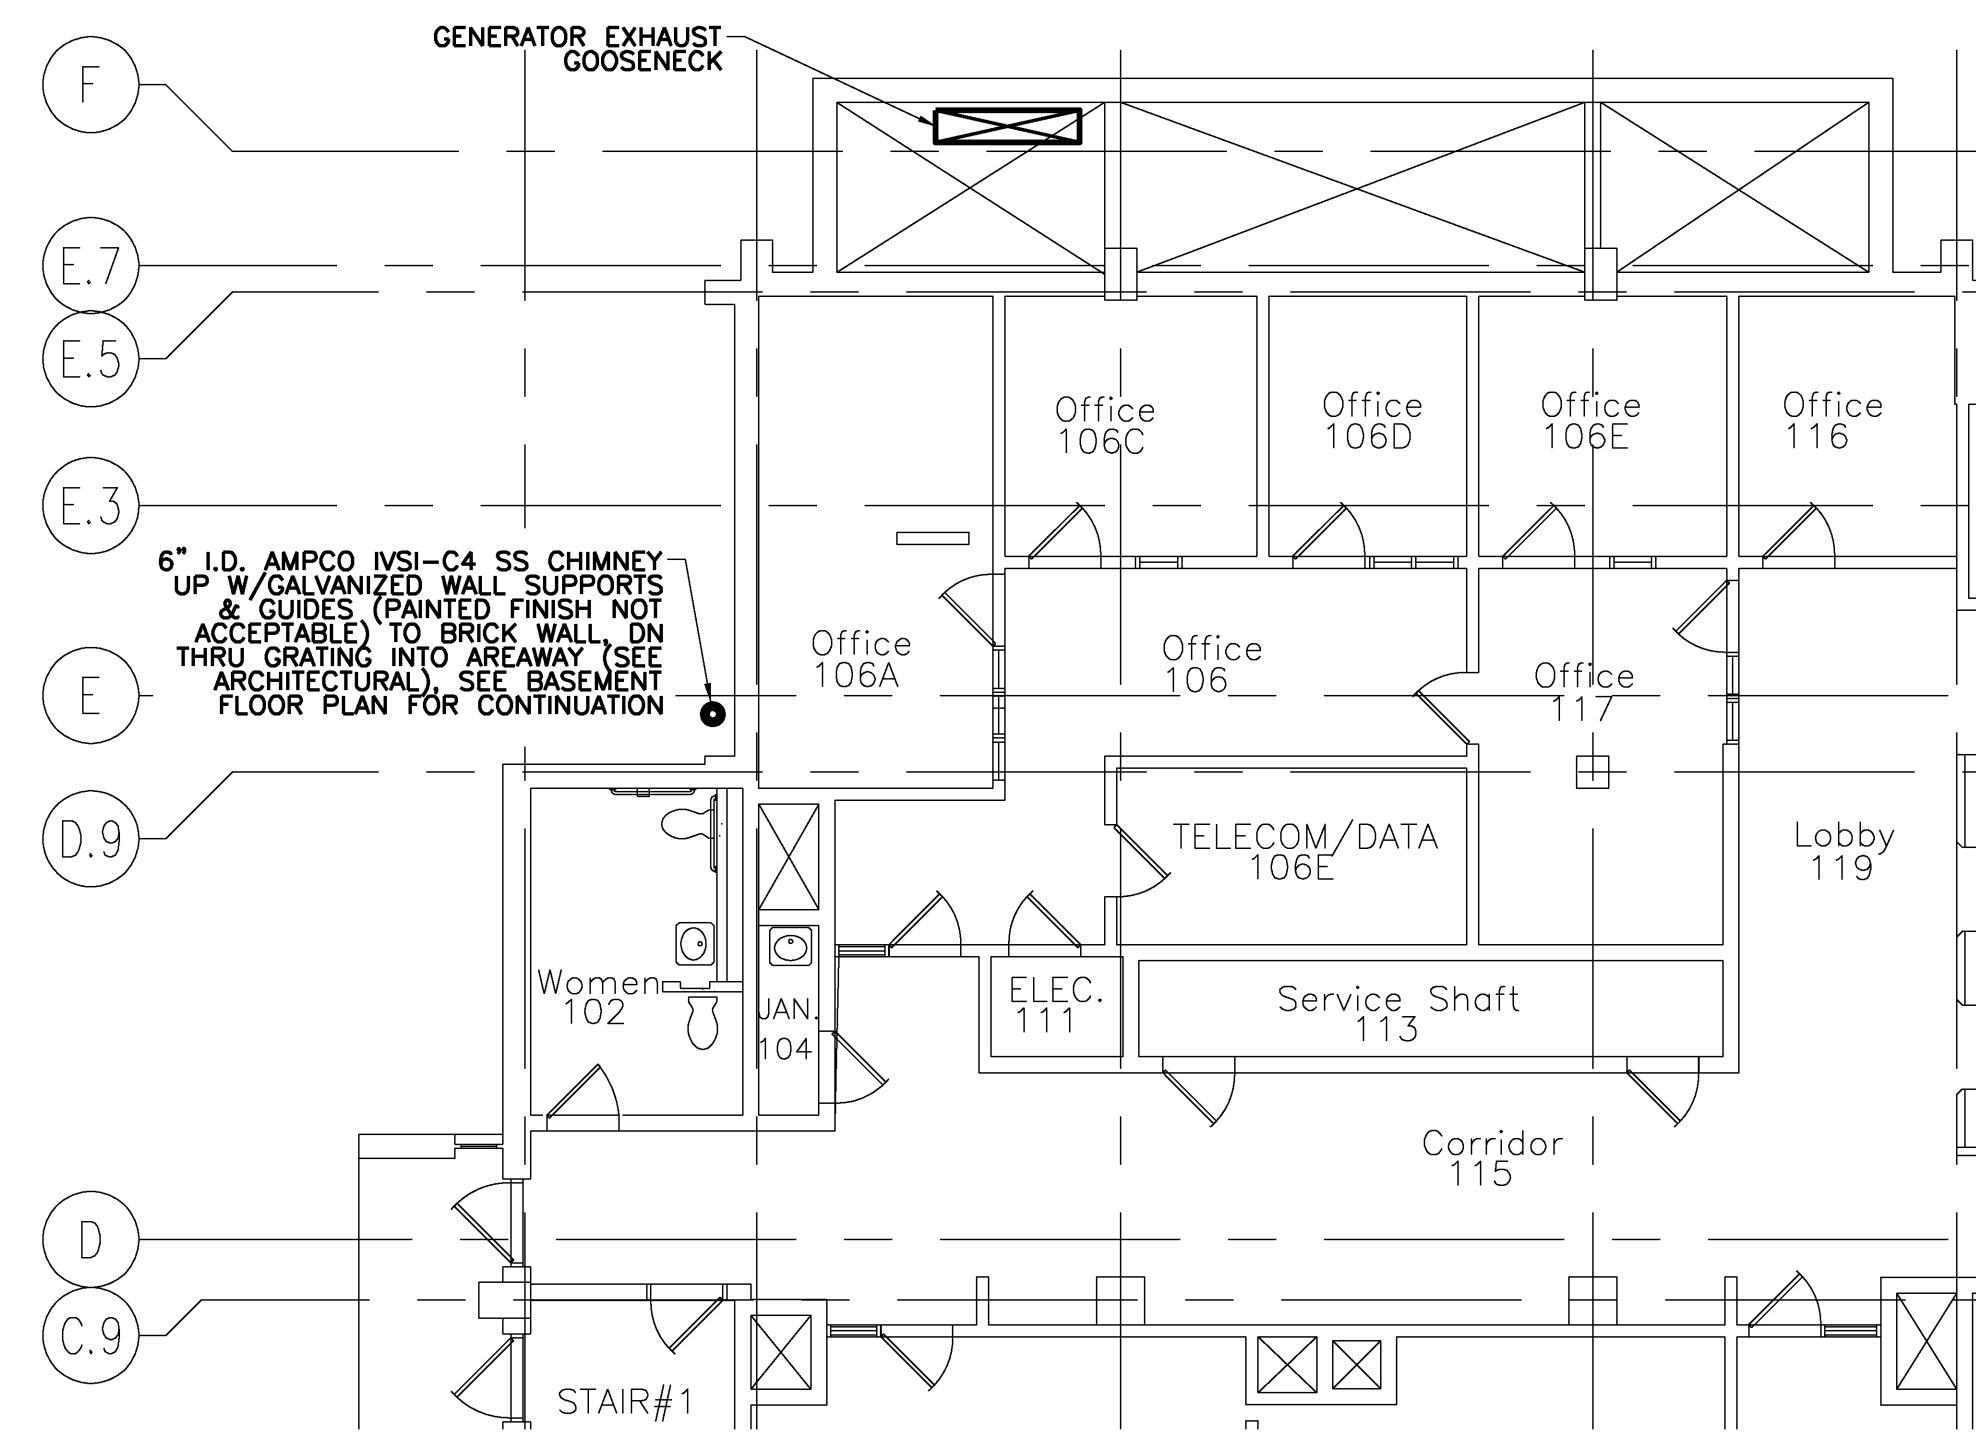


FIRST FLOOR PLAN
1/8" = 1'-0" REF: NA **B1**

NOT USED
1/8" = 1'-0" REF: NA **B3**

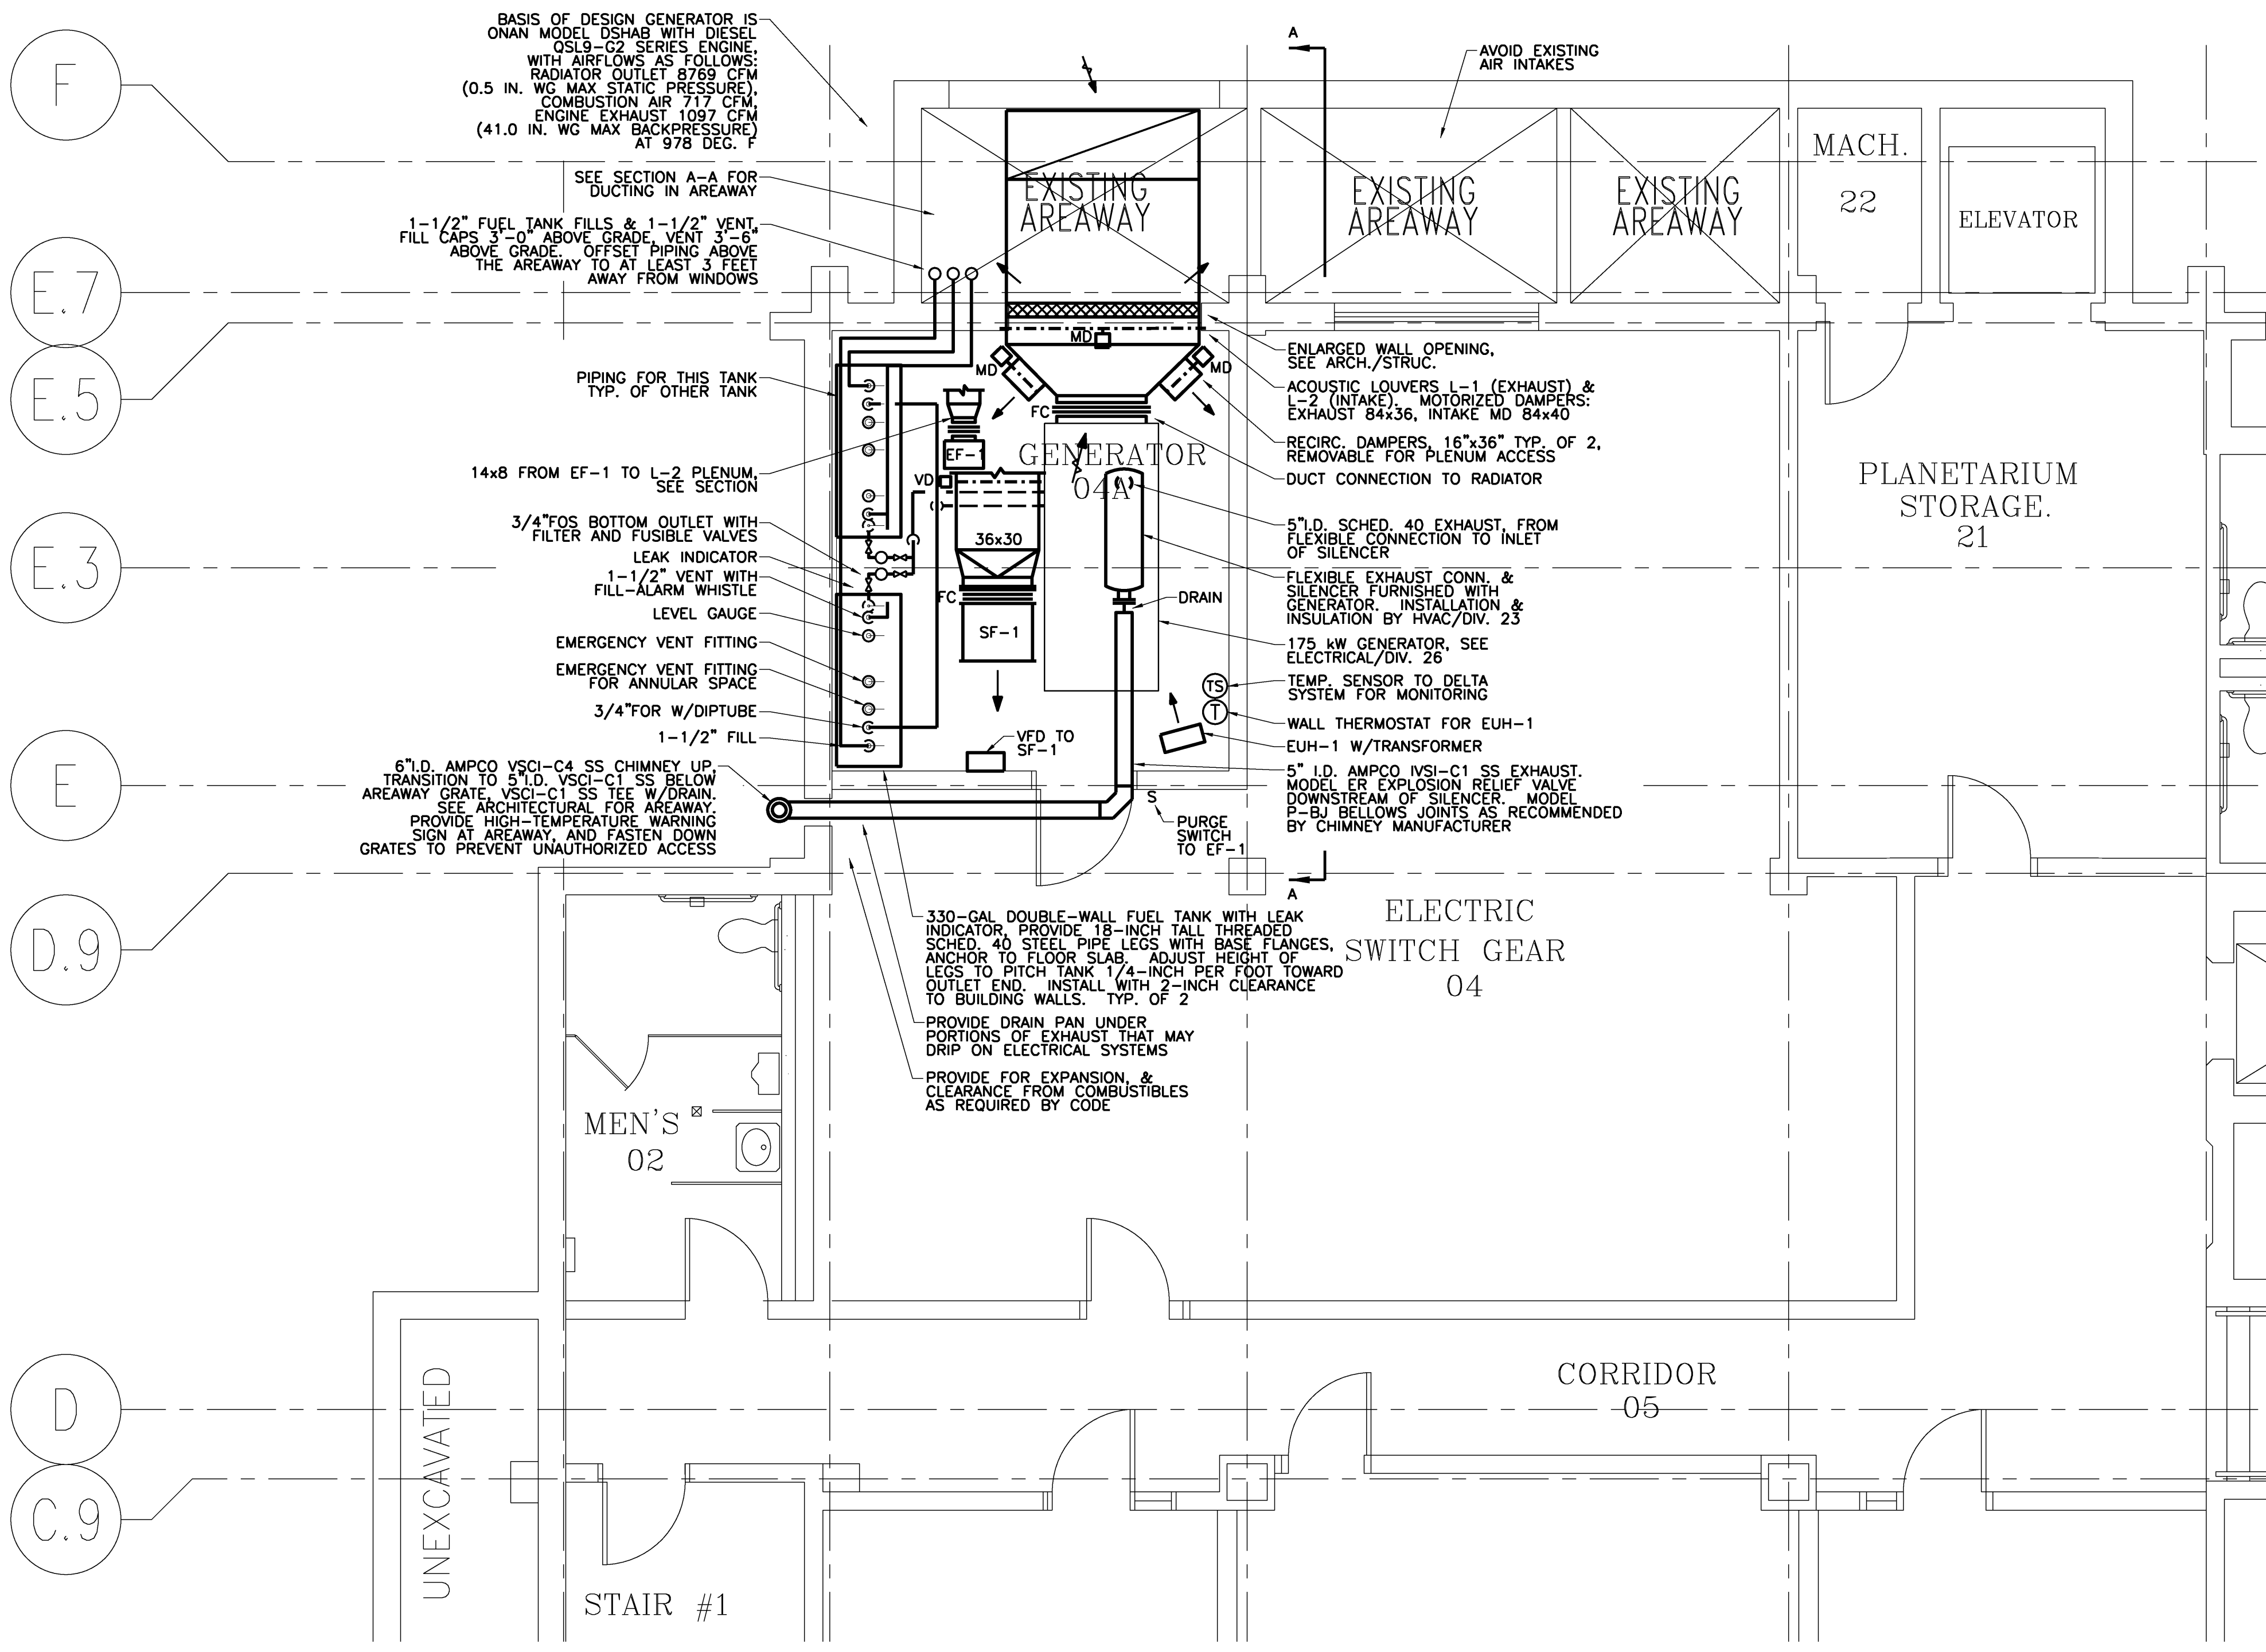

BASEMENT FLOOR PLAN
1/4" = 1'-0" REF: NA **A1**

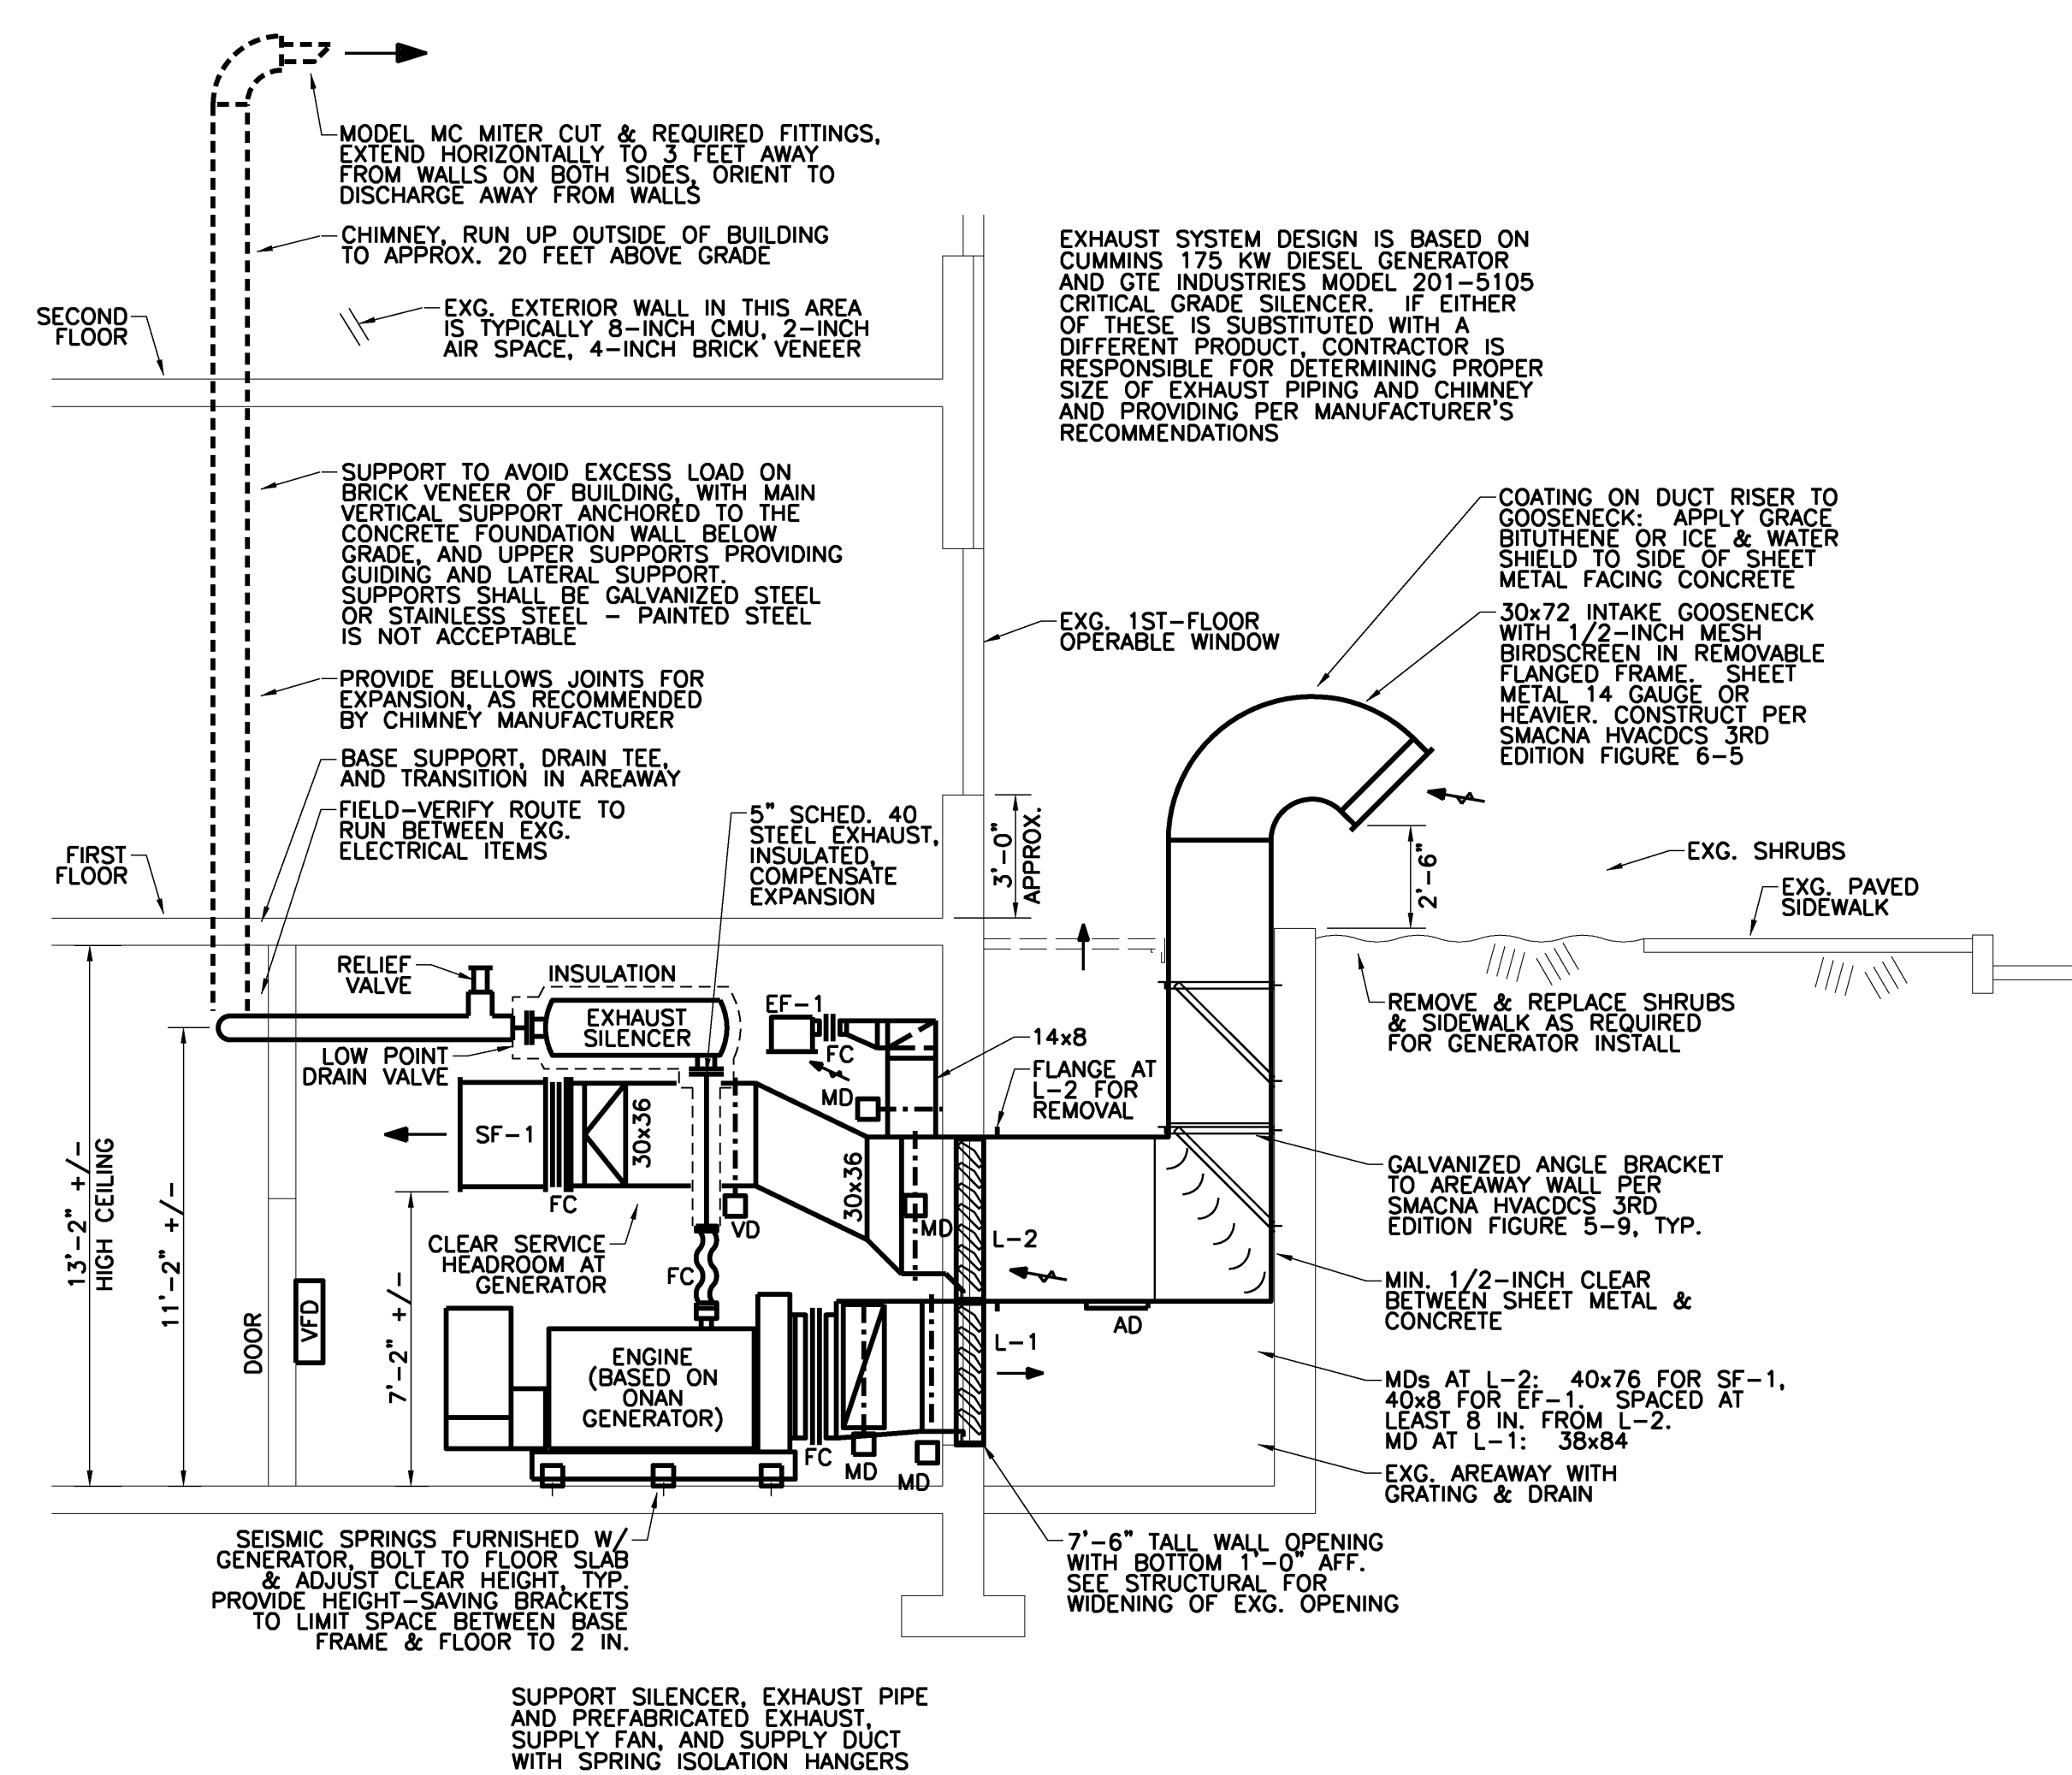

SECTION A-A

SECTION A-A
1/4" = 1'-0" REF: NA **A3**

Mark	Date	Description
05-09-2011		ISSUED FOR BID
04-05-2011		ISSUED FOR 100% REVIEW
01-24-2011		ISSUED FOR 75% REVIEW

Drawing Status

Drawing Title
**PARTIAL FLOOR PLANS
& SECTION**

PA / PE: Drawn By:
Drawing Number

M10.0