




FOURTH FLOOR PARTIAL PLAN — NEW WORK  
 3/32" = 1'-0" REF: NA **A3**

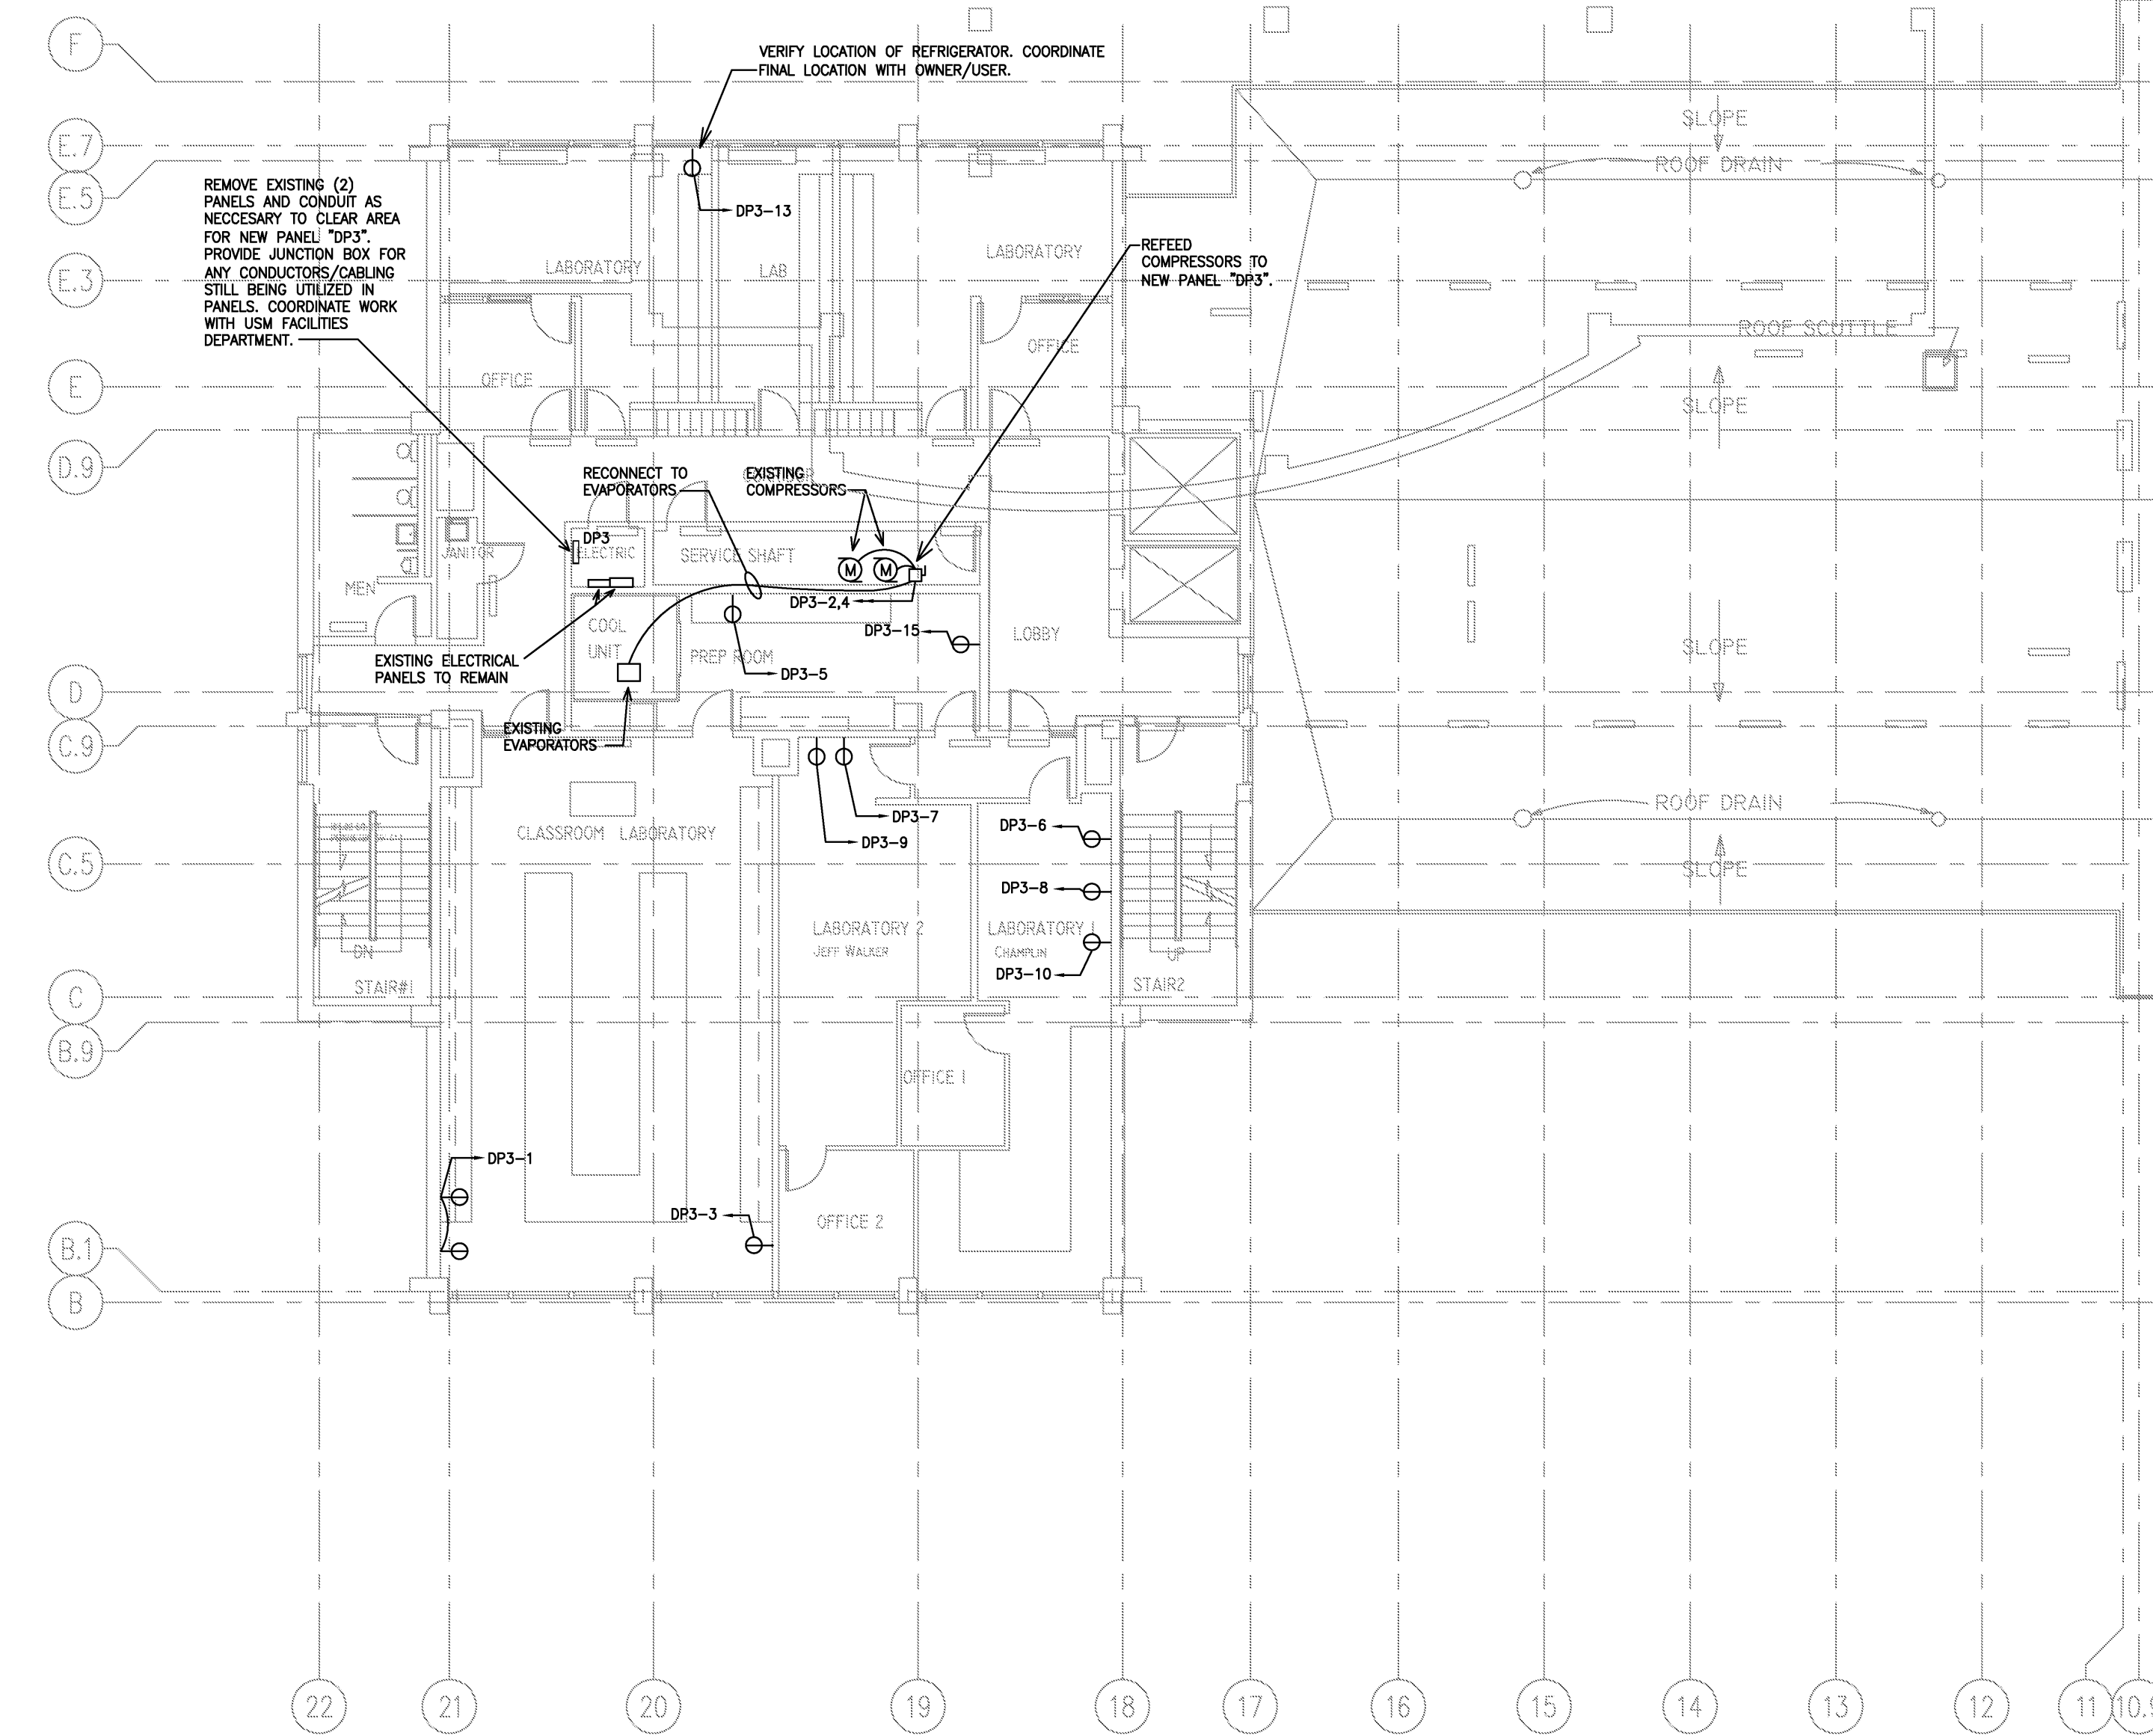

THIRD FLOOR PARTIAL PLAN — NEW WORK  
 3/32" = 1'-0" REF: NA **A2**

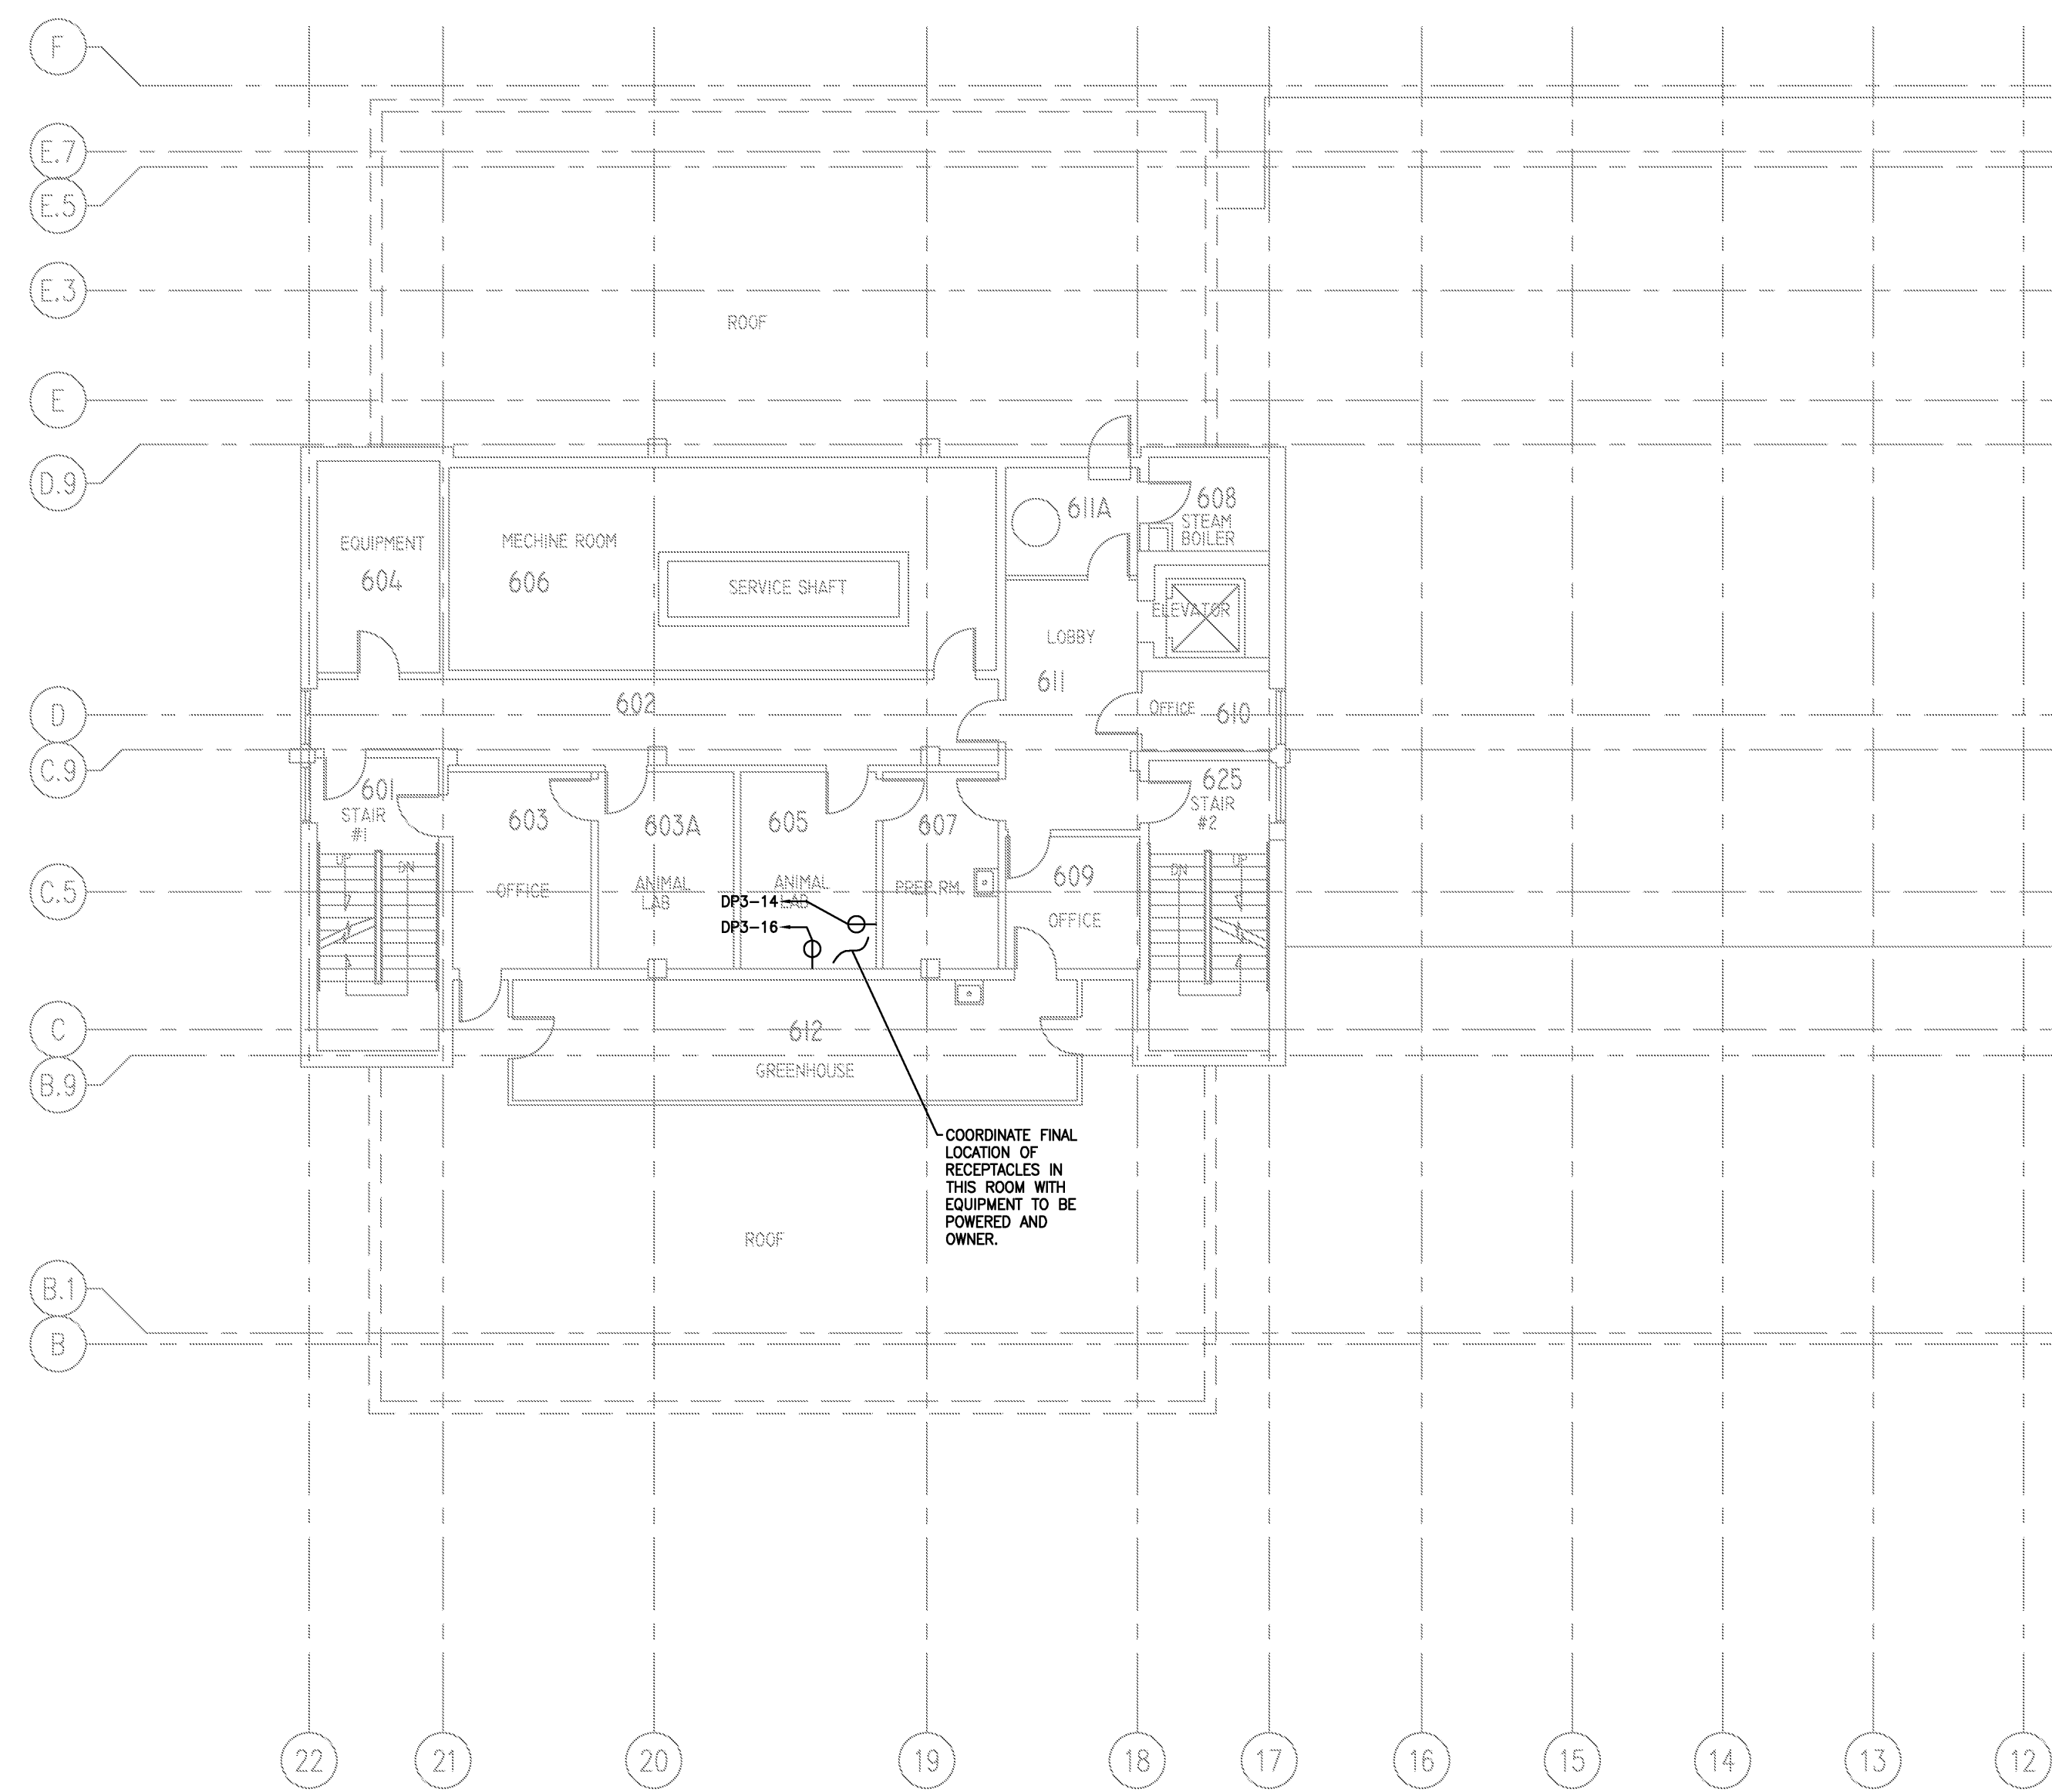

SIXTH FLOOR PARTIAL PLAN — NEW WORK  
 3/32" = 1'-0" REF: NA **A4**

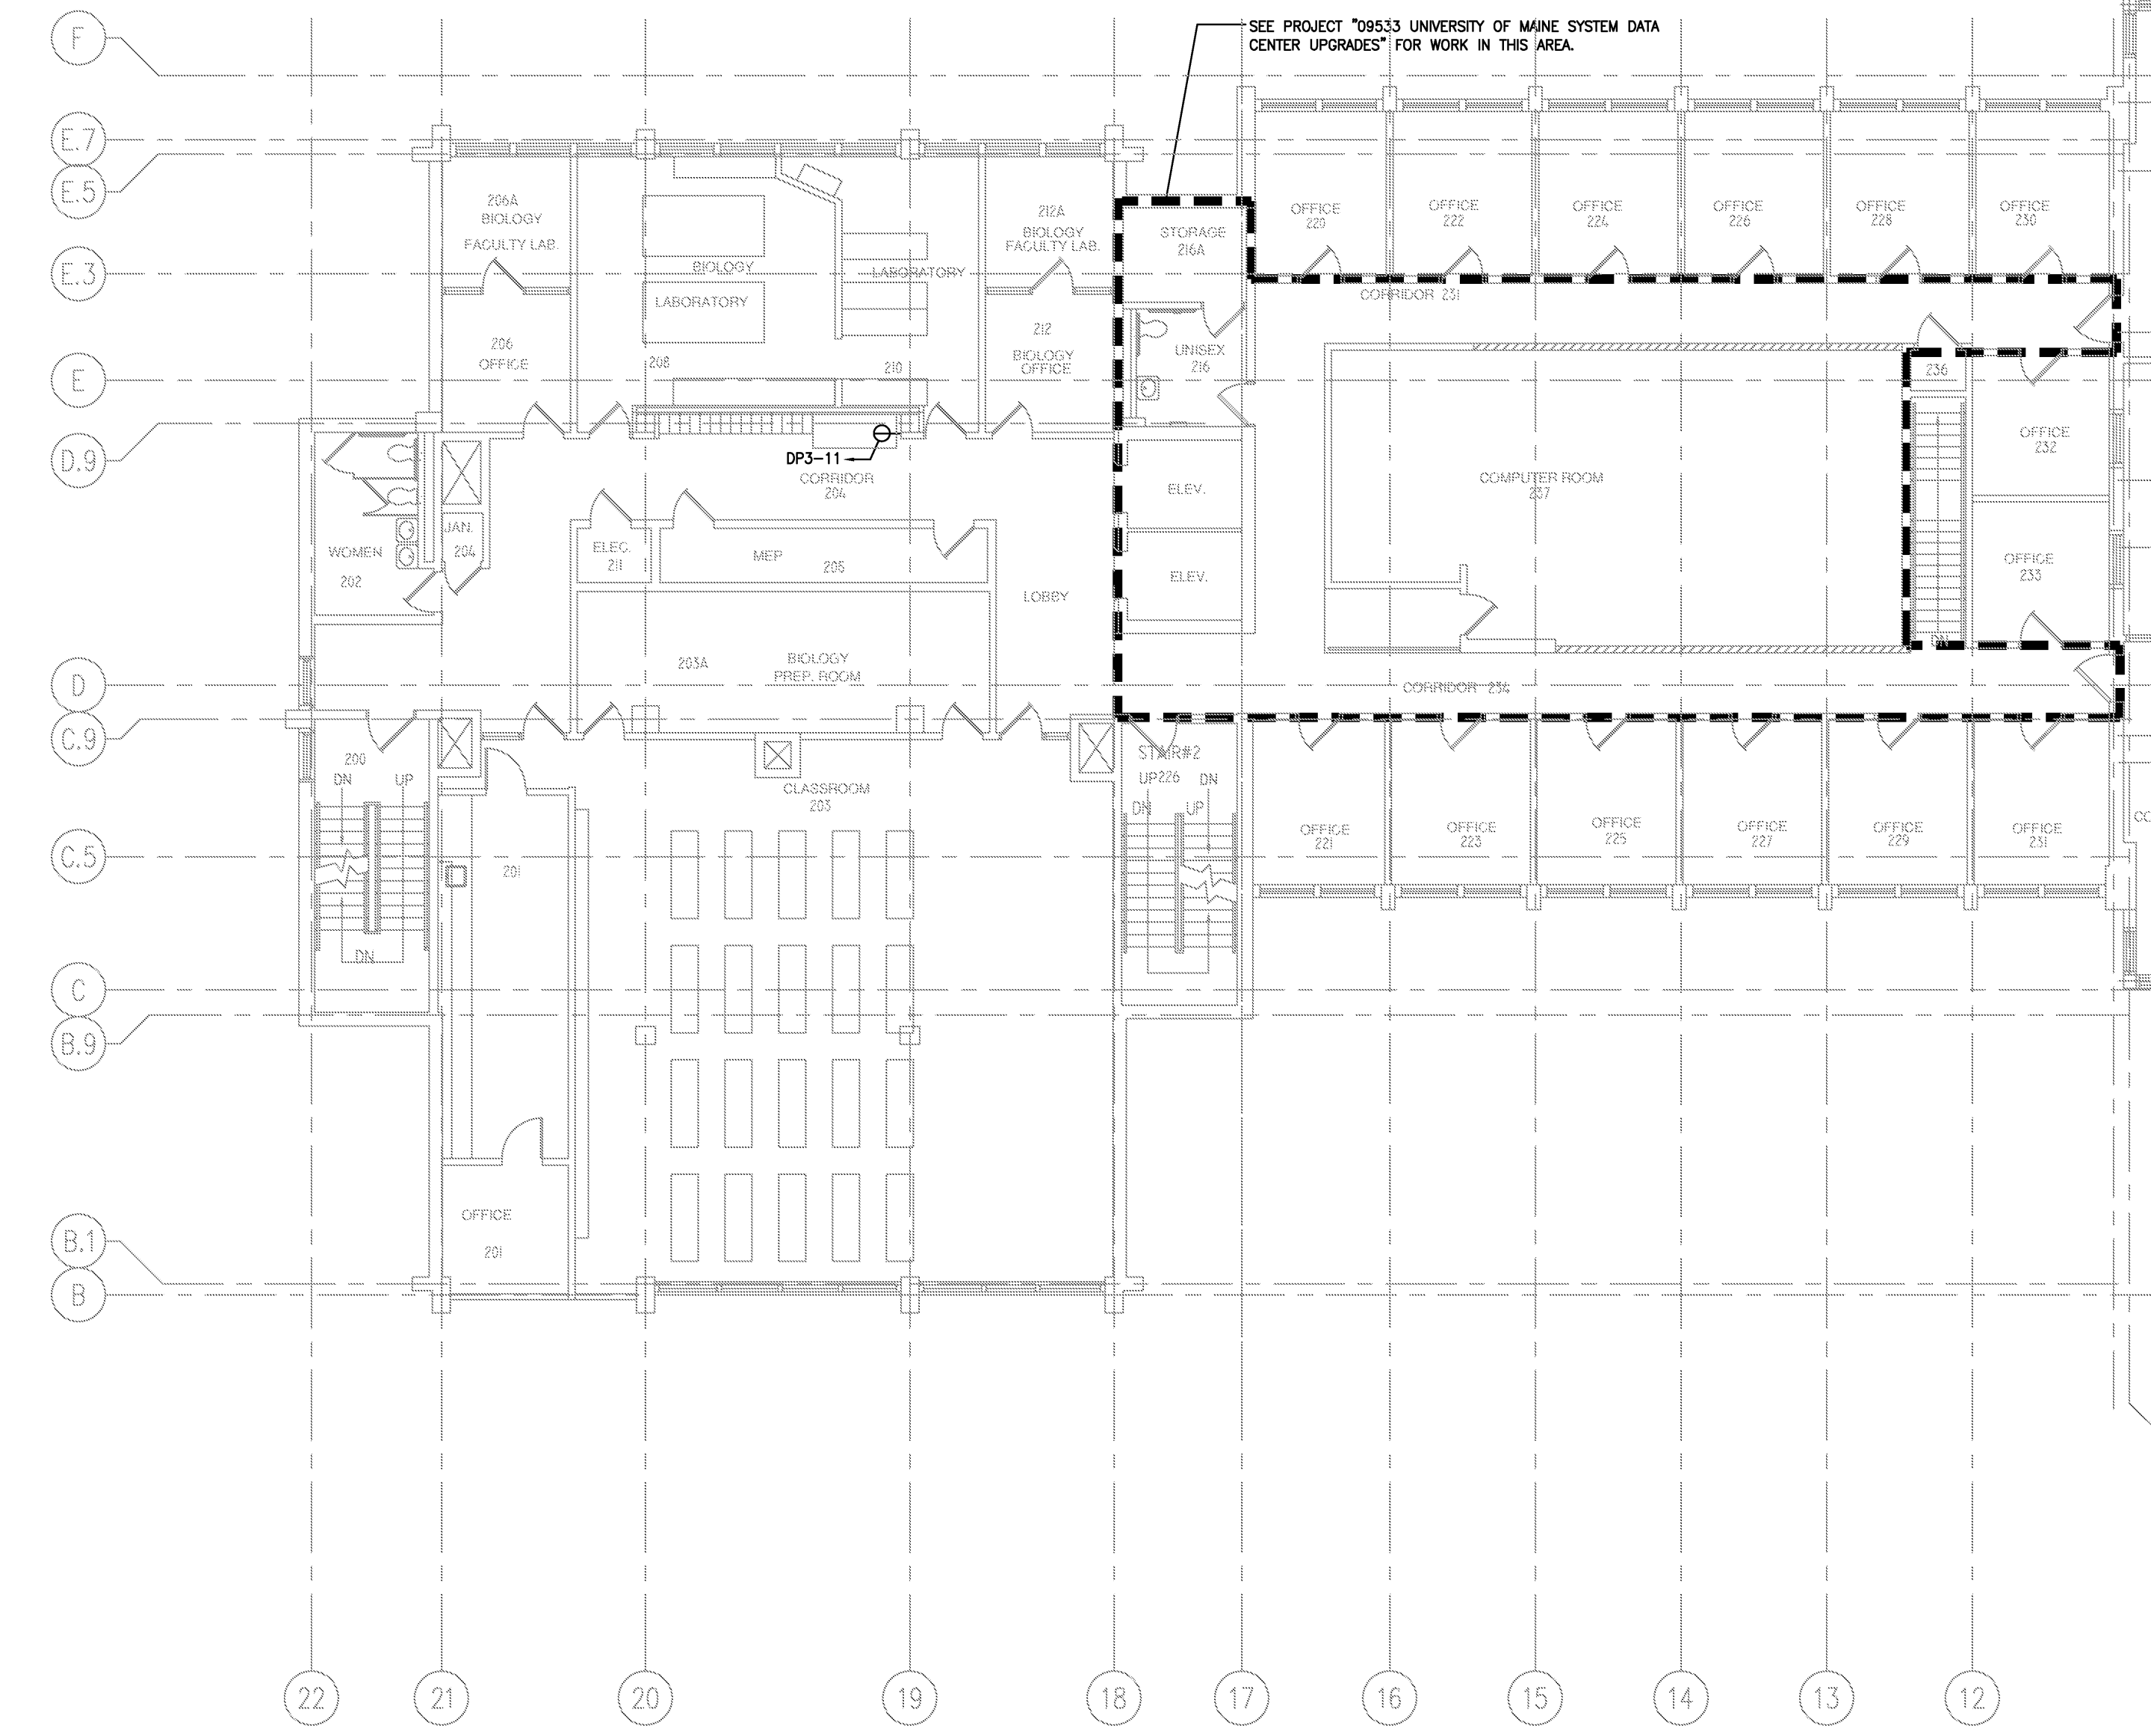


SECOND FLOOR PARTIAL PLAN — NEW WORK  
 3/32" = 1'-0" REF: NA **A1**

**HARRIMAN**  
 Architects + Engineers  
 85 Harriman Drive  
 Portland, ME 04101  
 207-775-0653 ext  
 100 Middle Street  
 Portland, ME 04101  
 207-775-0653 ext  
 One Perimeter Road  
 Manchester, NH 03103  
 603.626.1242 tel  
 www.harriman.com  
 © 2011

Project Title  
**UNIVERSITY OF SOUTHERN MAINE SCIENCE BUILDING GENERATOR REPLACEMENT**  
 Portland, Maine

HA Project No. **10633**

 Key Plan



Mark	Date	Description
05-09-2011		ISSUED FOR BID
04-06-2011		ISSUED FOR 100% REVIEW
01-24-2011		ISSUED FOR 75% REVIEW
Issue Dates		

Drawing Status

Drawing Title  
**ELECTRICAL NEW WORK MULTIPLE PARTIAL FLOOR PLANS**  
 PA / PE, PRM Drawn By: RJB  
 Drawing Number

**E20.1**