
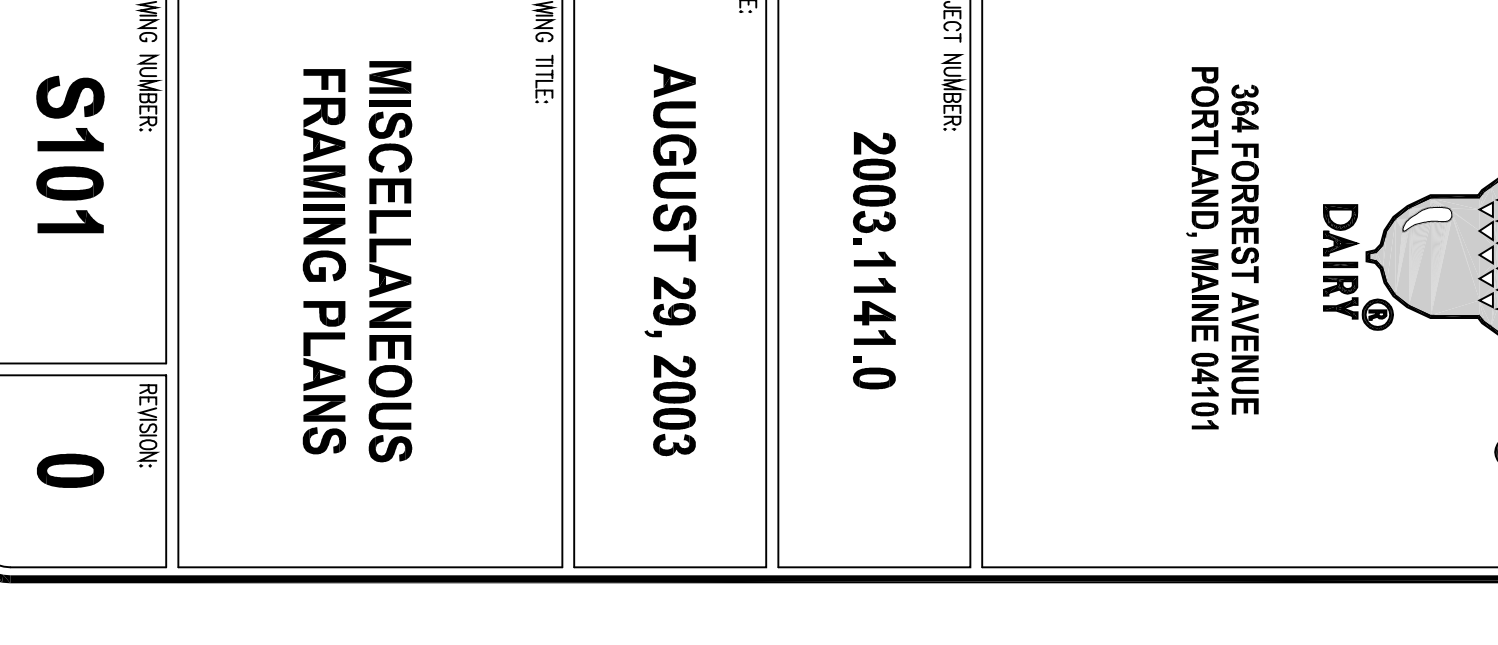
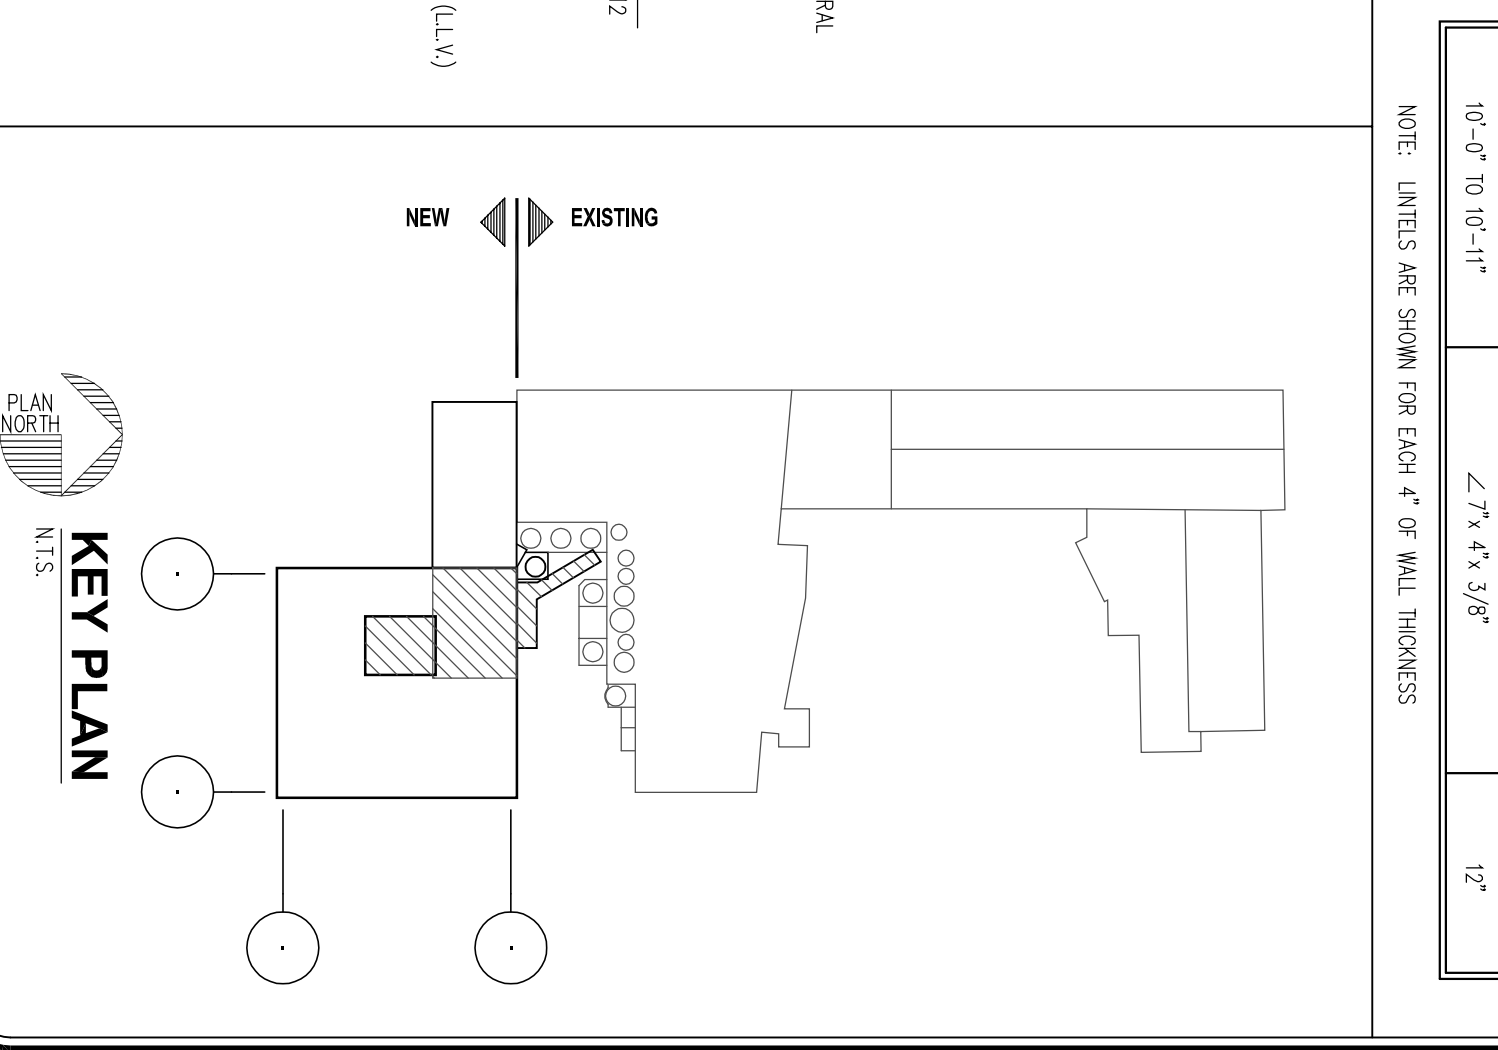
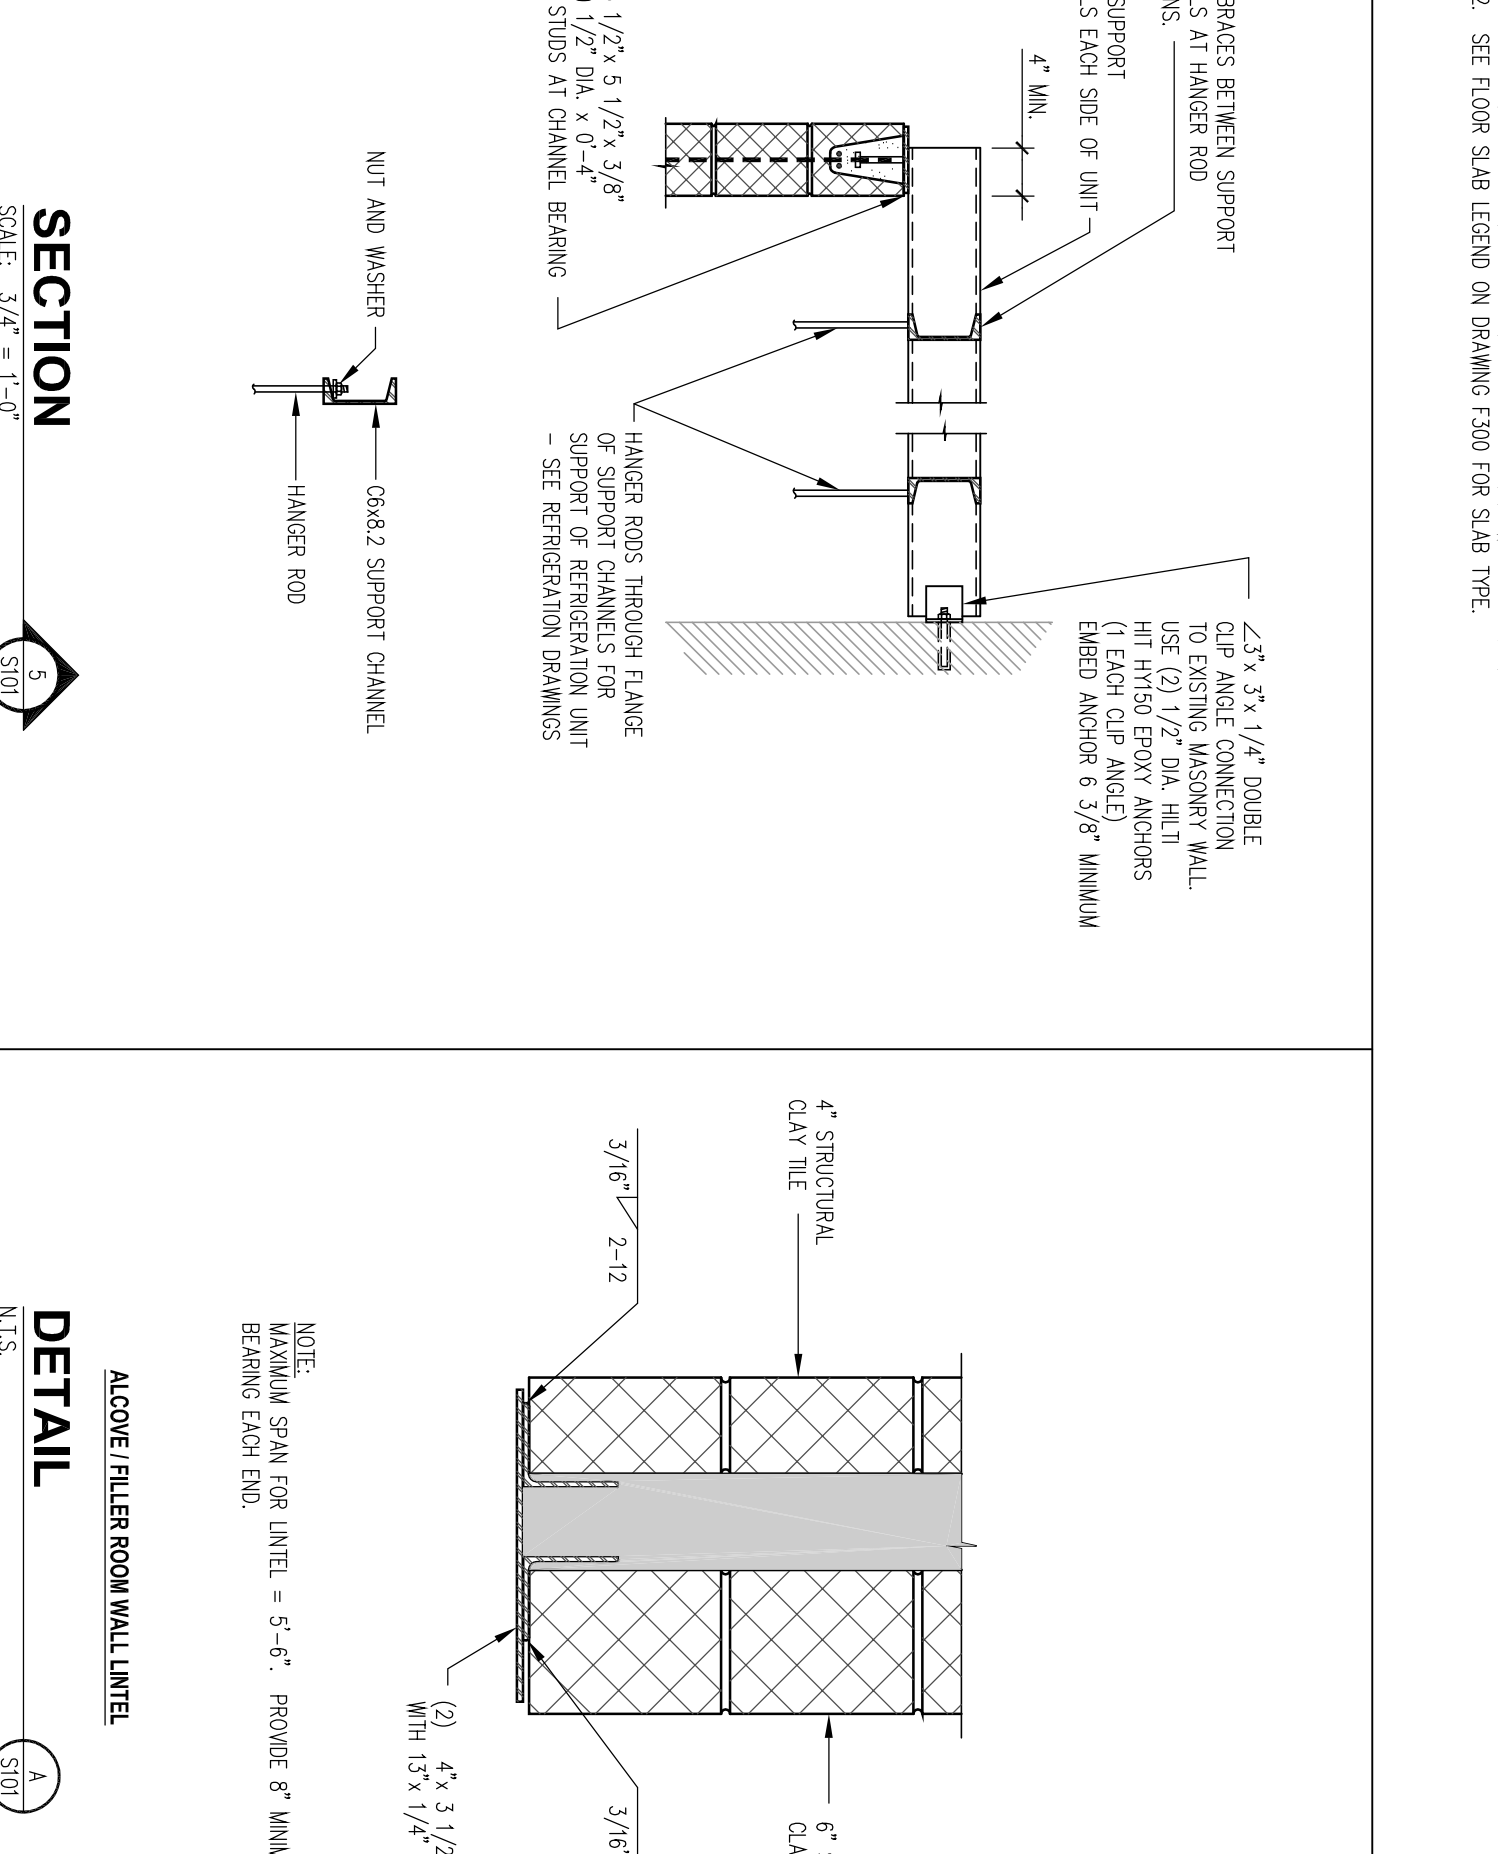
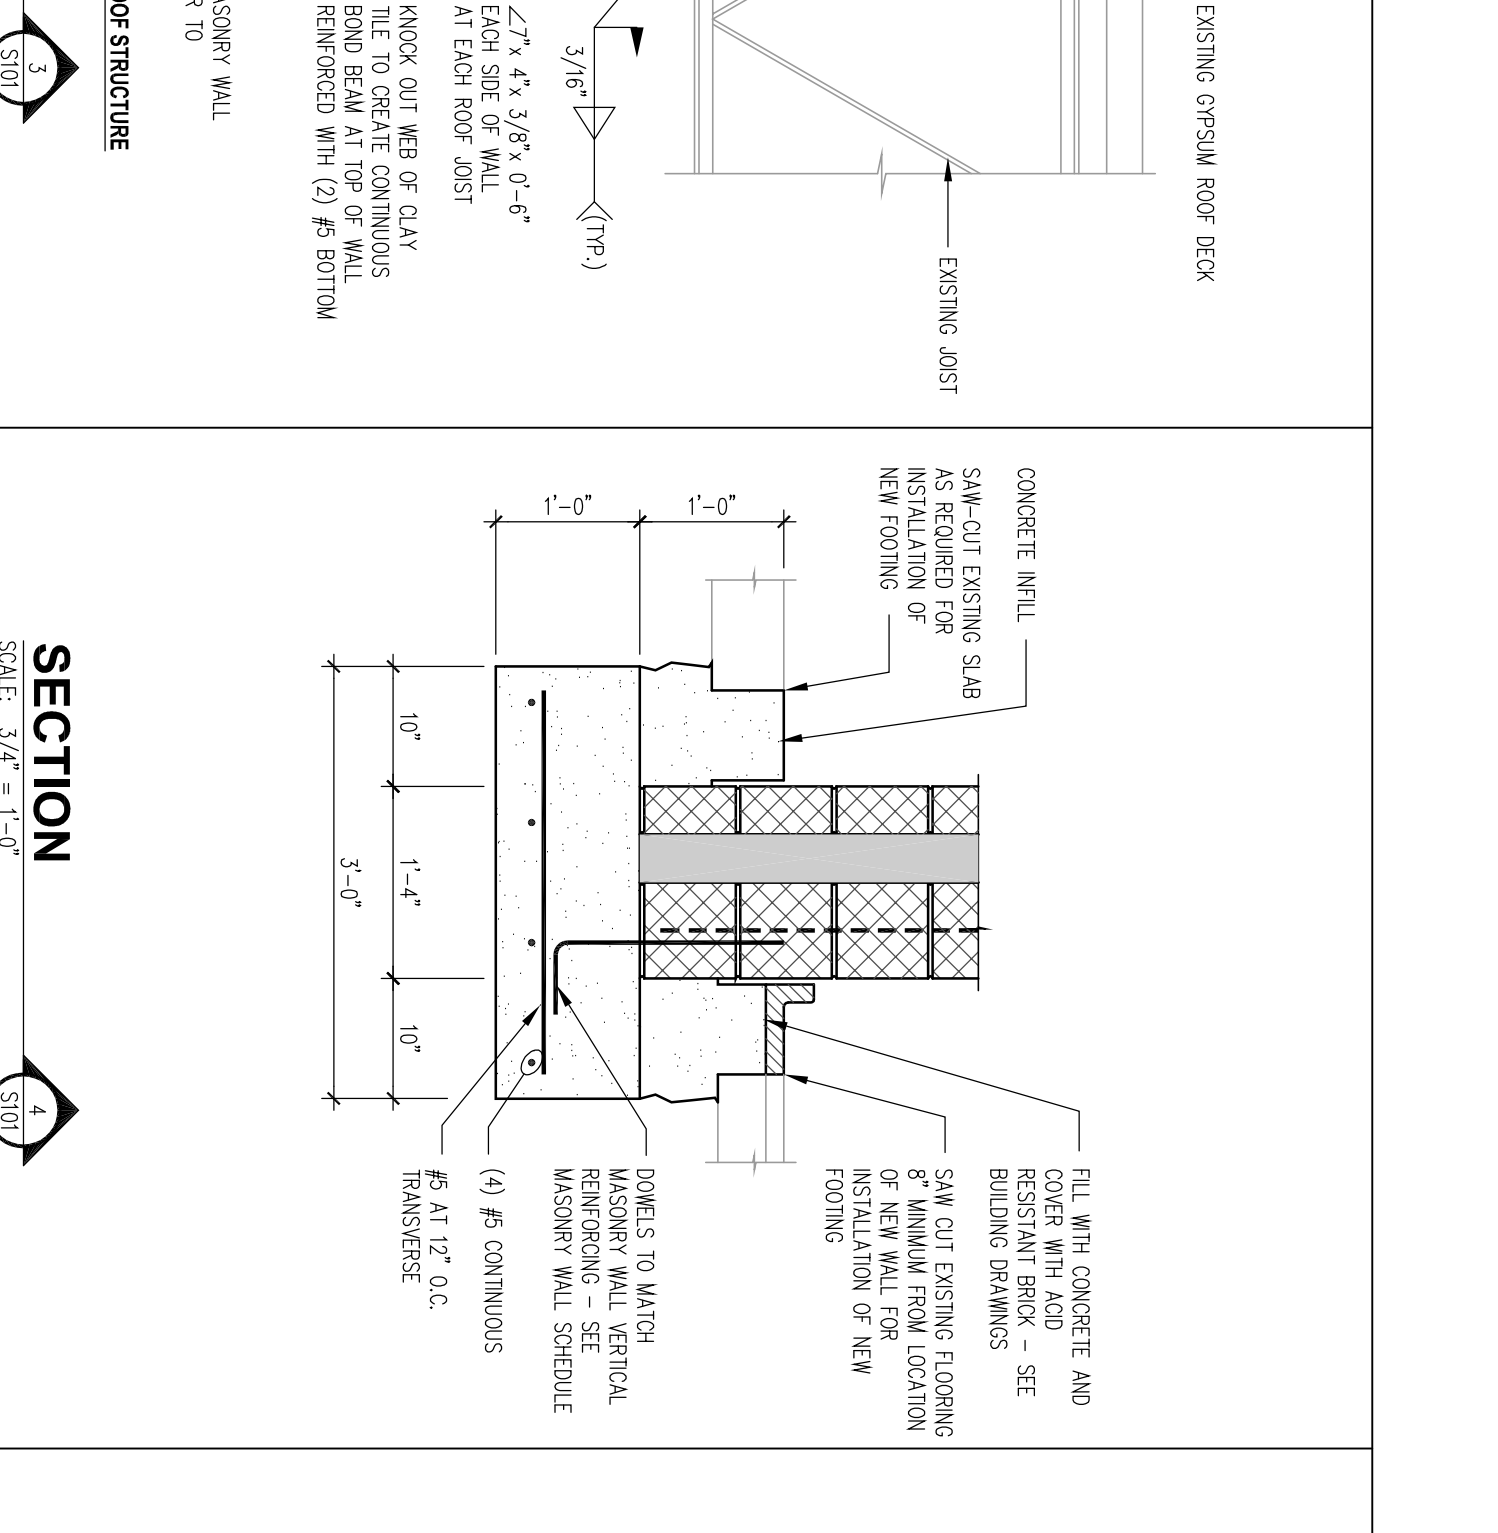


MARK	COLUMN SIZE
C-1	15 0" x 15 0"
C-2	15 0" x 10 1/2"
C-3	15 0" x 10 1/2"
C-4	15 0" x 9 3/8"
C-5	15 0" x 9 3/8"
C-6	15 0" x 9 3/8"
C-7	15 7 1/2" x 14 1/2"
C-8	15 10 1/2" x 12"

MARK	WALL (MINIMUM WIDTH)	VERTICAL REINFORCING
RECEIVING BAY EXTERIOR WALLS (17)	#5 AT 48" O.C. EACH FACE	
RECEIVING BAY INTERIOR WALLS (2) AND (3)	#4 AT 48" O.C. (CENTER)	
ALCOVE/FILTER ROOM INTERIOR WALL (5)	#4 AT 48" O.C. (CENTER)	
CALL FACE/ALCOVE AT EXISTING HIGH RISE (6)	#4 AT 24" O.C. (CENTER)	

MARK	WALKWAY OPENING	STRUCTURAL STEEL MEMBER	MINIMUM DEPTH
1P	8'-0" to 8'-11"	2 L 3 1/2" x 3 1/2" x 1/4"	8"
7	10'-0" to 8'-11"	4 L 3 1/2" x 1/4"	8"
8	0'-0" to 8'-11"	4 L 3 1/2" x 1/4"	8"
9	10'-0" to 8'-11"	4 L 3 1/2" x 1/4"	8"
10	10'-0" to 8'-11"	4 L 3 1/2" x 1/4"	12"

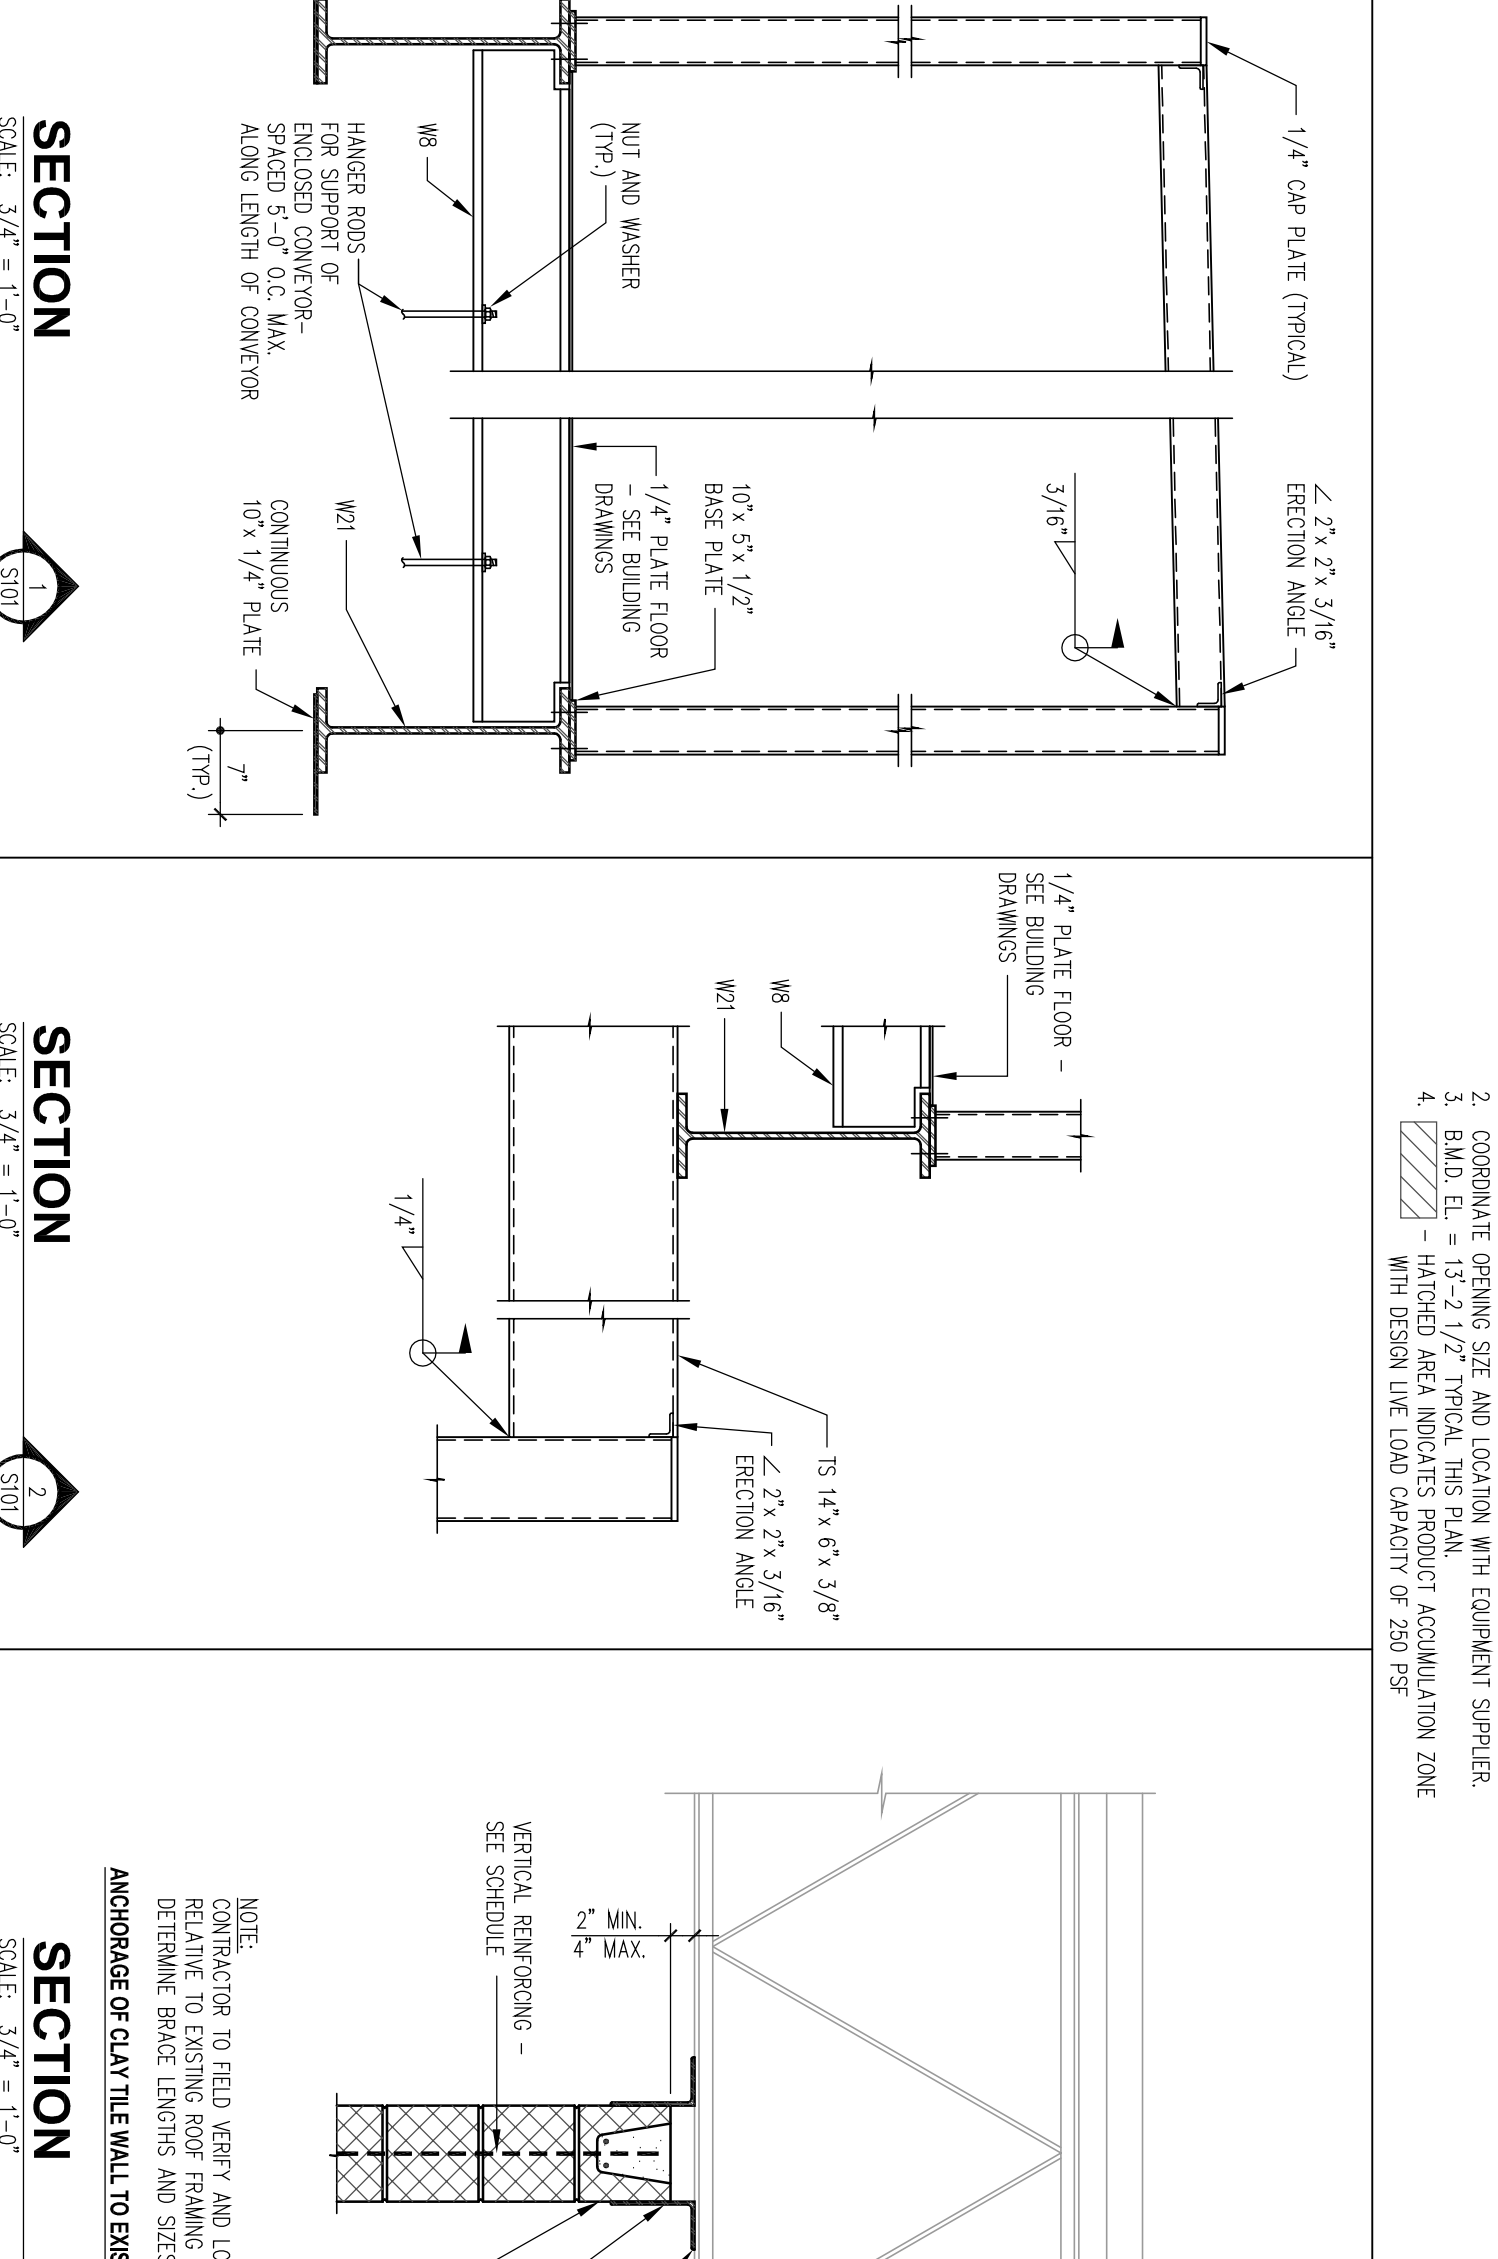

MARK	REVISIONS
0	ISSUED FOR BIDDING

DESIGNED BY:	K.A.S.
DRAWN BY:	G.L.B.
CHECKED BY:	R.C.C.
PROJECT MANAGER:	
DATE:	AUGUST 29, 2003
PROJECT NUMBER:	2003.1141.0
DRAWING TITLE:	MISCELLANEOUS FRAMING PLANS
DRAWING NUMBER:	S101
REVISION:	0

FACILITIES DESIGN, INC.
3904 Ashd Drive
Columbia, Pennsylvania 17512
Phone: (717) 285-9442
Fax: (717) 285-3102
Email: info@facilitiesdesign.com
Web: www.facilitiesdesign.com
CA NUMBER: 2003018

Engineering Design Services
Architectural Engineering
Building Structural
Foundation
Plumbing
Mechanical
Electrical
HVAC
Fire Protection
Life Safety
Thermal Radiation
Process Simulation
Project Management
Project Planning
Facility Siting
Master Planning
Process Systems

Oakhurst DAIRY
NEW MILK COOLER
384 FOREST AVENUE
PORTLAND, MAINE 04101