


FIRST FLOOR LIGHTING PLAN  
SCALE: 1/8" = 1'-0"

TITLE	CHARACTERISTICS	VOLTS	WATTAGE	CA	LAMP	ACCESSORIES/NOTES
A	Acrylic High Bay, Luminaire	277V	110	110	110MH/00C	
B	2' x 4' Surface Mounted Fluor. Parabolic Troffer	277V	277	277	277	
C	4' x 8' Fluorescent General Purpose Parabolic Troffer	277V	277	277	277	
D	4' x 8' Fluorescent General Purpose Parabolic Troffer	277V	277	277	277	
E	Decorative Wall Pack, MH	277V	277	277	277	Provide with Gasketed Gasket
F	Decorative Wall Pack, MH	277V	277	277	277	Provide with Gasketed Gasket
G	Decorative Wall Pack, MH	277V	277	277	277	Provide with Gasketed Gasket
H	DELTA	277V	277	277	277	
I	DELTA	277V	277	277	277	
J	DELTA	277V	277	277	277	
K	DELTA	277V	277	277	277	
L	DELTA	277V	277	277	277	
M	DELTA	277V	277	277	277	
N	DELTA	277V	277	277	277	
O	DELTA	277V	277	277	277	
P	DELTA	277V	277	277	277	
Q	DELTA	277V	277	277	277	
R	DELTA	277V	277	277	277	
S	DELTA	277V	277	277	277	
T	DELTA	277V	277	277	277	
U	DELTA	277V	277	277	277	
V	DELTA	277V	277	277	277	
W	DELTA	277V	277	277	277	
X	DELTA	277V	277	277	277	
Y	DELTA	277V	277	277	277	
Z	DELTA	277V	277	277	277	

**PLAN KEY NOTES**

1. MOUNT EMERGENCY LIGHTING FIXTURE 7'-0" AFF.
2. CONNECT NIGHT LIGHTS TO PANELBOARD UP/NIGHTLIGHT CIRCUIT.
3. POWER EXIT SIGNS AND BATTERY PACKS FROM CIRCUIT IN PANELBOARD UP.
4. POWER DOOR LIGHTS FROM CONDUIT RECEIPTALS SHOWN ON DRAWING EAO.
5. PROVIDE PHOTOELECTRIC RELAY TO CONTROL DOOR CHAMFER LIGHTS MOUNT ABOVE THE DOOR CHAMFER/FRAMING MOUNT.
6. REFER TO DRAWING "EAO" FOR REINFORCED LIGHTING PLANS.
7. MOUNT EMERGENCY LIGHTING FIXTURE 6'-0" AFF.
8. MOUNT EMERGENCY LIGHTING FIXTURE 6'-0" AFF.
9. MOUNT EMERGENCY LIGHTING FIXTURE 10'-0" AFF.

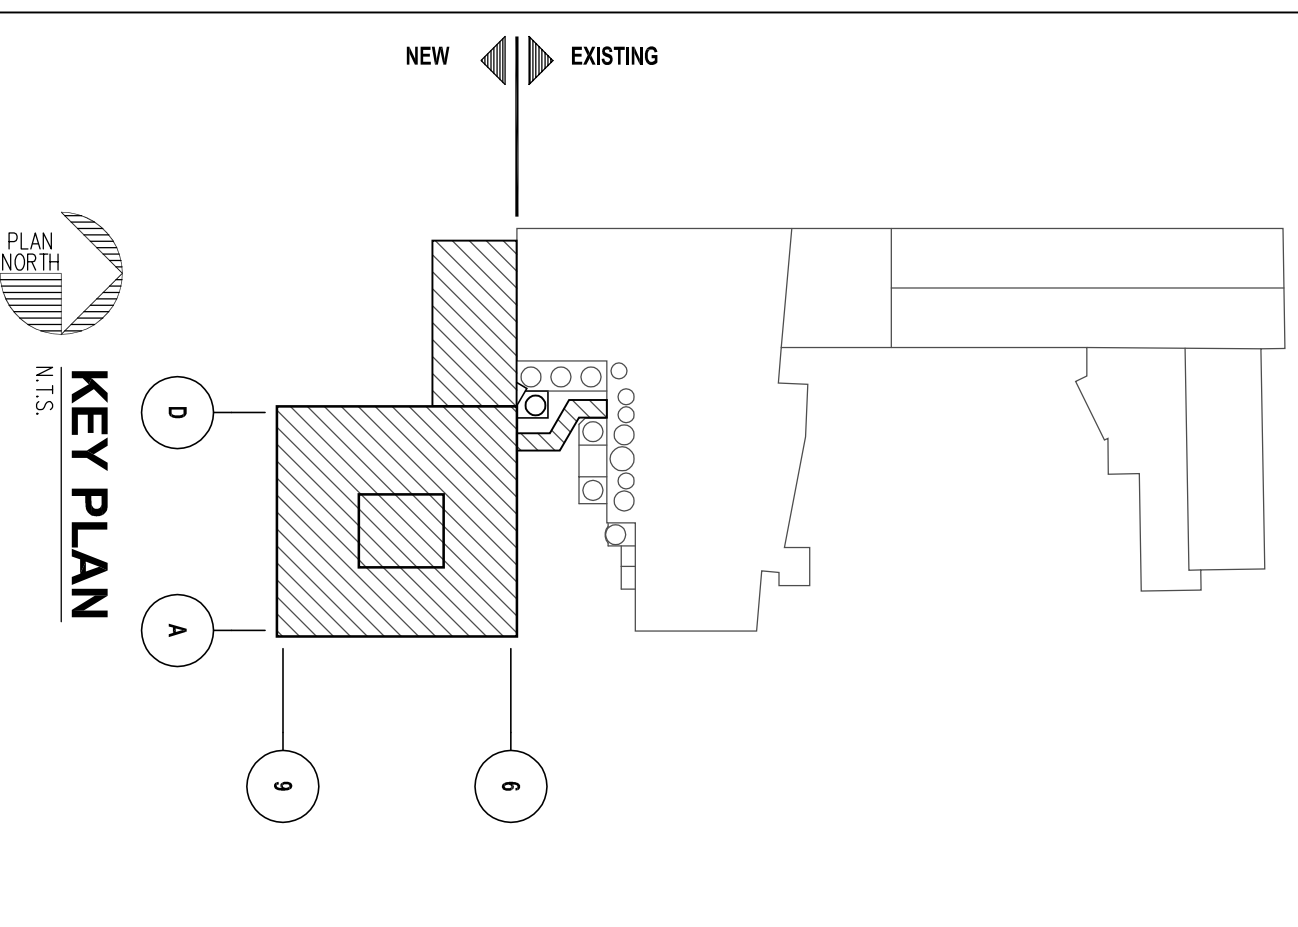

**PROJECT:** NEW MILK COOLER

**CLIENT:** OAKLUST DAIRY

**ADDRESS:** 384 FOREST AVENUE, PORTLAND, MAINE 04101

**DATE:** MARCH 1, 2004

**PROJECT NUMBER:** 0167.00

**DRAWING NUMBER:** E300

**REVISION:** 0

**FACILITIES DESIGN**

3904 Ashd Drive  
Columbia, Pennsylvania 17512  
Phone: (717) 285-9442  
Fax: (717) 285-3102  
Email: info@facilitiesdesign.com  
Web: www.facilitiesdesign.com

CA NUMBER: 20031118 F

**Engineering Design Services**

Architectural Engineering  
Blading Structural  
Foundation  
Fire Protection  
HVAC  
Interior Design  
Kitchen Design  
Lighting  
Mechanical  
Process Design  
Process Services  
Process Safety  
Process Simulation  
Process Water Management  
Project Management  
Quality Assurance  
Water/Wastewater Systems Studies

**REVISIONS**

NO.	DATE	DESCRIPTION
0	3-01-04	ISSUED FOR BID

**PROJECT MANAGER:** M.S.M.

**DESIGNED BY:** M.S.M.

**DRAWN BY:** M.S.M.

**REC. BY:** M.S.M.

**CHECKED BY:** M.S.M.

**PROJECT:** NEW MILK COOLER

This drawing and all information contained herein, remains the property of FACILITIES DESIGN, INC. No part of this drawing may be reproduced in whole or in part without the written consent of FACILITIES DESIGN, INC. Do not scale drawing. Contractor shall be responsible for any discrepancies that may exist between this drawing and the actual construction. Any discrepancies shall be reported to FACILITIES DESIGN, INC. prior to construction for resolution.