


FIRST FLOOR POWER PLAN
SCALE: 1/8" = 1'-0"

PLAN KEY NOTES

1. INSTANT RESPONSE, TELEPHONE OUTLET AND NETWORK OUTLET IN BACKGROUND IN ELECTRICAL ROOM.

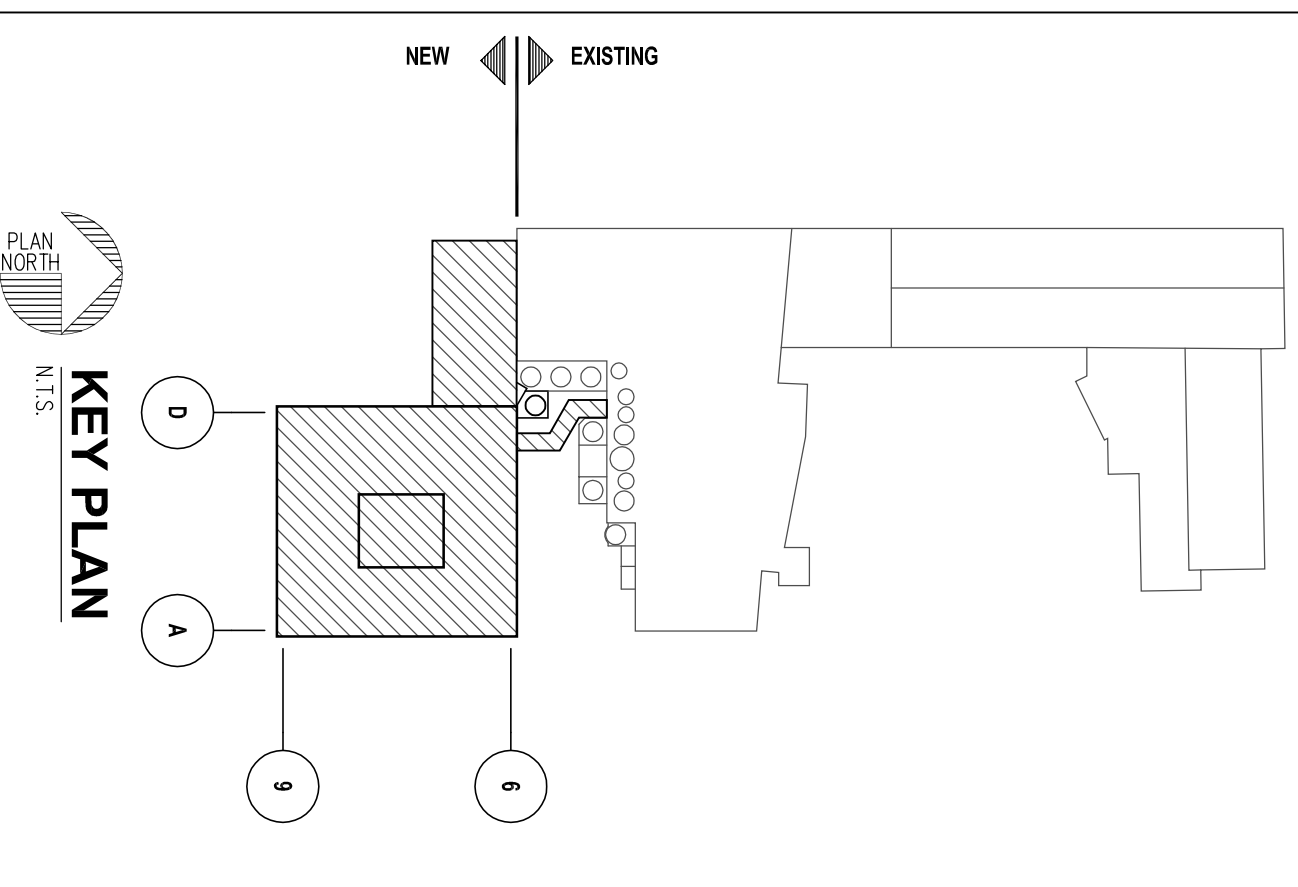

FACILITIES DESIGN

3904 Ashd Drive
Columbia, Pennsylvania 17512
Phone: (717) 285-9442
Fax: (717) 285-3102
Email: info@facilitiesdesign.com
Web: www.facilitiesdesign.com
CA WARE: 20031118 F

Engineering Design Services

Architectural Engineering
Building Structural
Foundation
Plumbing
Fire Protection
Control Systems
Lighting
Mechanical
Thermal Analysis
Process Services
Project Management
Project Cost Estimation
Project Scheduling
Master Planning
Master Scheduling
General Studies

REVISIONS

NO.	DATE	ISSUED FOR
0	3-01-04	ISSUED FOR BID

This drawing and all information contained herein, remains the property of FACILITIES DESIGN, INC. No part of this drawing may be reproduced in whole or in part without the express written consent of FACILITIES DESIGN, INC. Contractor shall be responsible for any discrepancies that may exist between this drawing and the actual conditions on the job site. Any discrepancies shall be reported to FACILITIES DESIGN, INC. prior to construction for resolution.

PROJECT MANAGER: MASH
DESIGNED BY: MASH
DRAWN BY: REC.
CHECKED BY: MASH

Oakhurst DAIRY

NEW MILK COOLER

384 FOREST AVENUE
PORTLAND, MAINE 04101

PROJECT NUMBER: 0167.00

FIRST FLOOR POWER PLAN

DATE: MARCH 1, 2004

DRAWING NUMBER: E400

REVISION: 0