

FIRST FLOOR UNDER-FLOOR PIPING PLAN
SCALE: 1/8" = 1'-0"
PLANNERS: 1. FOR TOP OF FLOOR SLAB. OTHER ELEVATIONS SEE DRAWING 1000.



GENERAL PLUMBING NOTES:

1. ALL LEGEND SYMBOLS AND ABBREVIATIONS DO NOT NECESSARILY APPEAR IN THESE CONTRACT DOCUMENTS.
2. THESE LEGEND AND ABBREVIATIONS PERTAIN TO THE PLUMBING DRAWINGS P100 THROUGH P200 ONLY.
3. CONTRACTOR SHALL BE RESPONSIBLE TO INTERFERE AND VERIFY ALL FIELD CONDITIONS PRIOR TO INSTALLATION OF SYSTEMS.
4. UNLESS ITEMS OR MATERIAL, EQUIPMENT OR WORK ARE SPECIFICALLY NOTED TO BE PROVIDED OR FURNISHED BY OTHERS, THEY SHALL BE PROVIDED BY THIS CONTRACTOR.
5. ALL WORK SHALL BE DONE IN ACCORDANCE WITH CHAPTER 22A STATE OF MAINE INTERNAL PLUMBING RULES.
6. ALL WORK MUST BE DONE IN A PROFESSIONAL AND WORKMAN LIKE MANNER.

PLUMBING ABBREVIATIONS

ABV	ABOVE HANGING FLOOR	LF	LOCAL FEET
BRH	BRITISH THERMAL UNIT/HOUR	M/C	MACHINICAL CONTRACTOR
CO	CONDENSATE	M/C	MACHINICAL CONTRACTOR
OD	OVERHEAD	MD	MID
CB	CALVEY BATH	ND	NON DRAIN
CB	CALVEY BATH	ND	NON DRAIN
CO	CONDENSATE	PC	PRESSURE COMP
CM	COLD WATER	PR	PRESSURE RELIEF
CD	CONDENSATE DRAIN	PRV	PRESSURE REDUCING VALVE
CD	CONDENSATE DRAIN	PSC	PRESSURE SENSITIVE CONTROL
CD	CONDENSATE DRAIN	P/SD	PRESS/SHOCK/DRIVE INCH GALVANIZ
CD	CONDENSATE DRAIN	PLN	PLANT WATER
CD	CONDENSATE DRAIN	PLN	PLANT WATER
PLUMBING SYMBOLS

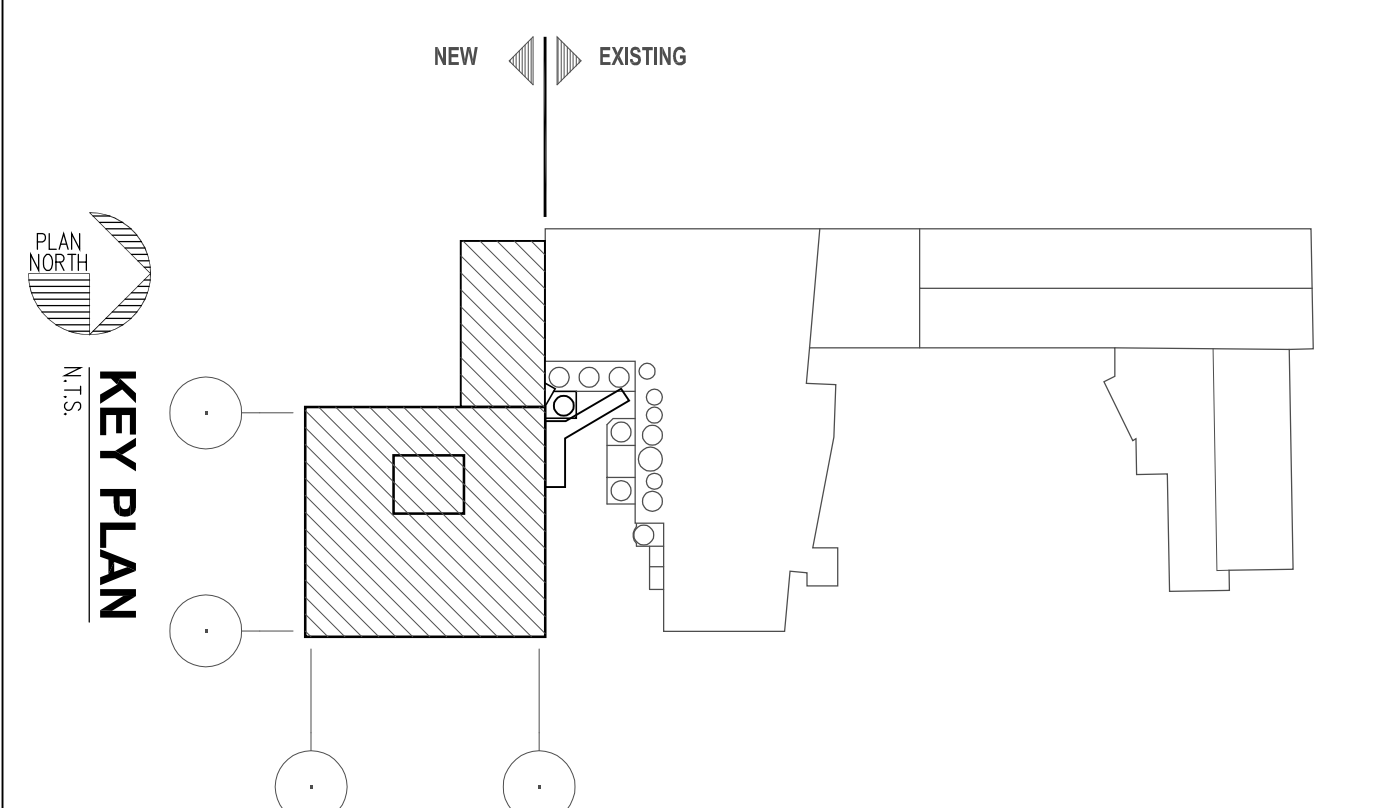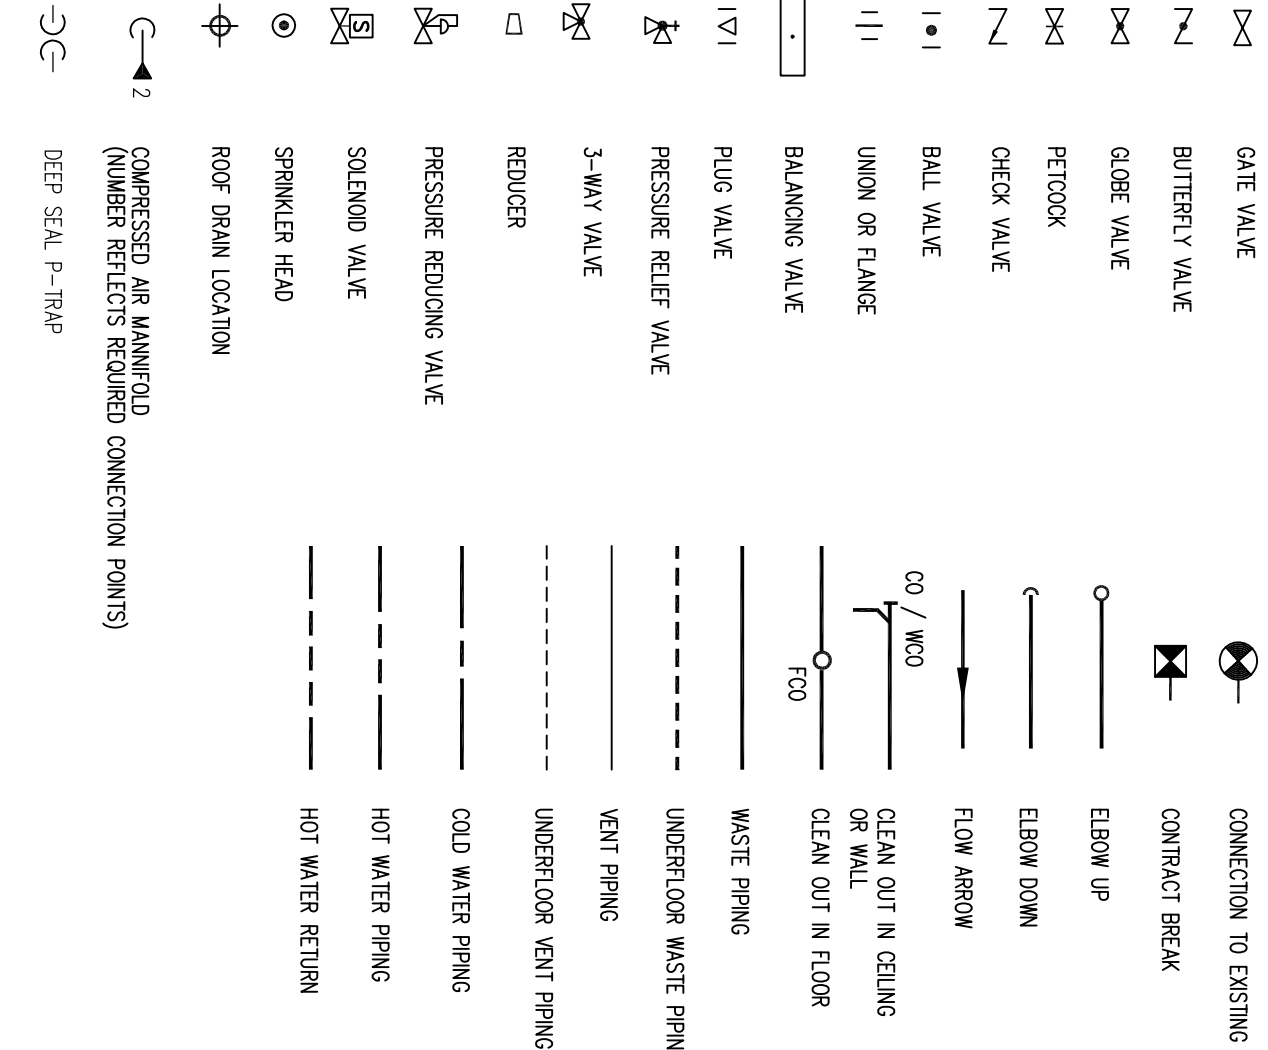

FACILITIES DESIGN, INC.

3904 Auld Drive
Columbia, Pennsylvania 17512
Phone: (717) 265-9442
Fax: (717) 265-3102
Email: info@facilitiesdesign.com
Web: www.facilitiesdesign.com

Engineering Design Services
Architectural Engineering
Building Mechanical
Process Mechanical
Plant Mechanical
Thermal Radiation
Process Services
Project Management
Process Safety
Process Hazard Analysis
Process Flow Simulation

NEW MILK COOLER
384 FOREST AVENUE
PORTLAND, MAINE 04101

Oakhurst DAIRY

PROJECT NUMBER: 2003.1141.0
DATE: AUGUST 29, 2003
DRAWING TITLE: FIRST FLOOR UNDER-FLOOR PIPING PLAN
DRAWING NUMBER: P100
REVISION: 1

DESIGNED BY: J.P.B.	CHECKED BY: J.P.B.	PROJECT MANAGER: G.S.T.
DRAWN BY: J.P.B.	CHECKED BY: G.S.T.	

REVISIONS

NO.	DATE	DESCRIPTION
1	8-29-03	ADDITIONAL R.F.I.
2	8-29-03	ISSUED FOR BIDDING

This drawing and all information contained herein remains the property of FACILITIES DESIGN, INC. No part of this drawing may not be reproduced or used in any form without the written consent of FACILITIES DESIGN, INC. Do not scale drawing. Contractor shall be responsible for any discrepancies that may arise during construction. No work shall be performed without the written consent of FACILITIES DESIGN, INC.