



HARRIMAN




AUBURN PORTLAND MANCHESTER

UNIVERSITY OF SOUTHERN MAINE CENTRAL HEAT PLANT UPGRADES

PORTLAND, ME


Harriman Project No. 14411

Key Plan Proj North

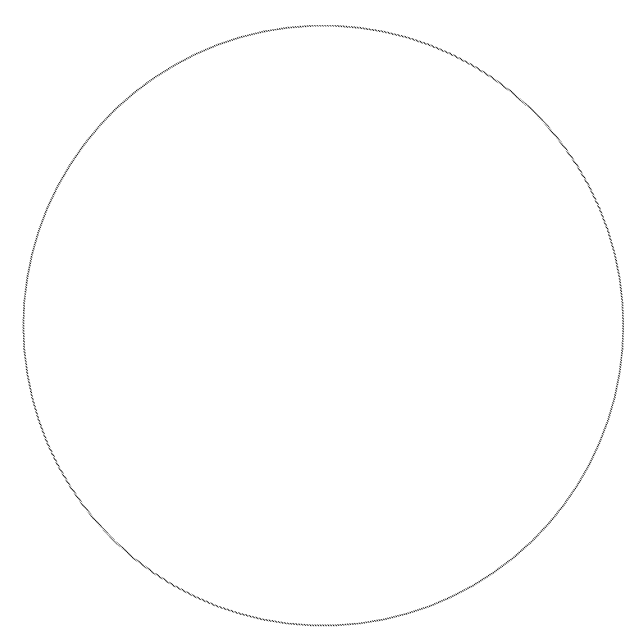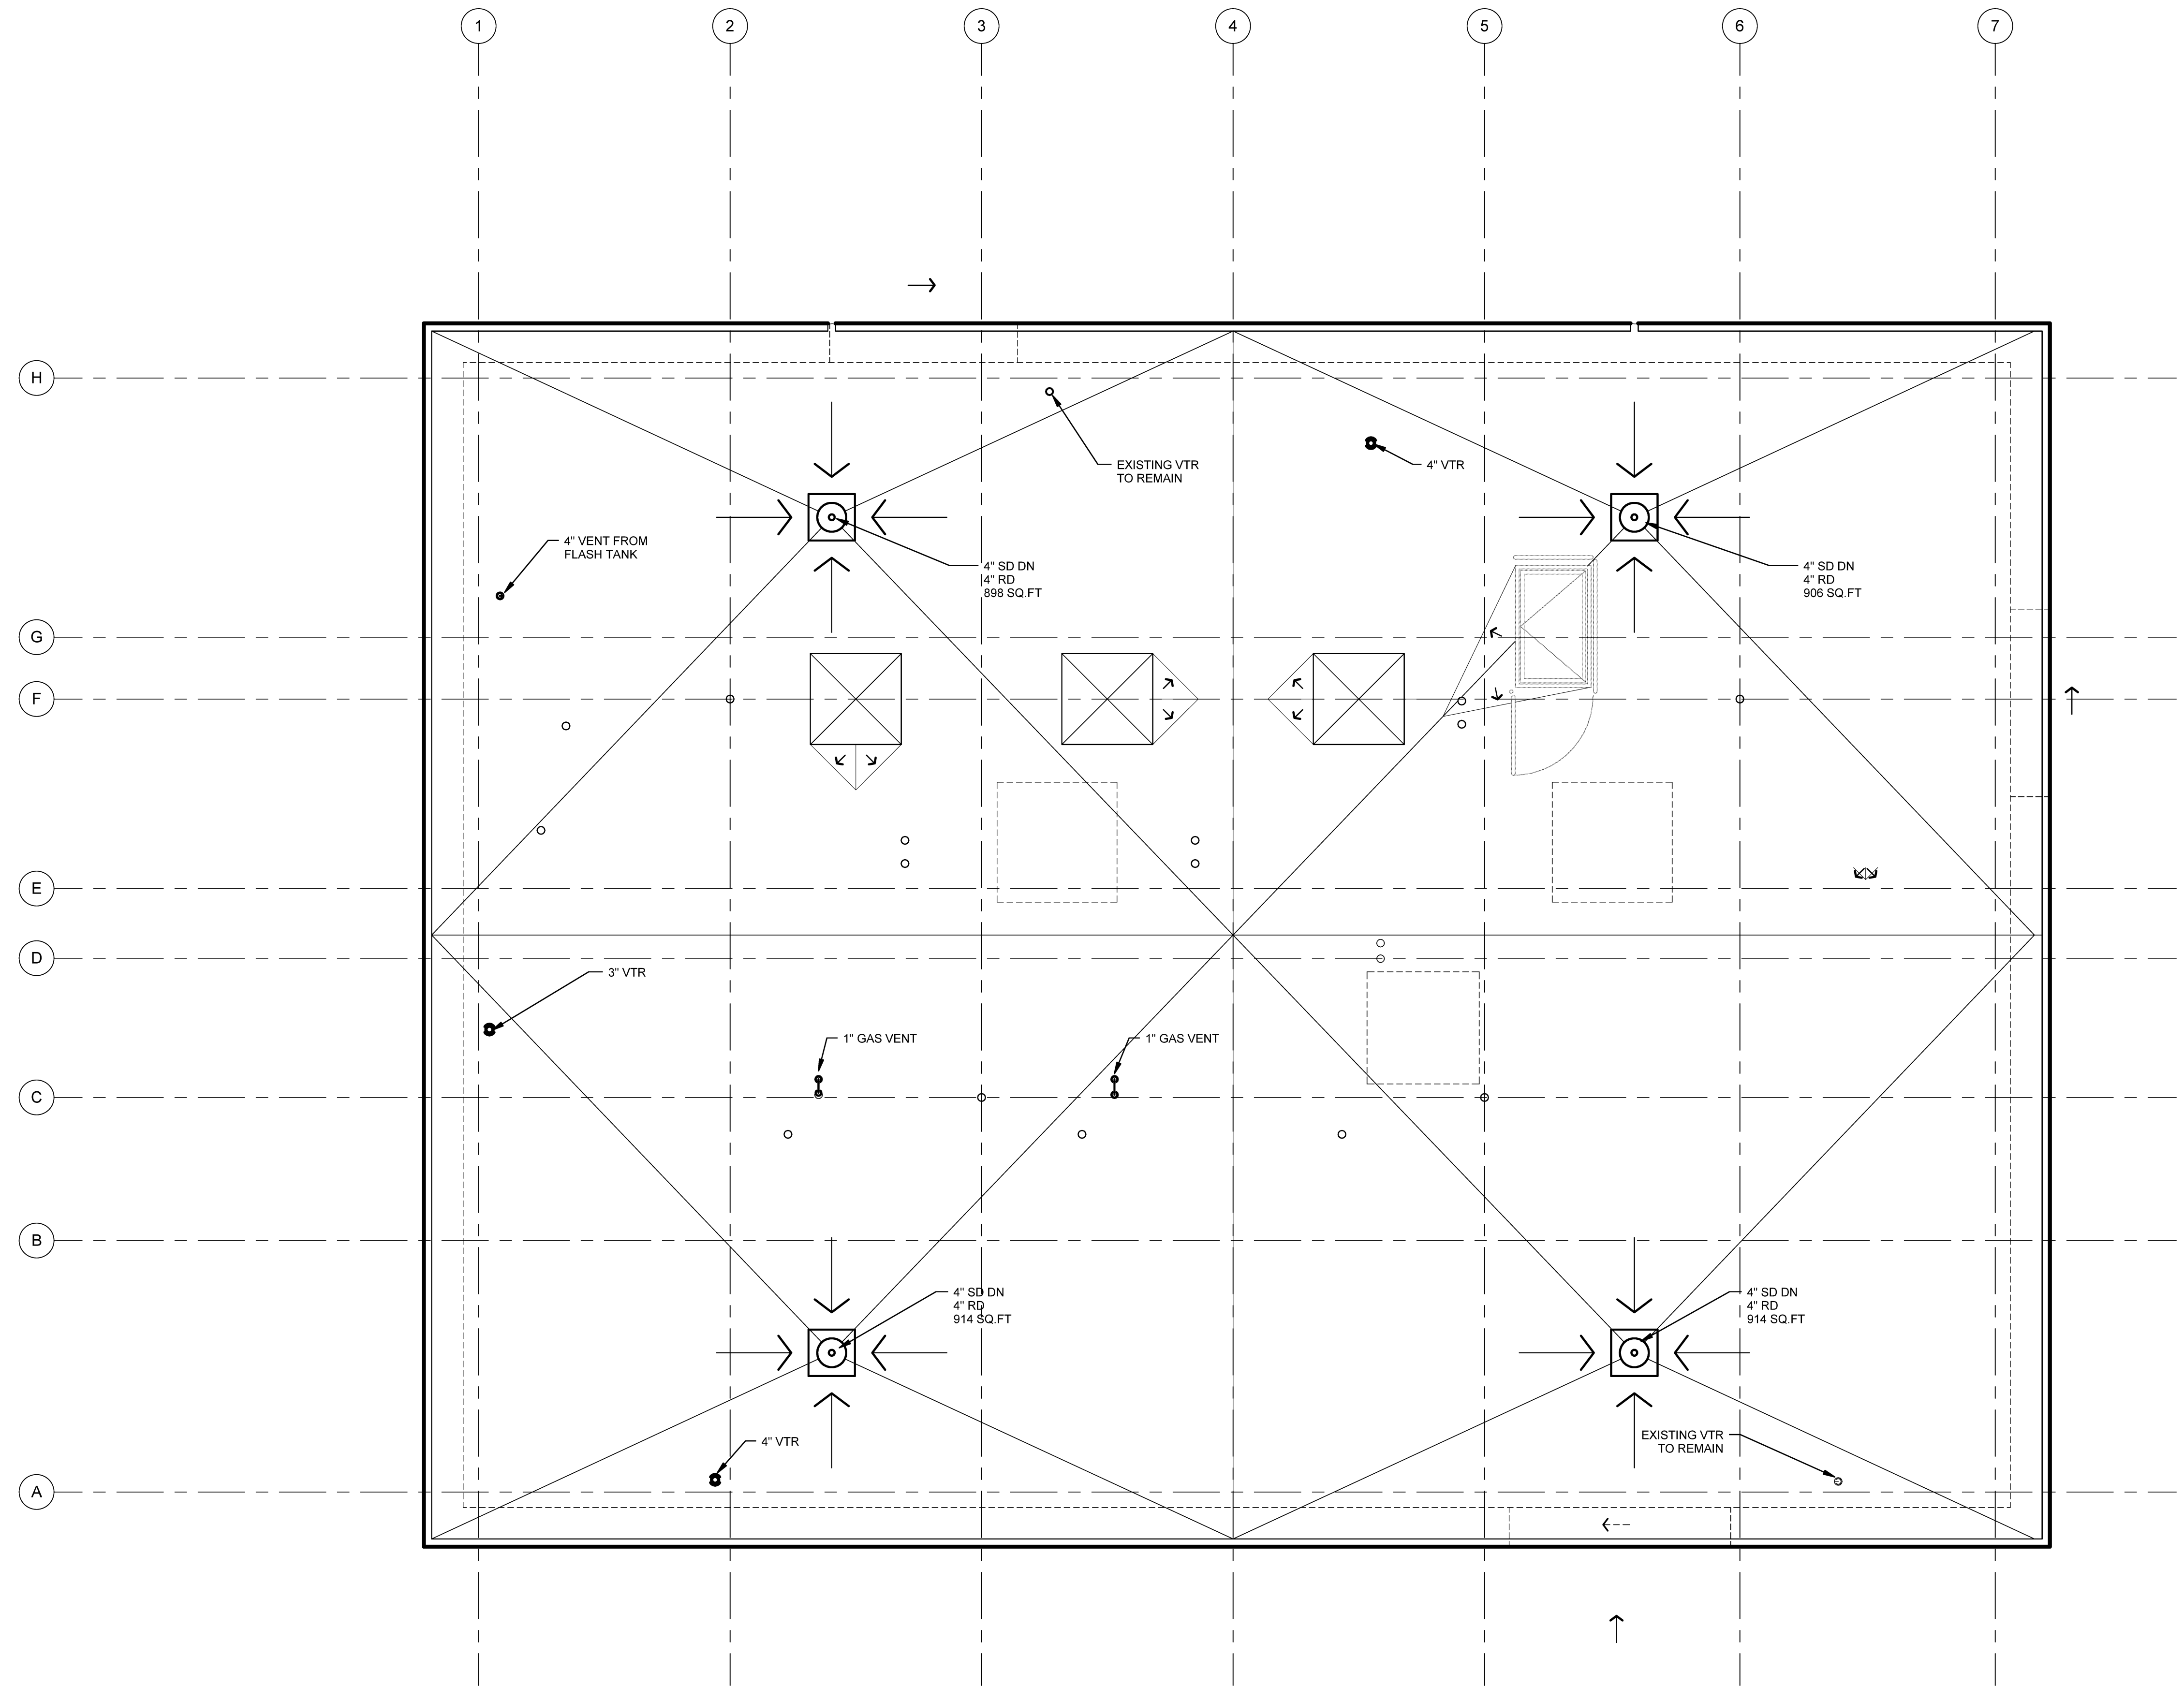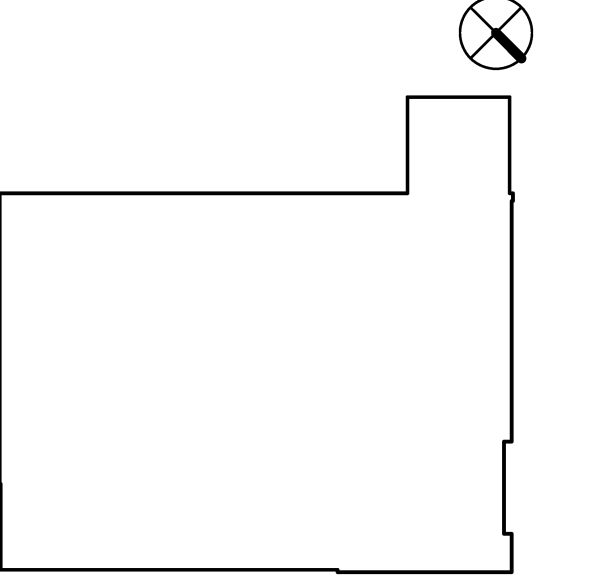

1 ROOF PLAN SCALE: 1/4" = 1'-0"

Mark	Date	Description
	10-10-14	FINAL REVIEW
	10-23-14	100% REVIEW
	10-31-14	ISSUED FOR BID

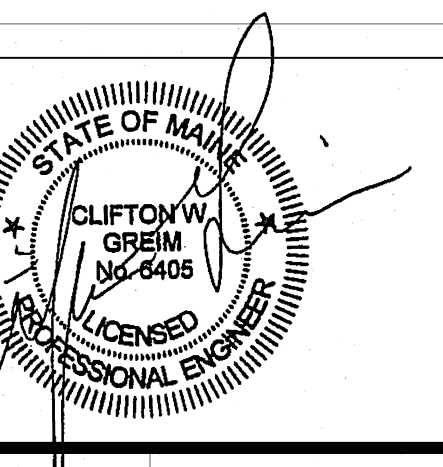

PA / PE	ROM	© 2014
Drawn By:	MAM	Harriman Associates

ROOF PLAN DRAINAGE

P10.3