



HARRIMAN



AUBURN PORTLAND MANCHESTER

UNIVERSITY OF SOUTHERN MAINE CENTRAL HEAT PLANT UPGRADES

PORTLAND, ME


Harriman Project No. 14411

Key Plan

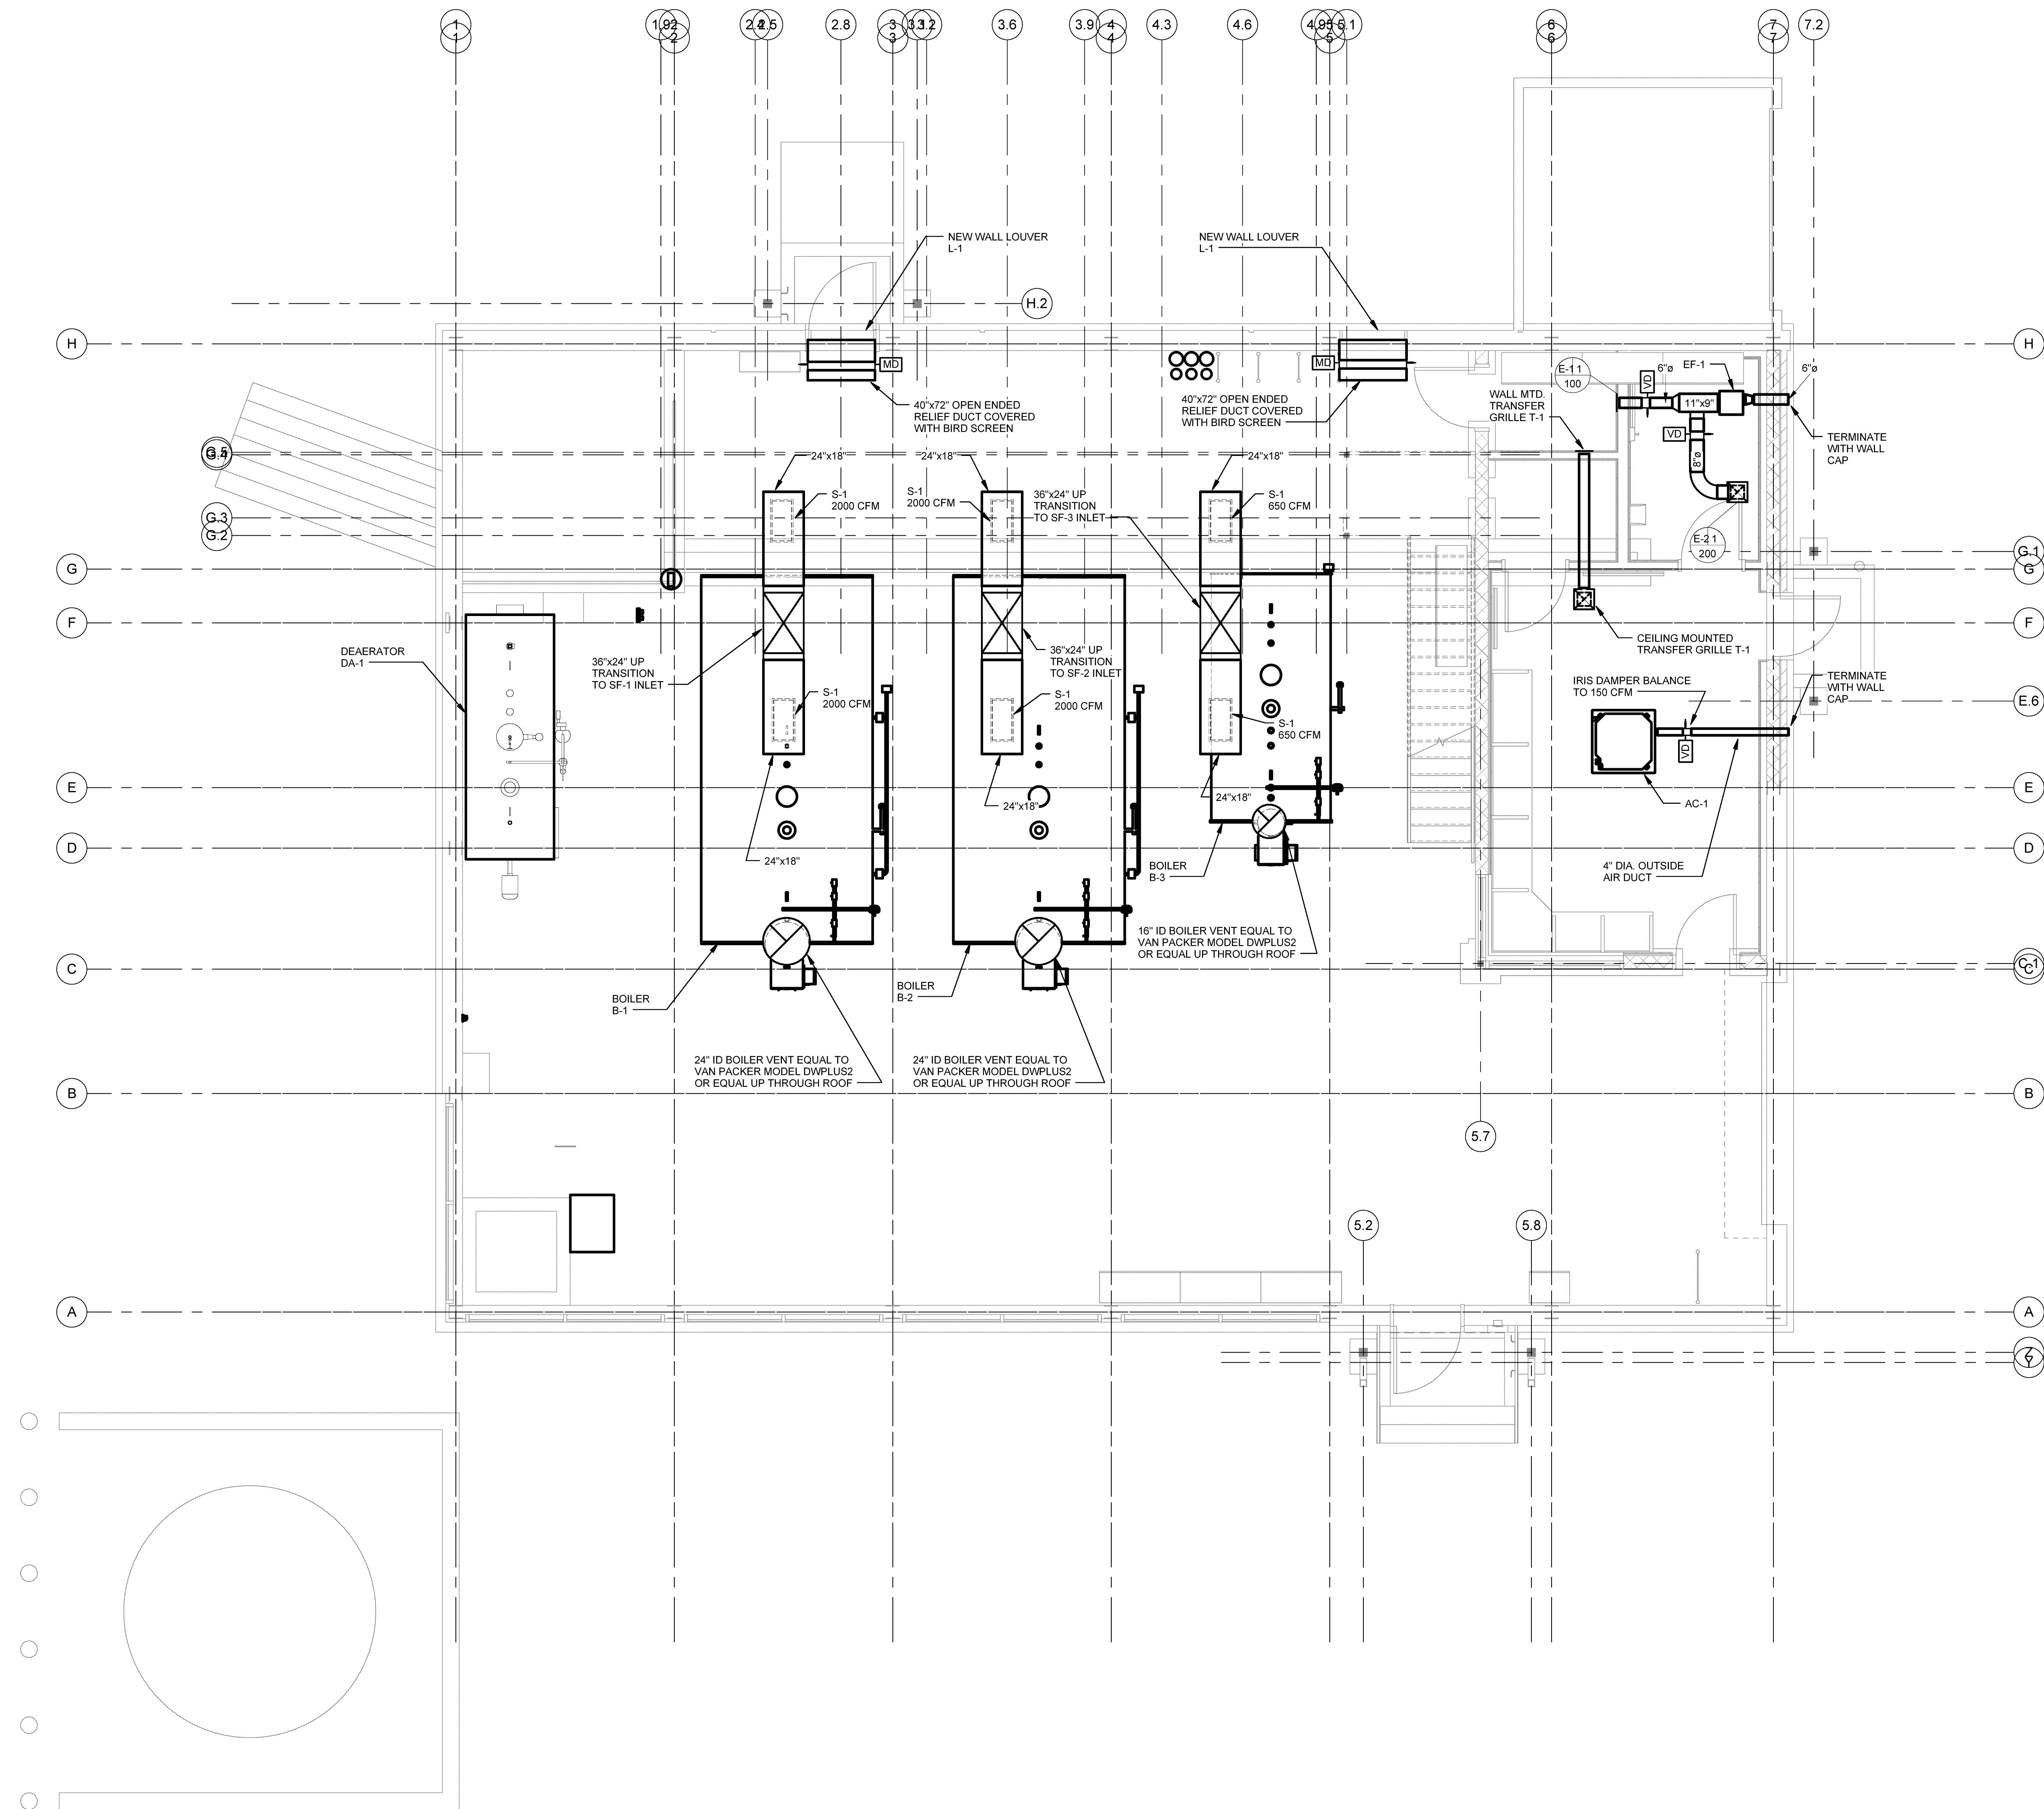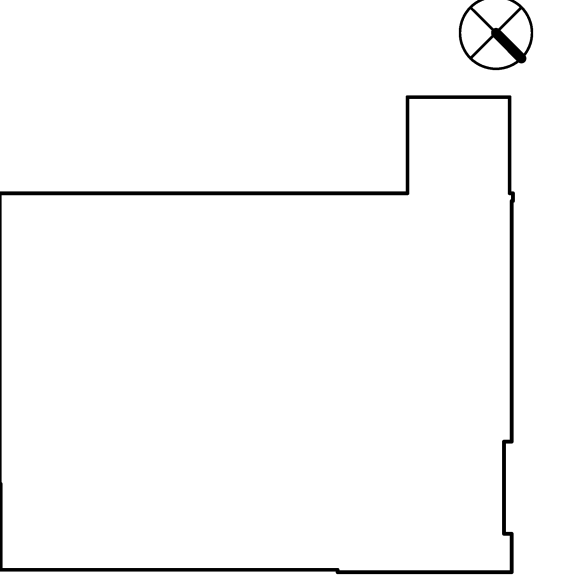

1 FIRST FLOOR DUCTWORK SCALE: 1/4" = 1'-0"

Mark	Date	Description
	09-05-14	DESIGN DEVELOPMENT
	09-19-14	PROGRESS REVIEW
	09-25-14	PROGRESS REVIEW
	10-03-14	PROGRESS REVIEW
	10-10-14	FINAL REVIEW
	10-23-14	100% REVIEW
	10-31-14	ISSUED FOR BID

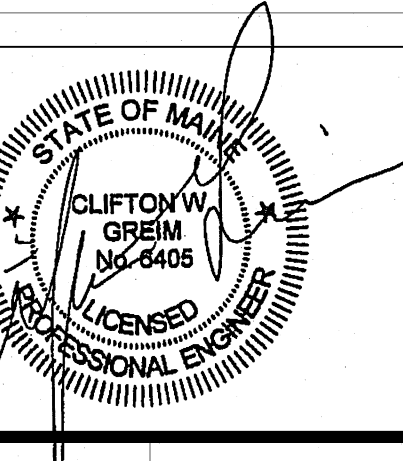

PA / PE	CG	© 2014
Drawn By:	JSL	Harriman Associates

FIRST FLOOR DUCTWORK PLAN

M10.1

Plot Date: 10/29/2014 9:02:38 AM