



HARRIMAN



AUBURN PORTLAND MANCHESTER

UNIVERSITY OF SOUTHERN MAINE CENTRAL HEAT PLANT UPDATES

PORTLAND, ME

Harriman Project No. 14411


Key Plan

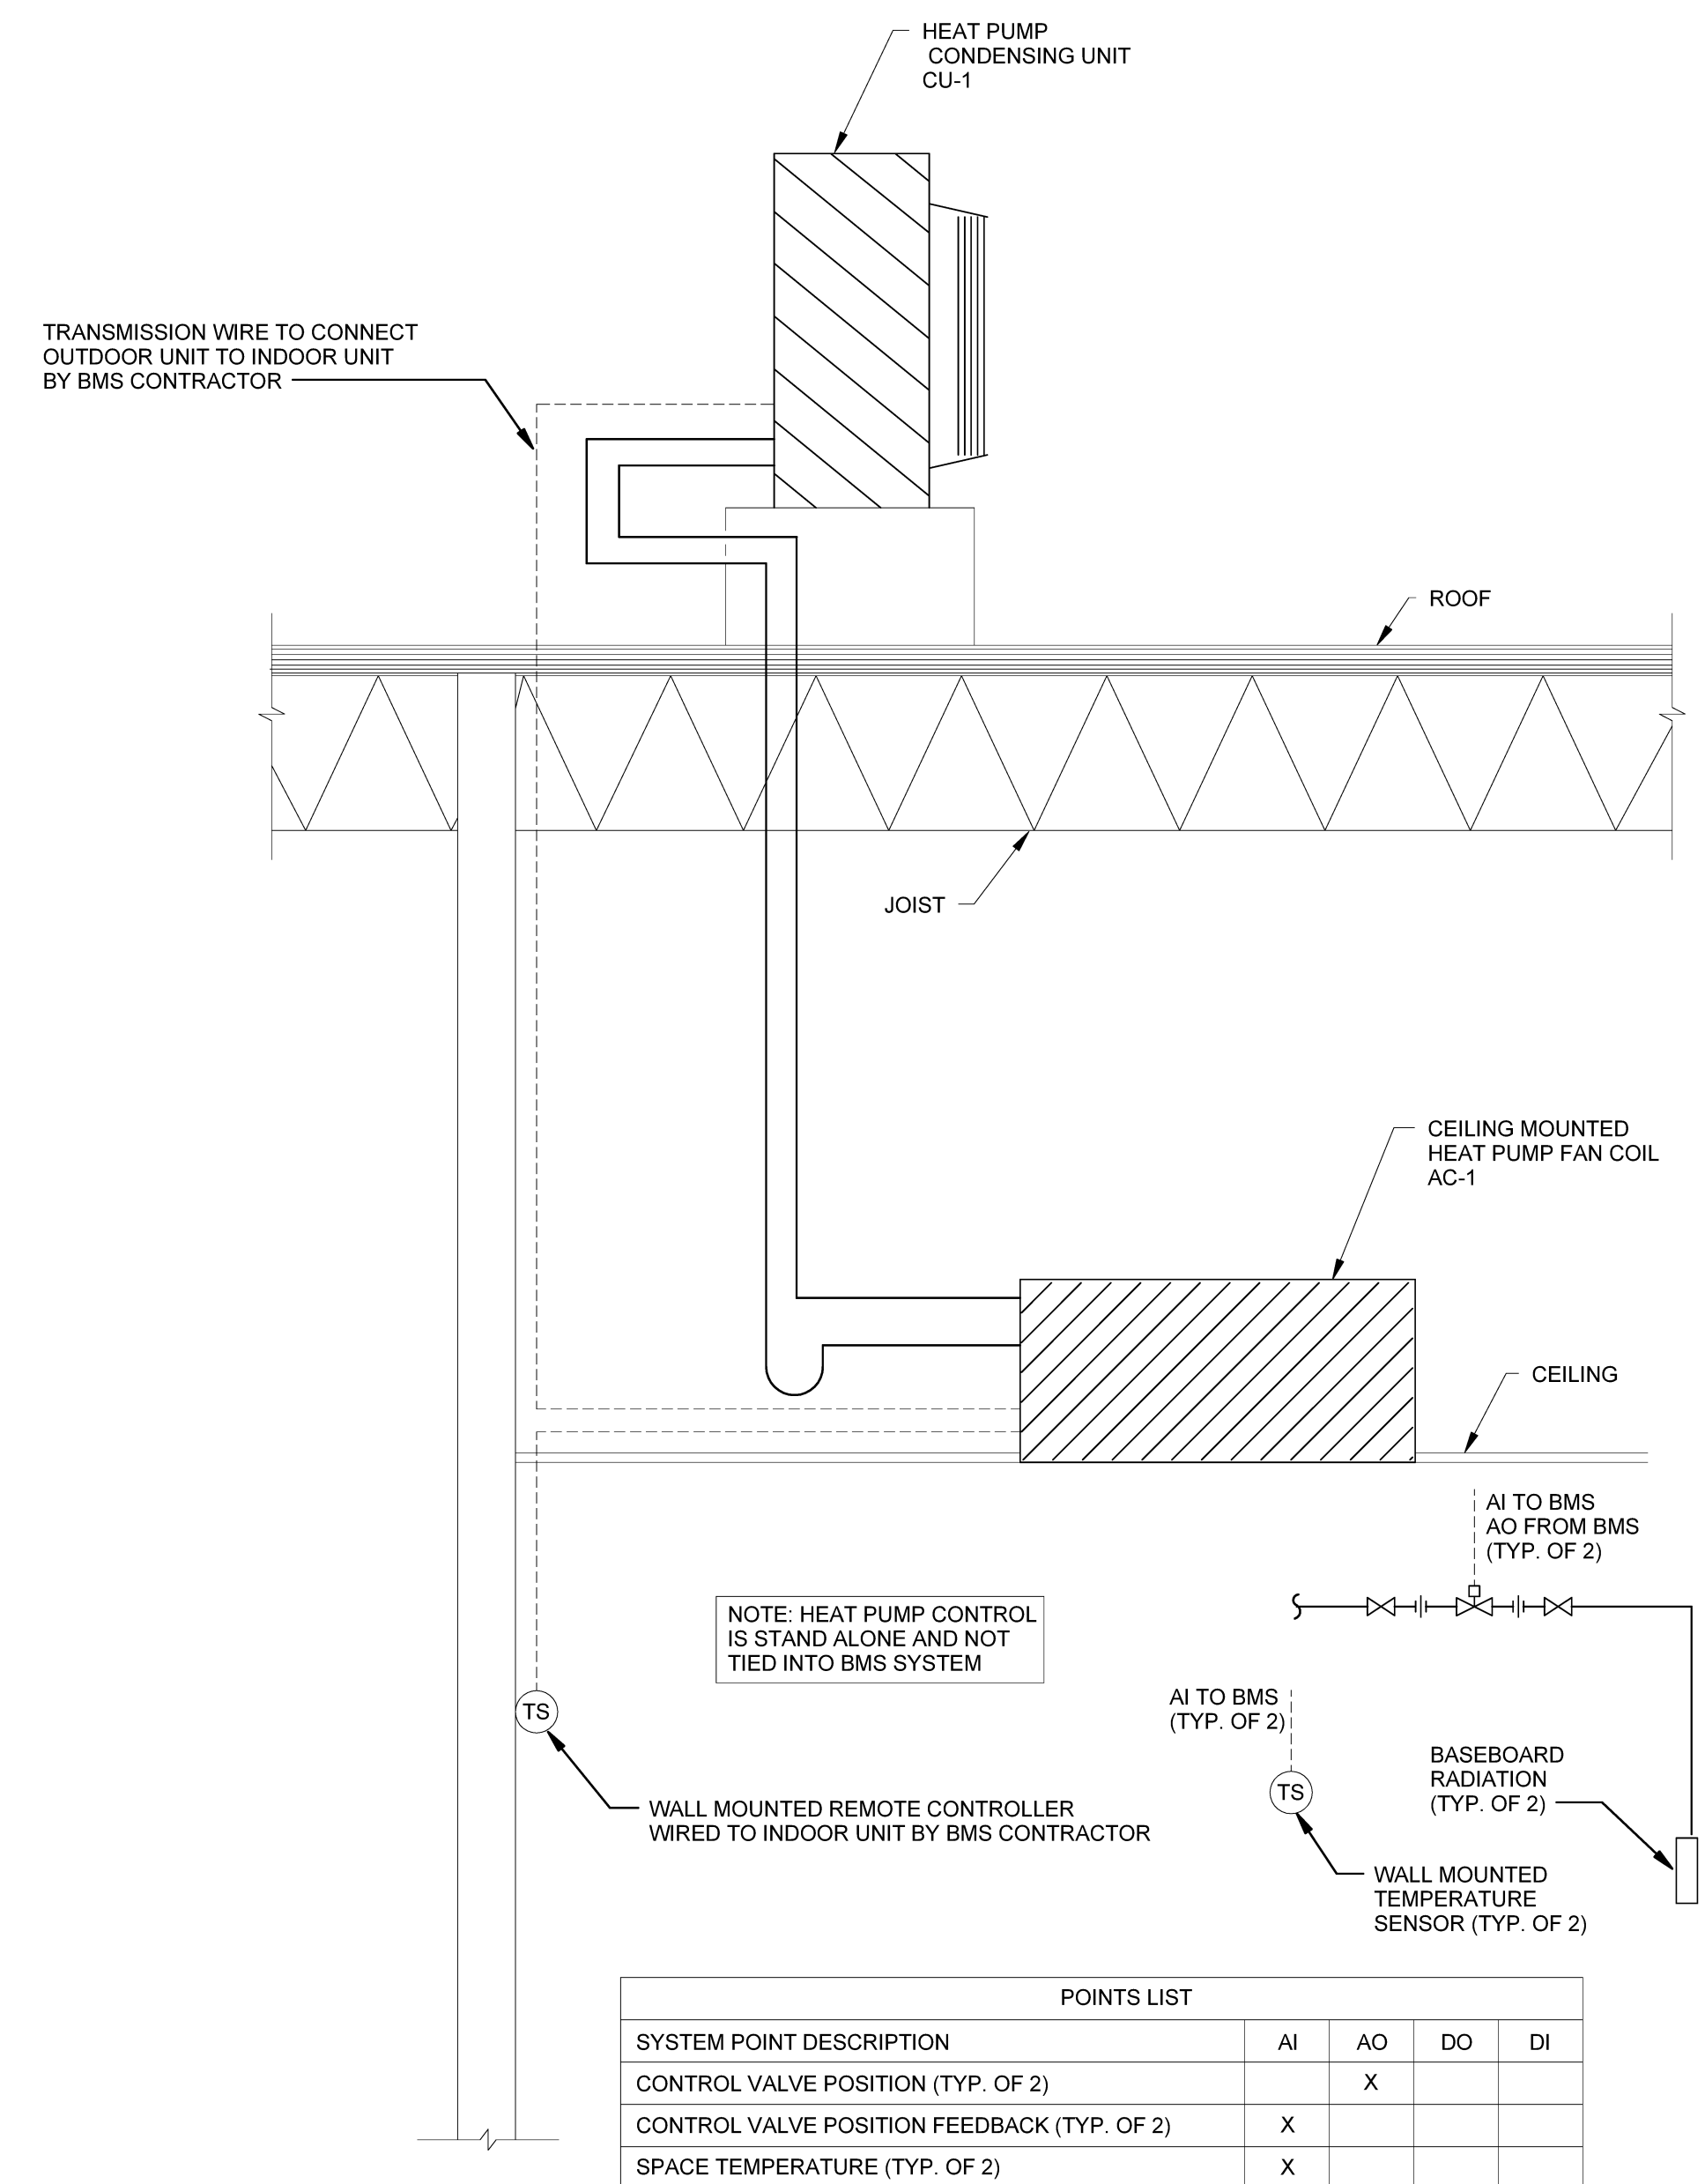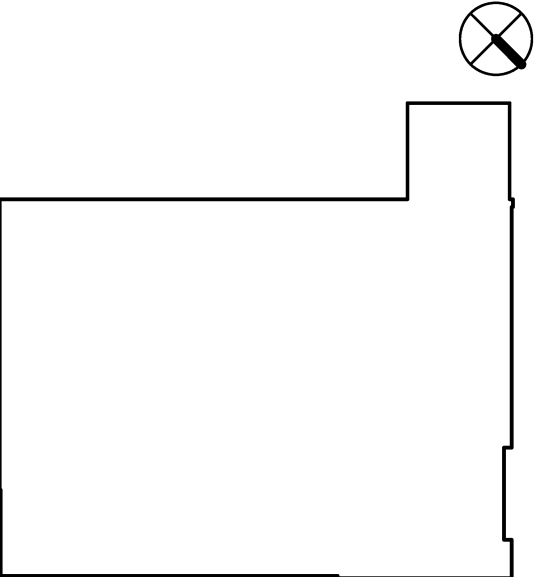

POINTS LIST table for heat pump split system with columns for System Point Description, AI, AO, DO, DI.


1 CONTROL DIAGRAM FOR HEAT PUMP SPLIT SYSTEM NO SCALE

POINTS LIST table for supply fans with columns for System Point Description, AI, AO, DO, DI.

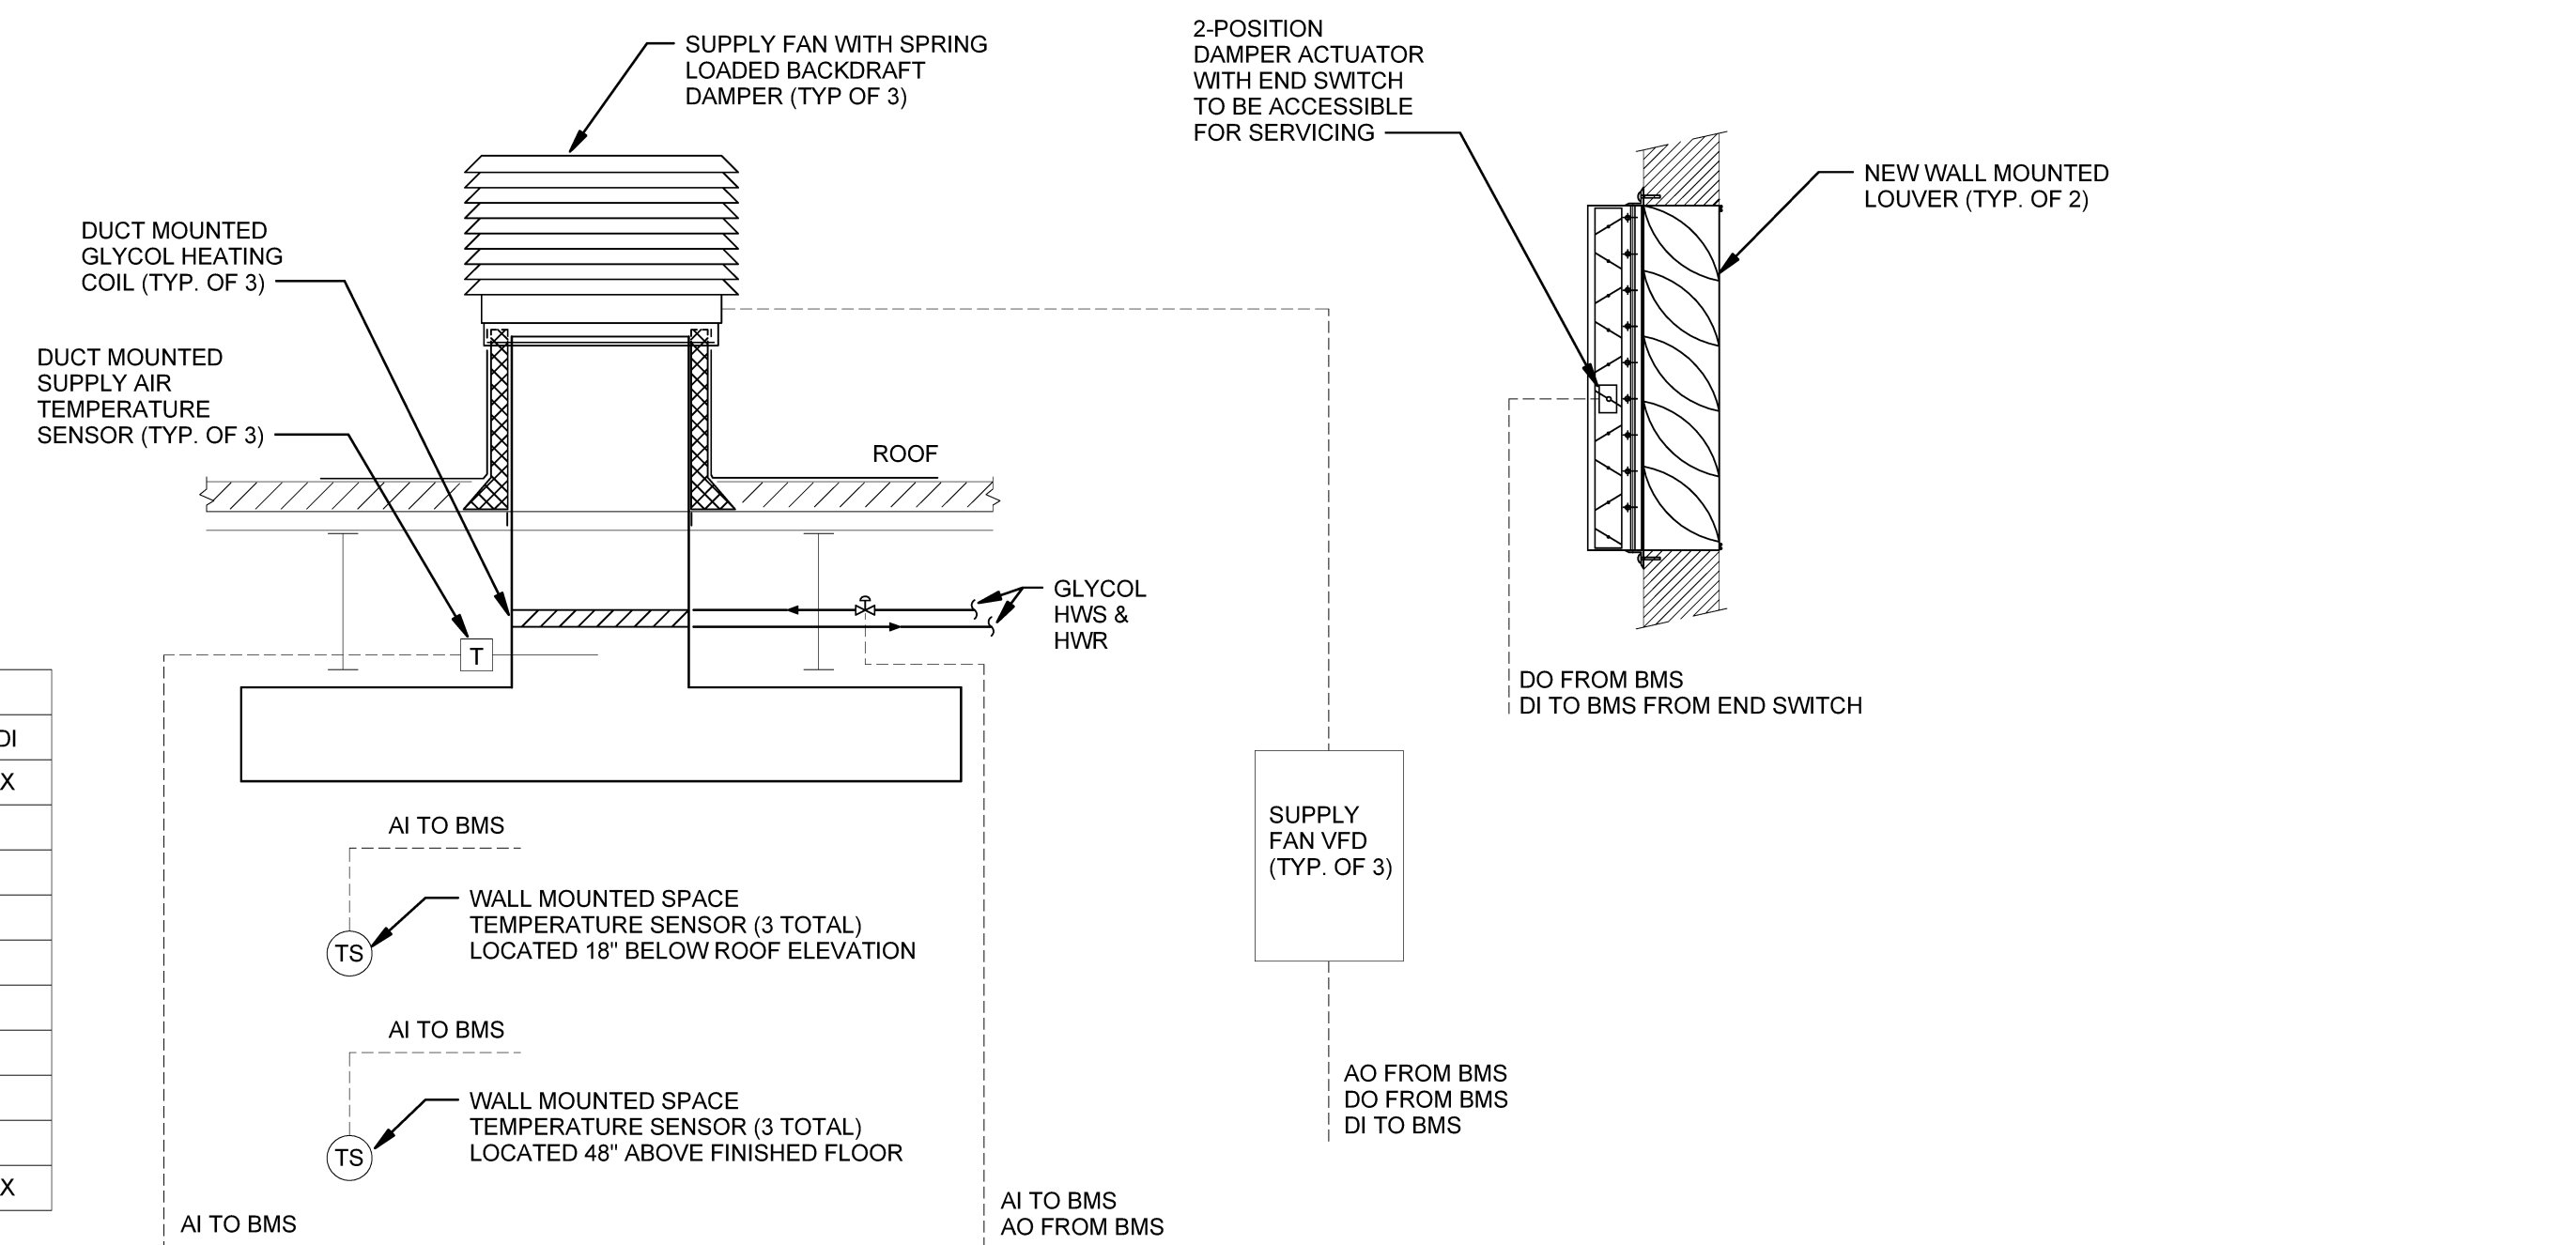


2 CONTROL DIAGRAM FOR SUPPLY FANS NO SCALE

POINTS LIST table for glycol HW heating system with columns for System Point Description, AI, AO, DO, DI.

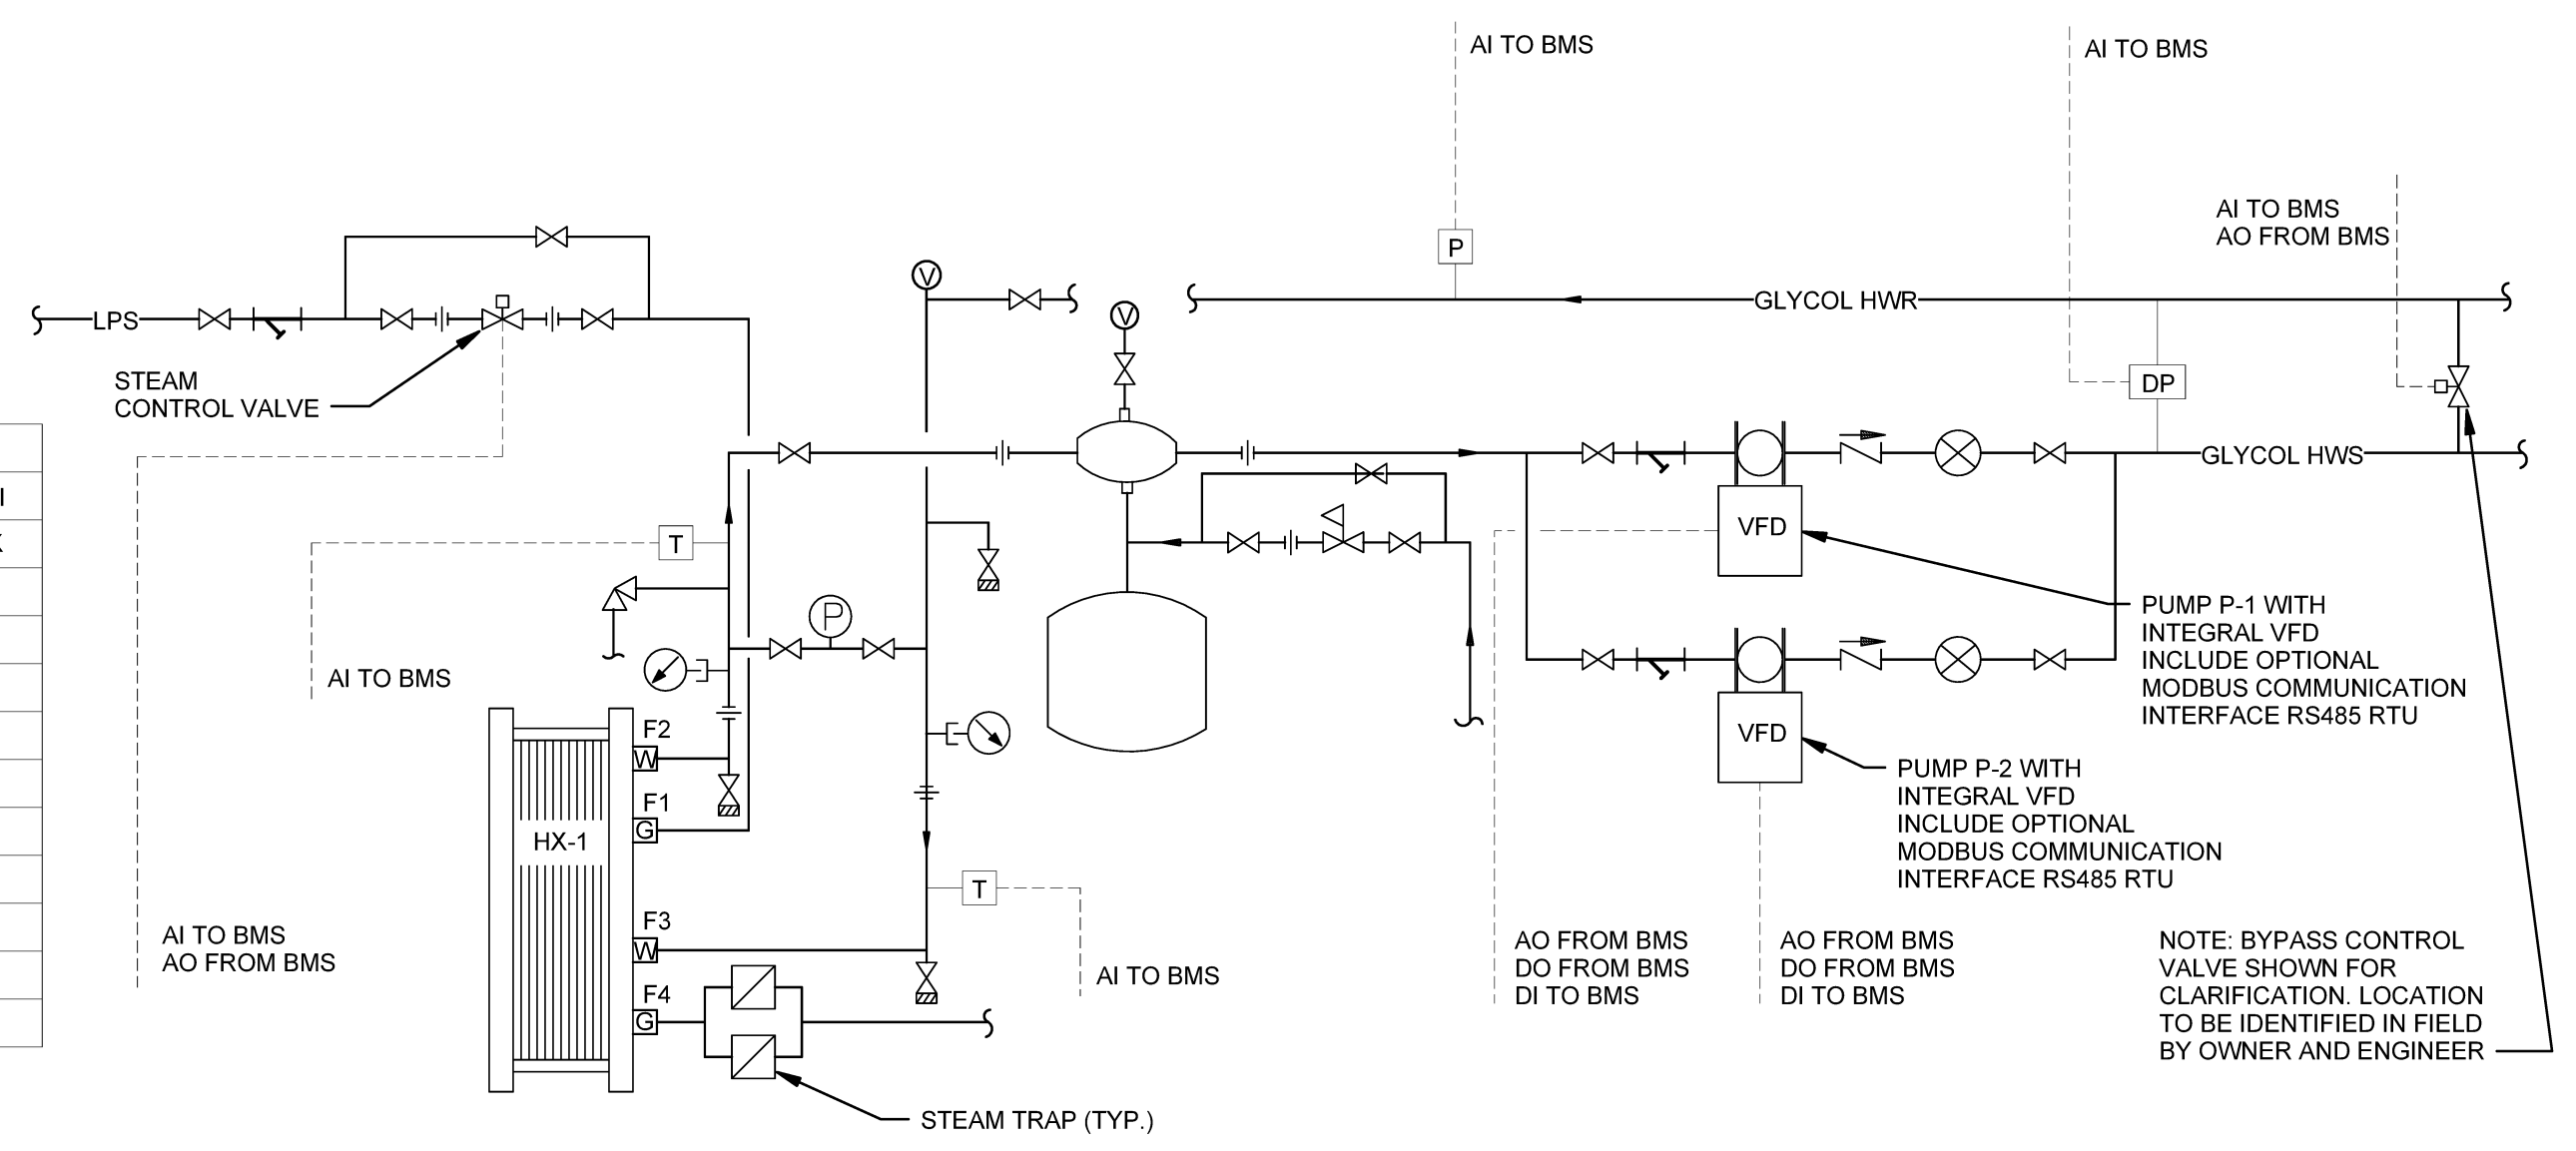


3 CONTROL DIAGRAM FOR GLYCOL HW HEATING SYSTEM NO SCALE

POINTS LIST table for boiler plant with columns for System Point Description, AI, AO, DO, DI.

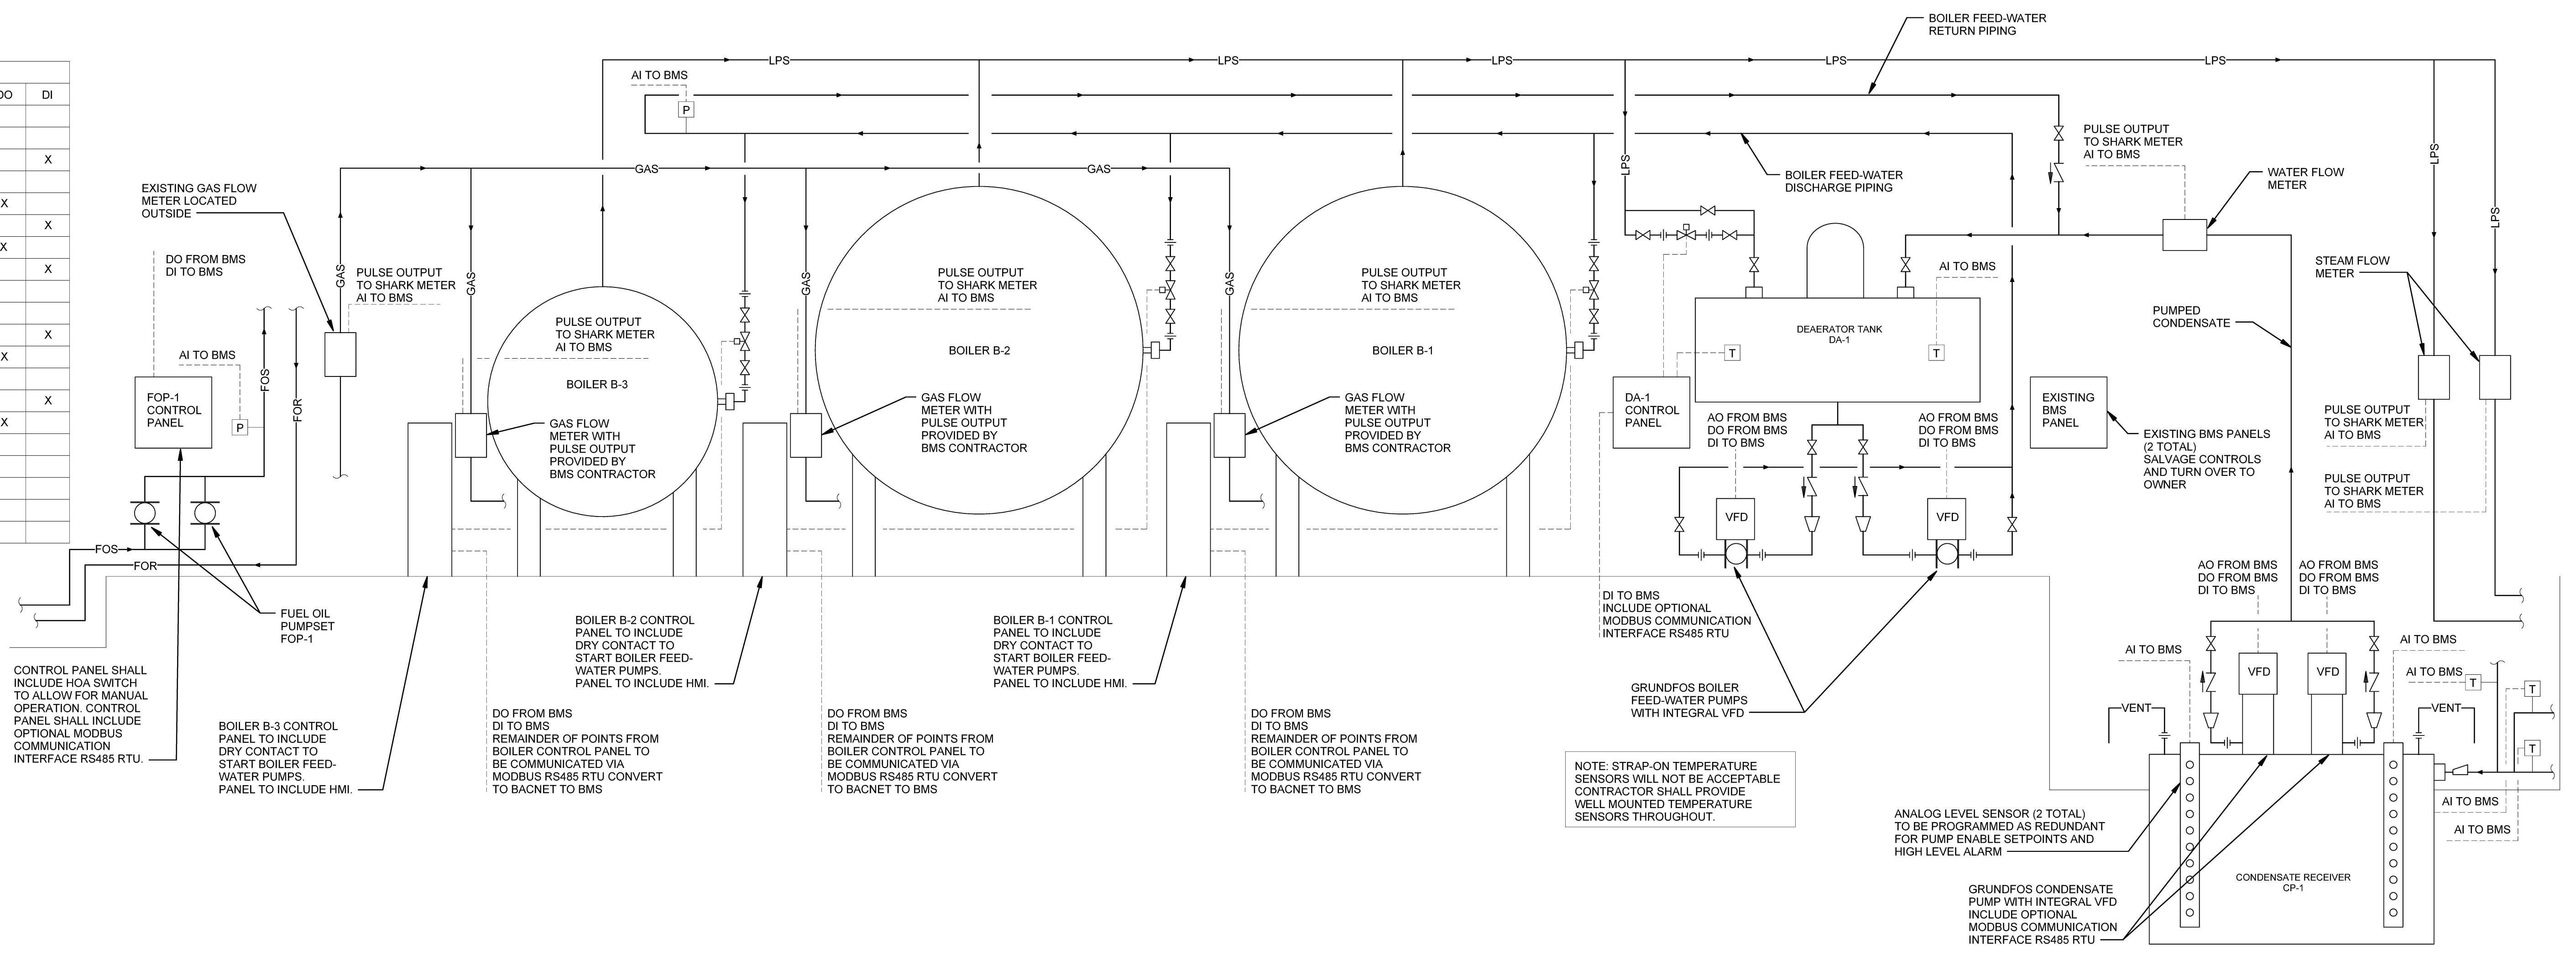

4 CONTROL DIAGRAM FOR BOILER PLANT NO SCALE

Issues and Revisions table with columns for Mark, Date, Description.

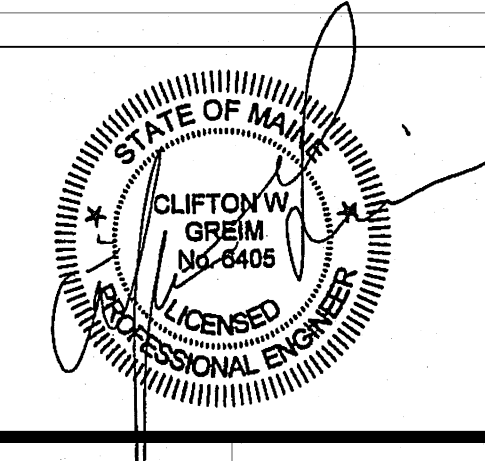

Drawing Scale: 1/8" = 1'-0"

PA/PE: CG © 2014 Harriman Associates

CONTROL DIAGRAMS

M30.2

Plot Date: 10/29/2014 9:04:11 AM