

HARRIMAN

AUBURN PORTLAND MANCHESTER


UNIVERSITY OF SOUTHERN MAINE CENTRAL HEAT PLANT UPGRADES

PORTLAND, ME


Harriman Project No. 14411

Key Plan

Prog North

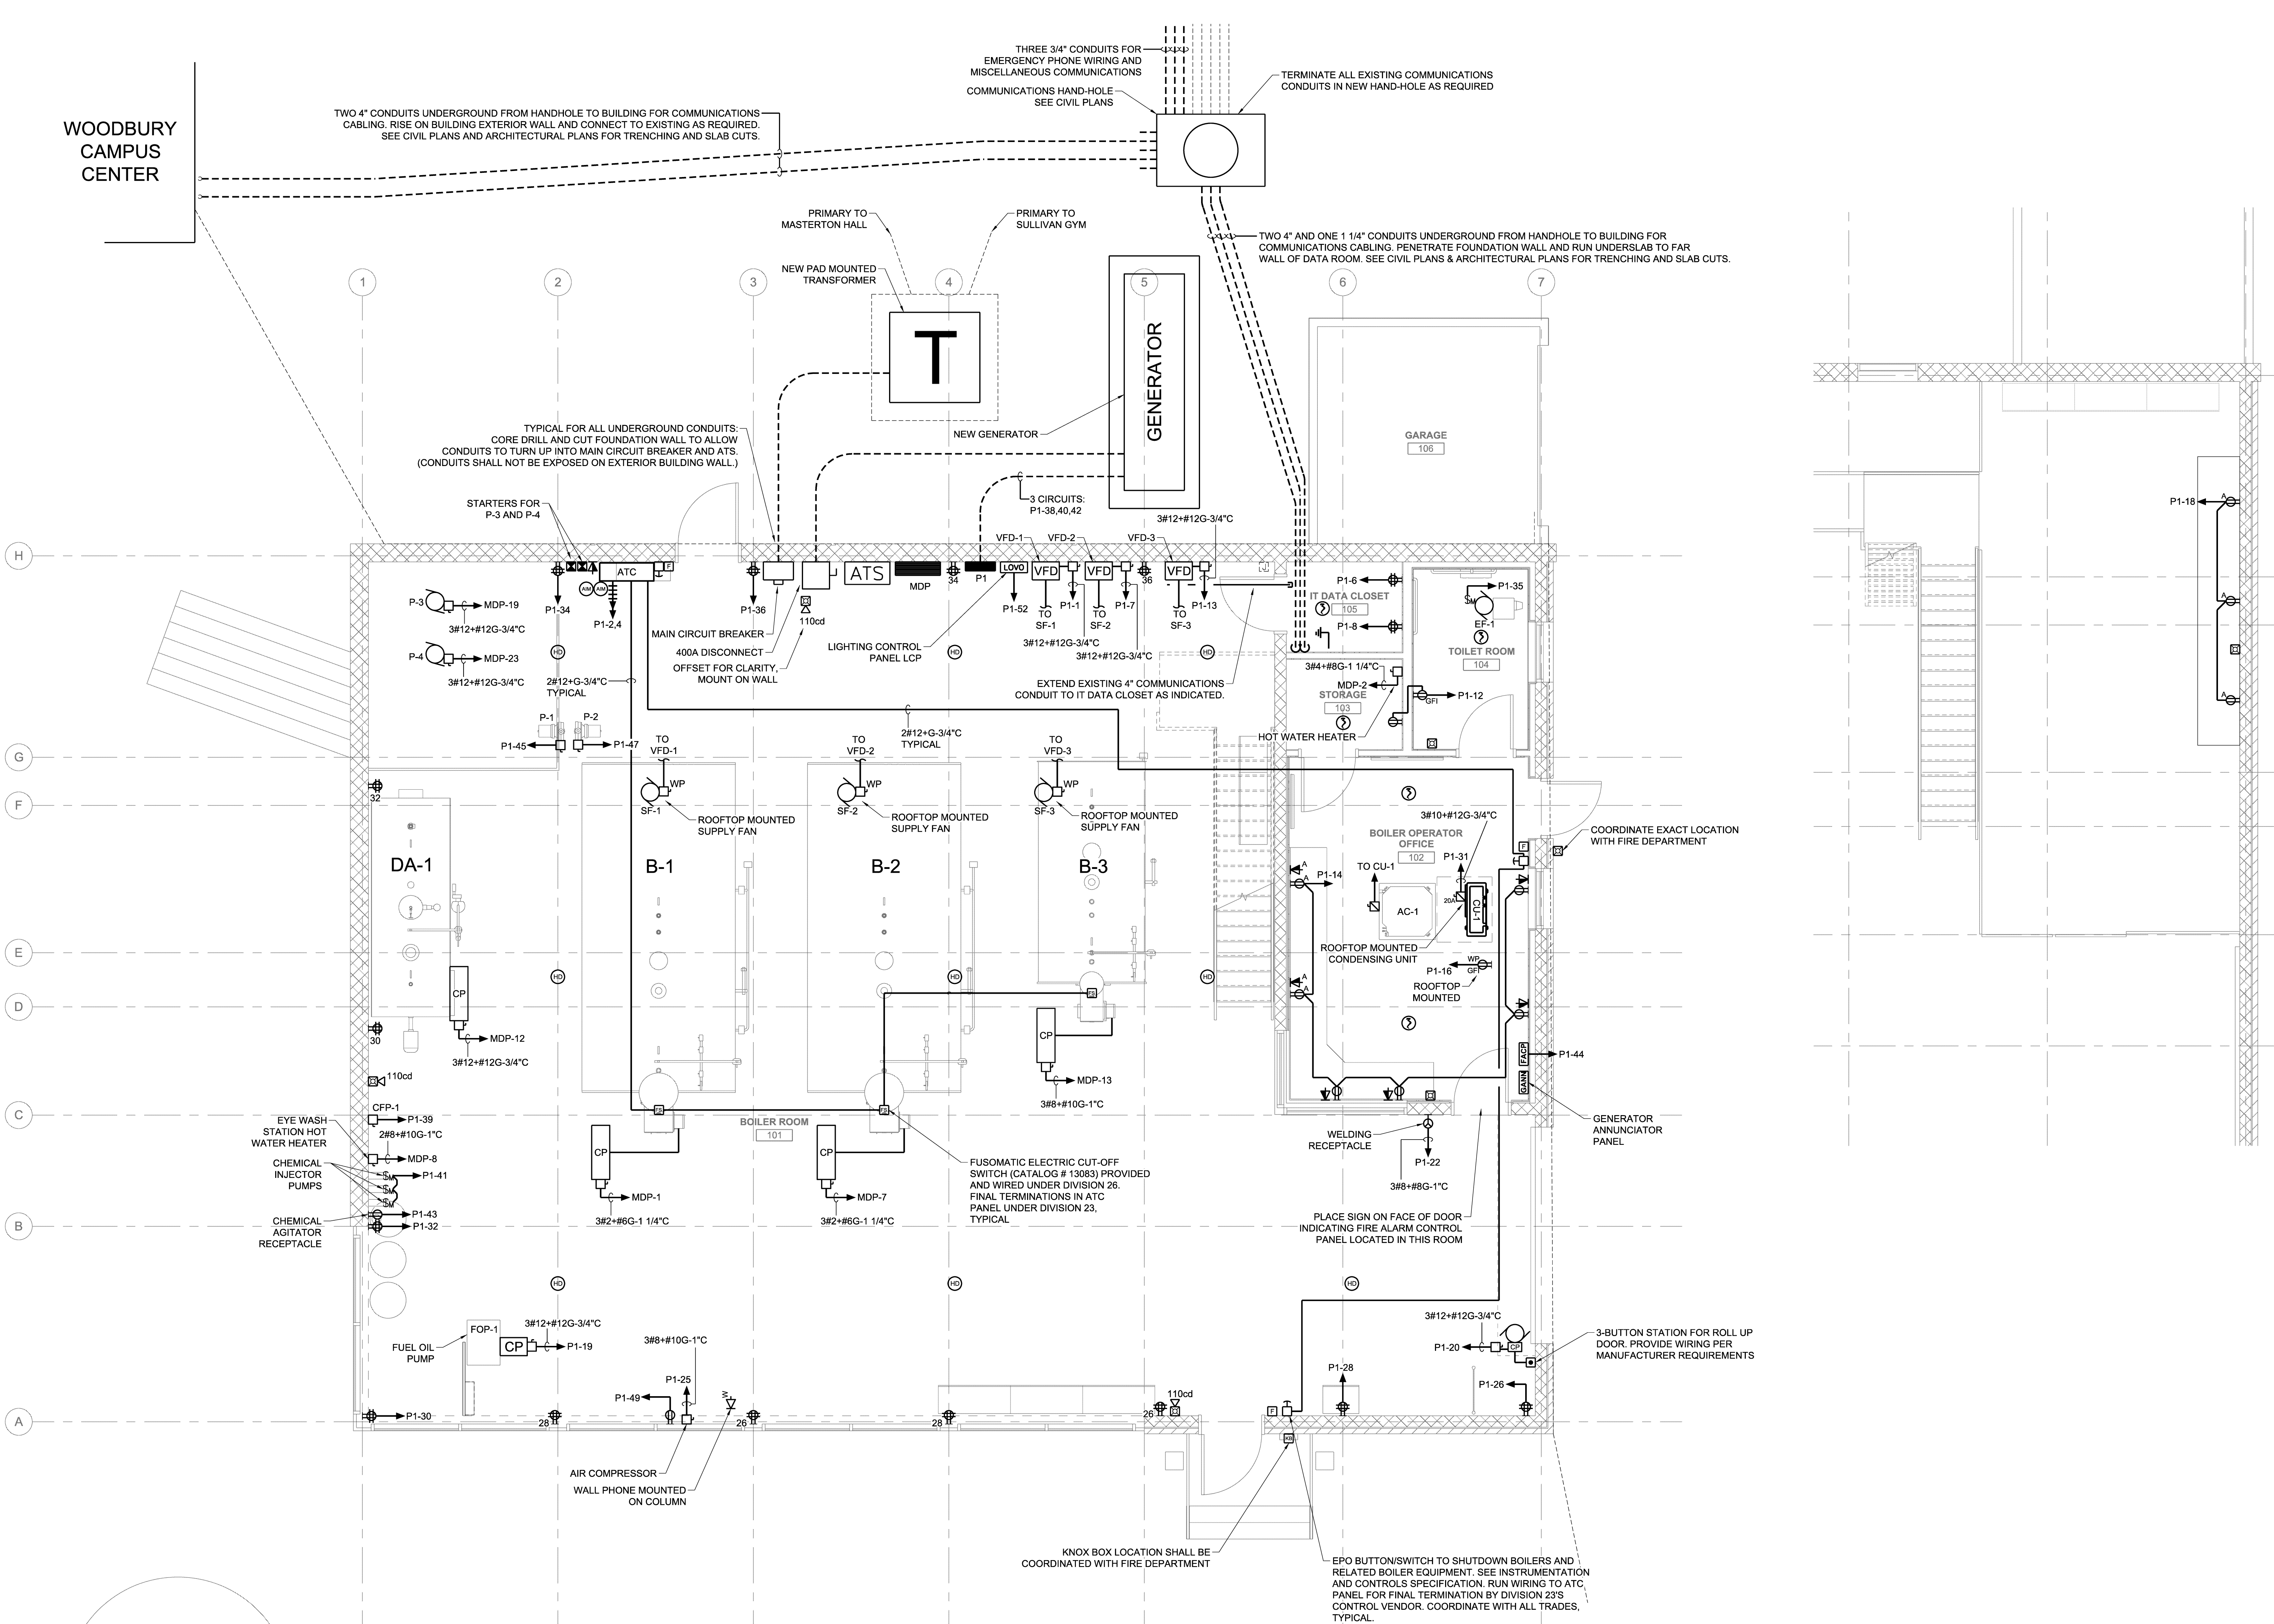

Issues and Revisions		
Mark	Date	Description
-	08-25-14	REVISED SCHEMATIC DESIGN
-	09-05-14	DESIGN DEVELOPMENT
-	09-19-14	PROGRESS REVIEW
-	09-26-14	PROGRESS REVIEW
-	10-03-14	PROGRESS REVIEW
-	10-10-14	FINAL REVIEW
-	10-23-14	100% REVIEW
-	10-31-14	ISSUED FOR BID

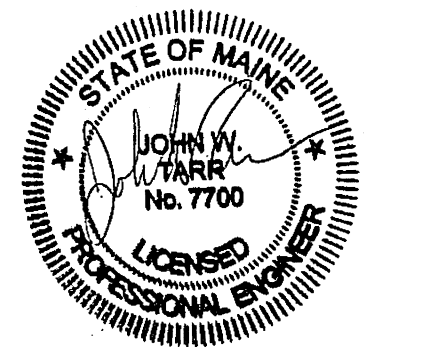

Drawing Scales 1/4" = 1'-0"

PA / PE: JWT © 2014 Harriman Associates  
Drawn By: BSO

POWER AND SYSTEMS FLOOR PLANS

E20.1