

HARRIMAN



AUBURN PORTLAND BANGOR

UNIVERSITY OF SOUTHERN MAINE CENTRAL HEAT PLANT UPGRADES

PORTLAND, ME


Normal Project No. 14411

City Plan

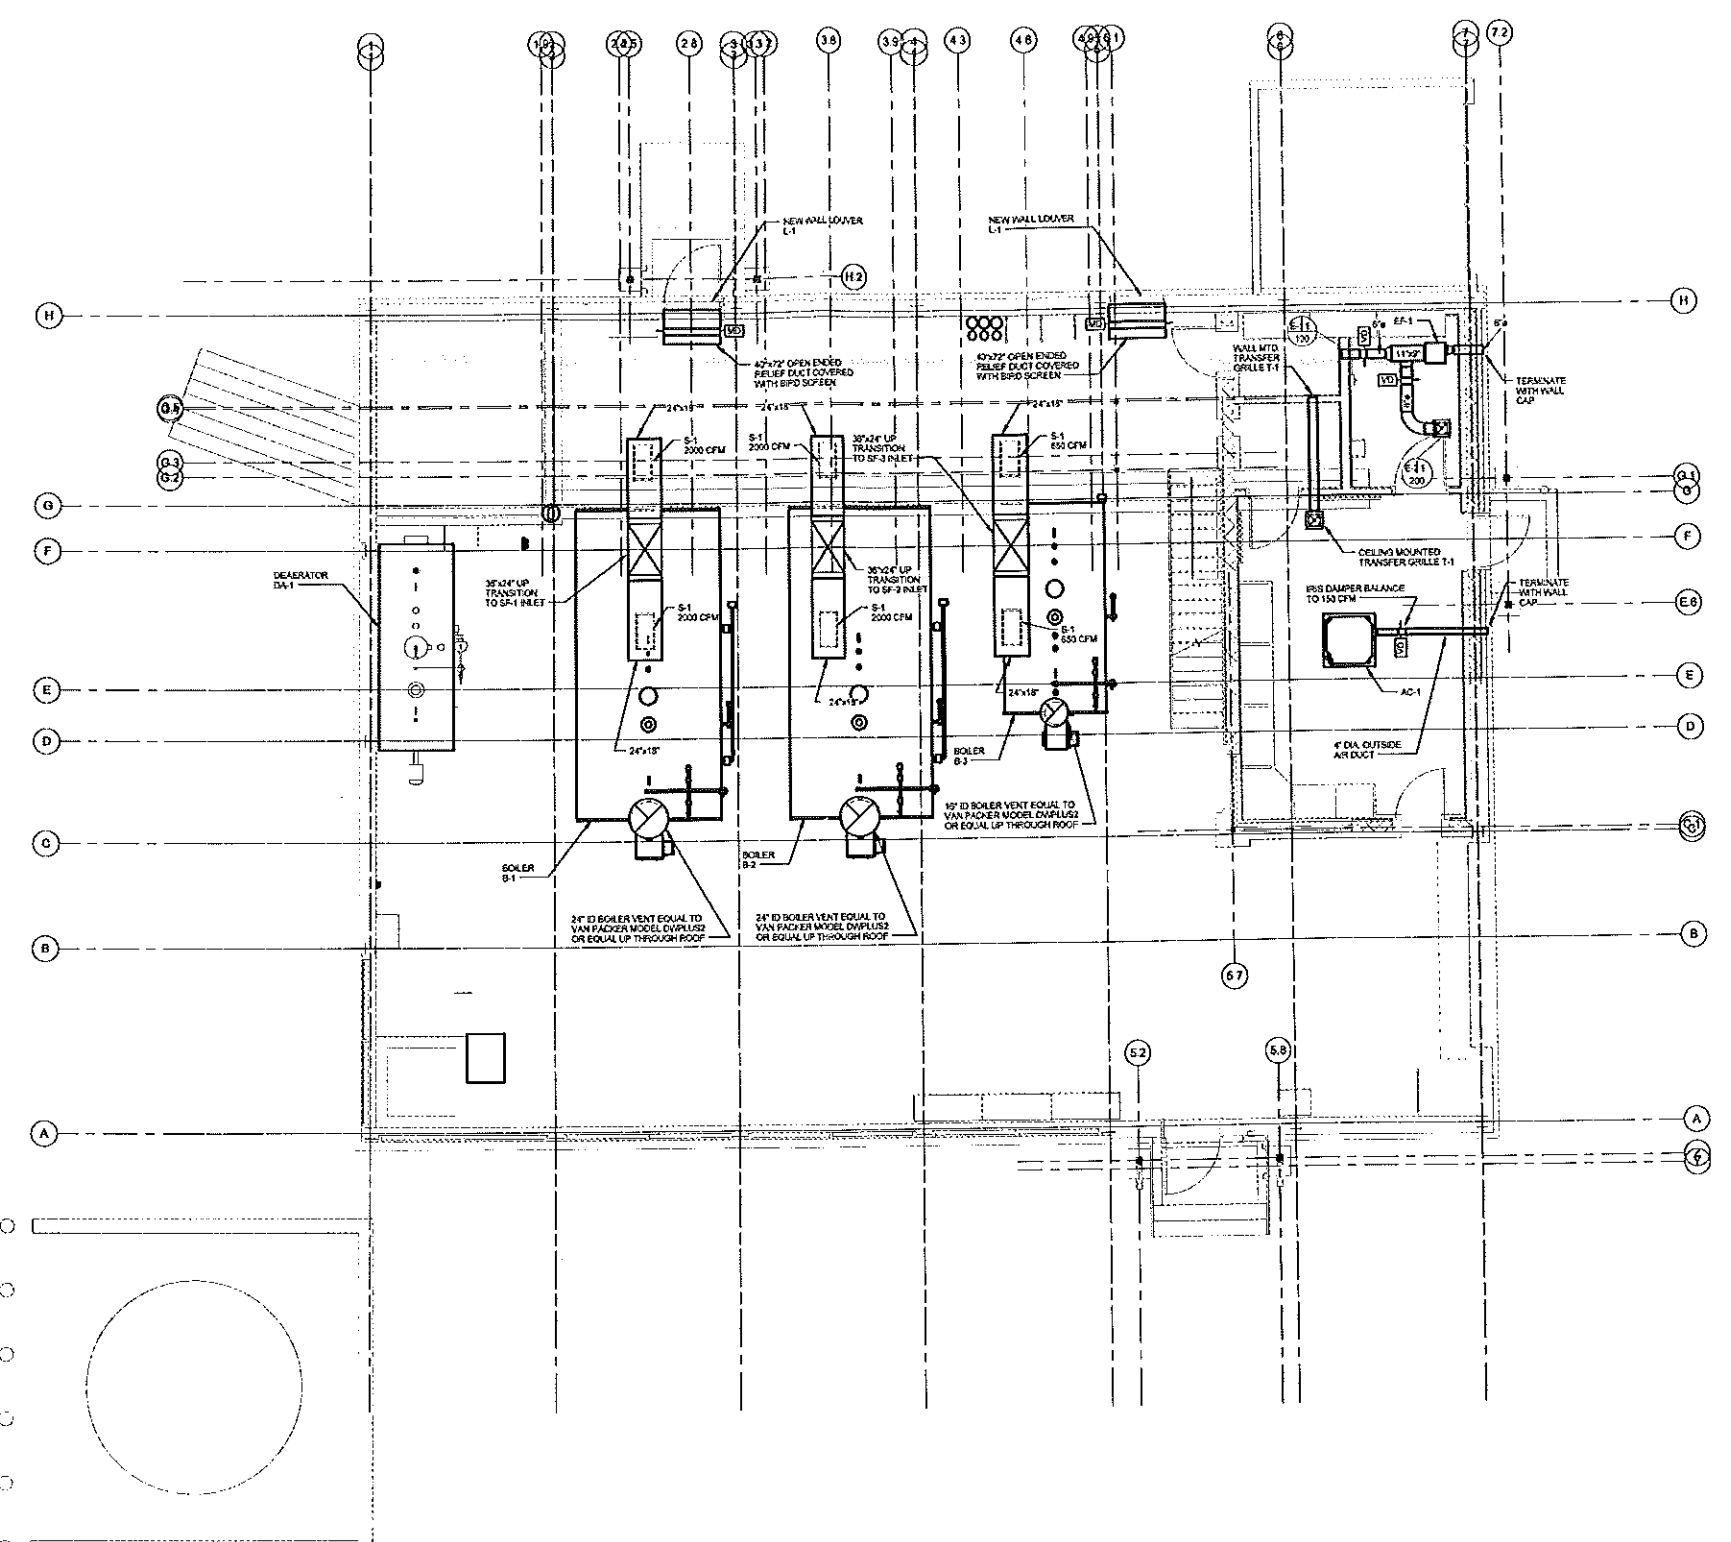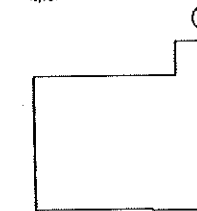

1 FIRST FLOOR DUCTWORK SCALE: 1/4" = 1'-0"

Mark	Code	Description
03-05-14	DESIGN DEVELOPMENT	
05-19-14	PROGRESS REVIEW	
08-25-14	PROGRESS REVIEW	
10-03-14	PROGRESS REVIEW	
10-15-14	FINAL REVIEW	
12-23-14	100% REVIEW	
10-31-14	ISSUED FOR BID	

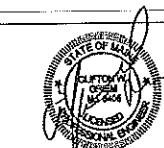

Drawn By: JSL	Checked By:
DATE: 03	DATE: 2014
Drawn By: JSL	Checked By: Harriman Associates

FIRST FLOOR DUCTWORK PLAN

M10.1

Plot Date: 10/20/2014 8:02:38 AM