
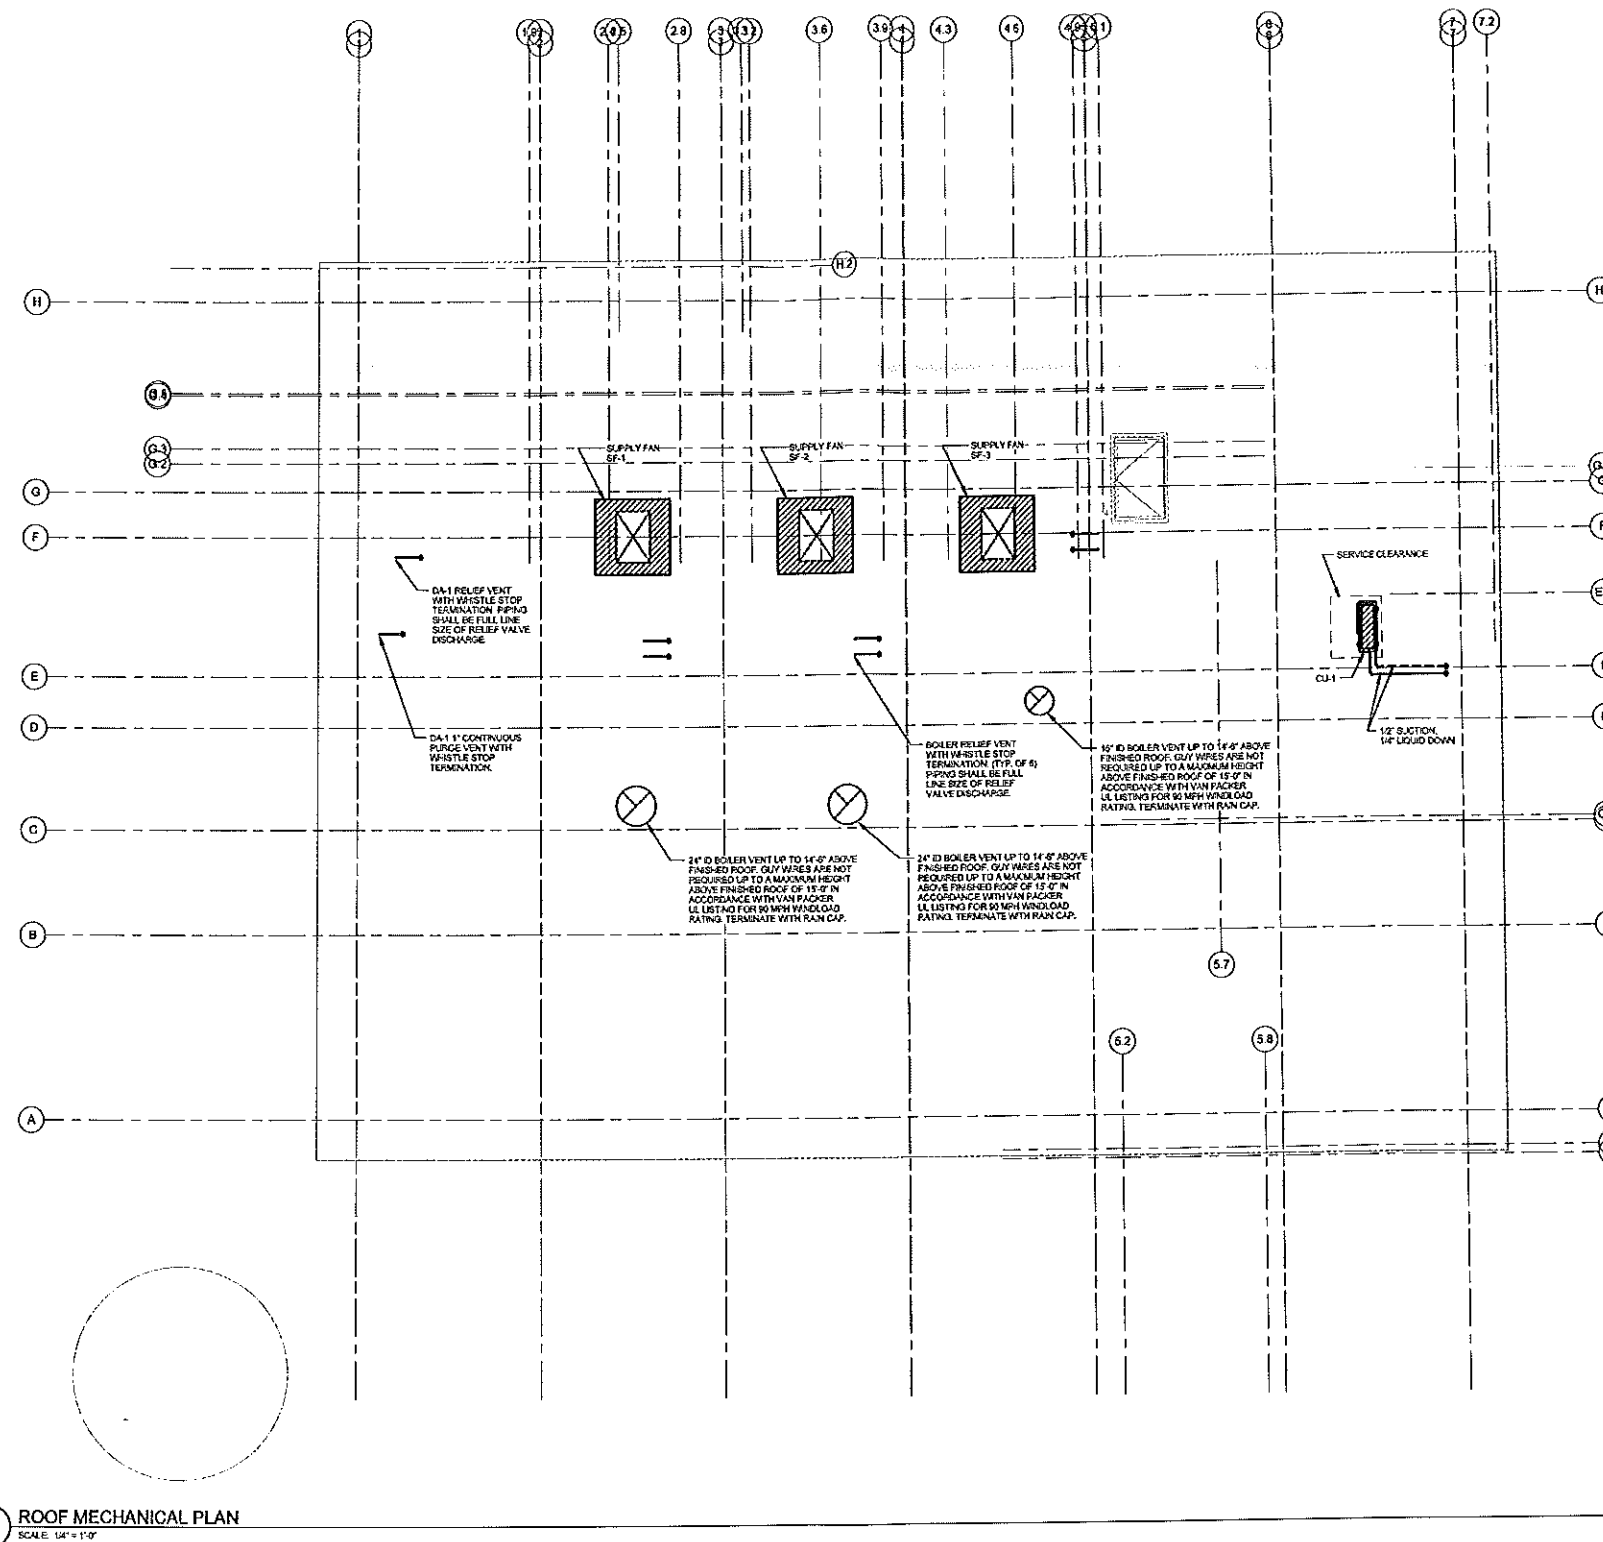


**UNIVERSITY OF SOUTHERN MAINE  
 CENTRAL HEAT PLANT  
 UPGRADES**

PORTLAND, ME


Worksheet Page # No. 14411

Key Plan

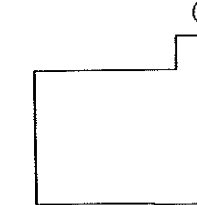

Revisions and Actions

Mark	Date	Description
03-05-14		DESIGN DEVELOPMENT
09-13-14		PROGRESS REVIEW
09-25-14		PROGRESS REVIEW
10-03-14		PROGRESS REVIEW
11-10-14		FINAL REVIEW
12-22-14		100% REVIEW
12-31-14		ISSUED FOR BD

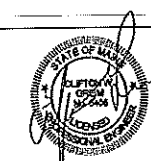

Drawn by	JL	Scale	1/4" = 1'-0"
Checked by			
PA: FE	CO	© 2014	Harriman Associates
Drawn by	JL		

**ROOF MECHANICAL PLAN**

**M10.2**