
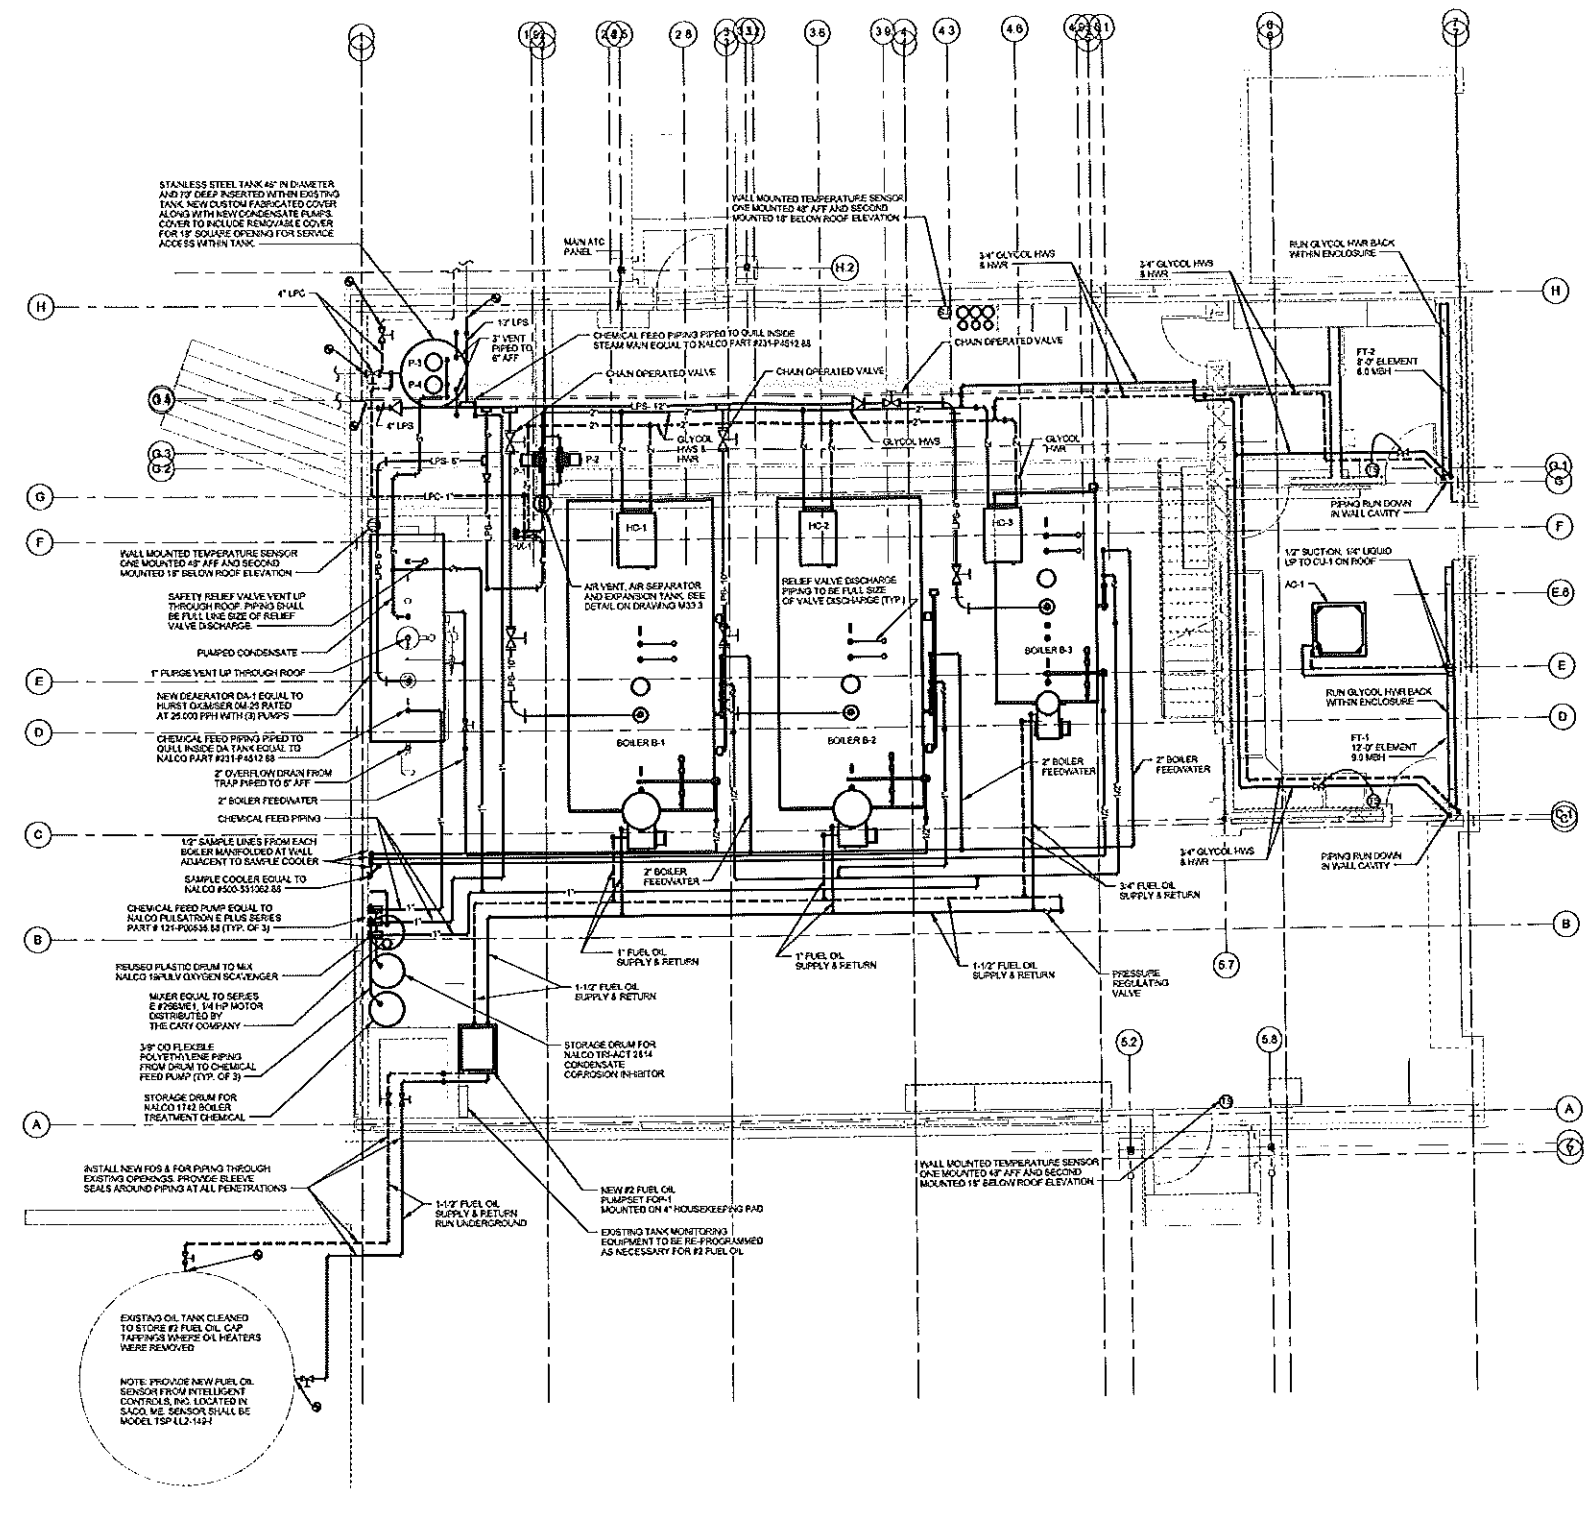


**UNIVERSITY OF SOUTHERN MAINE  
 CENTRAL HEAT PLANT UPGRADES**

PORTLAND, ME

Harriman Project No. 14111

Fig. No. 1

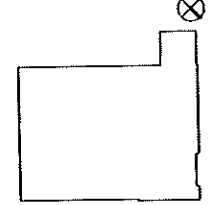


**1 FIRST FLOOR PIPING**  
 SCALE 1/4" = 1'-0"

EXISTING OIL TANK CLEANED TO STORE #2 FUEL OIL. CAP TAKEN OFF WHERE OIL HEATERS WERE REMOVED.

NOTE: PROVIDE NEW FUEL OIL SENSOR FROM INTELLIGENT CONTROLS, INC. LOCATED IN SACO. ME. SENSOR SHALL BE MODEL TSP142-1424.

| Date     | Description              |
|----------|--------------------------|
| 08-13-14 | SCHEMATIC DESIGN         |
| 08-25-14 | REVISED SCHEMATIC DESIGN |
| 09-25-14 | DESIGN DEVELOPMENT       |
| 09-18-14 | PROGRESS REVIEW          |
| 09-25-14 | PROGRESS REVIEW          |
| 10-03-14 | PROGRESS REVIEW          |
| 10-10-14 | FINAL REVIEW             |
| 10-23-14 | 100% REVIEW              |
| 10-31-14 | ISSUED FOR BID           |

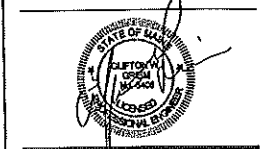

|               |              |
|---------------|--------------|
| Drawing Scale | 1/4" = 1'-0" |
| DATE          | 03/14        |
| Drawn by      | JSL          |

**FIRST FLOOR PIPING PLAN**

**M20.1**