




**3-5/8" MTL STUD FULL HGT** NA  
 WALL FINISHES VARY - COORDINATE W/ FINISH SCHEDULE ON SHEET AE640

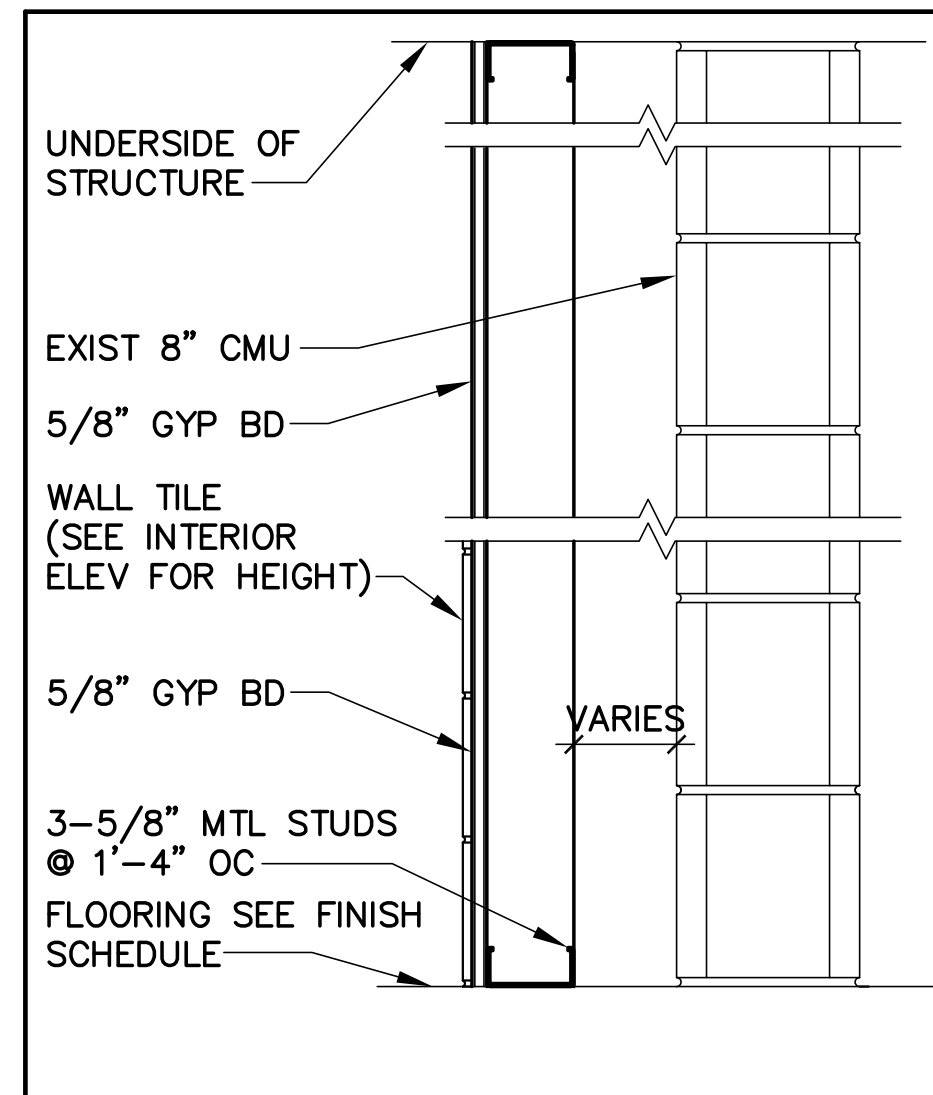

**CMU & MTL STUD CHASE WALL W/ WALL TILE** NB

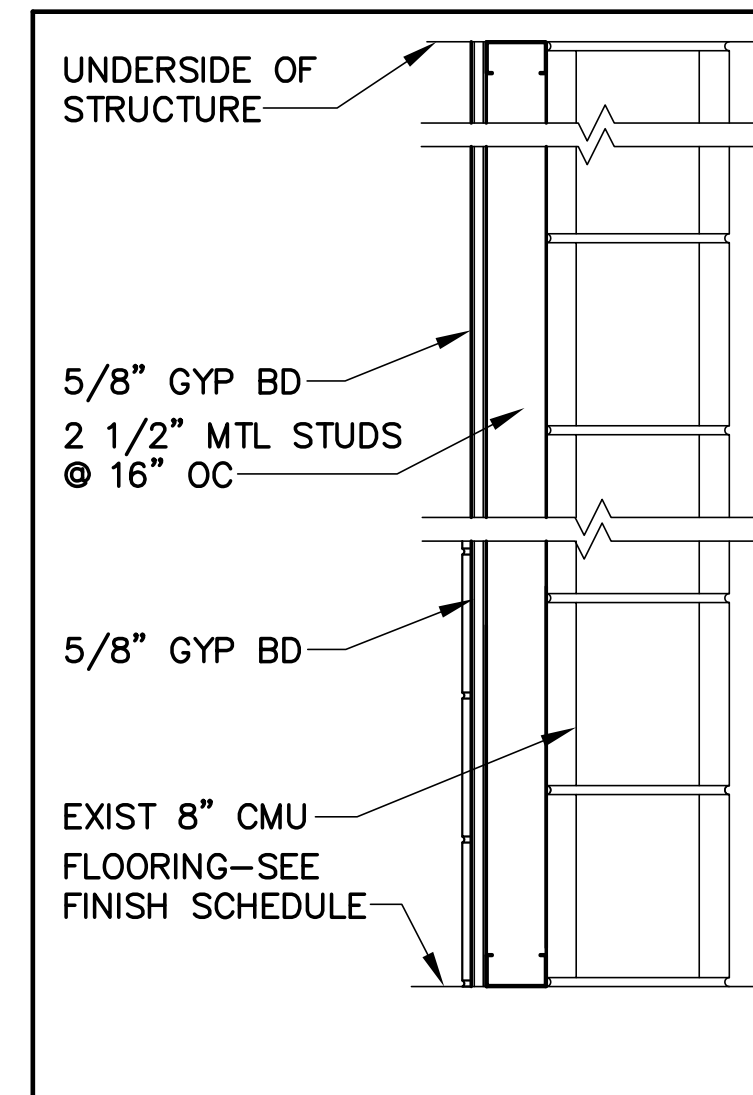


**MTL STUD FURRING W/ WALL TILE** NC

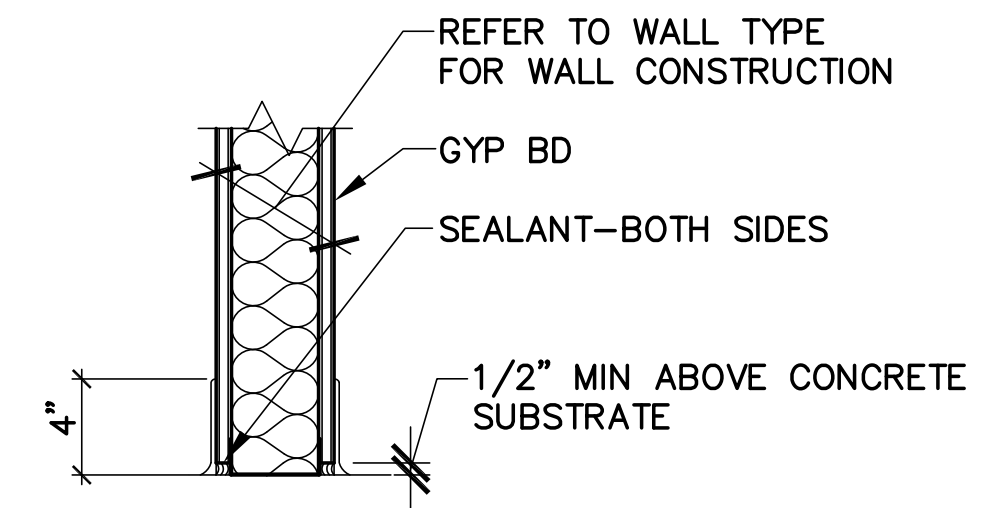

**1 TYPICAL GYPSUM BOARD SILL DETAIL**  
 AE001 AE001 SCALE: 1-1/2"=1'-0"

**STANDARD MOUNTING HEIGHTS:**

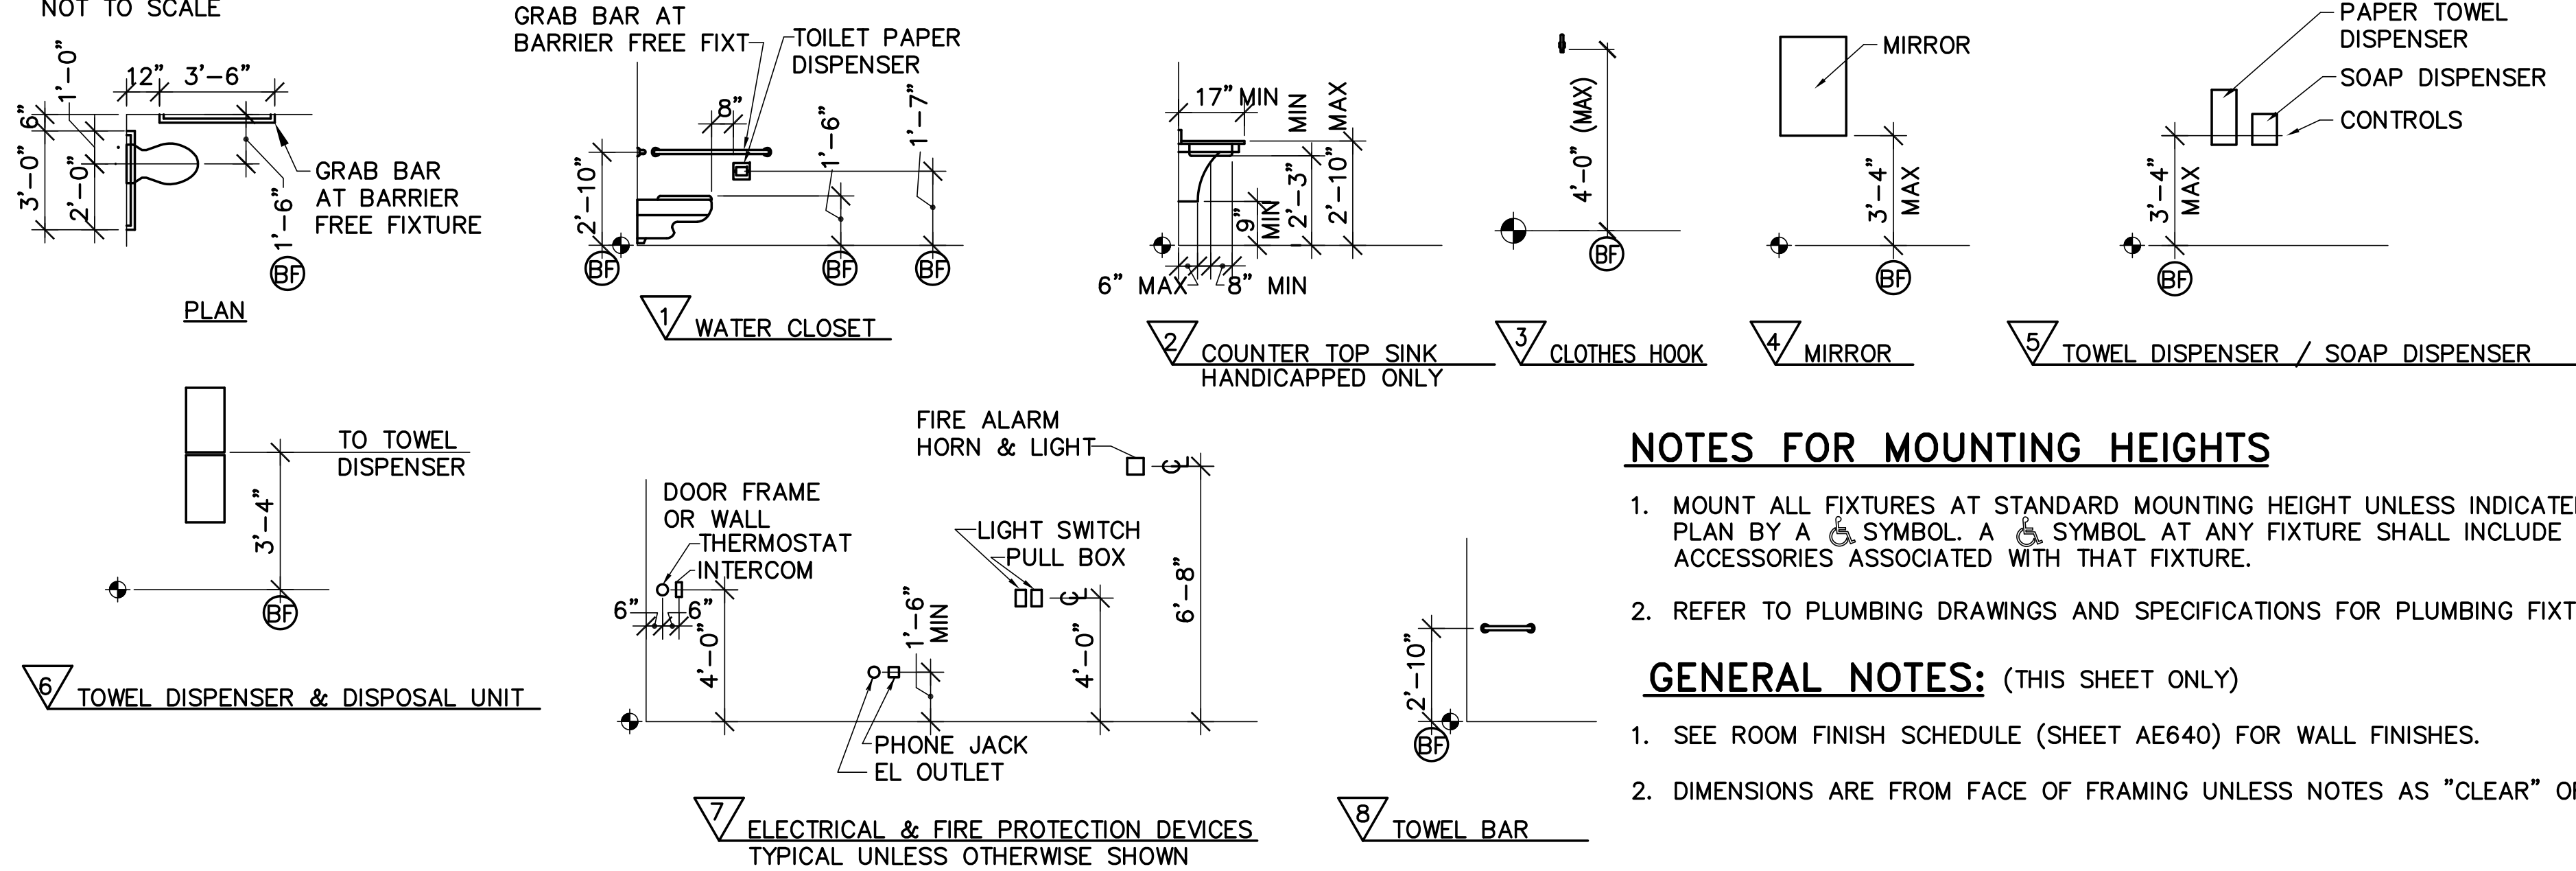


**NOTES FOR MOUNTING HEIGHTS**


1. MOUNT ALL FIXTURES AT STANDARD MOUNTING HEIGHT UNLESS INDICATED ON PLAN BY A SYMBOL. A SYMBOL AT ANY FIXTURE SHALL INCLUDE ALL ACCESSORIES ASSOCIATED WITH THAT FIXTURE.
2. REFER TO PLUMBING DRAWINGS AND SPECIFICATIONS FOR PLUMBING FIXTURES.

**GENERAL NOTES: (THIS SHEET ONLY)**


1. SEE ROOM FINISH SCHEDULE (SHEET AE640) FOR WALL FINISHES.
2. DIMENSIONS ARE FROM FACE OF FRAMING UNLESS NOTES AS "CLR" OR "CLR".

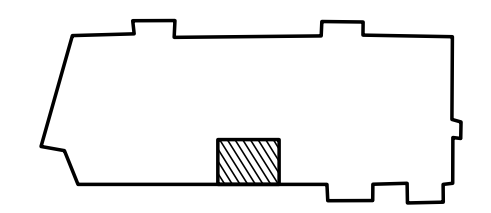

**KEYPLAN**  
 NOT TO SCALE PLAN NORTH

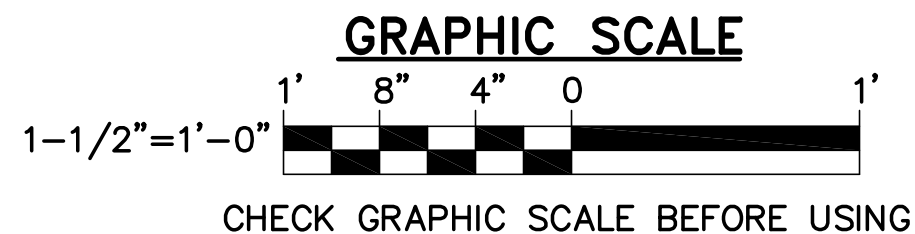

CHECK GRAPHIC SCALE BEFORE USING

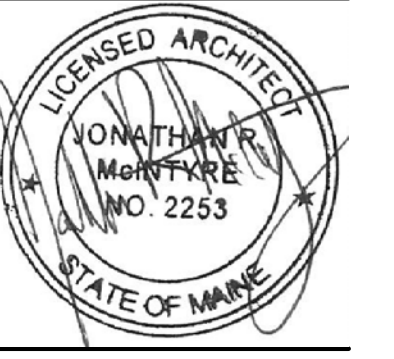

DESIGNED BY: JMC  
 DRAWN BY: CAM  
 CHECKED BY: JMC  
 PROJECT: 21702.09

**UNIVERSITY OF SOUTHERN MAINE  
 PORTLAND, MAINE**  
 Woodbury Campus Center  
 35 Bedford Street  
 Portland, ME 04101  
 T (207) 750-4160

**WOODBURY CAMPUS CENTER  
 BATHROOM ADDITION**  
 Portland, Maine

**WALL TYPES,  
 DETAILS, AND  
 MOUNTING  
 HEIGHTS**

SCALE: AS NOTED  
 DATE: 06-30-17

DWG.: **AE001**

SHEET: **3** OF **12**