



DESIGNED BY: KAO  
 DRAWN BY: RSW  
 CHECKED BY: KAO  
 PROJECT: 21702.09

**UNIVERSITY OF SOUTHERN MAINE**  
**PORTLAND, MAINE**  
 Woodbury Campus Center  
 35 Bedford Street  
 Portland, ME 04101  
 T (207) 750-4160

**WOODBURY CAMPUS CENTER**  
**BATHROOM ADDITION**  
 Portland, Maine

**PARTIAL ELECTRICAL PLANS**

SCALE: AS NOTED  
 DATE: 06-30-17

DWG.: **E-101**

SHEET: **12** OF **12**

**GENERAL SHEET NOTES**


- REFER TO SHEET E-001 FOR LIGHTING FIXTURE SCHEDULE AND PANELBOARD SCHEDULE.

**REMOVALS KEYNOTE**


- DISCONNECT FAN ON ROOF, PROTECT WIRING AND CONDUIT FOR RE-USE.

**INSTALLATION KEYNOTES**


- PROVIDE CONNECTION TO FAN ON ROOF. REUSE EXISTING CIRCUIT TO PANELBOARD A. VERIFY CIRCUIT IN FIELD.
- PROVIDE STROBE COMPATIBLE WITH HONEYWELL SFP-50D FACP, CONNECT TO EXISTING ZONE. FOR MALL AREA, A2.

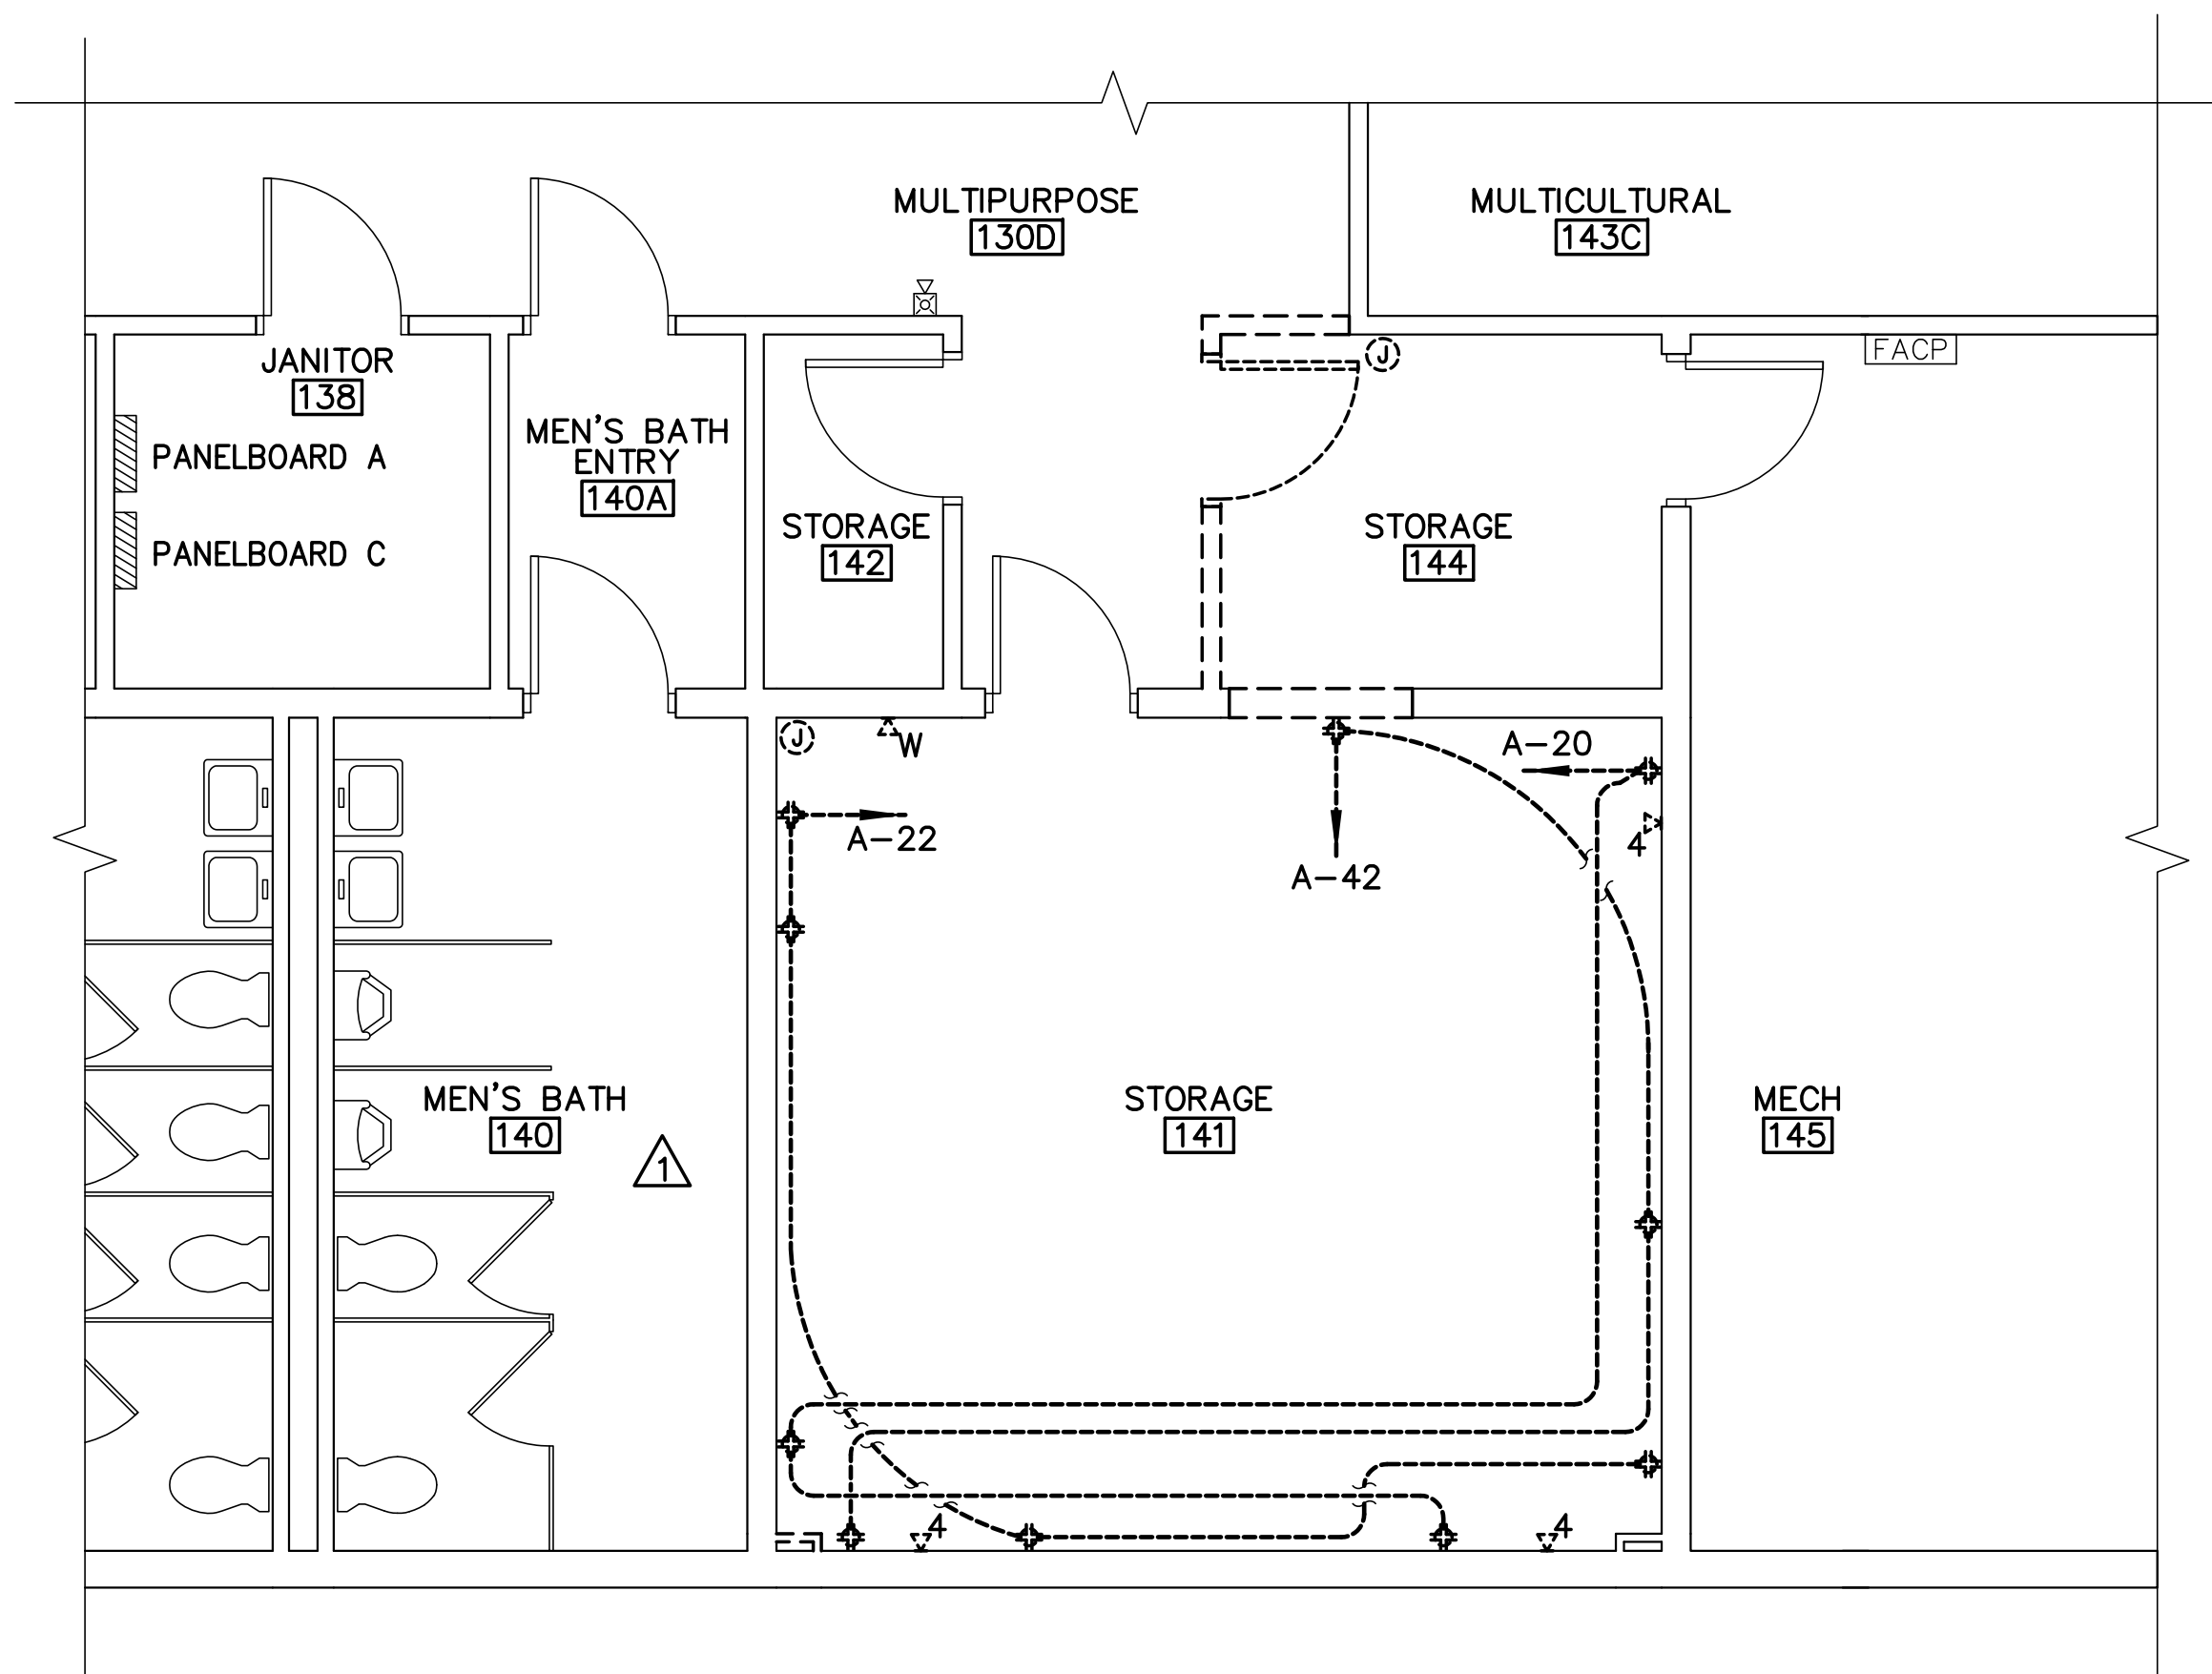


**1 PARTIAL ELECTRICAL REMOVALS PLAN**  
 E-101 SCALE: 1/4"=1'-0"

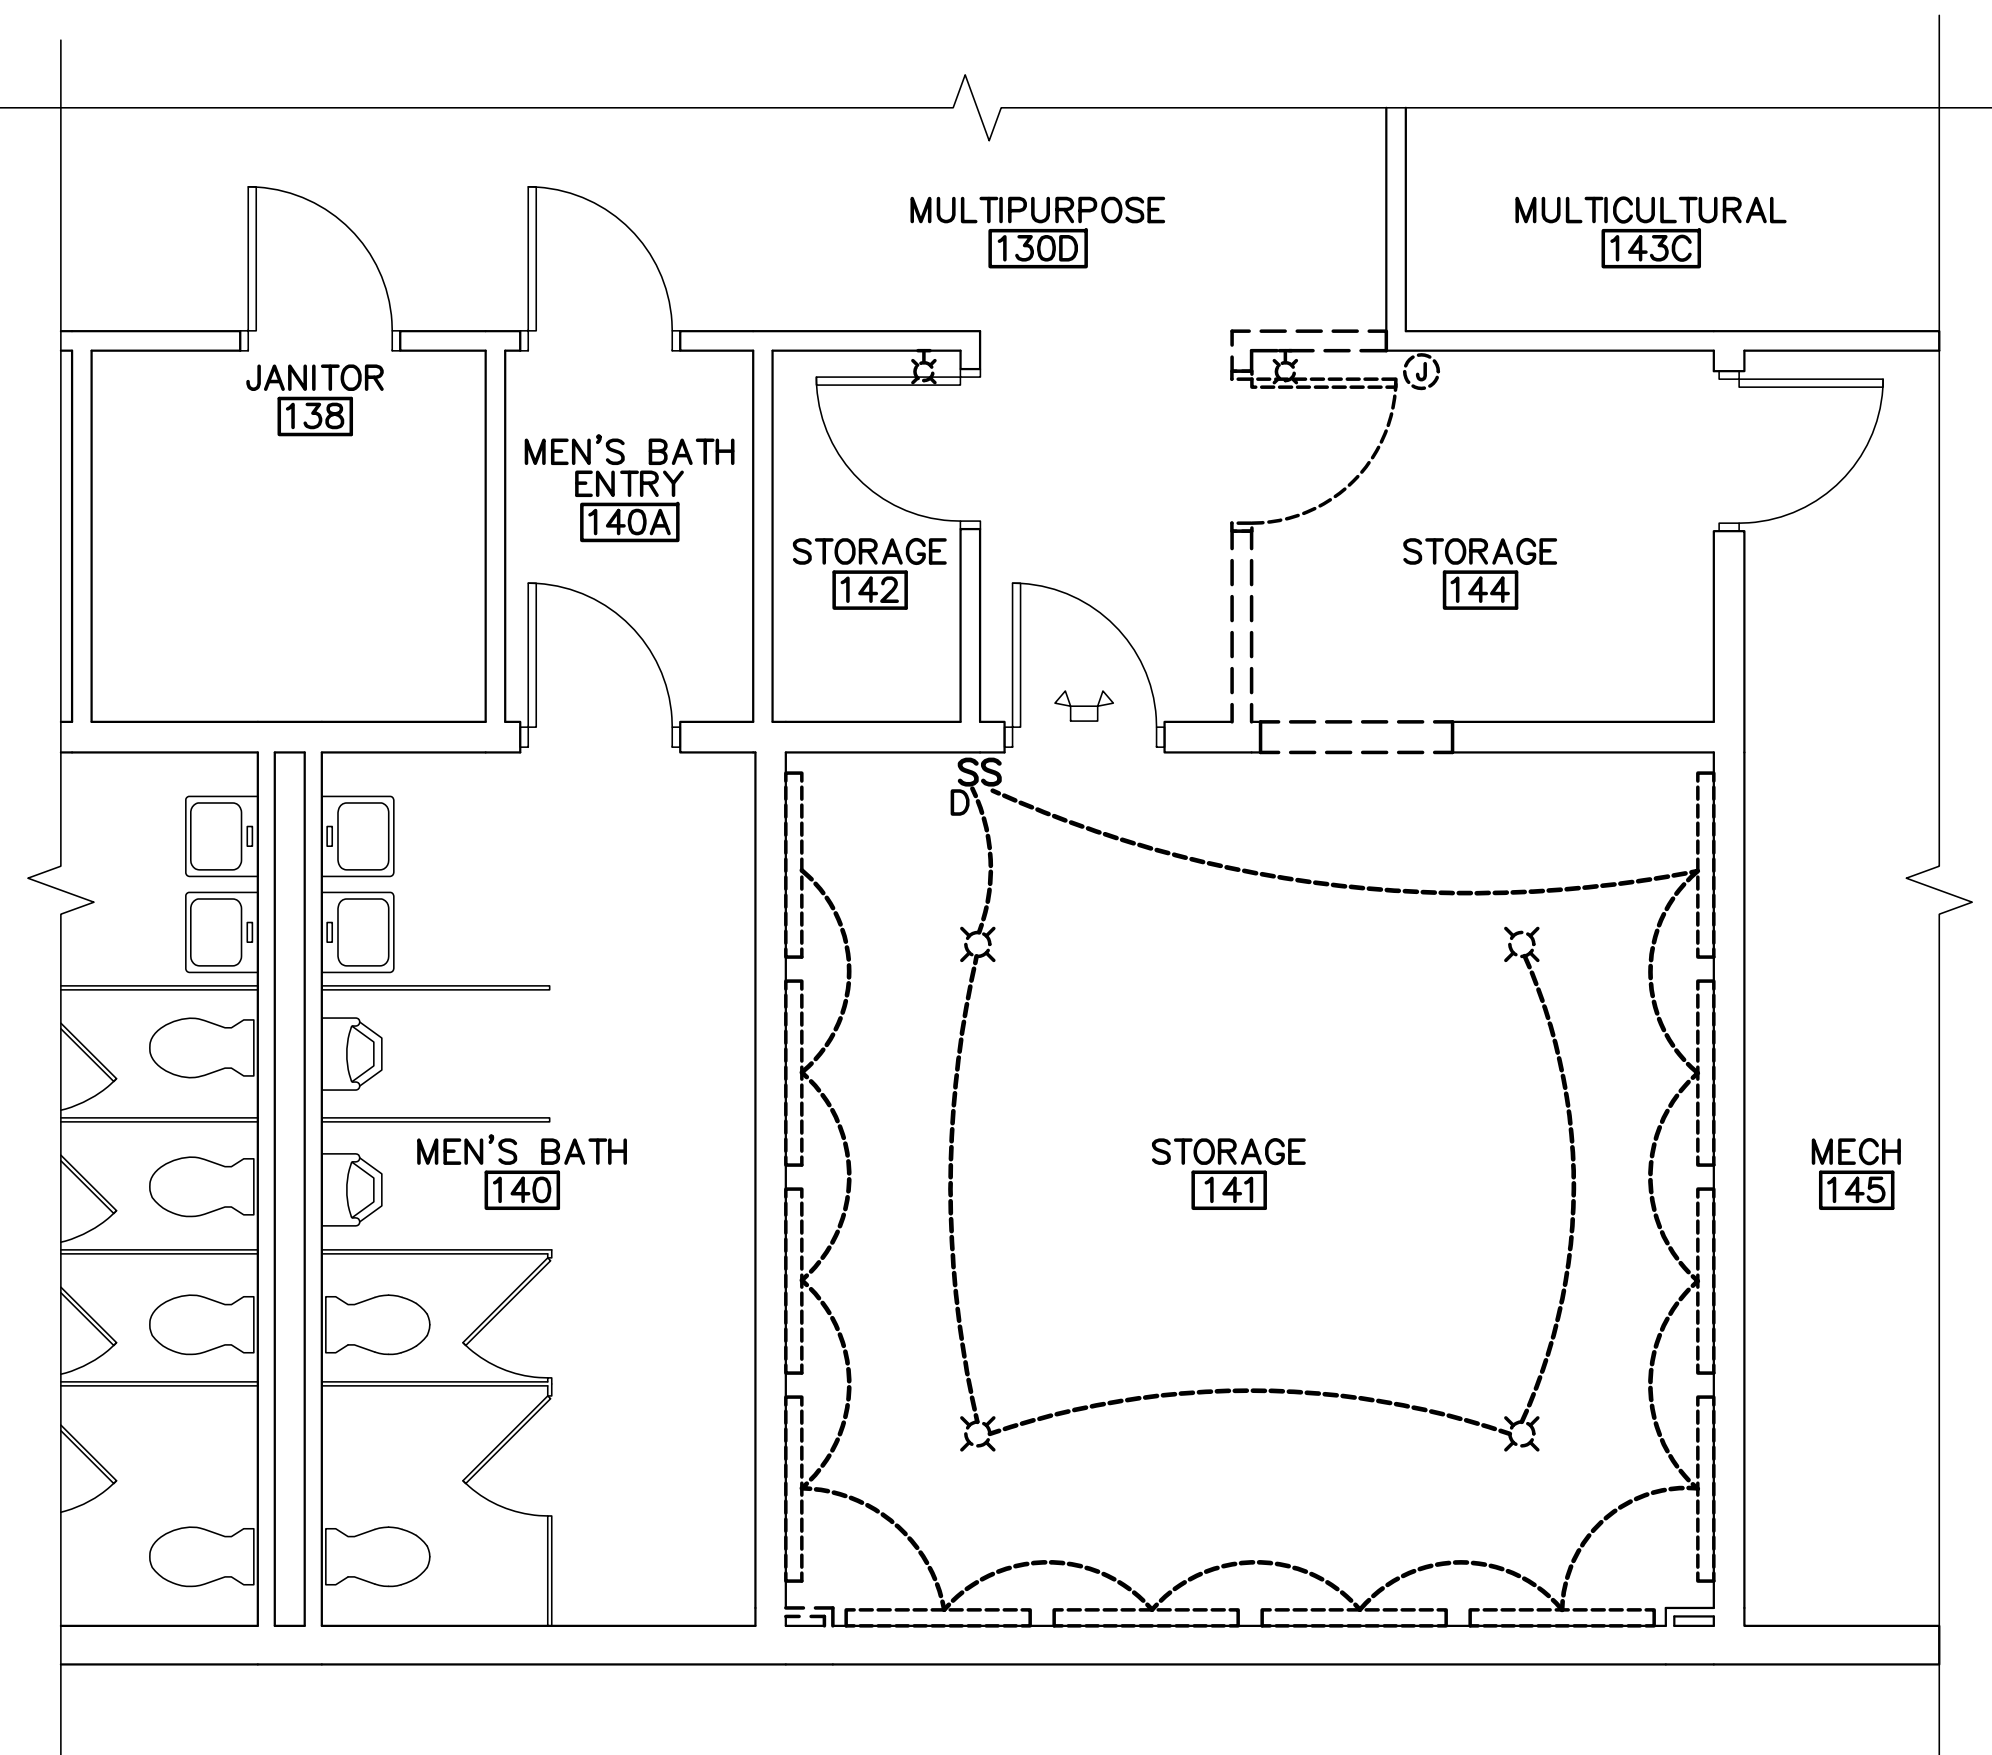



**2 PARTIAL LIGHTING REMOVALS PLAN**  
 E-101 SCALE: 1/4"=1'-0"

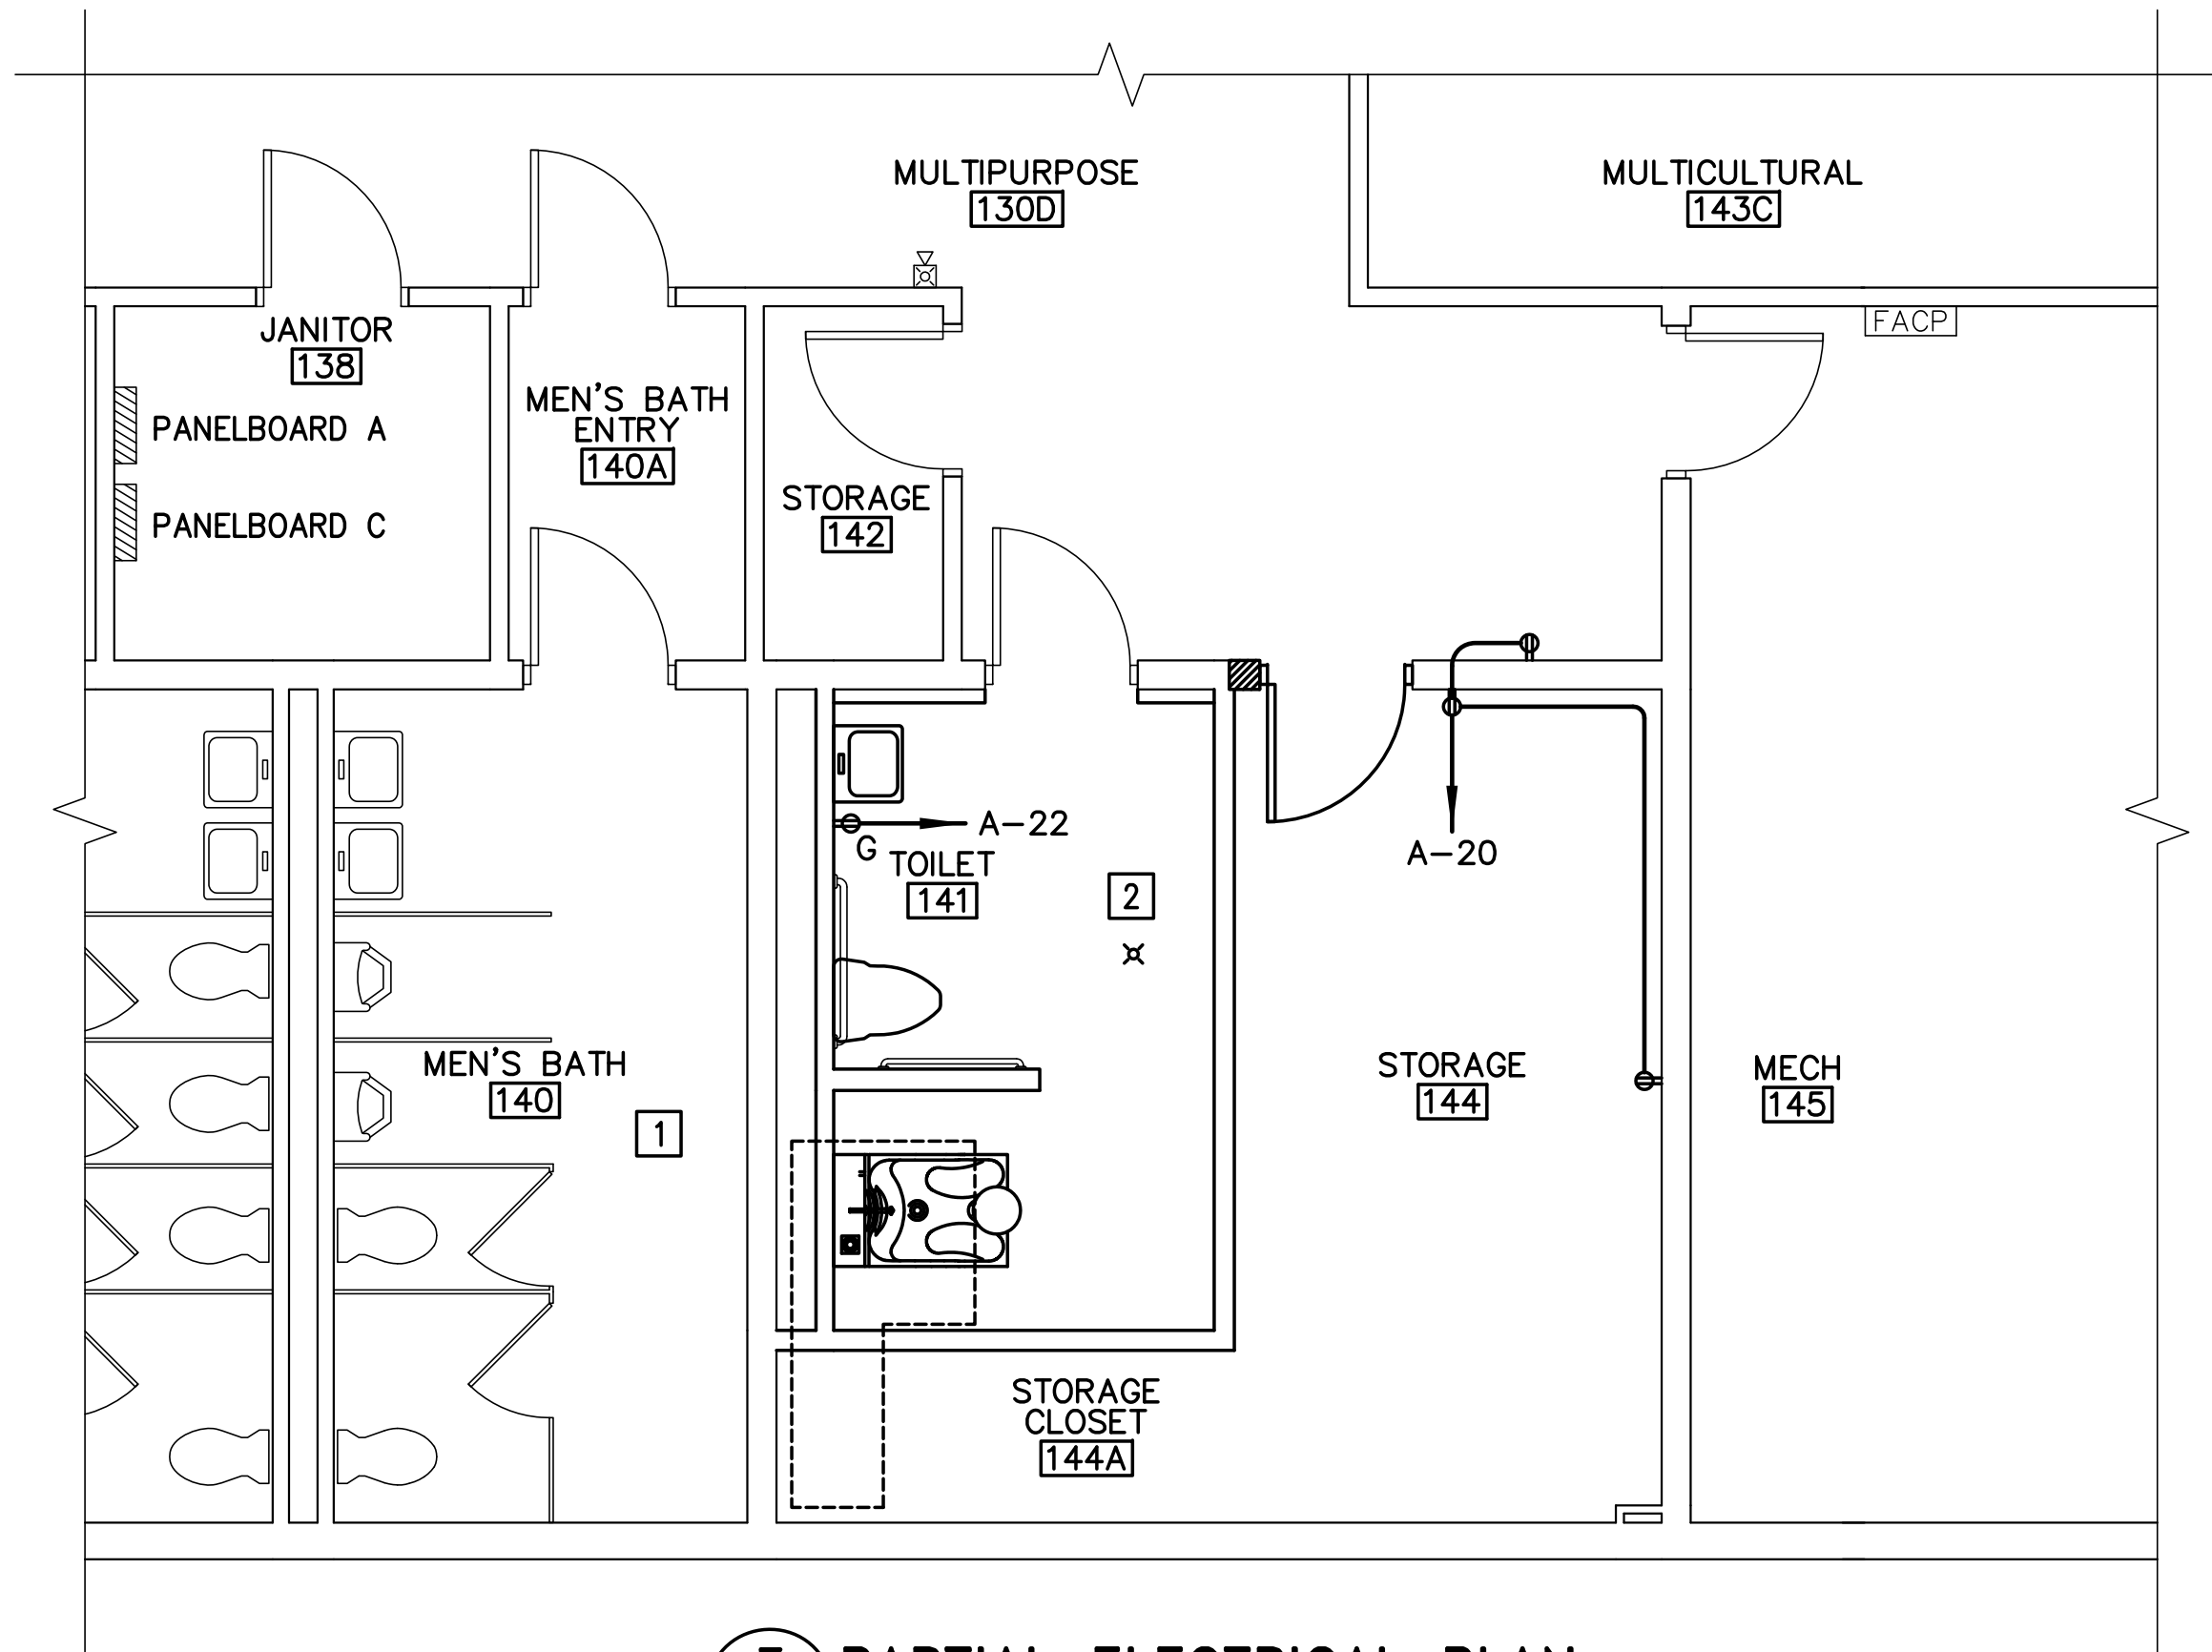

**3 PARTIAL ELECTRICAL PLAN**  
 E-101 SCALE: 1/4"=1'-0"

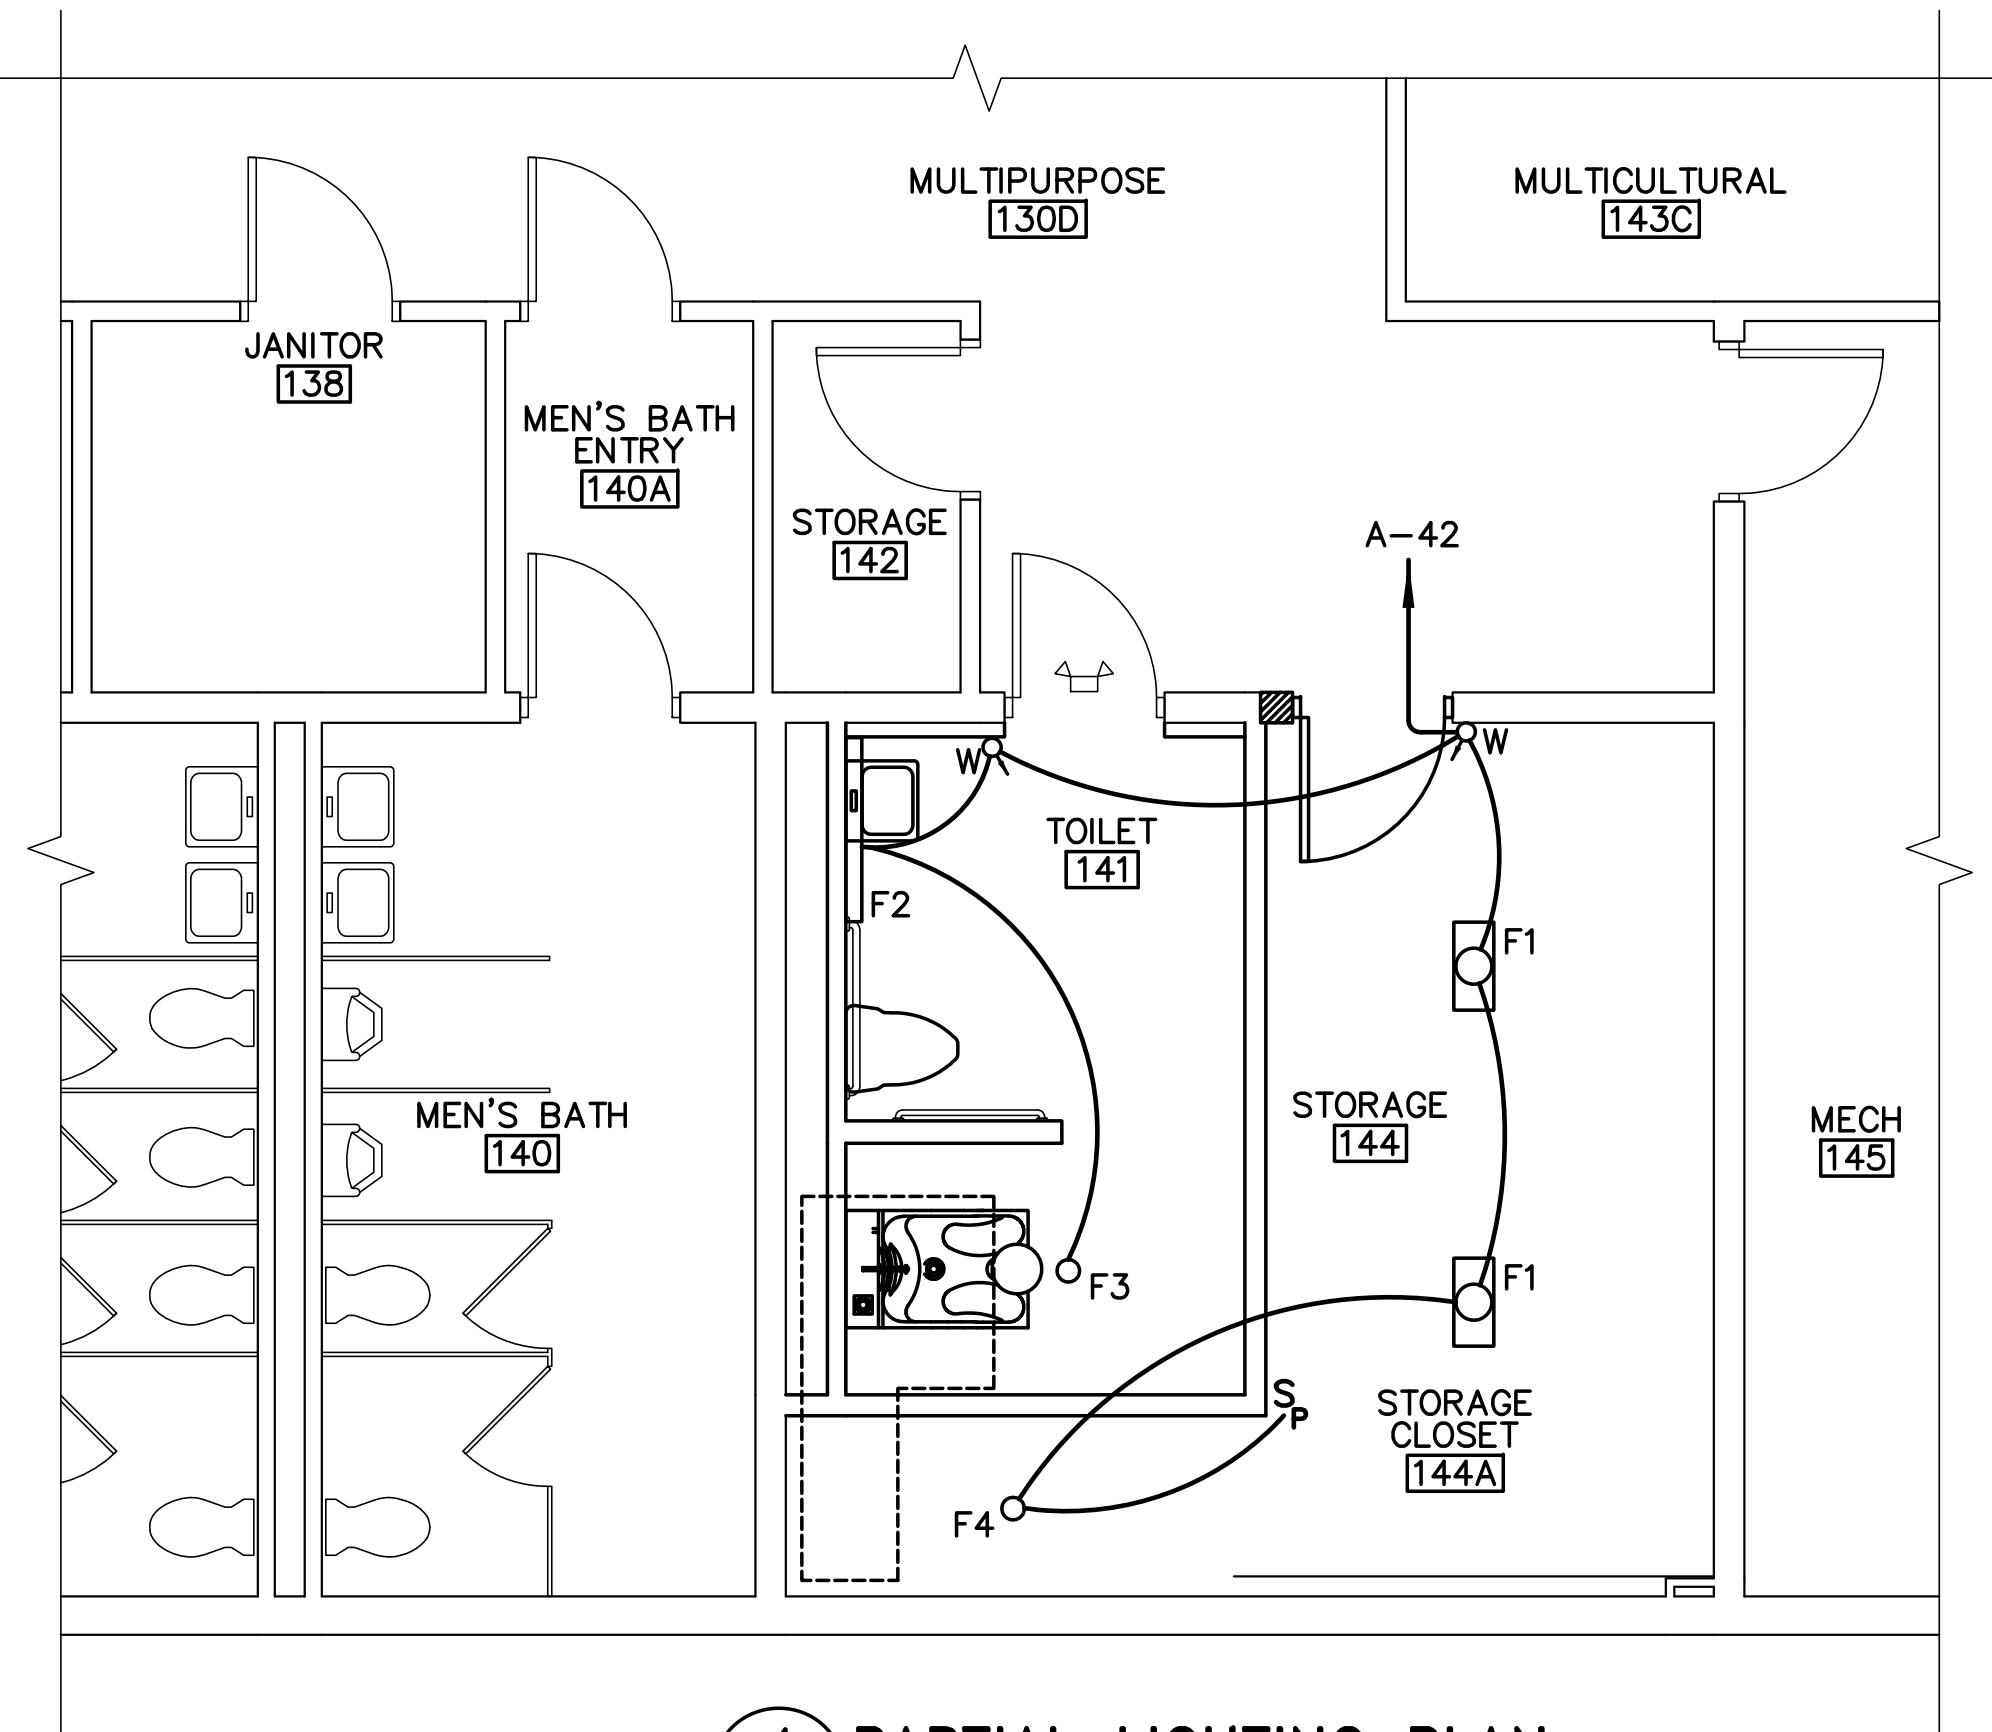

**4 PARTIAL LIGHTING PLAN**  
 E-101 SCALE: 1/4"=1'-0"

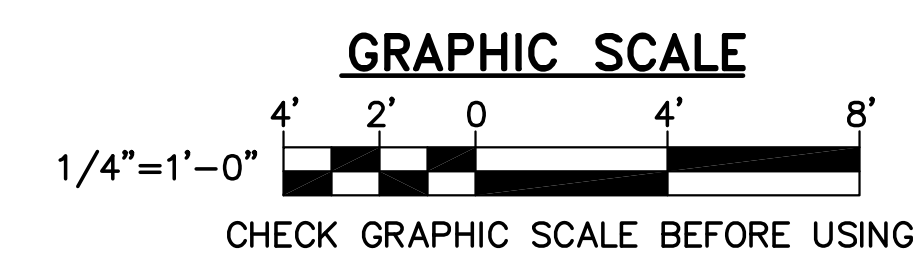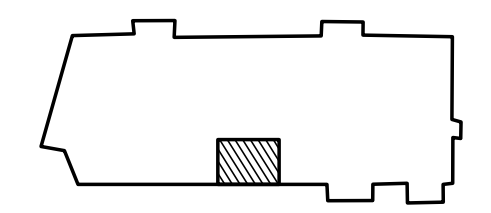

CHECK GRAPHIC SCALE BEFORE USING