



MECHANICAL NOTES
 1. DUCTWORK SHALL BE CONSTRUCTED AND SEALED IN ACCORDANCE WITH SMACNA STANDARDS.
 2. BRANCH DUCTS SHALL INCLUDE BALANCING DAMPERS.
 3. SUPPLY DUCTWORK SHALL BE INSULATED PER ASHRAE 90.1 AND IECC 2012

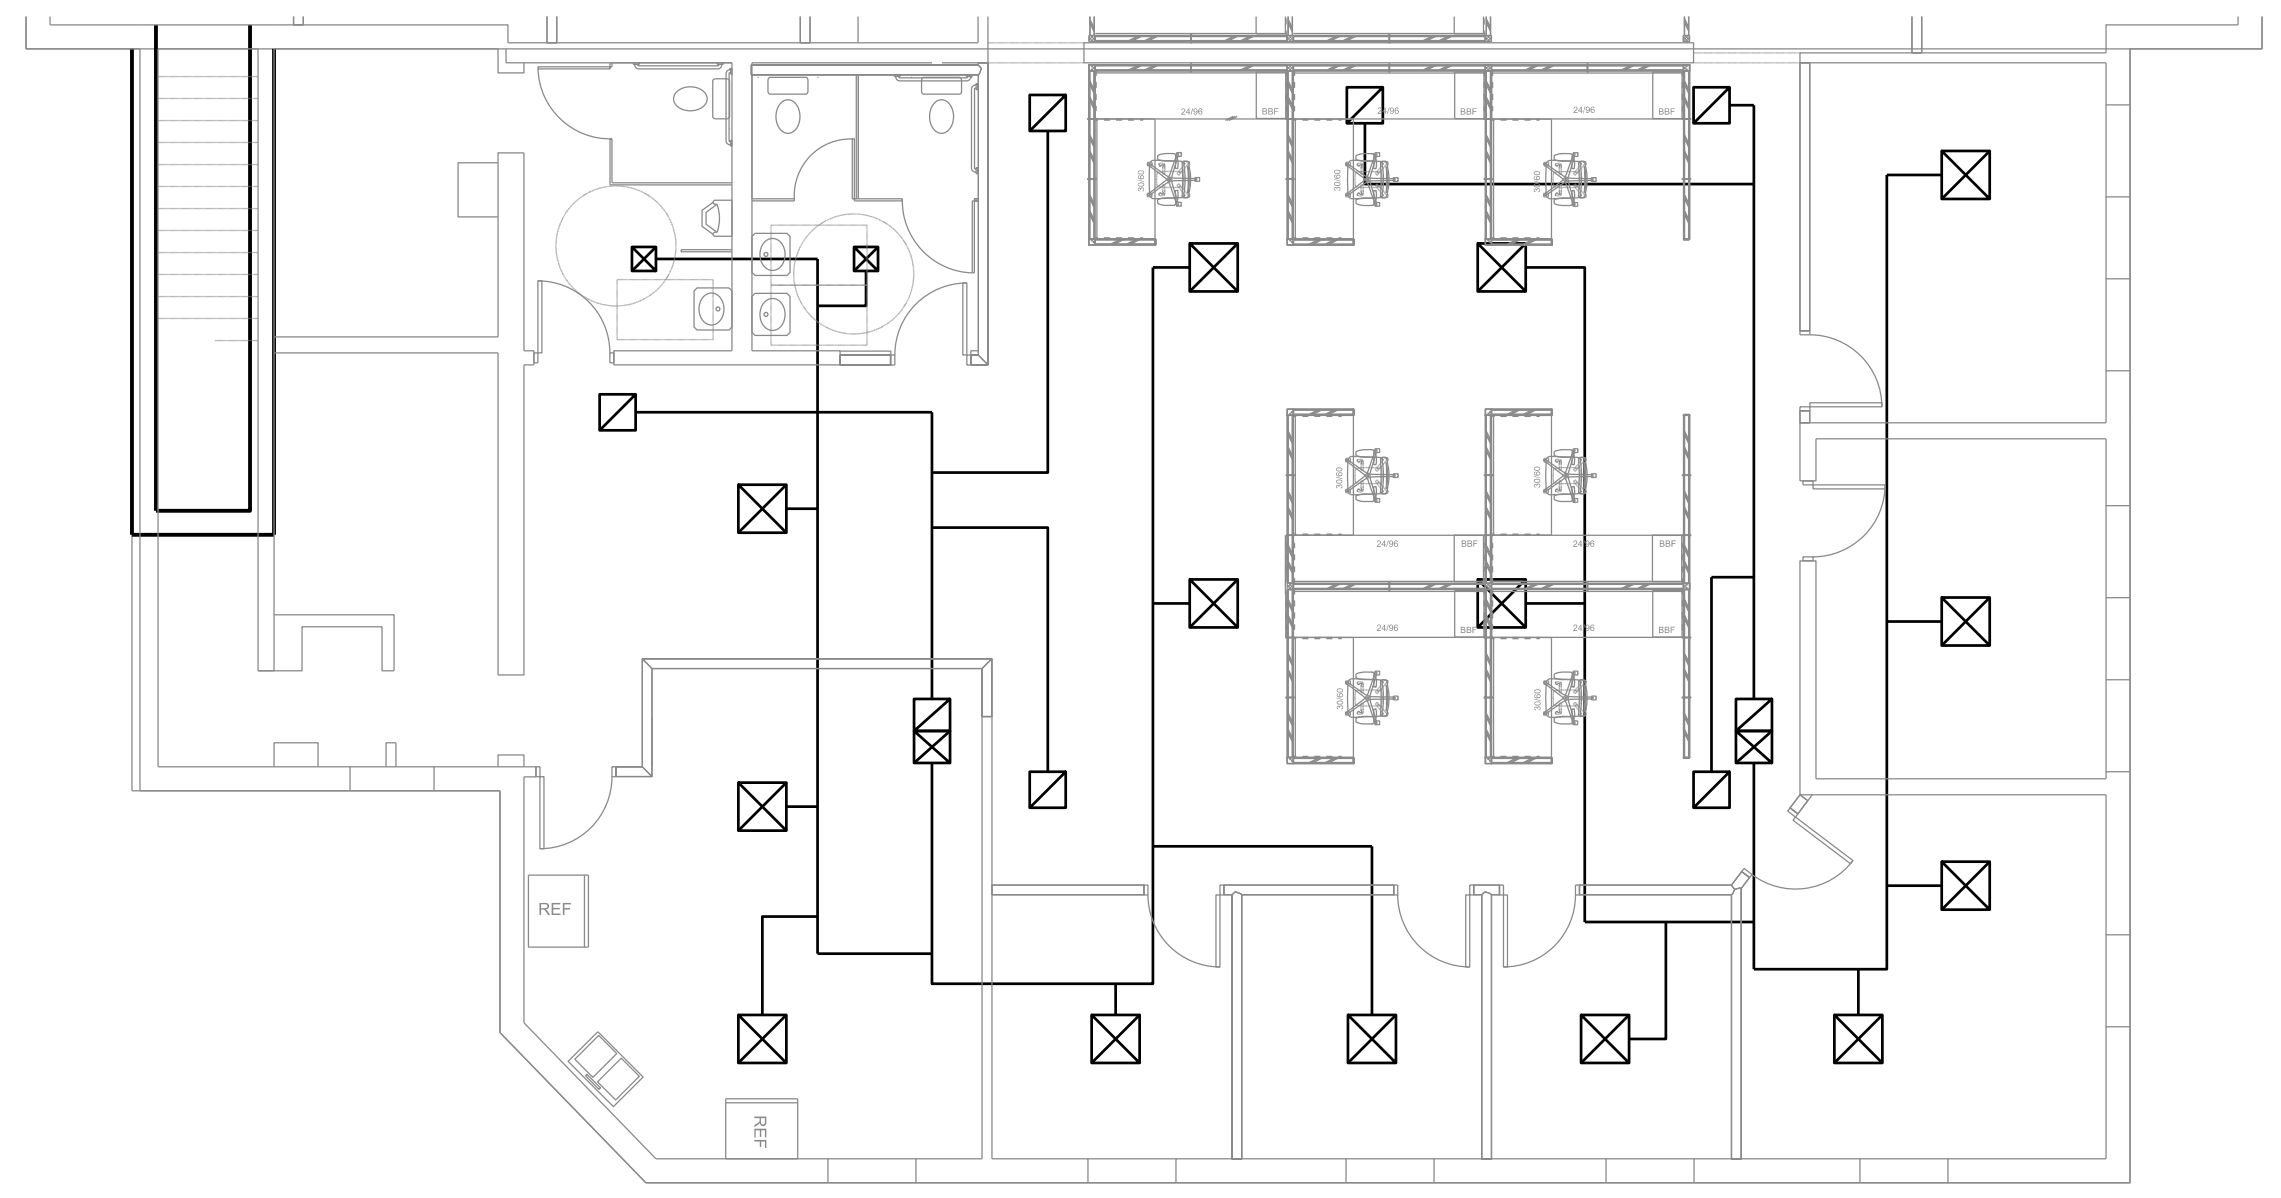


SECOND FLOOR MECHANICAL PLAN
 SCALE - 1/8" = 1'-0"

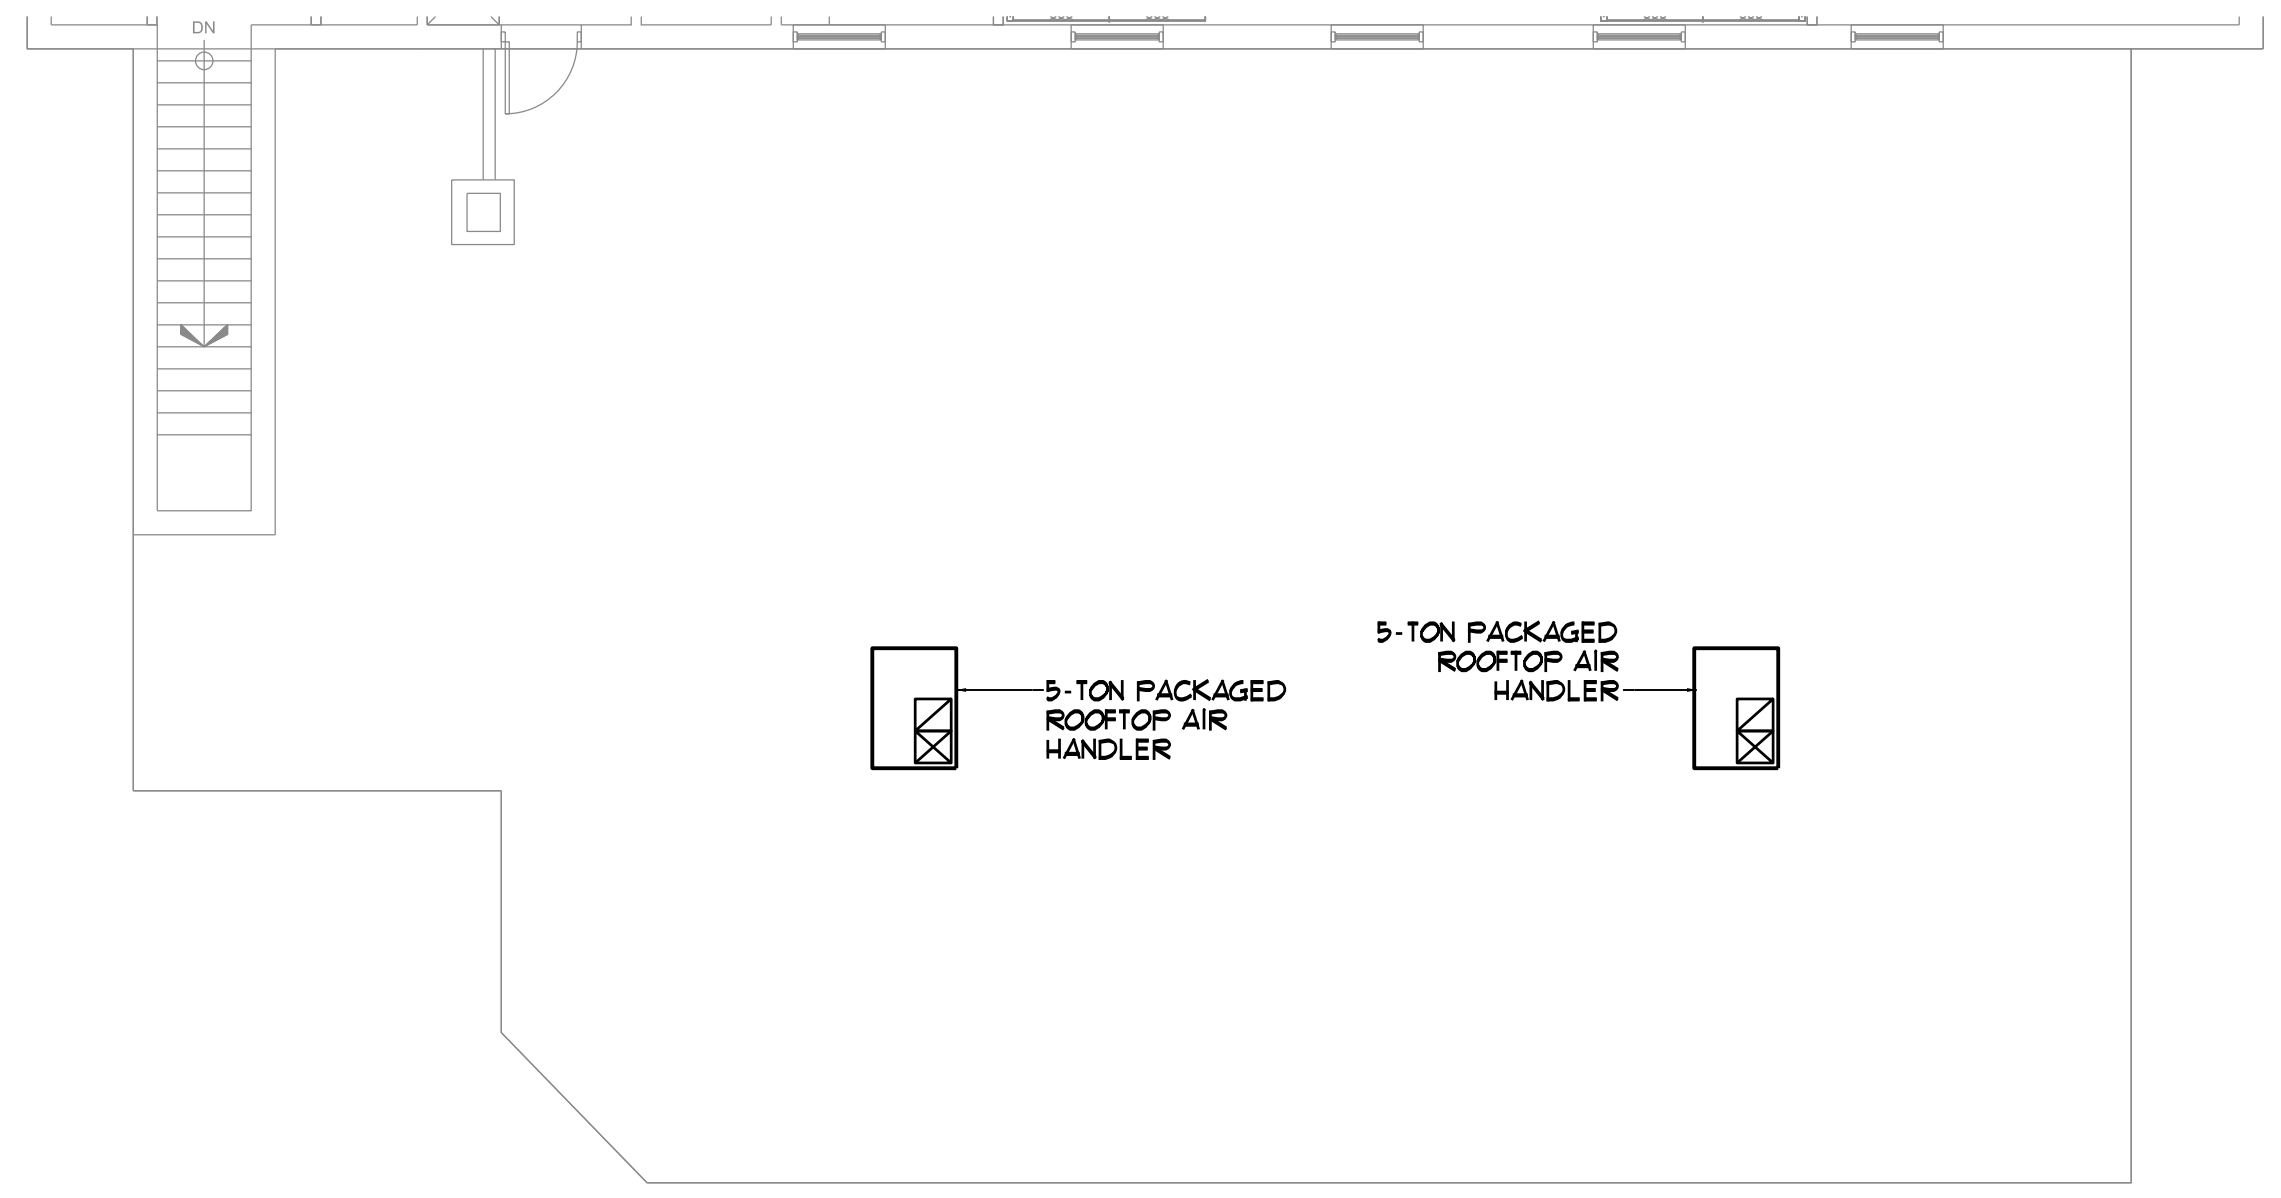

ROOF MECHANICAL PLAN
 SCALE - 1/8" = 1'-0"

UNITED INSURANCE AGENCY
 470 FOREST AVE.
 PORTLAND, MAINE

CONSULTANTS:

BENNETT ENGINEERING
 MECHANICAL • ELECTRICAL
 (207) 855-9475

REVISIONS:
 ISSUED FOR PERMIT

DATE: AUGUST 26, 2015

PROJECT No. xxxxxx

DRAWN BY: JMV

CHECKED BY: SPDoel

SCALE: AS NOTED

SHEET TITLE:
 MECHANICAL PLANS

M1-1