




1 CEILING TYPE 1 - GWB

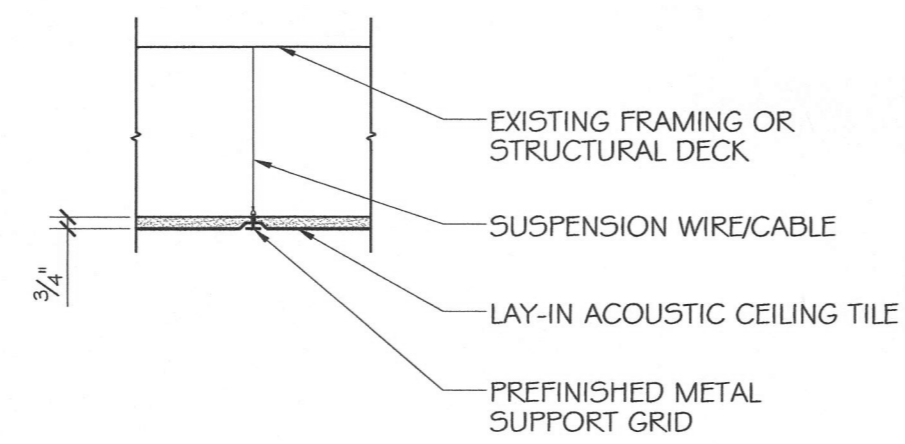


2 CEILING TYPE 2 - ACT

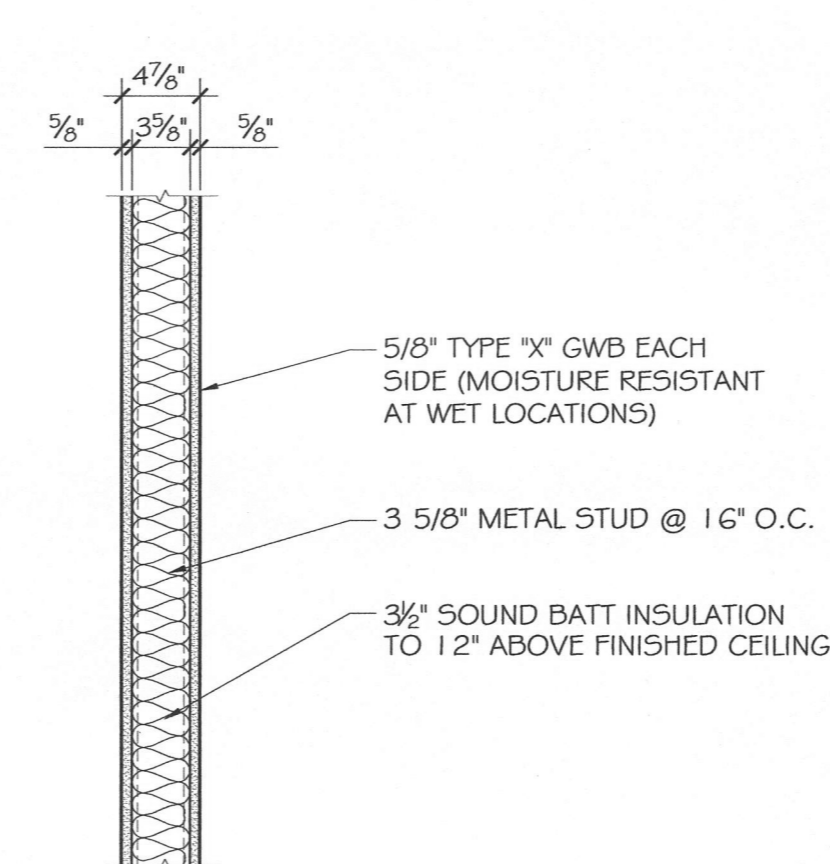


1 WALL TYPE 1

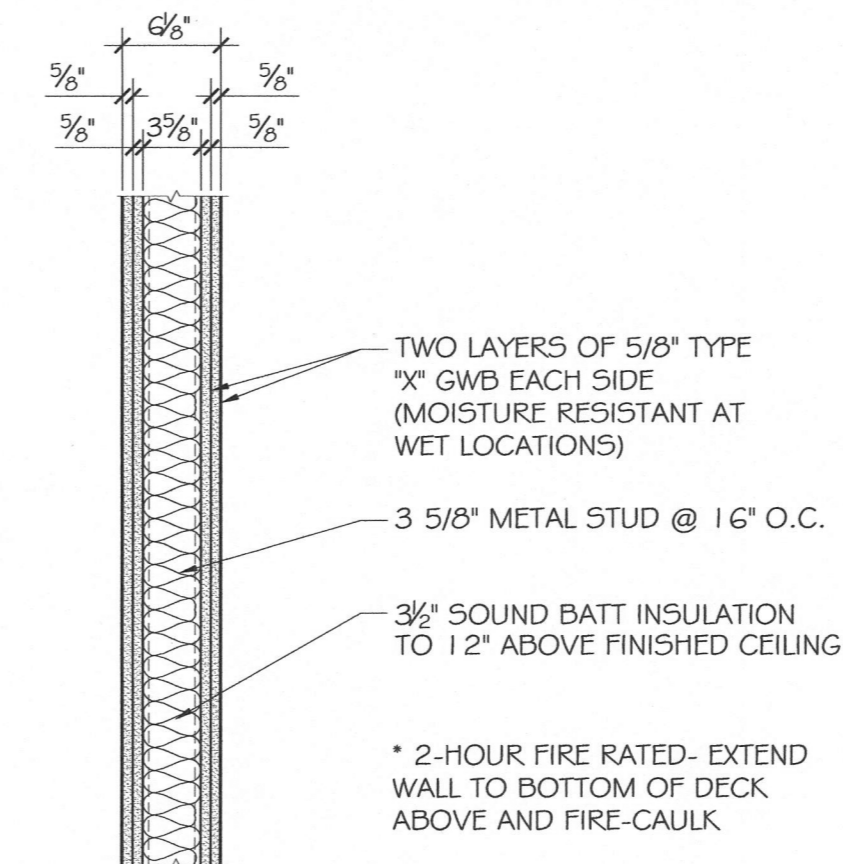

2 WALL TYPE 2


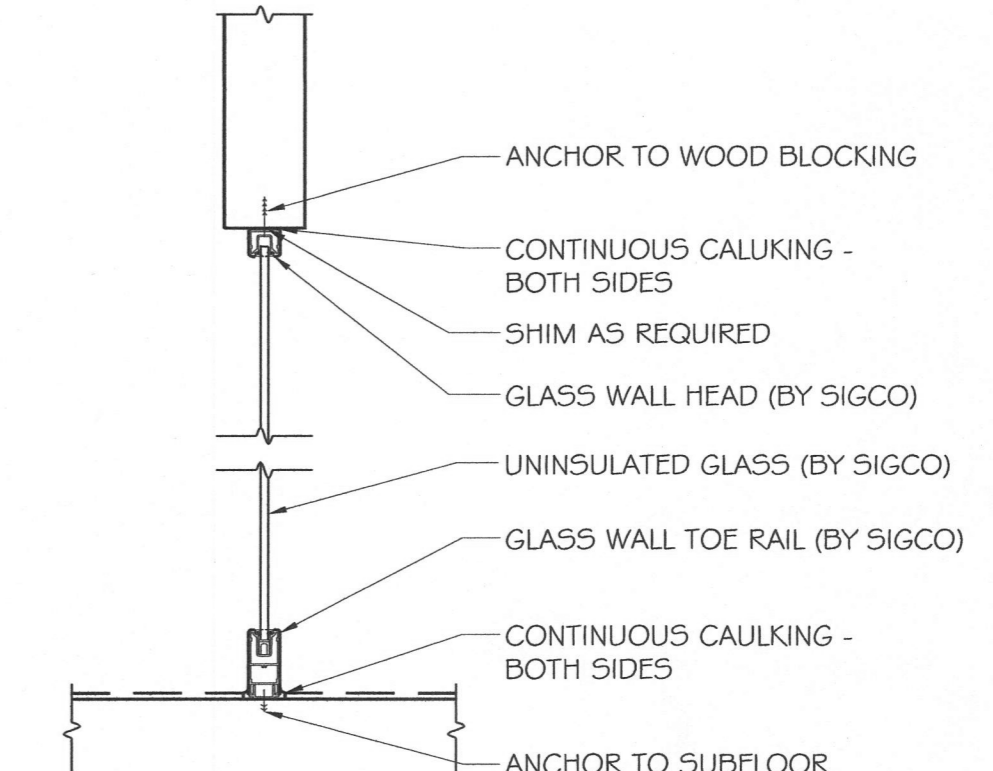


3 WALL TYPE 3

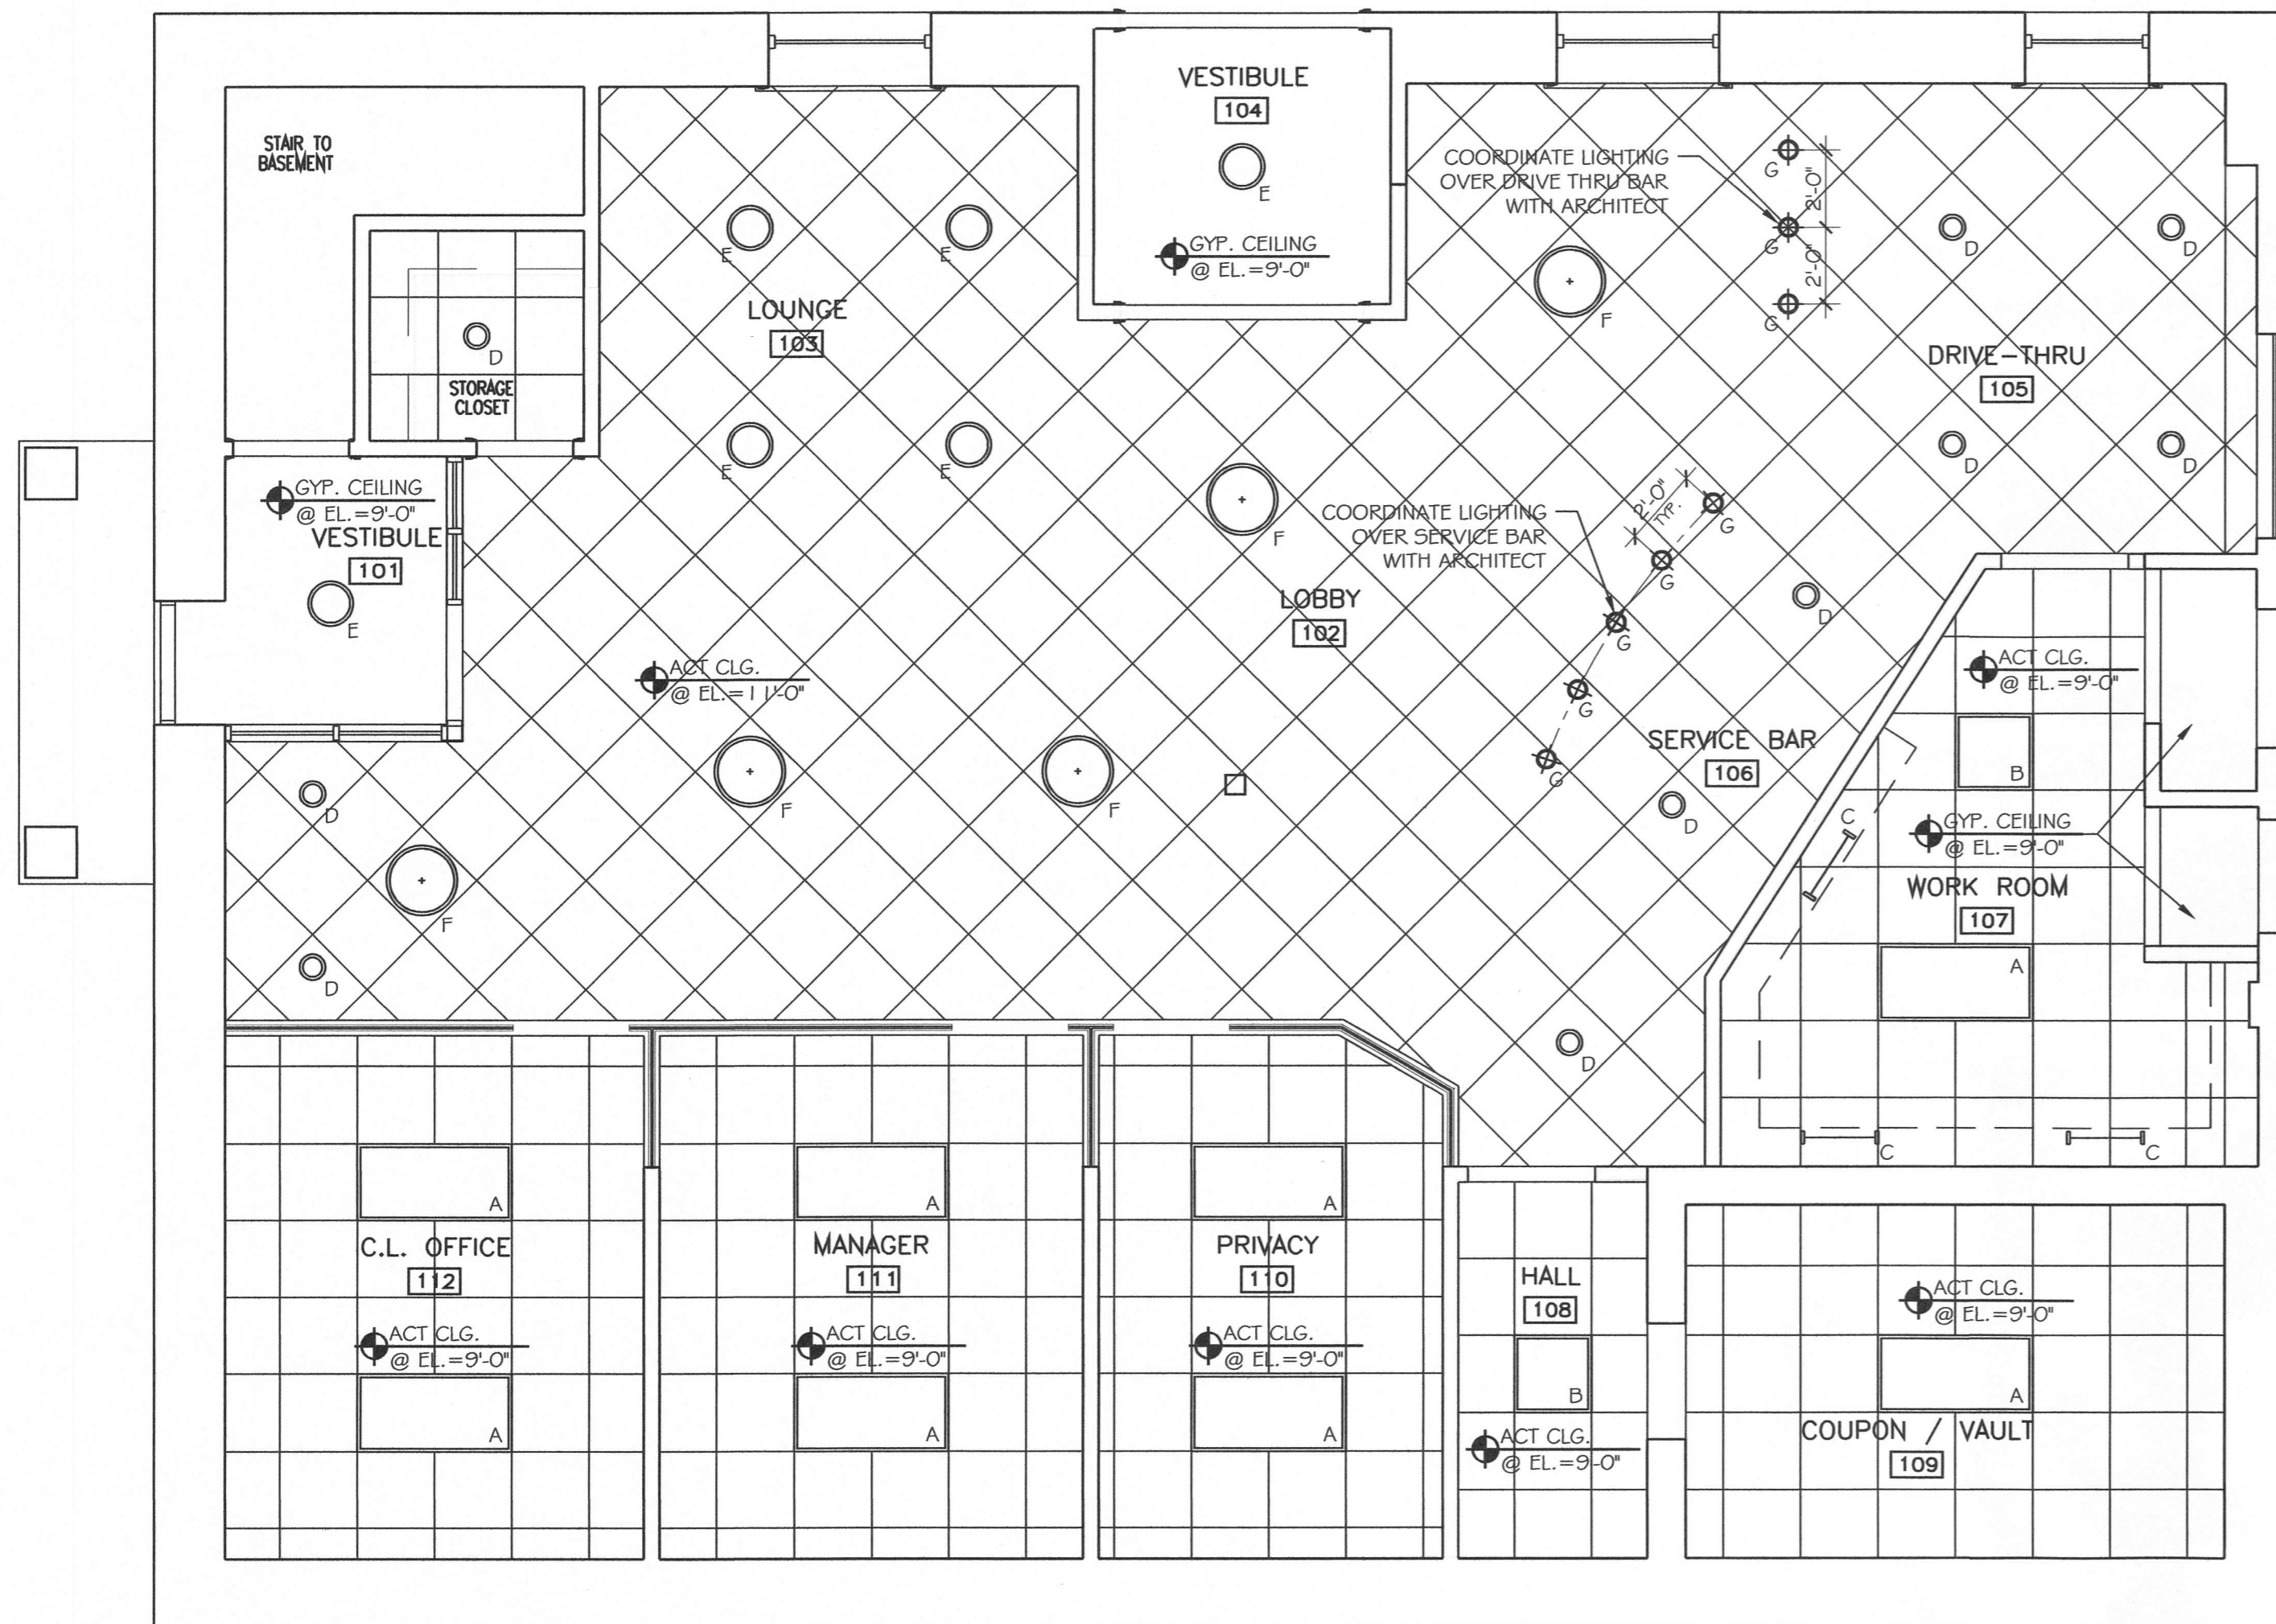

LIGHTING SCHEDULE

	LIGHTING FIXTURE TYPE A = 2' x 4' RECESSED FLORESCENT FOCAL POINT #FLU-24-B-3-TSHO-S-120-G-PS-W1
	LIGHTING FIXTURE TYPE B = 2' x 2' RECESSED FLORESCENT FOCAL POINT #FLU-22-B-2-TSHO-S-120-G-PS-W1
	LIGHTING FIXTURE TYPE C = 24" SURFACE-MTD. STRIP LUMAX #LUM114-ED1-PC-IS-SW
	LIGHTING FIXTURE TYPE D = 6" RECESSED INTERIOR DOWNLIGHT PRESCOLITE #BX1 #ICAT/COGC
	LIGHTING FIXTURE TYPE E = 12" SURFACE-MTD. GLOBE BETA CALCO #60-2105-OP-SN-1
	LIGHTING FIXTURE TYPE F = PENDANT-MOUNTED 24" FLORESCENT BOWL BETA CALCO #60-3002-OP-SN-1-DC
	LIGHTING FIXTURE TYPE G = CABLE-HUNG GLASS SHADE PENDANT PRIMA #P63-00-15677-F-SV-SG-20

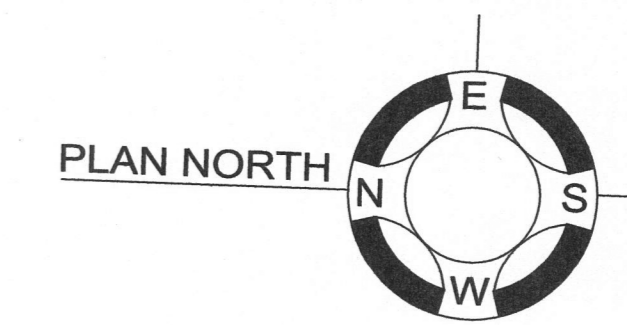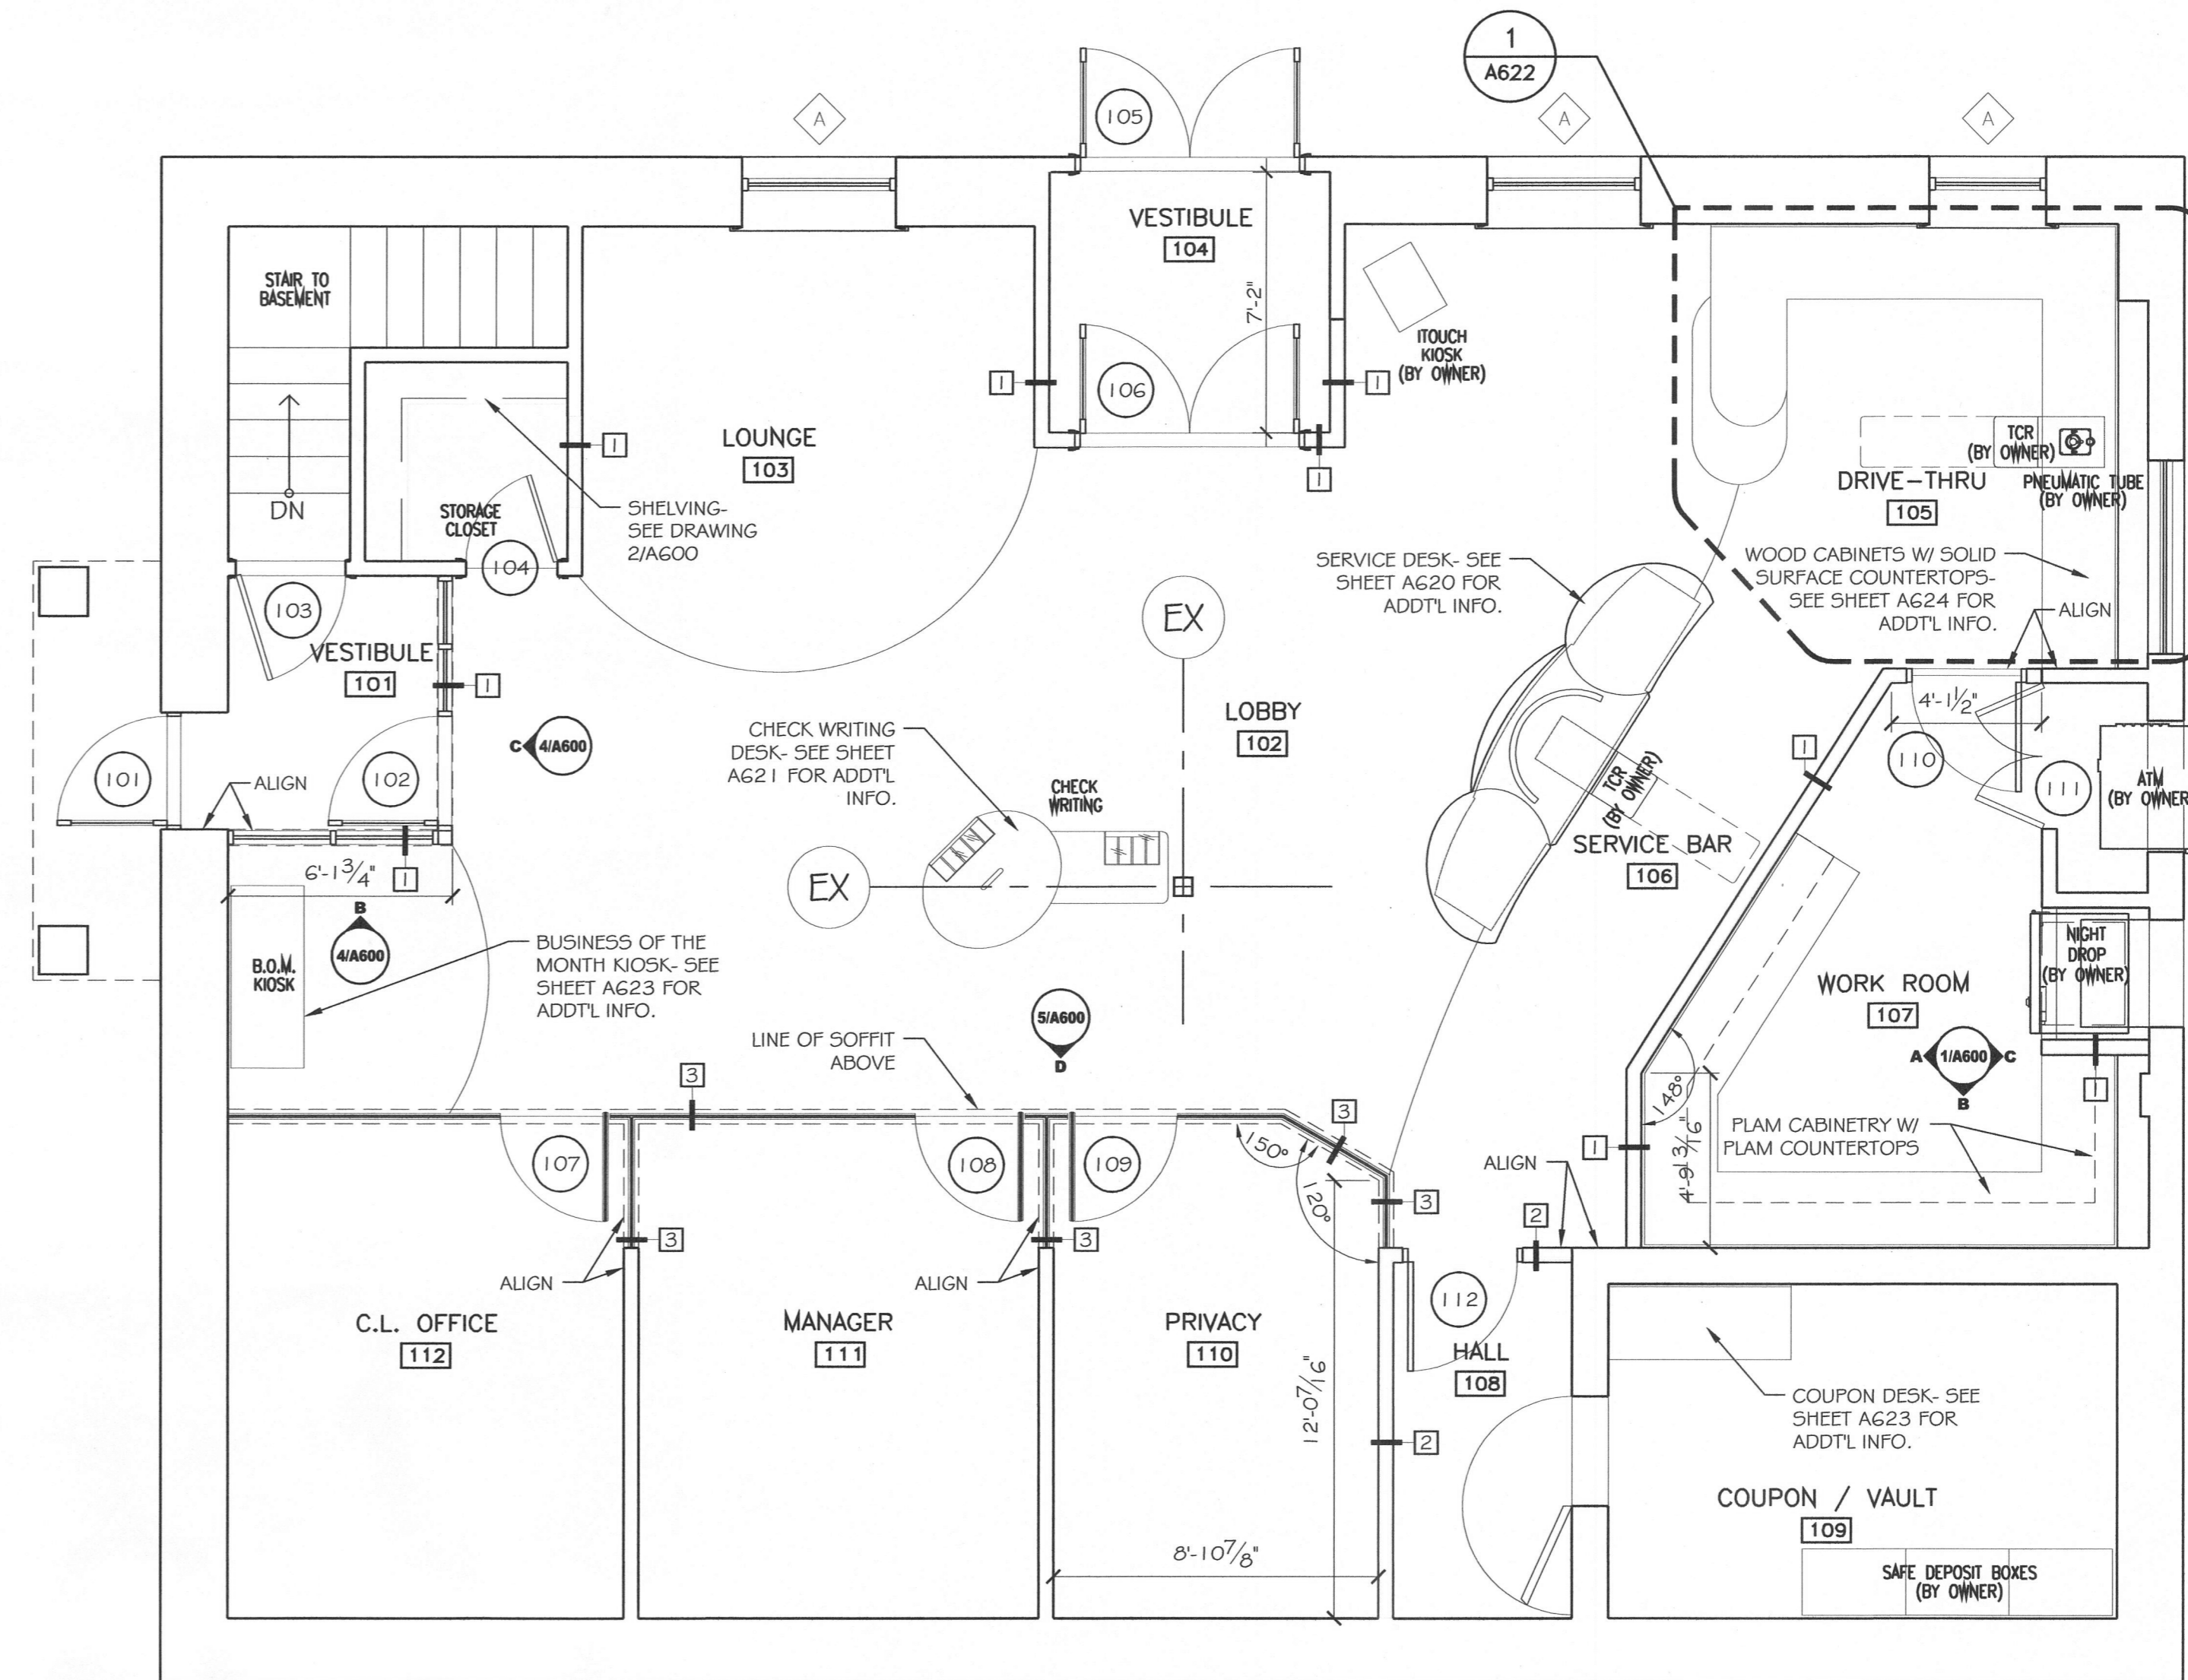

PLATZ ASSOCIATES
Architects - Engineers
Construction Managers
Tel 207-784-2941
Fax 207-784-3856
Two Great Falls Plaza, Auburn, Maine 04210

Construction of:
NORWAY SAVINGS BANK
446 Forest Avenue
Portland, Maine 04101



DRAWING STATUS
 OFFICE REVIEW
 CLIENT REVIEW
 PERMIT REVIEW
 BID SET
 CONTRACT DRAWING
 CONSTRUCTION
No drawing shall be recognized as a construction document unless it bears a blue inked registration seal.

SHEET TITLE
FIRST FLOOR PLAN & RCP
JOB NO.
20142
DRAWN BY
TRN
CHECKED BY
TRN
SCALE
1/4" = 1'-0"
ORIGINAL DATE
05-12-14
REVISION DATE

SHEET
A100

2 REFLECTED CEILING PLAN
SCALE: 1/4" = 1'-0"

1 RENOVATED FIRST FLOOR PLAN
SCALE: 1/4" = 1'-0"

20142-NB-Perkins20K203 ARCHITECTURAL/JO