

REVISION	DESCRIPTION	DATE
0	ISSUED FOR REVIEW & APPROVAL	8/26/2014


RESERVED FOR CITY STAMP

CUNNINGHAM
 Security Systems
 10 Princes Point Road, Yarmouth, Maine 04096
 Office: 207.846.3350 • Fax: 207.846.6080

NORWAY SAVINGS BANK
 446 FOREST AVENUE
 PORTLAND, MAINE 04101
BASEMENT FIRE ALARM PLAN

DRAWN	JPB UNICAD JOB #14519
CHECKED	WAYNE B. HAWES NCET # 90496
DATE	8/26/2014
REVISION	0
SCALE	1/4"=1'-0"

FA-2

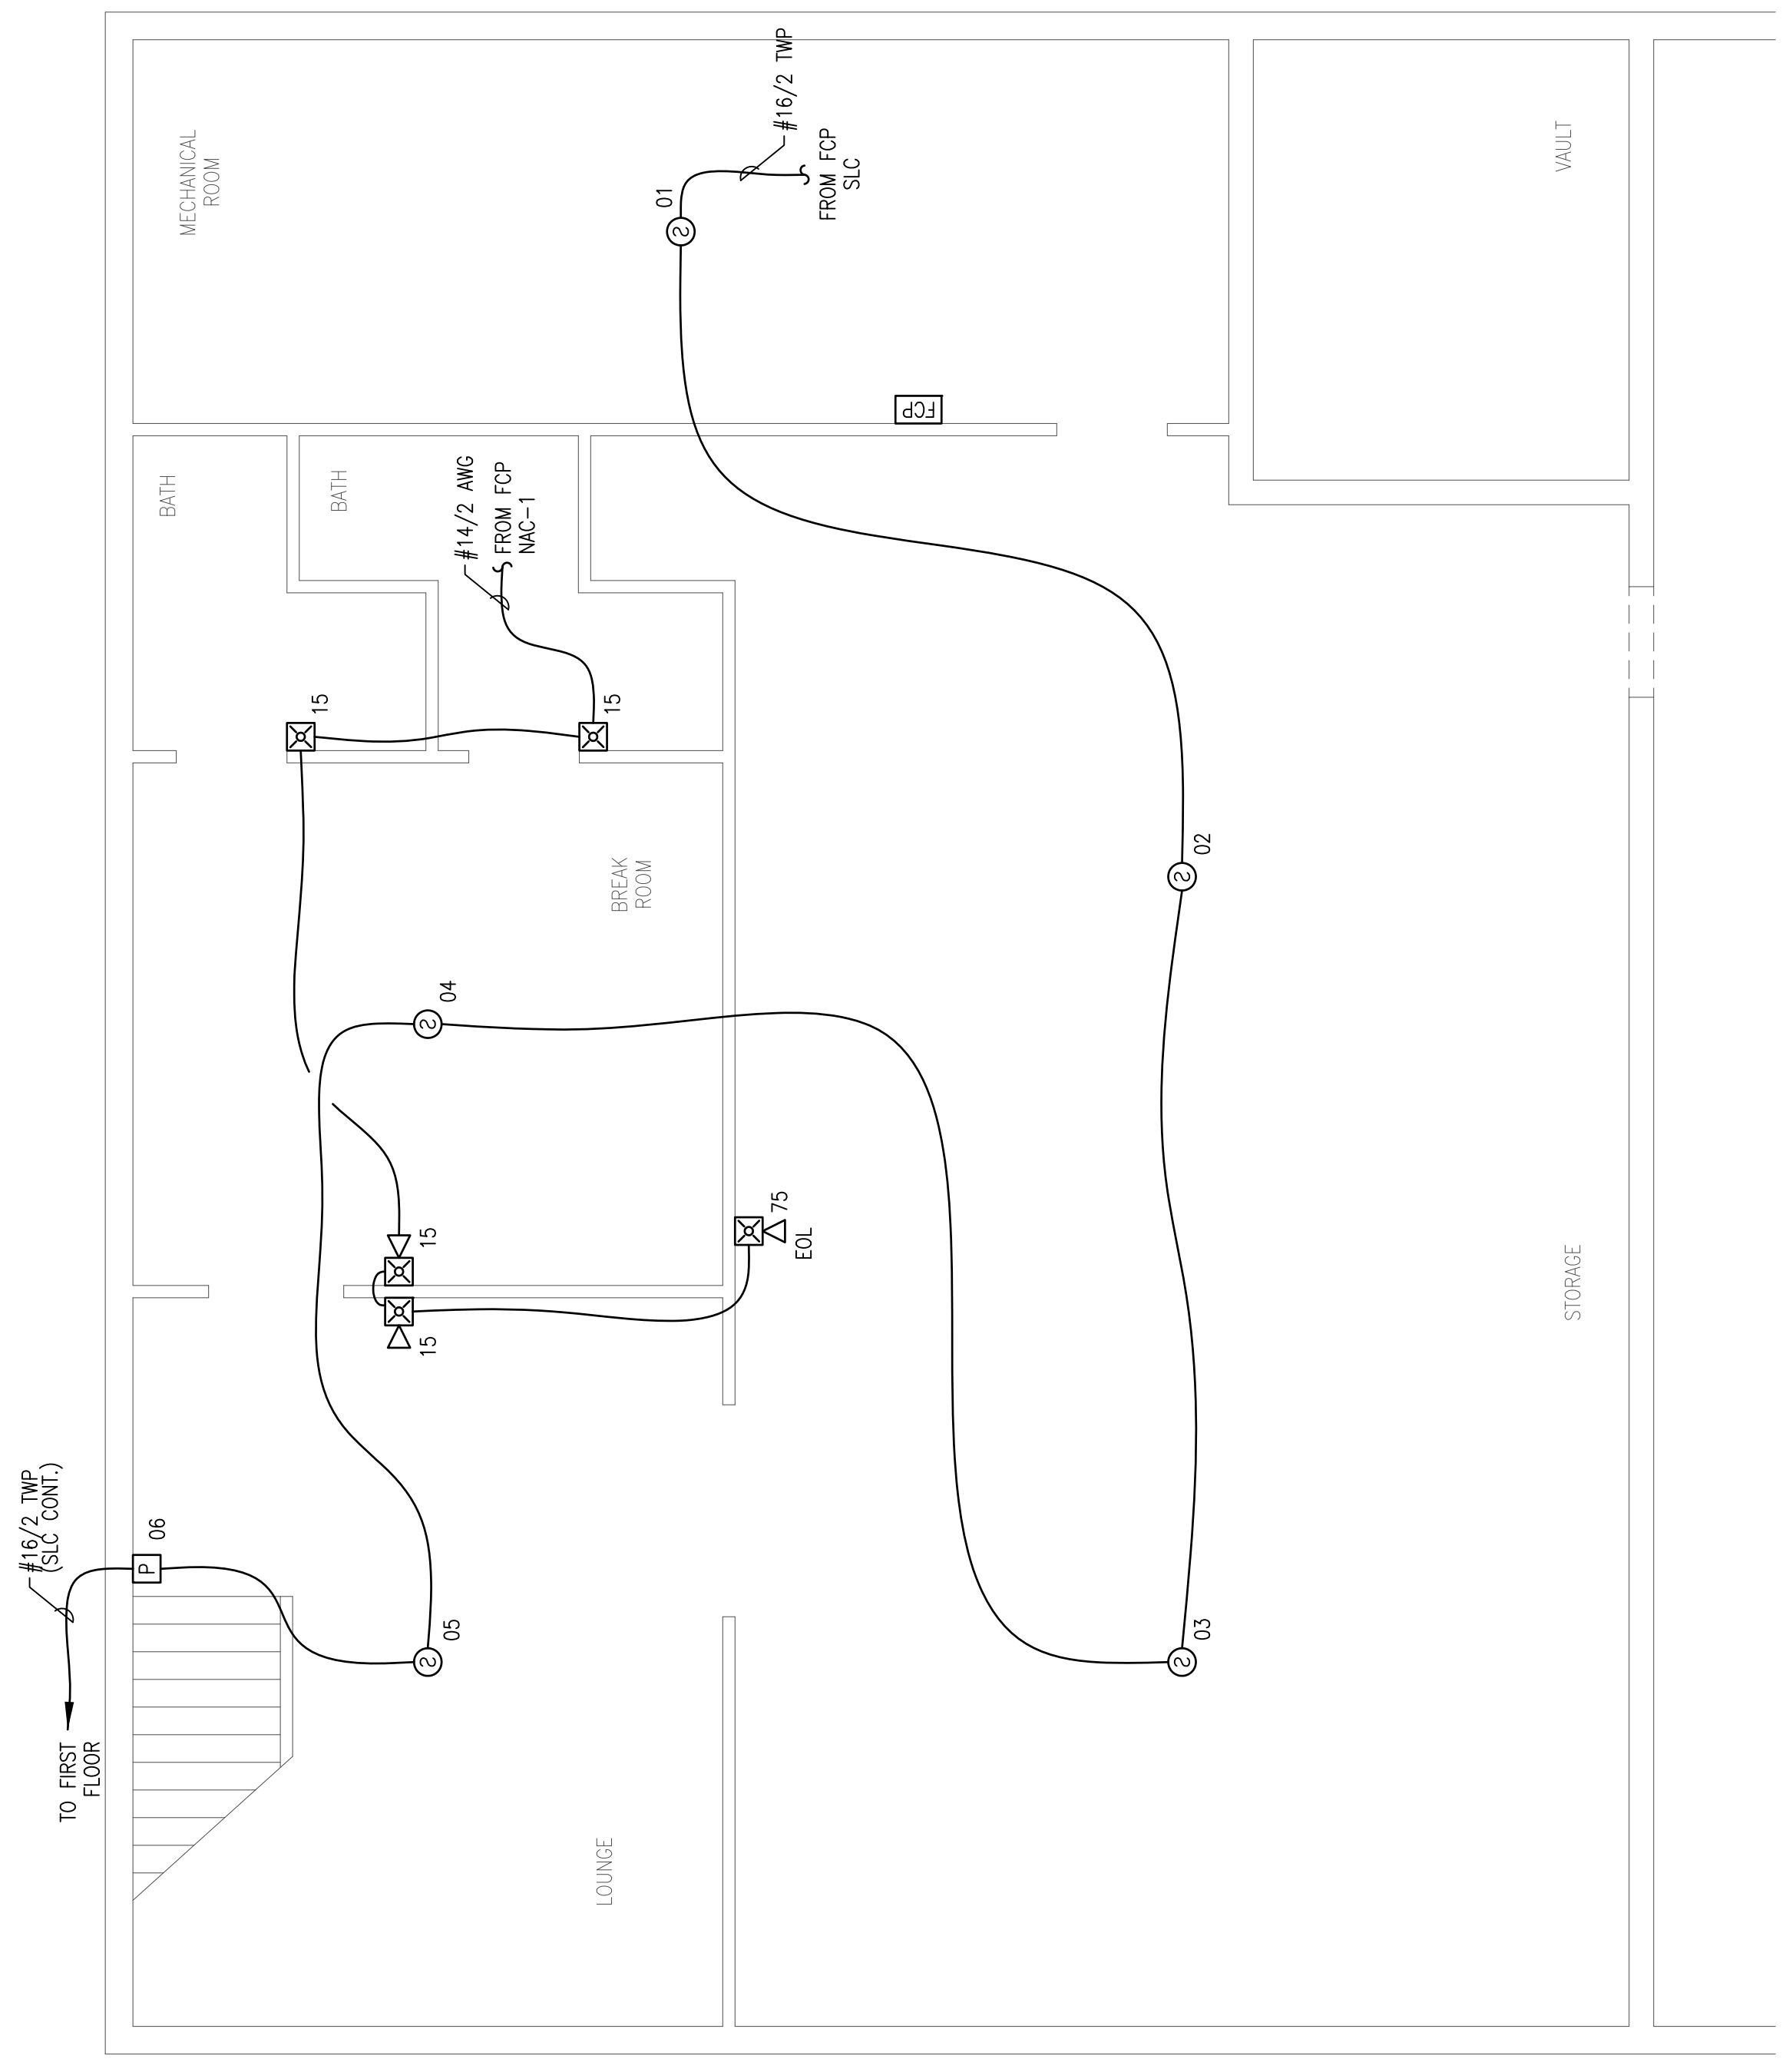

BASEMENT FIRE ALARM PLAN
 SCALE: 1/4"=1'-0"