

REVISION	DESCRIPTION	DATE
0	ISSUED FOR REVIEW & APPROVAL	8/26/2014

RESERVED FOR CITY STAMP


CUNNINGHAM
 Security Systems
 10 Princes Point Road, Yarmouth, Maine 04096
 Office: 207.846.3350 • Fax: 207.846.6080

NORWAY SAVINGS BANK
 446 FOREST AVENUE
 PORTLAND, MAINE 04101
FIRST FLOOR FIRE ALARM PLAN

DRAWN	JPB UNICAD JOB #14519
CHECKED	WAYNE B. HAWES NCET # 90496
DATE	8/26/2014
REVISION	0
SCALE	1/4"=1'-0"

FA-3

UNICAD Inc.
 100 Main Street
 Portland, ME 04101
 Office: 207.865.6410
 www.unicad.net
 Fire Alarm Design & Drafting Services

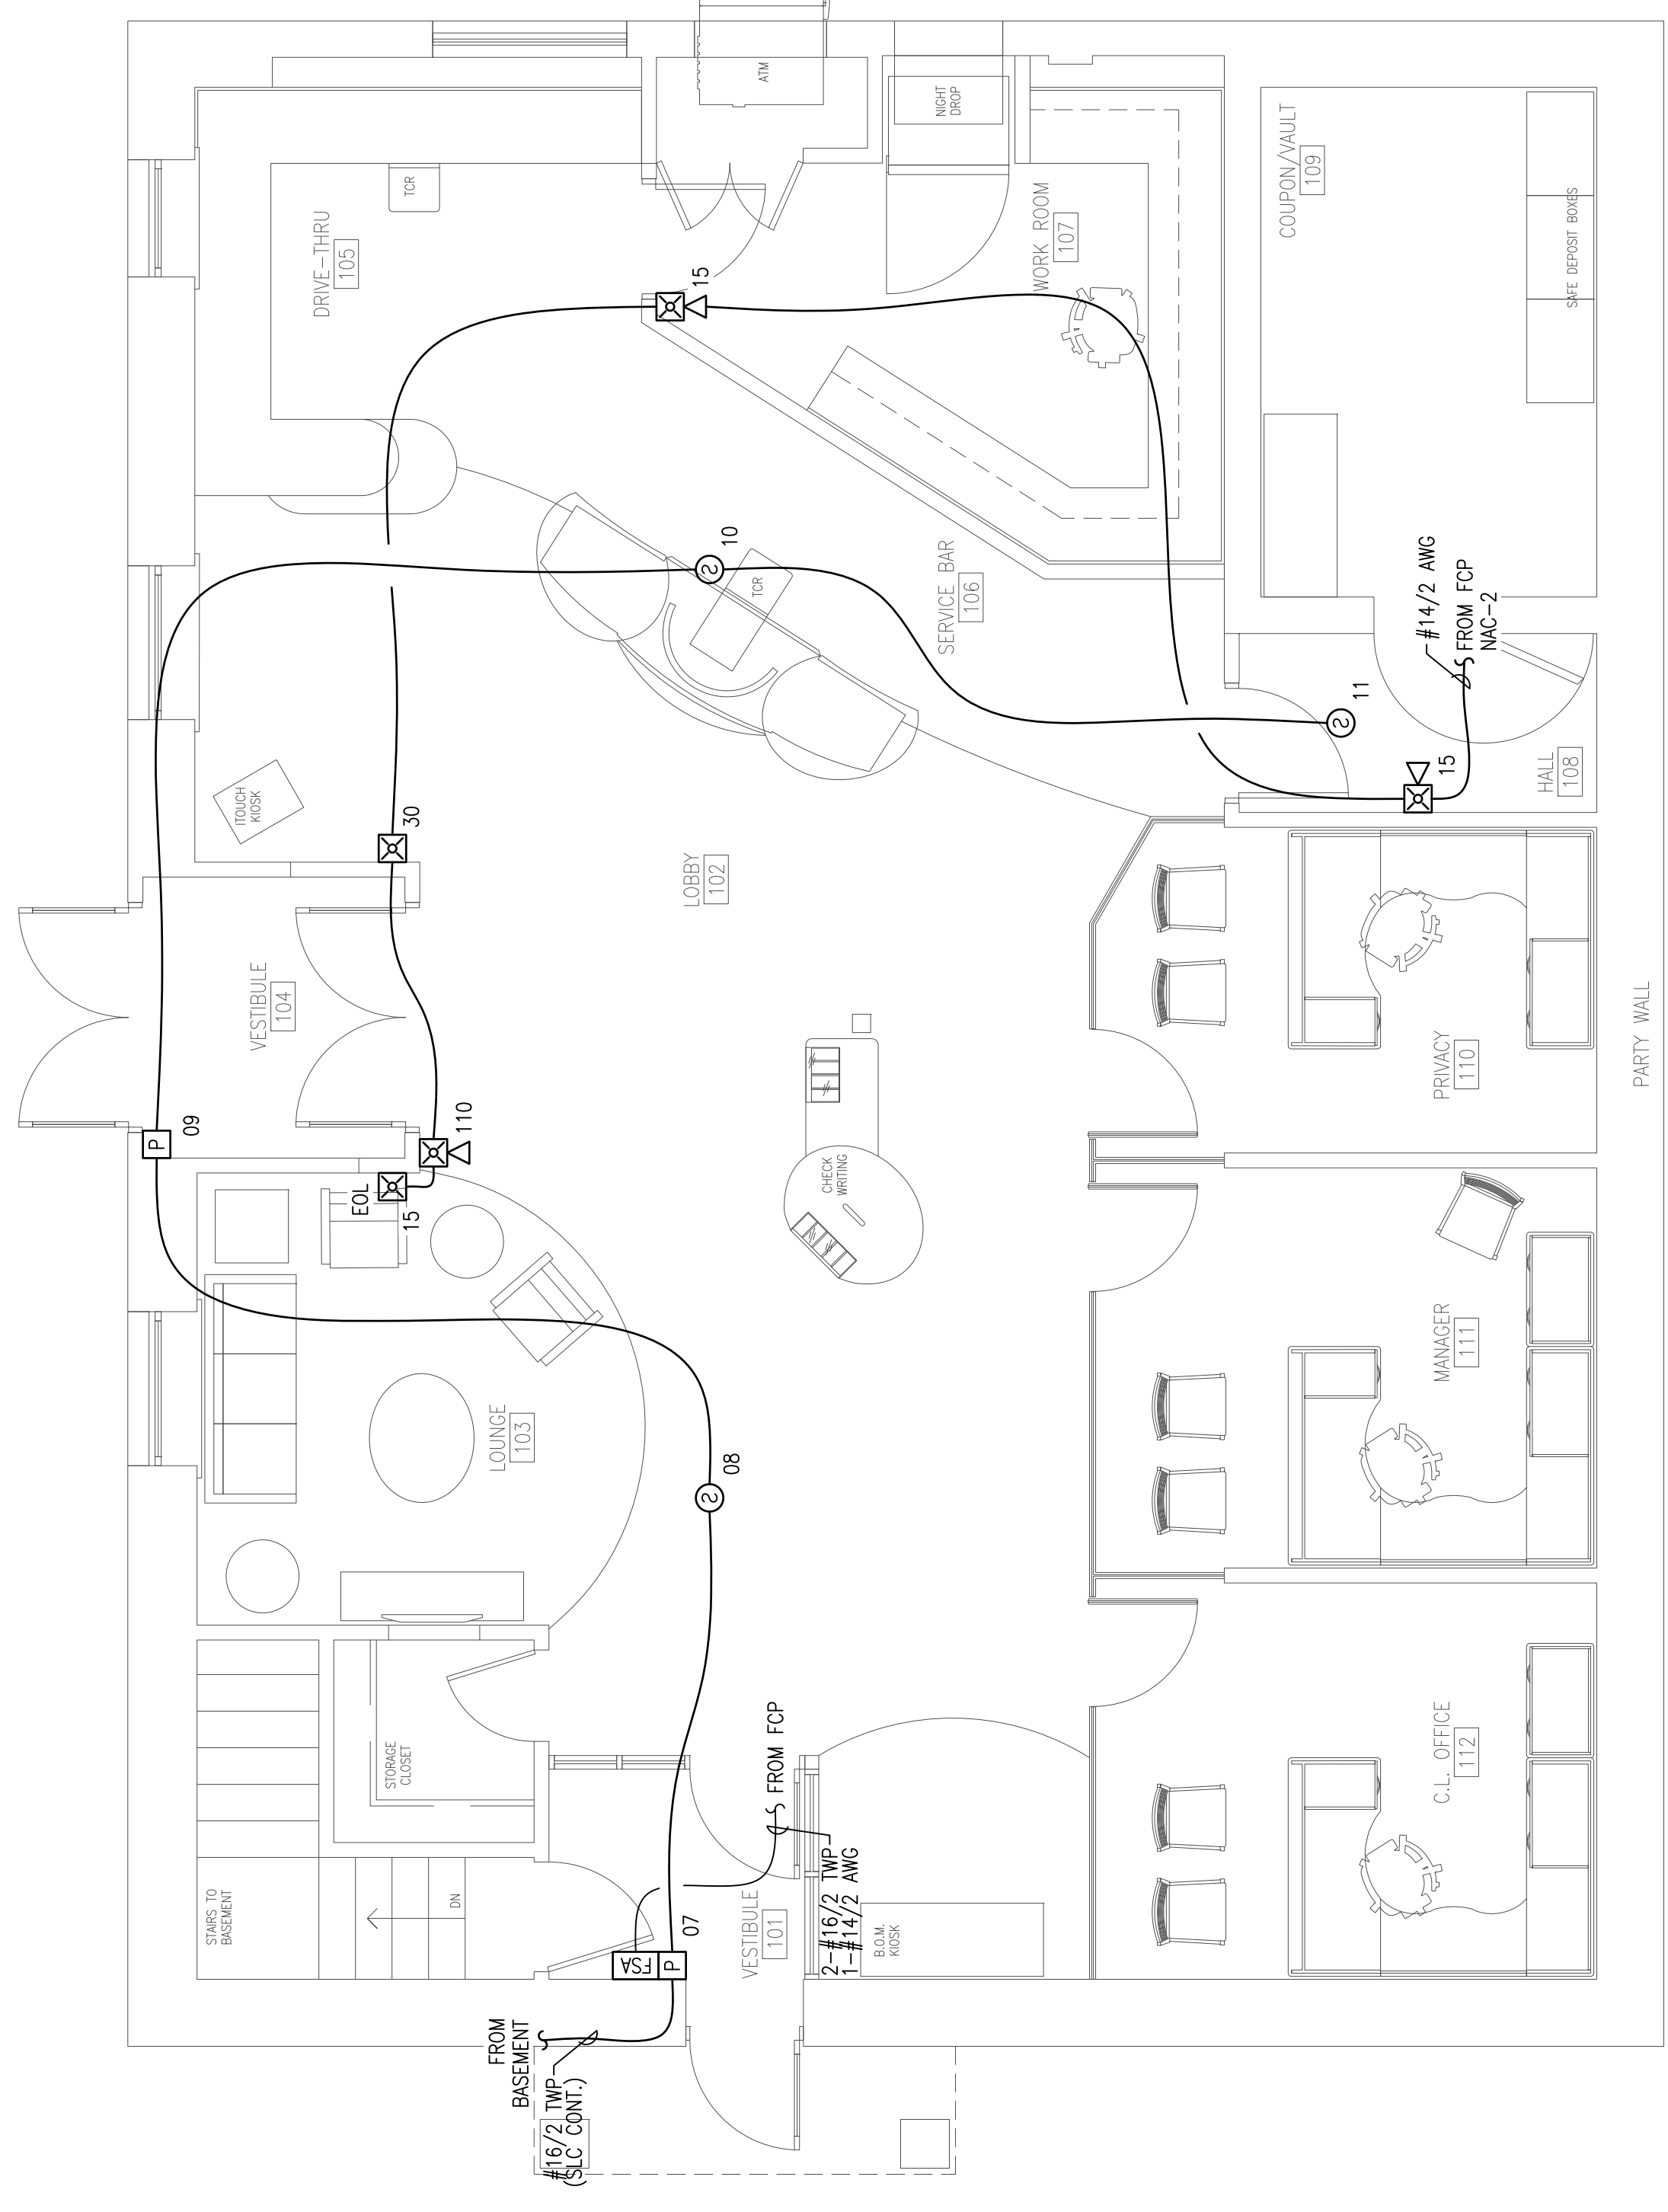

FIRST FLOOR FIRE ALARM PLAN
 SCALE: 1/8"=1'-0"

