


ISSUE:	DATE:	DESCRIPTION:
A	08/28/09	100% OWNER REVIEW SET
B	08/13/09	ISSUED FOR BID

REVISION:	DATE:	DESCRIPTION:

KEY PLAN:

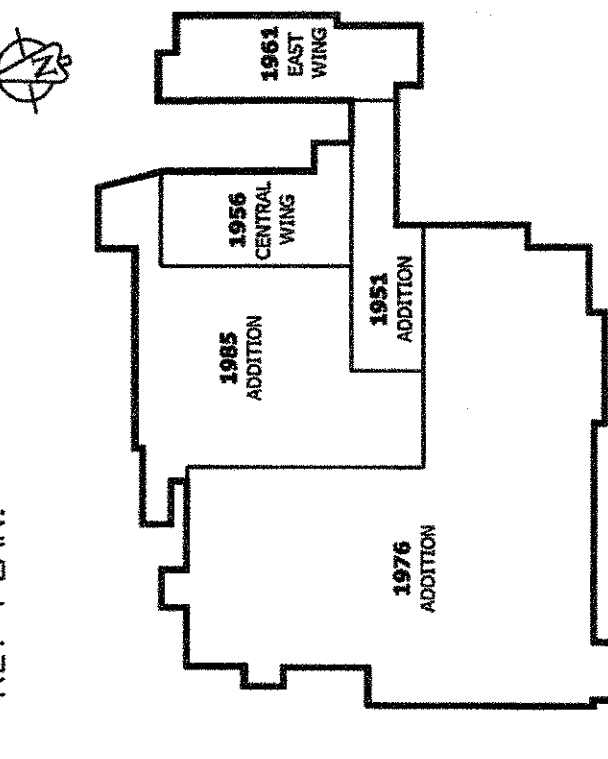


DRAWING TITLE:
ELECTRICAL ONE LINE DIAGRAM EXISTING & DEMOLITION SEAL:

DESIGNED BY:	
CHECKED BY:	
DATE:	AS NOTED
PROJECT NO.:	092374.00.E

DRAWING NO.:

E-501

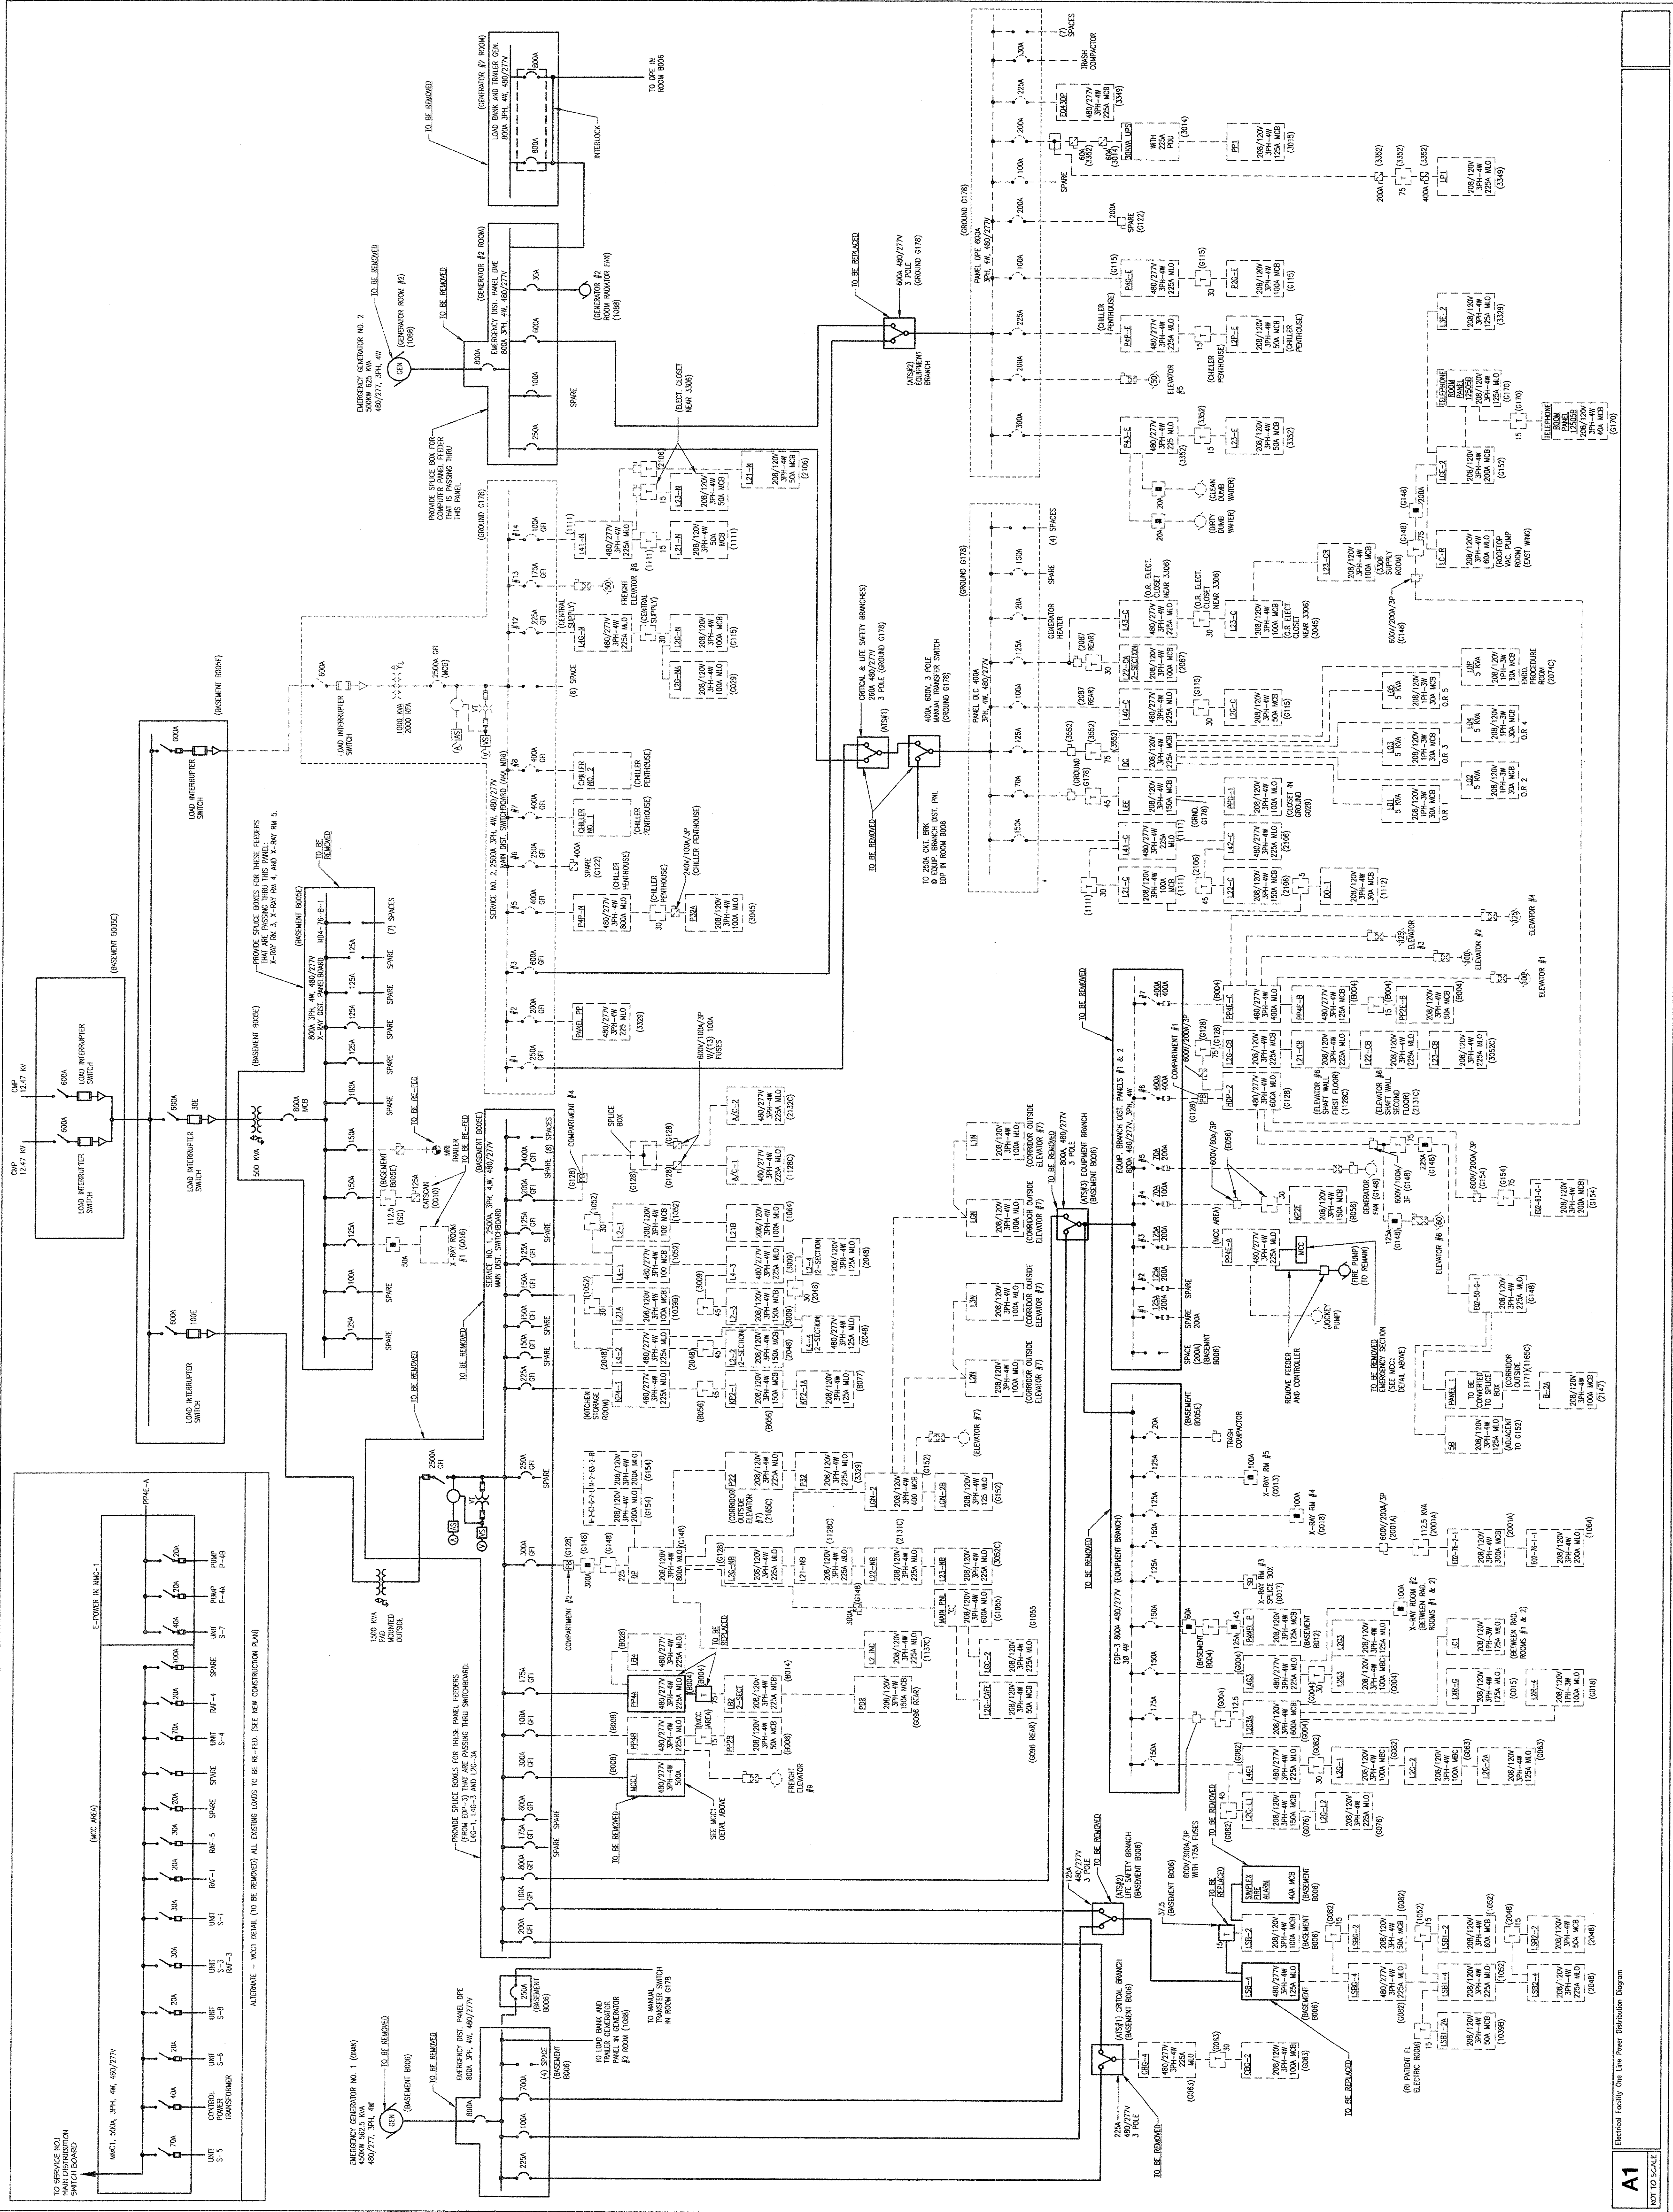

Electrical Facility One Line Power Distribution Diagram

A1
NOT TO SCALE