

GENERAL NOTES:



1. REFER TO 0200 FOR PROJECT GENERAL NOTES, ABBREVIATIONS AND SYMBOLS LEGEND.
2. UNLESS INDICATED OTHERWISE, CENTER ALL CEILING FIXTURES. USE 1/4" AT THE END OR GREATER AT PARTIALS TO MAINTAIN CENTERING.
3. REFER TO ROOM FINISH SCHEDULE FOR CEILING HEIGHTS AND CEILING FINISHES TO BE PROVIDED.
4. REFER TO ROOM FINISH SCHEDULE FOR CEILING HEIGHTS AND CEILING FINISHES TO BE PROVIDED.
5. FIRE SPRINKLERS SHALL BE LOCATED IN ALL CORRIDORS WITH OTHER CEILING FIXTURES TYPICALLY.
6. FIRE SPRINKLERS SHALL BE PLACED TO CORRELATE WITH LIGHT FIXTURE FOOTPRINTS INDICATED.

REFLECTED CEILING NOTES:


1. UNLESS INDICATED OTHERWISE, CENTER ALL CEILING FIXTURES. USE 1/4" AT THE END OR GREATER AT PARTIALS TO MAINTAIN CENTERING.
2. UNLESS INDICATED OTHERWISE, CENTER ALL CEILING FIXTURES. USE 1/4" AT THE END OR GREATER AT PARTIALS TO MAINTAIN CENTERING.
3. REFER TO ROOM FINISH SCHEDULE FOR CEILING HEIGHTS AND CEILING FINISHES TO BE PROVIDED.
4. REFER TO ROOM FINISH SCHEDULE FOR CEILING HEIGHTS AND CEILING FINISHES TO BE PROVIDED.
5. FIRE SPRINKLERS SHALL BE LOCATED IN ALL CORRIDORS WITH OTHER CEILING FIXTURES TYPICALLY.
6. FIRE SPRINKLERS SHALL BE PLACED TO CORRELATE WITH LIGHT FIXTURE FOOTPRINTS INDICATED.

SYMBOLS LEGEND:

- 2x2 SUSPENDED CEILING PANEL AND GRID ASSEMBLY
- GRID CEILING
- 2x2 AIR PLANT FIXTURE
- 24" AIR PLANT FIXTURE
- 14" LIGHT FIXTURE
- 14" LIGHT FIXTURE
- FLUORESCENT TRIM FIXTURE
- DOWN LIGHT
- CEILING MOUNTED EXIT LIGHT
- RETURN AIR GRILLE
- SUPPLY AIR GRILLE
- EXHAUST AIR GRILLE
- SPRINKLER HEAD
- CEILING MOUNTED SPEAKER
- CEILING MOUNTED SPEAKER DETECTOR
- CORRELATION AND MARK
- PENDANT LIGHT FIXTURE
- LINEAR FIXTURE
- CEILING CREDIT CAMERA
- CONTROL POINT
- EXISTING CEILING TO REMAIN

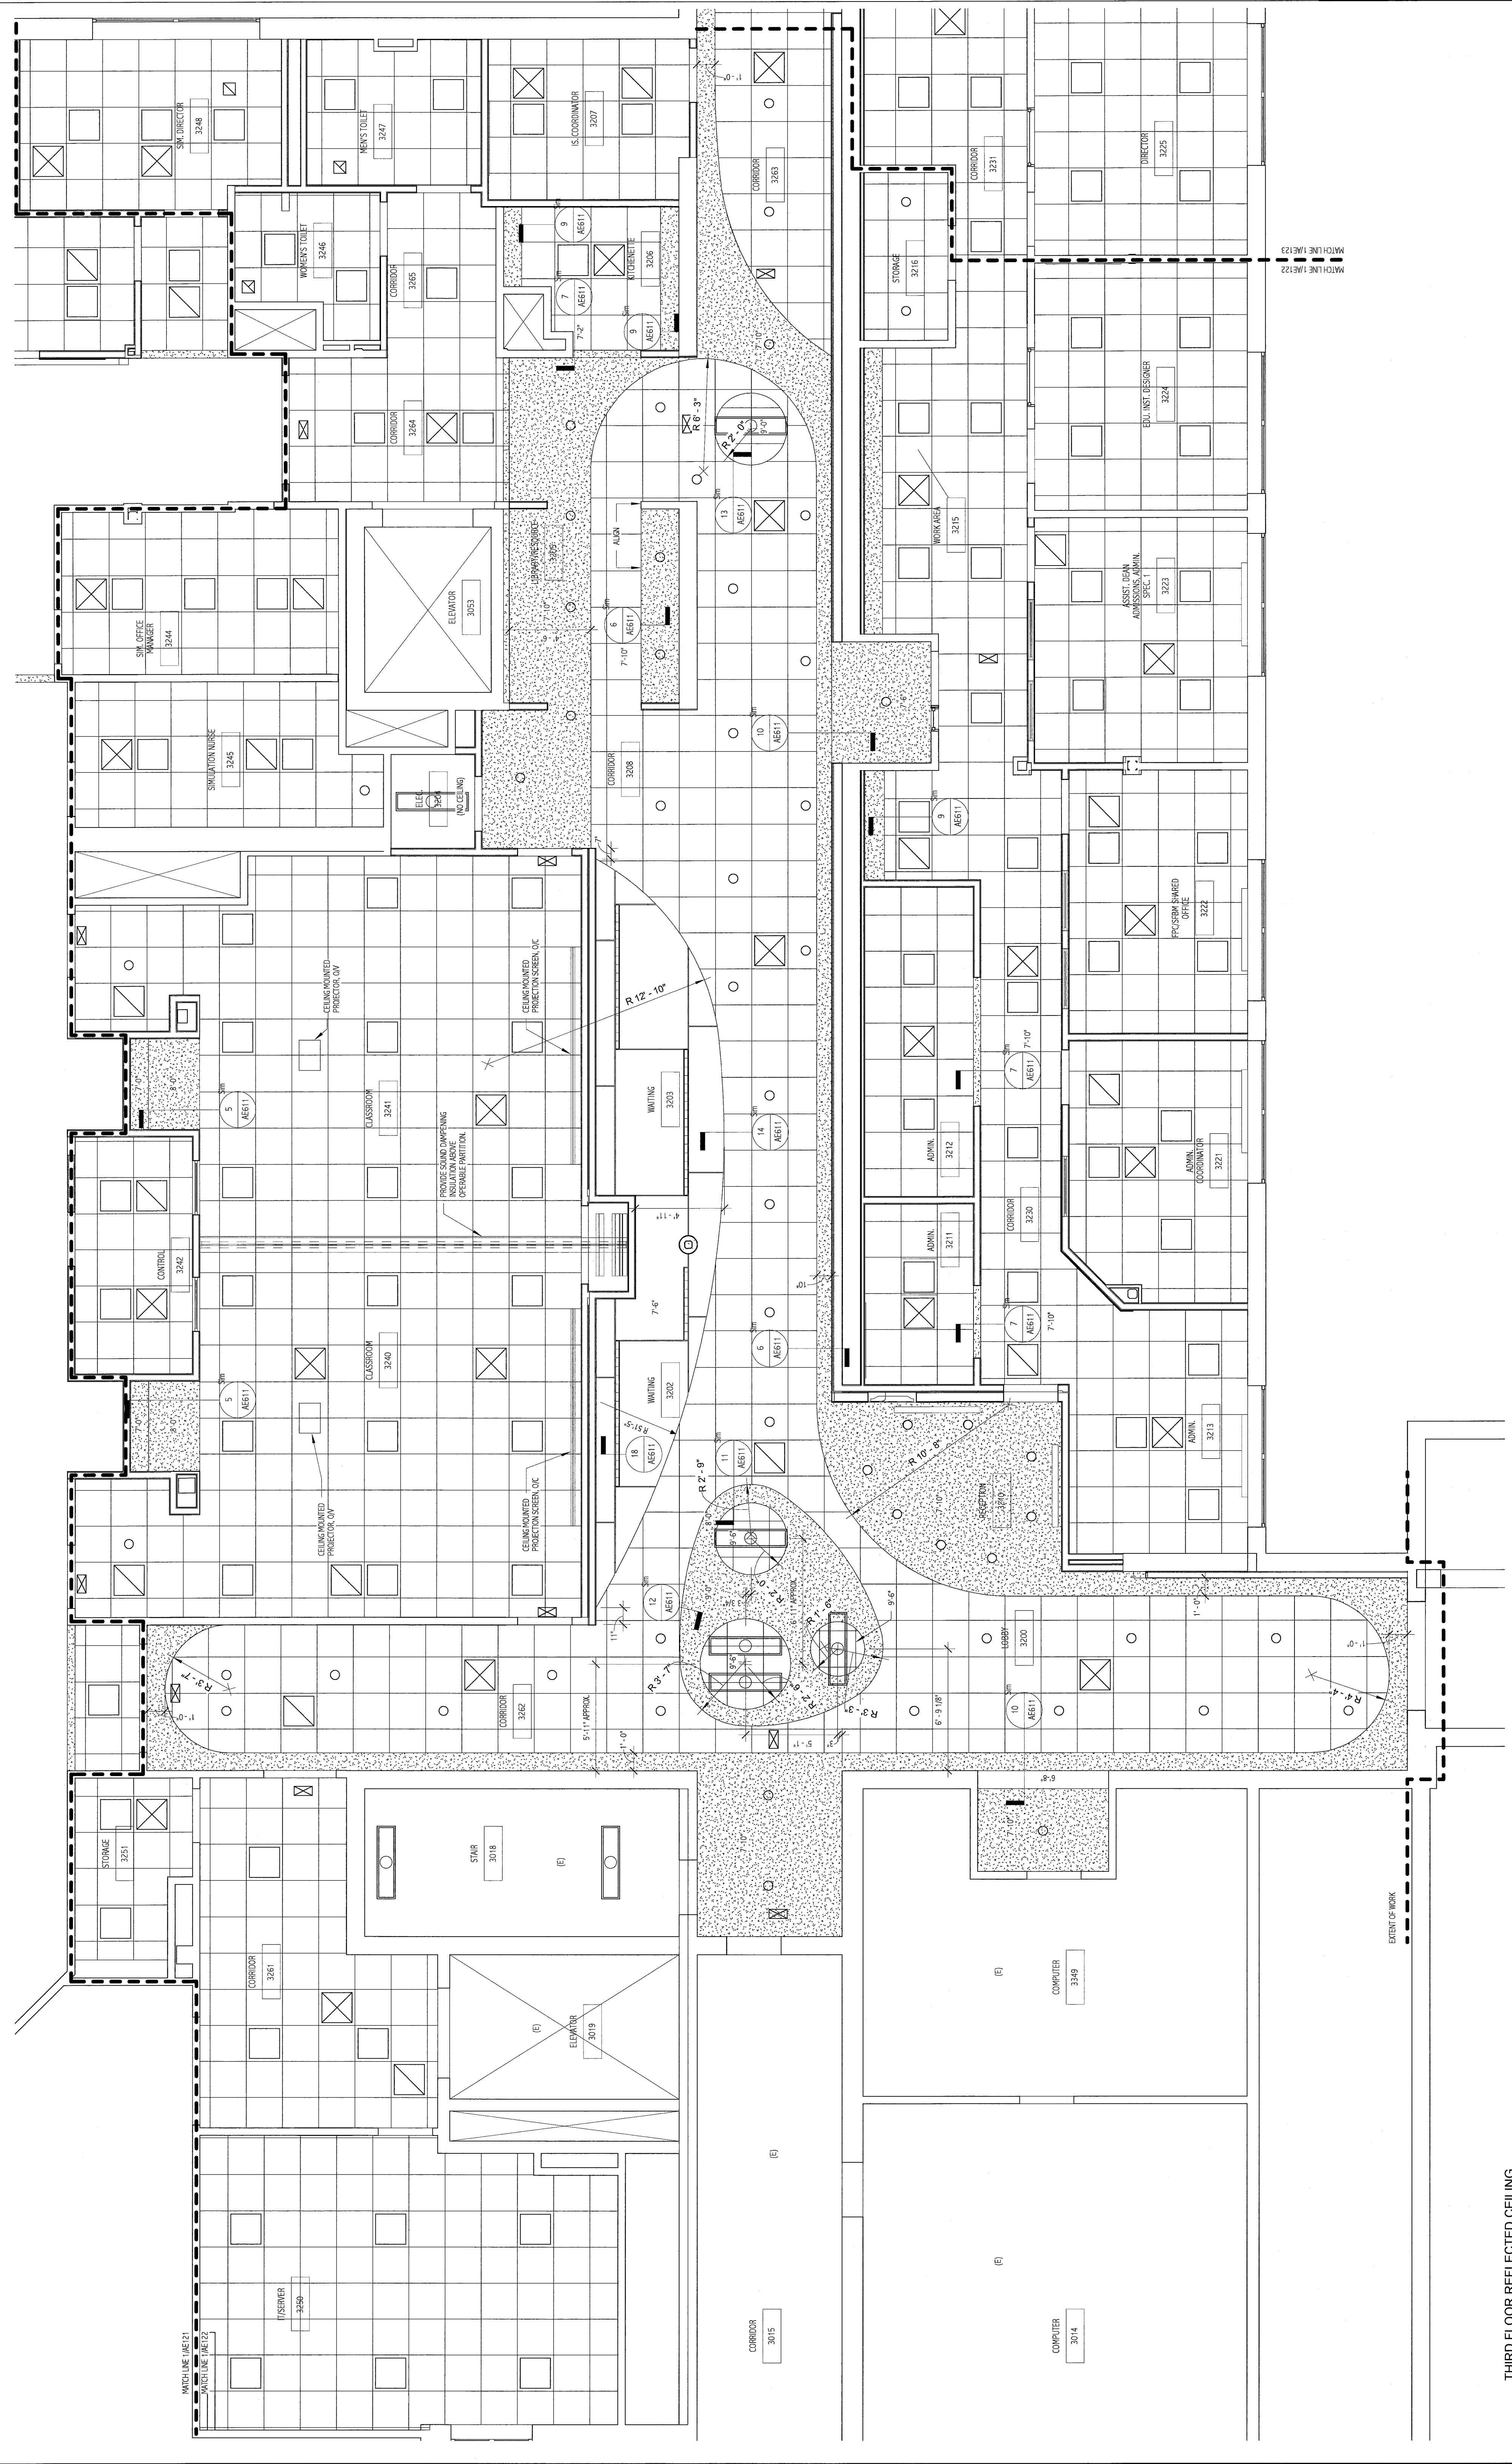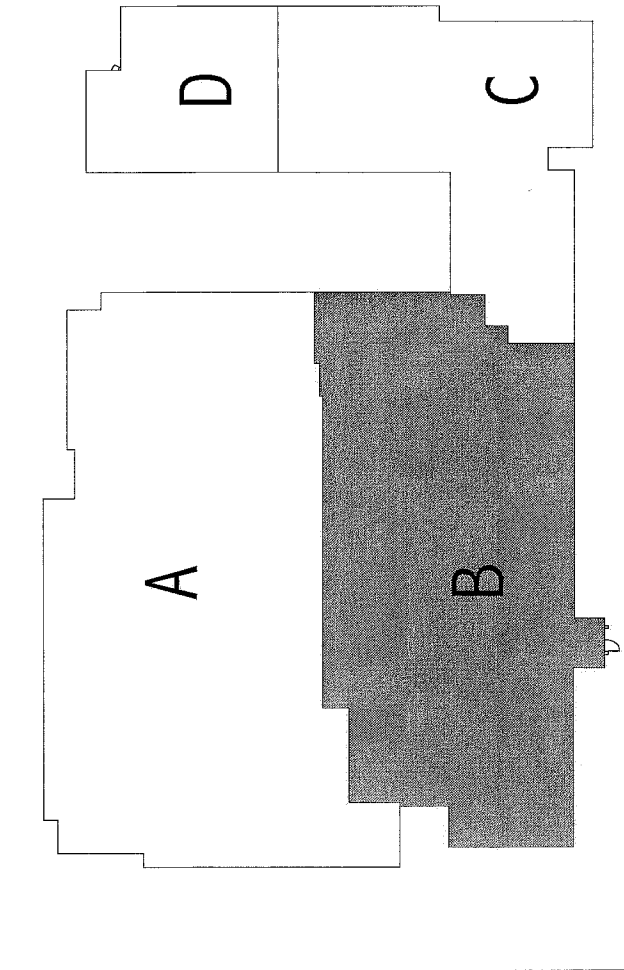

ISSUED FOR CONSTRUCTION
4-24-09

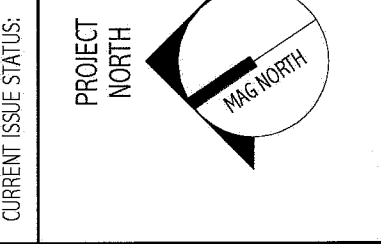

ARCHITECTURE
ENGINEERING
PLANNING
INTERIOR DESIGN
COMMISSIONS



THIRD FLOOR REFLECTED CEILING PLAN - AREA B

SCALE	A=HORIZONTAL	DATE	4-24-09
PROJECT NUMBER	00P	GRAPHIC SCALE	0' 1'
DATE OF WORK	00P	SHEET No.	AE122
PROJECT No.	00000	DATE OF RECORD	

THIRD FLOOR REFLECTED CEILING
PLAN - AREA B
1/4" = 1'-0"