


**NOTE:**  
1. SEE SHEET M-001 FOR LEGEND AND ABBREVIATIONS.  
2. REFER TO DRAWING A-001 FOR DEFINITION OF ALTERNATES.

**KEYED NOTES:**  
① OFFSET DUCTWORK AS NEEDED TO CROSS NEW STEEL.  
② RETURN TO PRE-CONSTRUCTION AIRFLOW BALANCE.

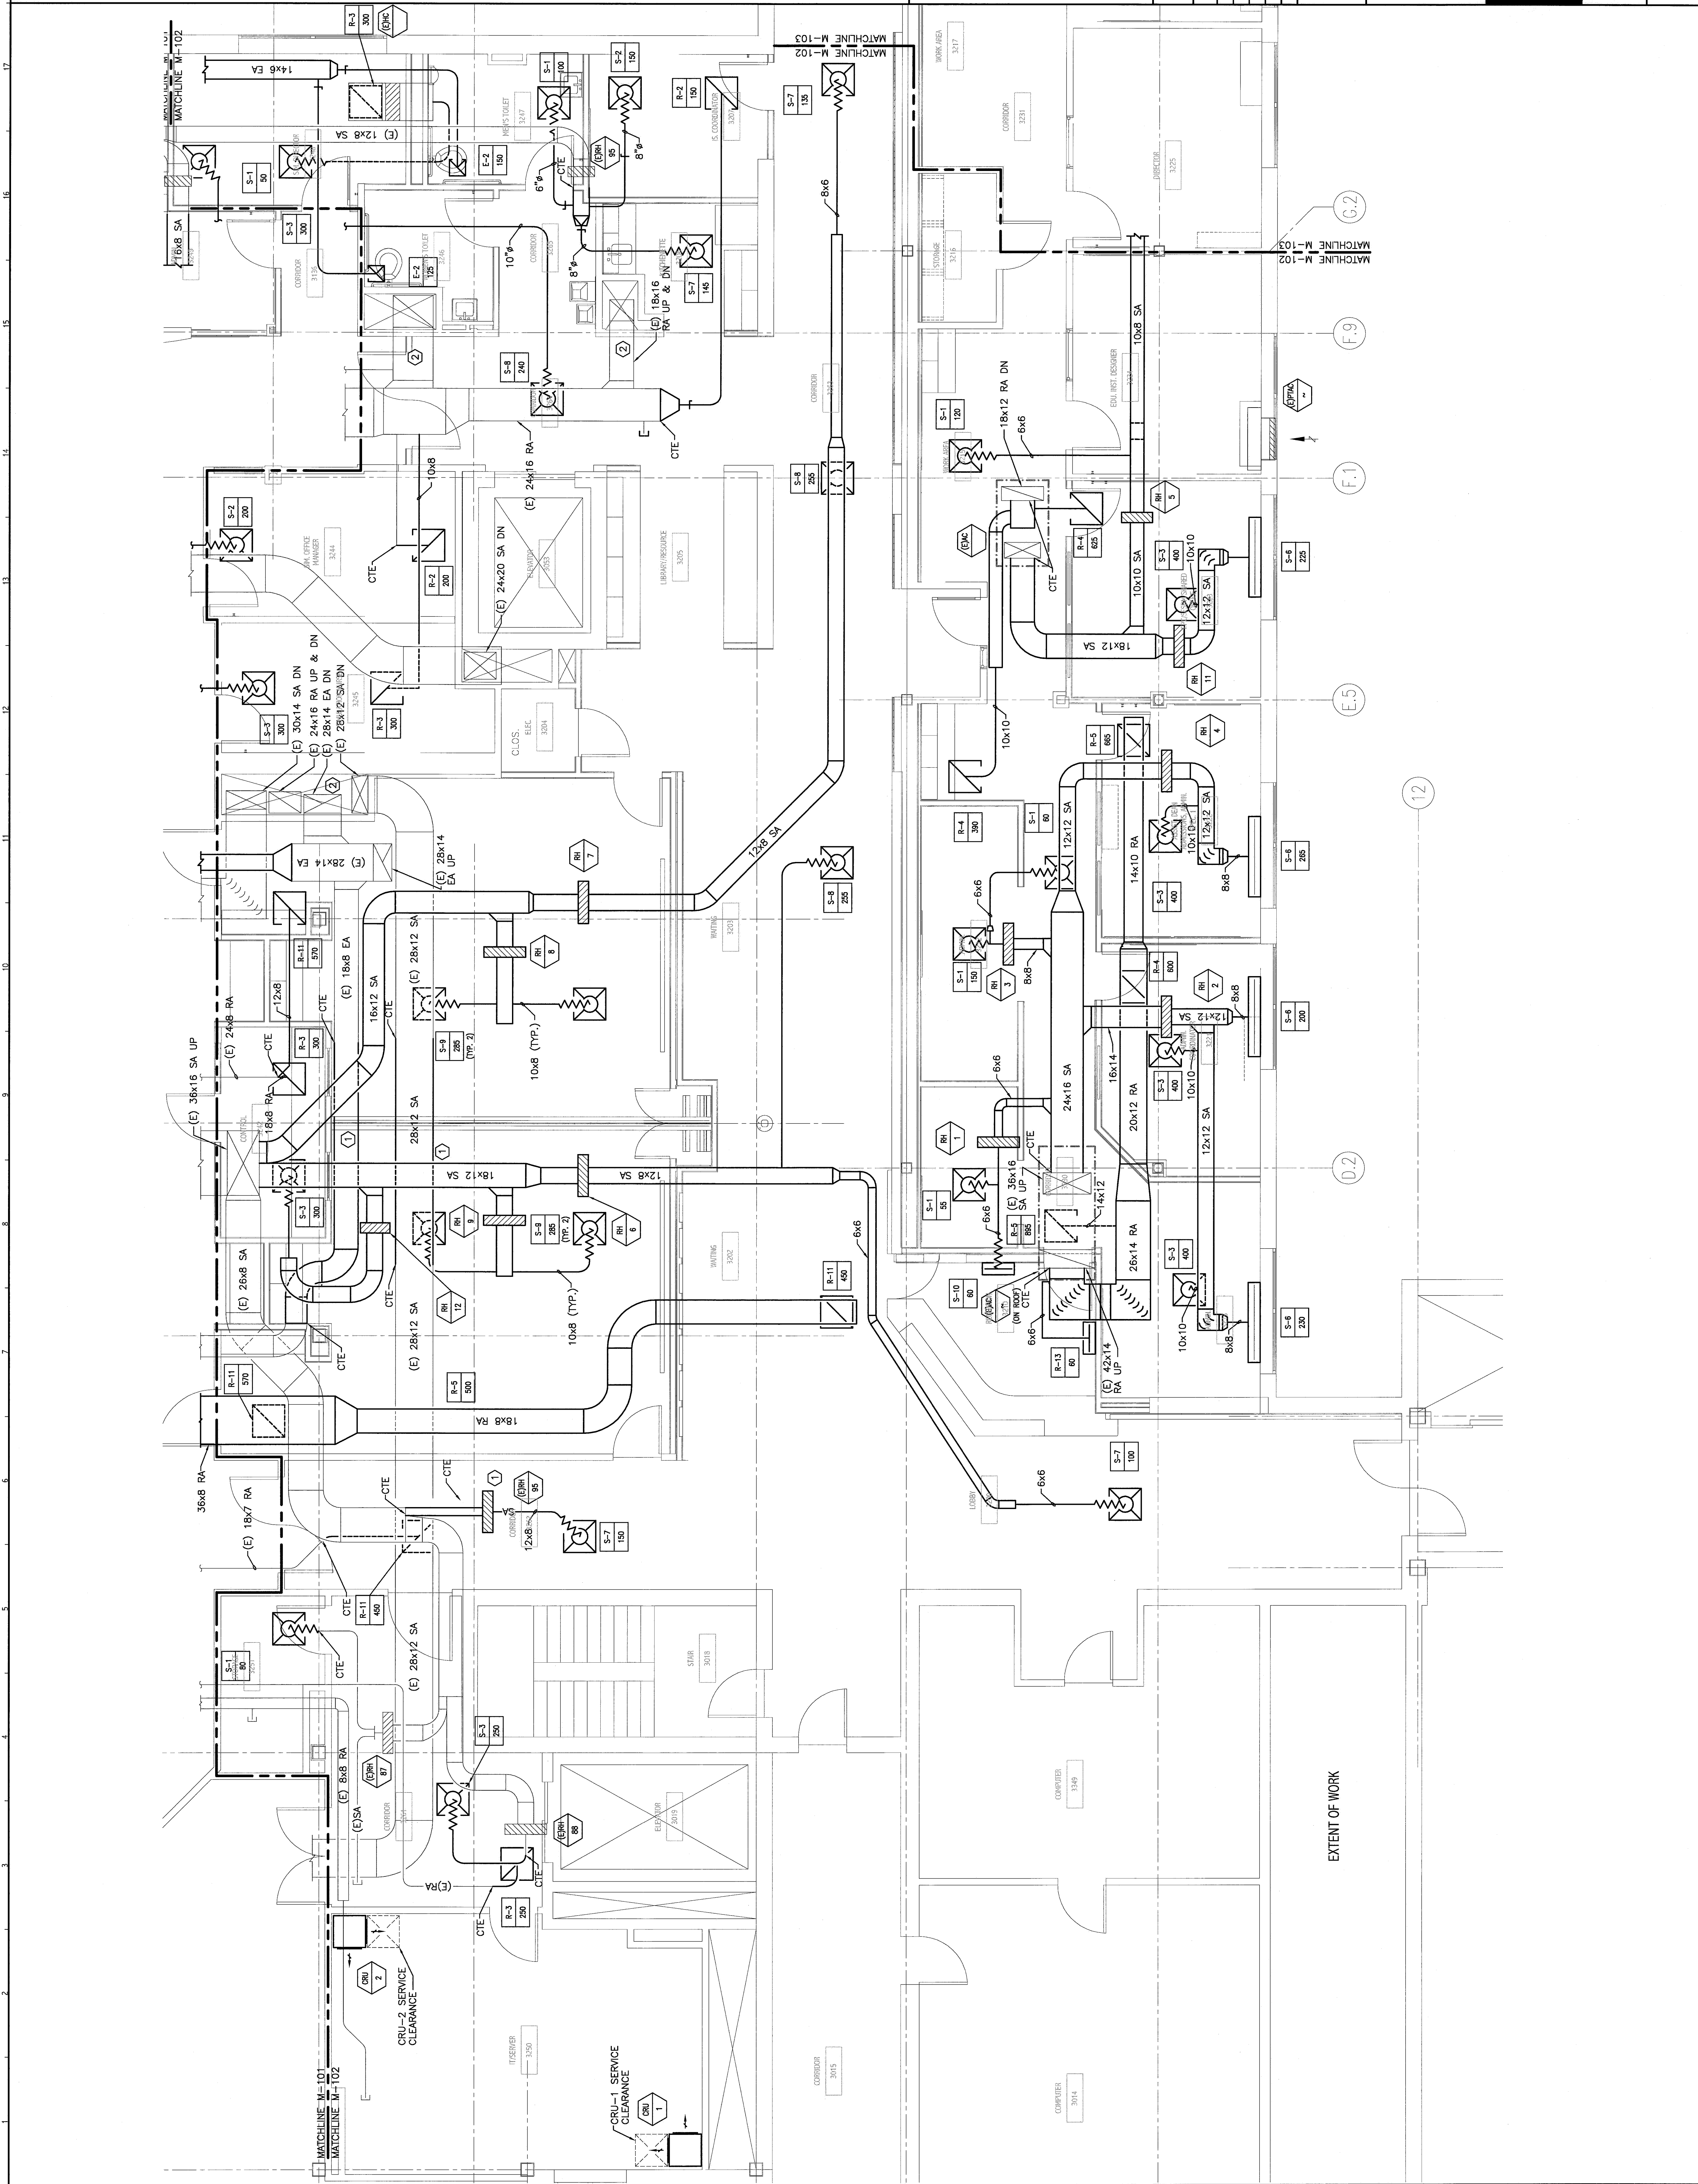

A1	THIRD FLOOR FACILITY PLAN	1/4"=1'-0"
F18	KEY PLAN	
0	ISSUED FOR CONSTRUCTION	4-24-09
	DESCRIPTION	
	DATE	

PROJECT NORTH

ISSUED FOR CONSTRUCTION  
4-24-09

SMRTI  
ARCHITECTURE  
ENGINEERING  
PLANNING  
INTERIOR DESIGN  
COMMISSIONING

144 Fore Street P.O. Box 618  
Portland, Maine 04104  
Tel: (207) 775-3946  
Fax: (207) 775-0070  
www.smrti.com

MAINE MEDICAL CENTER  
OFFICE OF MEDICAL EDUCATION  
PORTLAND, MAINE

THIRD FLOOR - AREA B  
HVAC DUCTWORK PLAN

SHEET TITLE	1/4"=1'-0"	DATE	4-24-09
PROJECT MANAGER	CP	GRAPHIC SCALE	0'
DB COPY/OWNER	BAJ/DB		
NAME OF RECORD	RNE	SHEET No.	M-102
SMART CAD FILE	M-102-08093		
PROJECT No.	08093-00		

