
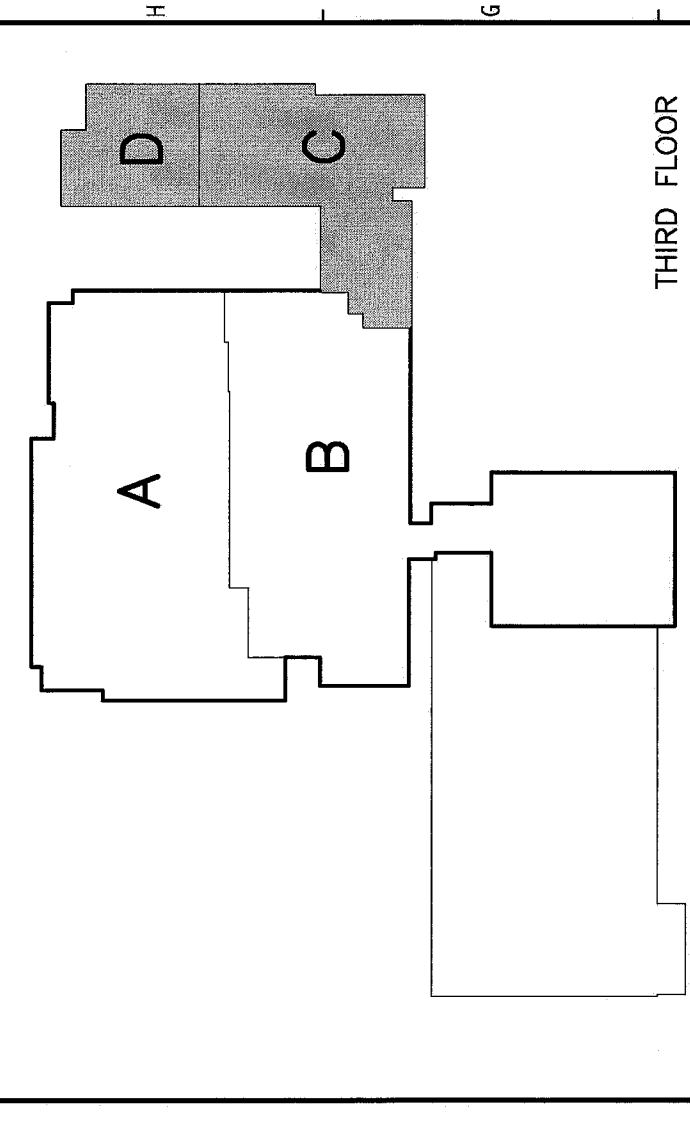


NOTE:
 1. SEE SHEET M-001 FOR LEGEND AND ABBREVIATIONS.
 2. REFER TO DRAWING A-001 FOR DEFINITION OF ALTERNATES.


KEYED NOTES:
 (1) NOT USED.
 (2) 8x6 EA UP TO (E)EE-3 ON ROOF.
 (3) 12x6 EA UP TO (E)EE-5 ON ROOF.
 (4) 12x10 EA UP TO (E)EE-5 ON ROOF.

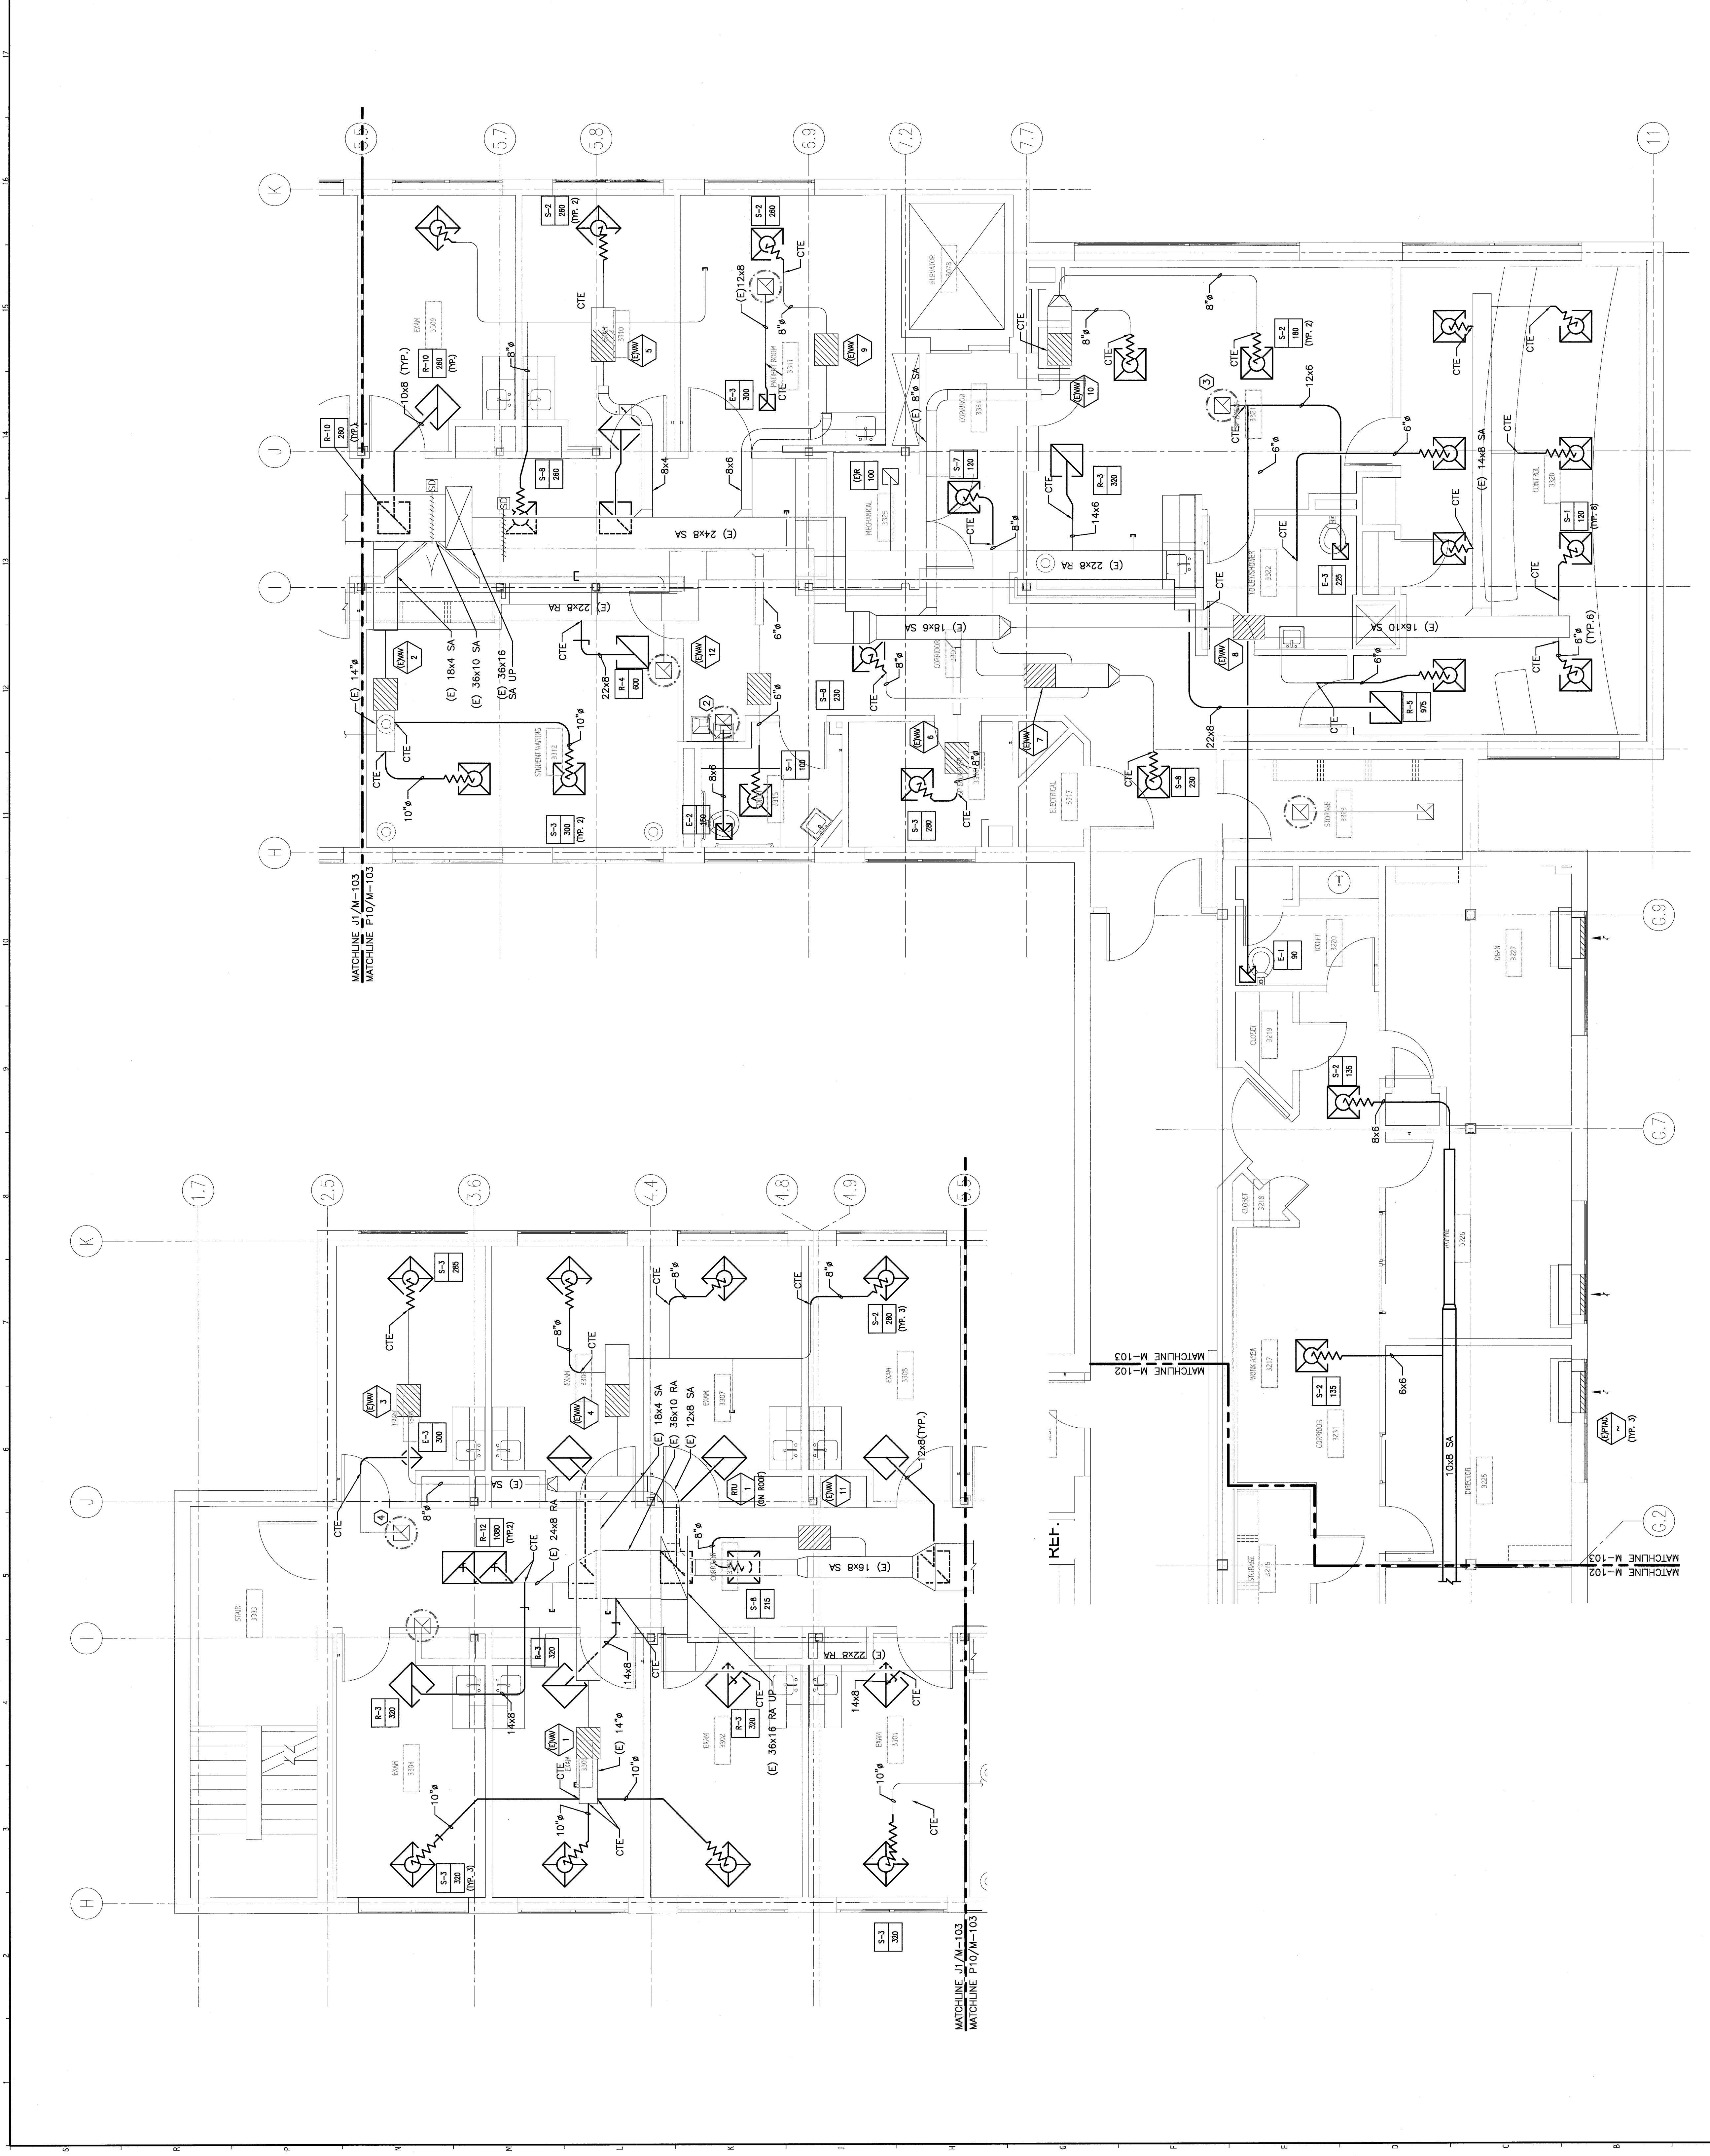

F18 KEY PLAN

REV.	ISSUED FOR CONSTRUCTION	DATE
0		4-24-09

ISSUED FOR CONSTRUCTION
 4-24-09

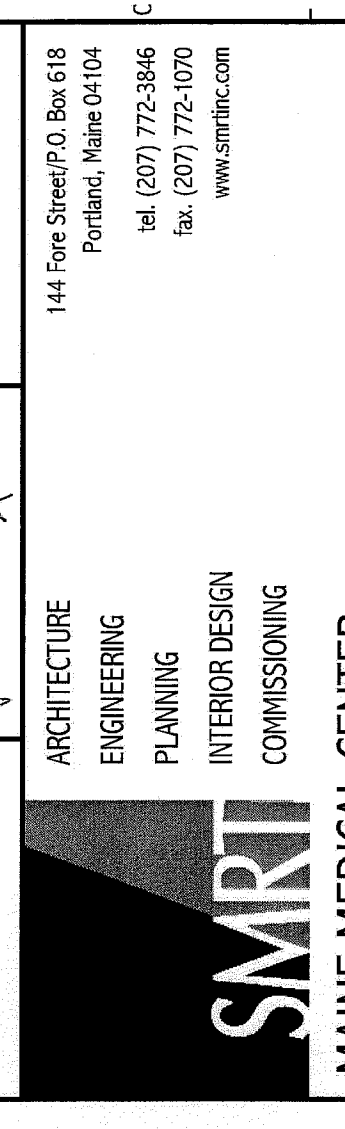

SMRTI
 MAINE MEDICAL CENTER
 OFFICE OF MEDICAL EDUCATION
 PORTLAND, MAINE

THIRD FLOOR AREA C & D
 HVAC DUCTWORK PLAN

PROJECT NO.	08059-00
DATE	4-24-09
GRAPHIC SCALE	0' = 1"
PROJECT MANAGER	CARDIL
DATE OF RECORD	RHE
SHEET NO.	M-103
PROJECT TITLE	M-103

A1 THIRD FLOOR PLAN

1/2" = 1'-0"