


NOTE:
 1. SEE SHEET PLOT1 FOR LEGEND AND ABBREVIATIONS.
 2. REFER TO DRAWING A-001 FOR DEFINITION OF ALTERNATES.


KEYED NOTES:
 ① PIPING LOCATED IN CEILING OF FLOOR BELOW.
 ② CONNECT TO EXISTING CW, HW, V, AND W PIPING IN WALL.
 ③ 4" V-RISE AND 4" S IN CEILING OF FLOOR BELOW. OFFSET
 4" S PIPING IN CEILING OF FLOOR BELOW AND CONNECT TO
 EXISTING 4" S-DROP.

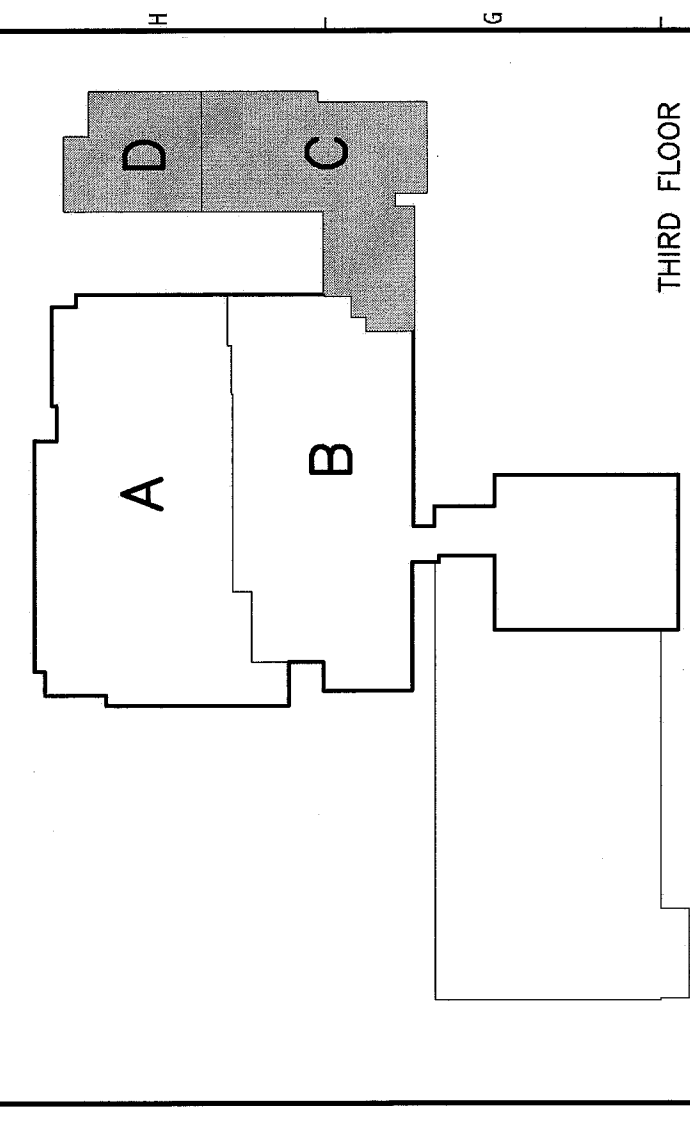

F18 KEY PLAN

REV.	ISSUED FOR CONSTRUCTION	DATE
0		4-24-09

ISSUED FOR CONSTRUCTION
 4-24-09

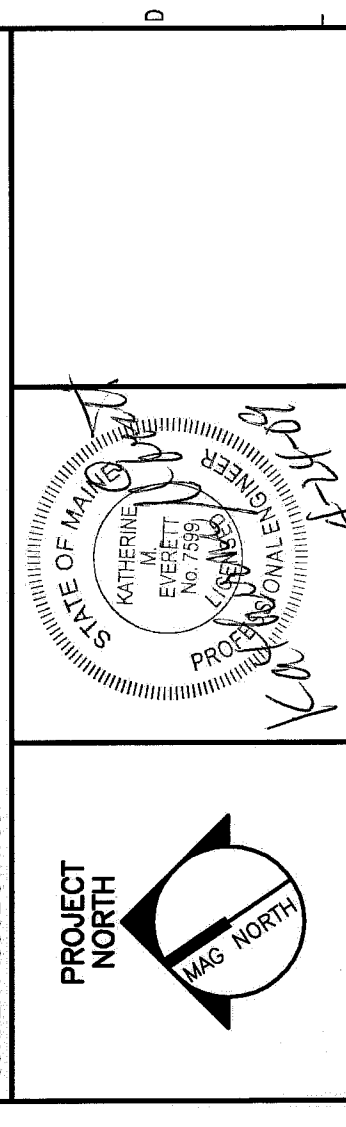

144 Free Street, P.O. Box 618
 Portland, Maine 04104
 Tel: (207) 776-3846
 Fax: (207) 776-0070
 www.smrti.com

SMRTI
 ARCHITECTURE
 ENGINEERING
 PLANNING
 INTERIOR DESIGN
 COMMISSIONING

MAINE MEDICAL CENTER
 OFFICE OF MEDICAL EDUCATION
 PORTLAND, MAINE

THIRD FLOOR AREA C & D
 PLUMBING PLAN

SCALE:	1/4"=1'-0"	DATE:	4-24-09
PROJECT MANAGER:	CP	GRAPHIC SCALE:	0'
DD CAP/DRAWN:	CAU/JPB		
AE OF RECORD:	KME	SHEET No.:	PL103
SHEET CAD FILE:	PL103-08093	PROJECT No.:	08093-00

A1 THIRD FLOOR PLAN

1/4"=1'-0"