

H14 REFLECTED CEILING PLAN
1/4" = 1'-0"

LEGEND:

- MECHANICAL DIFFUSER
- LIGHT FIXTURE
- ACOUSTIC PANEL CEILING
- GYPSUM WALL BOARD CEILING

PLAN NORTH


KEY PLAN

Allied Engineering
Structural Mechanical Electrical Consulting
160 Veranda Street
Portland, Maine 04103
T: 307.251.2268
F: 307.251.2266
Web: www.allied-eng.com

REV.	DESCRIPTION	DATE
--	--	--
--	--	--
--	--	--

ISSUED FOR CONSTRUCTION
09 / 25 / 15

CURRENT ISSUE STATUS:

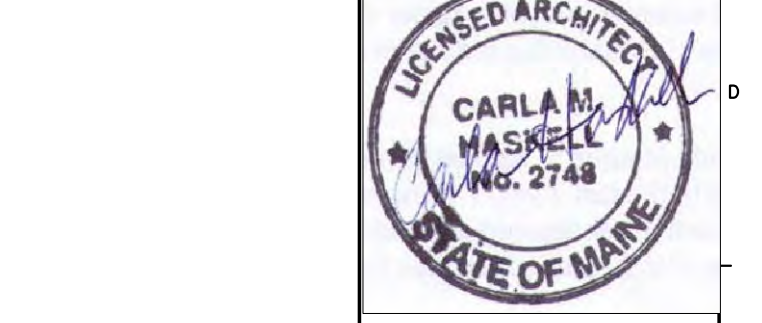

SEE SHEET G1001 FOR GENERAL NOTES.

- GENERAL NOTES:**
1. CEILING HEIGHTS AT NEW CEILINGS TO MATCH EXISTING ADJACENT CEILINGS.
 2. SEE FINISH SCHEDULE AND SPECIFICATION FOR ACOUSTIC PANEL CEILING TYPES AND LOCATIONS.
 3. MAINTAIN AND PROVIDE 2 HOUR RATED SPRAY FIRE PROOFING TO DECK AND BAR JOISTS ABOVE EXPOSED AS PART OF THIS WORK.

DESIGN GROUP COLLABORATIVE
ARCHITECTURE
DESIGN + PLANNING

40 CHURCH STREET
ELLSWORTH, MAINE
(207) 664-0560

22 FREE STREET
PORTLAND, MAINE
(207) 659-3300

**MAINE MEDICAL CENTER
PREP NORDX RENOVATIONS**
PORTLAND, MAINE

REFLECTED CEILING PLAN

SHEET TITLE:	REFLECTED CEILING PLAN	
DATE:	9/25/15	GRAPHIC SCALE:
SCALE:	AS NOTED	
PROJECT NO.:	122033	SHEET No.:
DRAWN BY:	LMC	
A/E OF RECORD:	CMH	

AE-102

A1 REFLECTED CEILING PLAN
1/4" = 1'-0"