
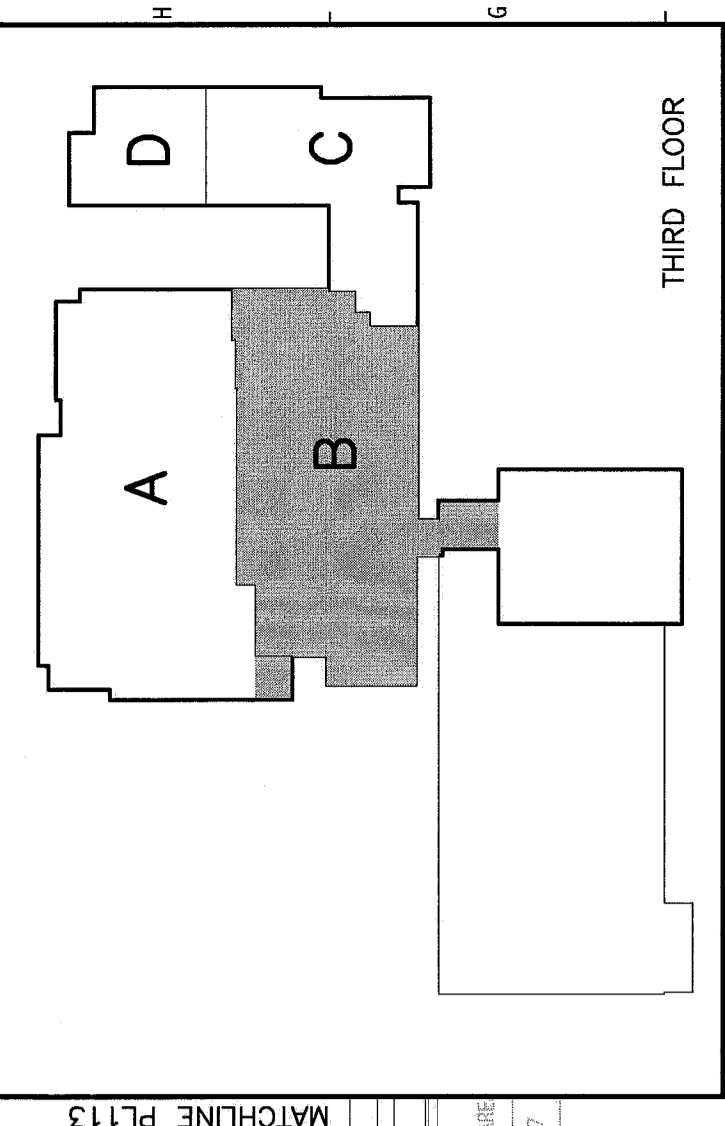



- NOTE:**
- SEE SHEET PLOT FOR LEGEND AND ABBREVIATIONS.
  - REFER TO DRAWING A-001 FOR DEFINITION OF ALTERNATES.

- KEYED NOTES:**
- PIPING LOCATED IN CEILING BELOW.
  - PROVIDE A WATER HAMMER ARRESTOR WITH SHUT-OFF VALVE-ACCESSIBLE.
  - 1/2" CW-UP IN CHASE. ROUTE 1" CW TO WC-A AND 3/4" CW TO UR-B.
  - 1" CW-UP IN WALL.
  - 1/2" CW AND 1/2" HW-UP IN WALL. ROUTE 1/2" CW AND 1/2" HW-EACH TO SK-B. ROUTE 1/2" CW TO EMC-A. 1/2" CW THRU 1/2" DUAL CHECK BACKFLOW PREVENTER AND FILTER AND CONNECT TO OWNER SUPPLIED COFFEE MAKER.
  - 1/2" CW-DROP TO TRAP PRIMER VALVE. SEE DETAIL A47/FL501-SIMILAR.
  - 1/2" CW AND 1/2" HW-RISE IN WALL. ROUTE 1/2" CW AND 1/2" HW-EACH TO LAV-A. ROUTE 1/2" CW TO TRAP PRIMER VALVE AND TRAP PRIME FUNNEL DRAIN.

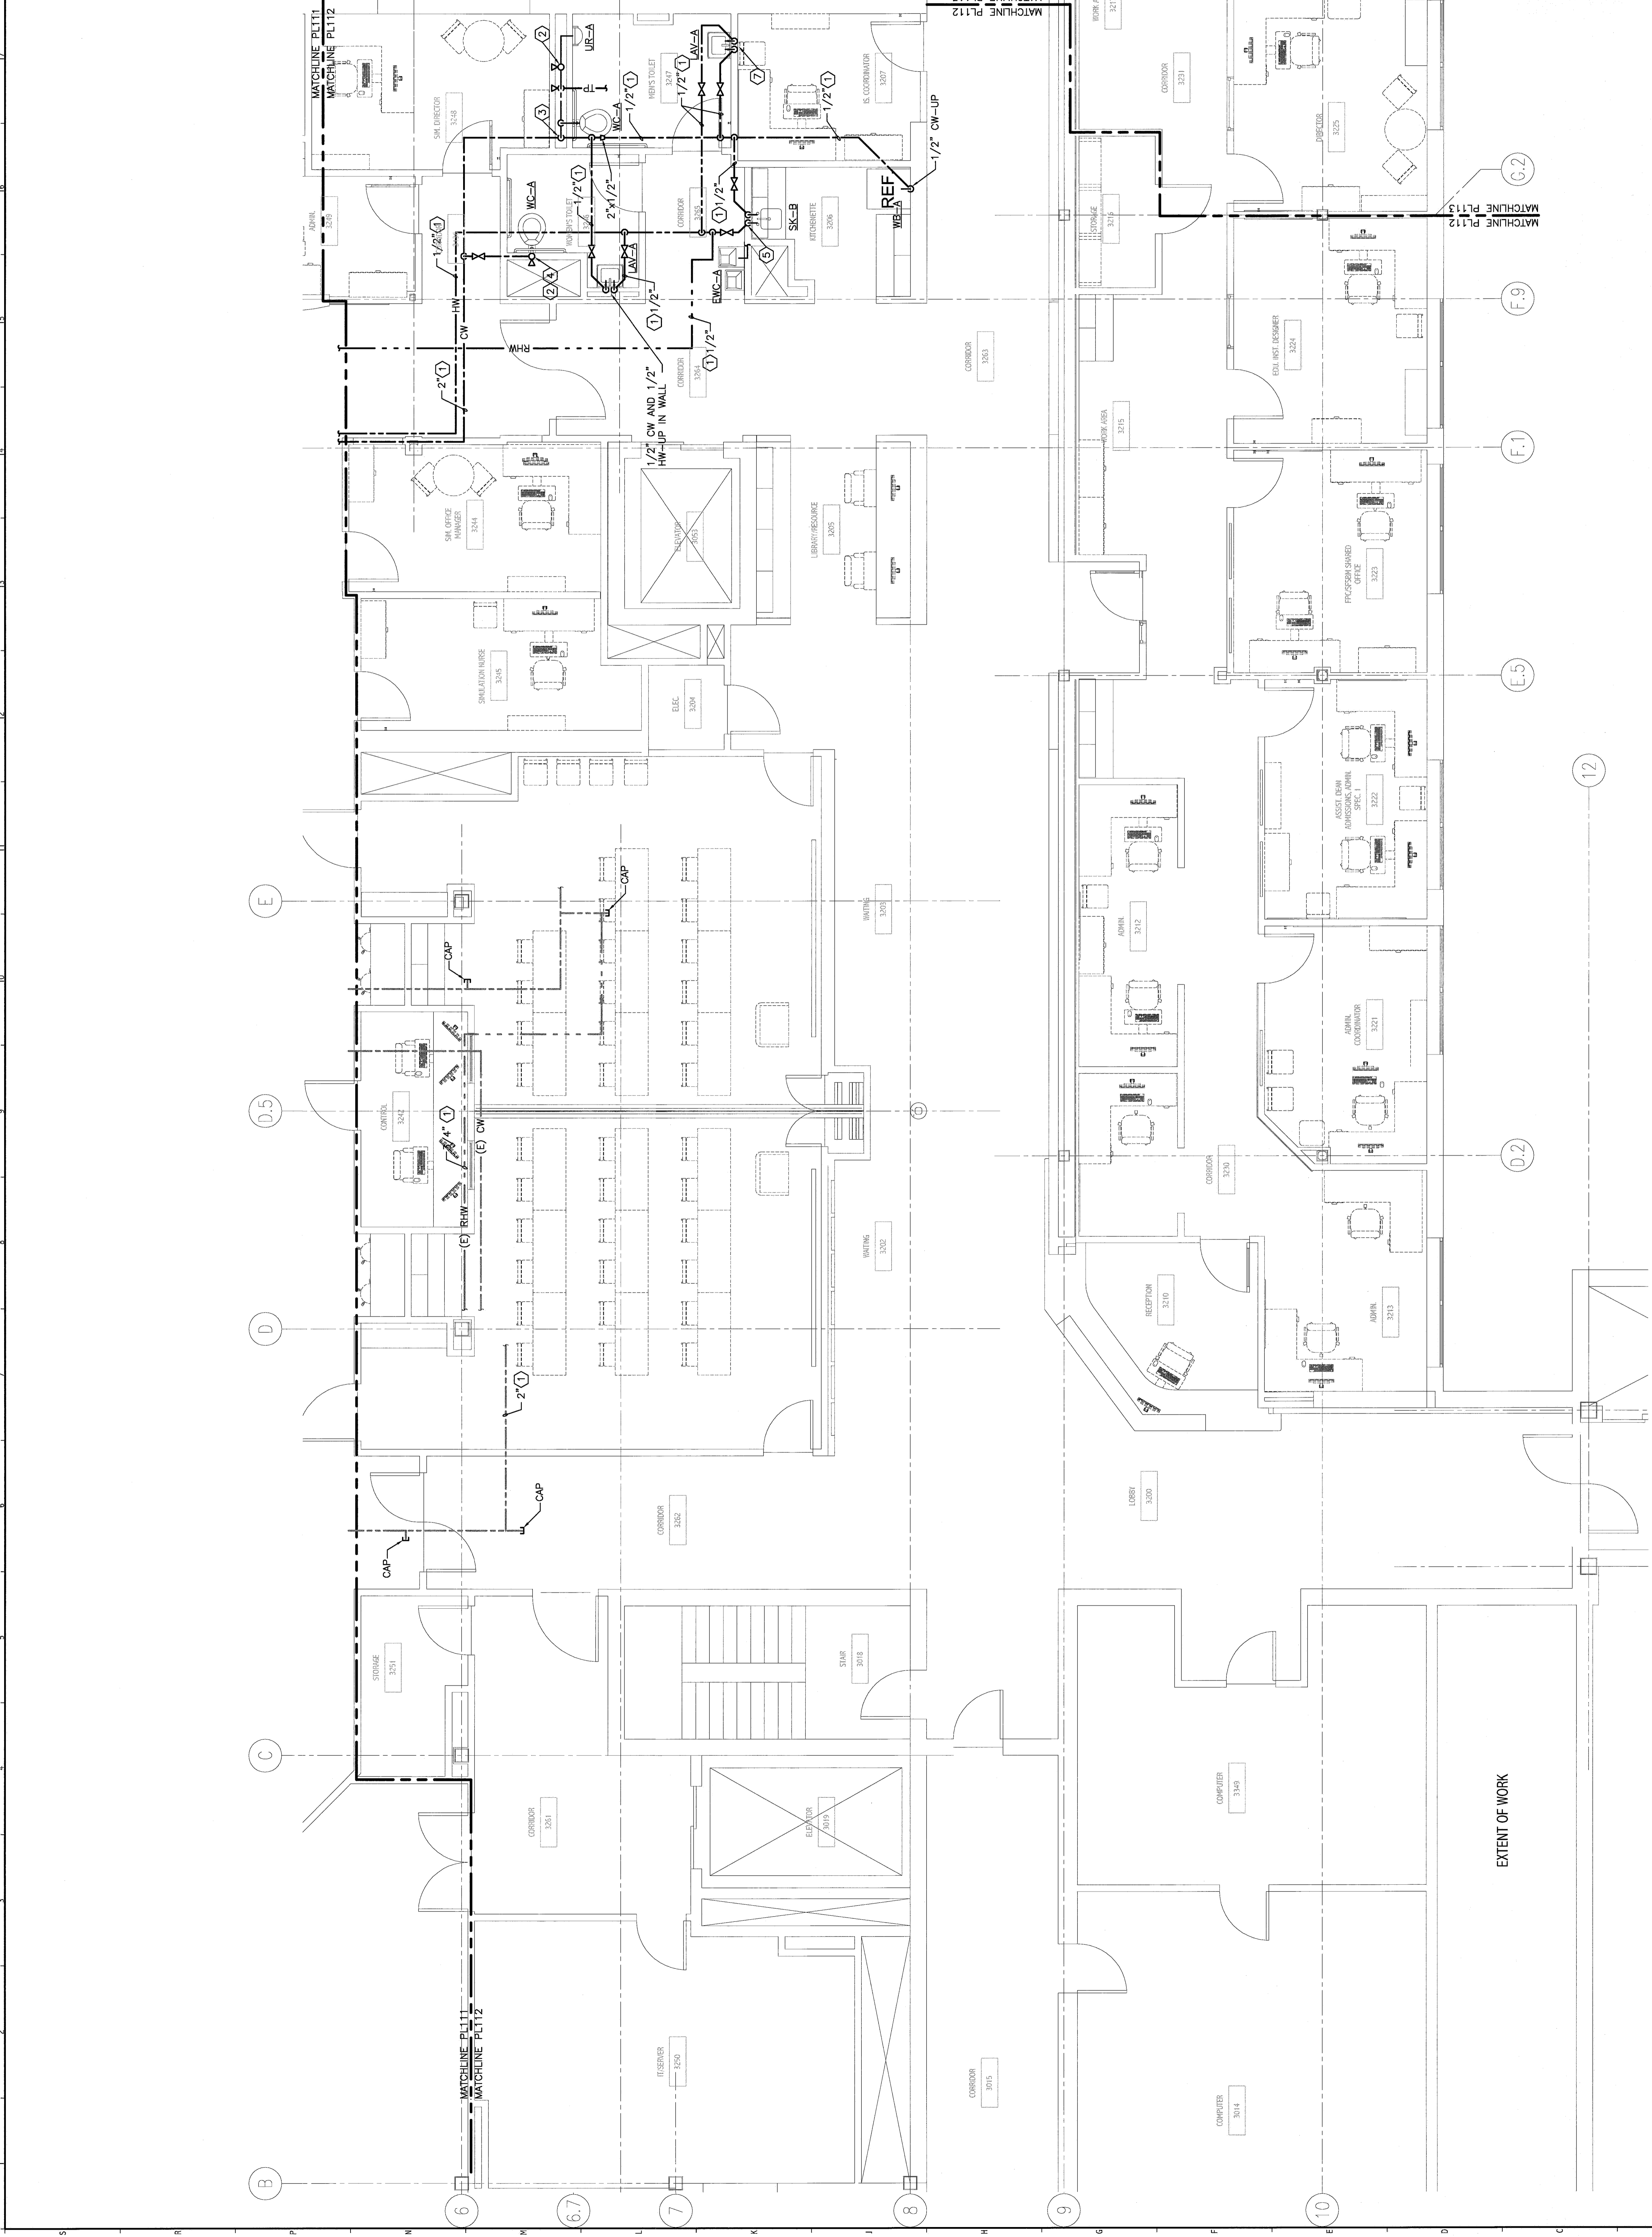

REV.	ISSUED FOR CONSTRUCTION	DATE
0		4-24-09

**ISSUED FOR CONSTRUCTION**  
4-24-09

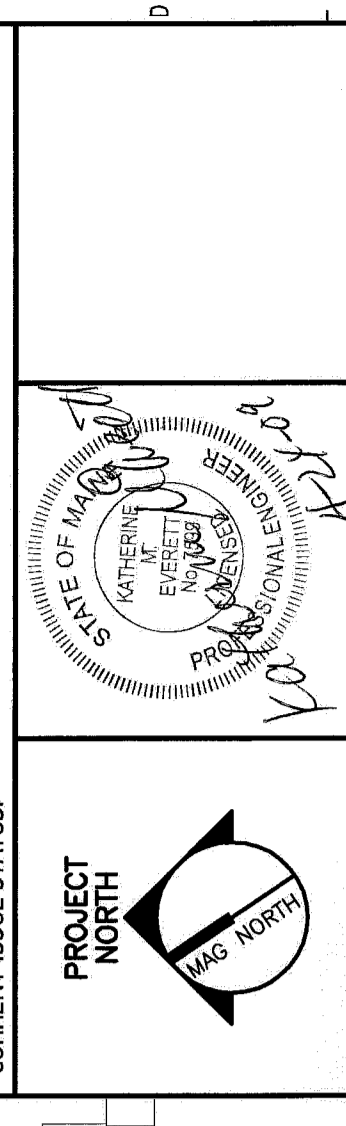

PROJECT NORTH  
ARCHITECTURE  
ENGINEERING  
PLANNING  
INTERIOR DESIGN  
COMMISSIONING

**SMART**  
MAINE MEDICAL CENTER  
OFFICE OF MEDICAL EDUCATION  
PORTLAND, MAINE

THIRD FLOOR AREA B  
SUPPLY PIPING PLAN

SCALE:	1/4"=1'-0"	DATE:	4-24-09
PROJECT MANAGER:	CP	GRAPHIC SCALE:	0' 1'
JOB CAPTAIN:	CM/HJB		
DATE OF RECORD:	RVE	SHEET No.	PL112
SHEET CAD FILE:	PL112-08093		
PROJECT No.:	08093-00		

**A1 THIRD FLOOR PLAN**

1/4"=1'-0"