
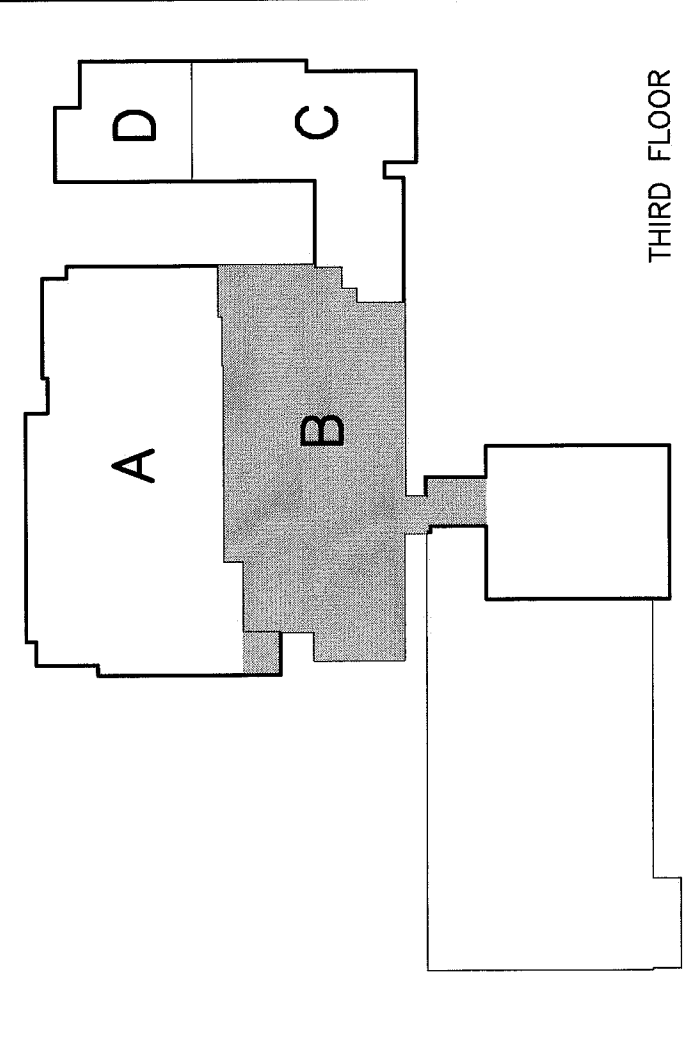


NOTES:

- SEE SHEET E-01 FOR LEGEND AND GENERAL NOTES.
- FOR LOCATION OF PANELBOARDS P43E AND DC, SEE EP101.

KEYED NOTES:


- INSTALL 8" ABOVE COUNTER TO CENTER.
- INSTALL 24" AFF TO CENTER.
- INSTALL 36" AFF TO CENTER.
- INSTALL 48" AFF TO CENTER.
- INSTALL 60" AFF TO CENTER.
- INSTALL 72" AFF TO CENTER.
- INSTALL 84" AFF TO CENTER.
- PROVIDE CONNECTION TO PROJECTION SCREEN.
- INSTALL RECEPTACLE ON RACK. COORDINATE WITH OWNER FOR LOCATION.

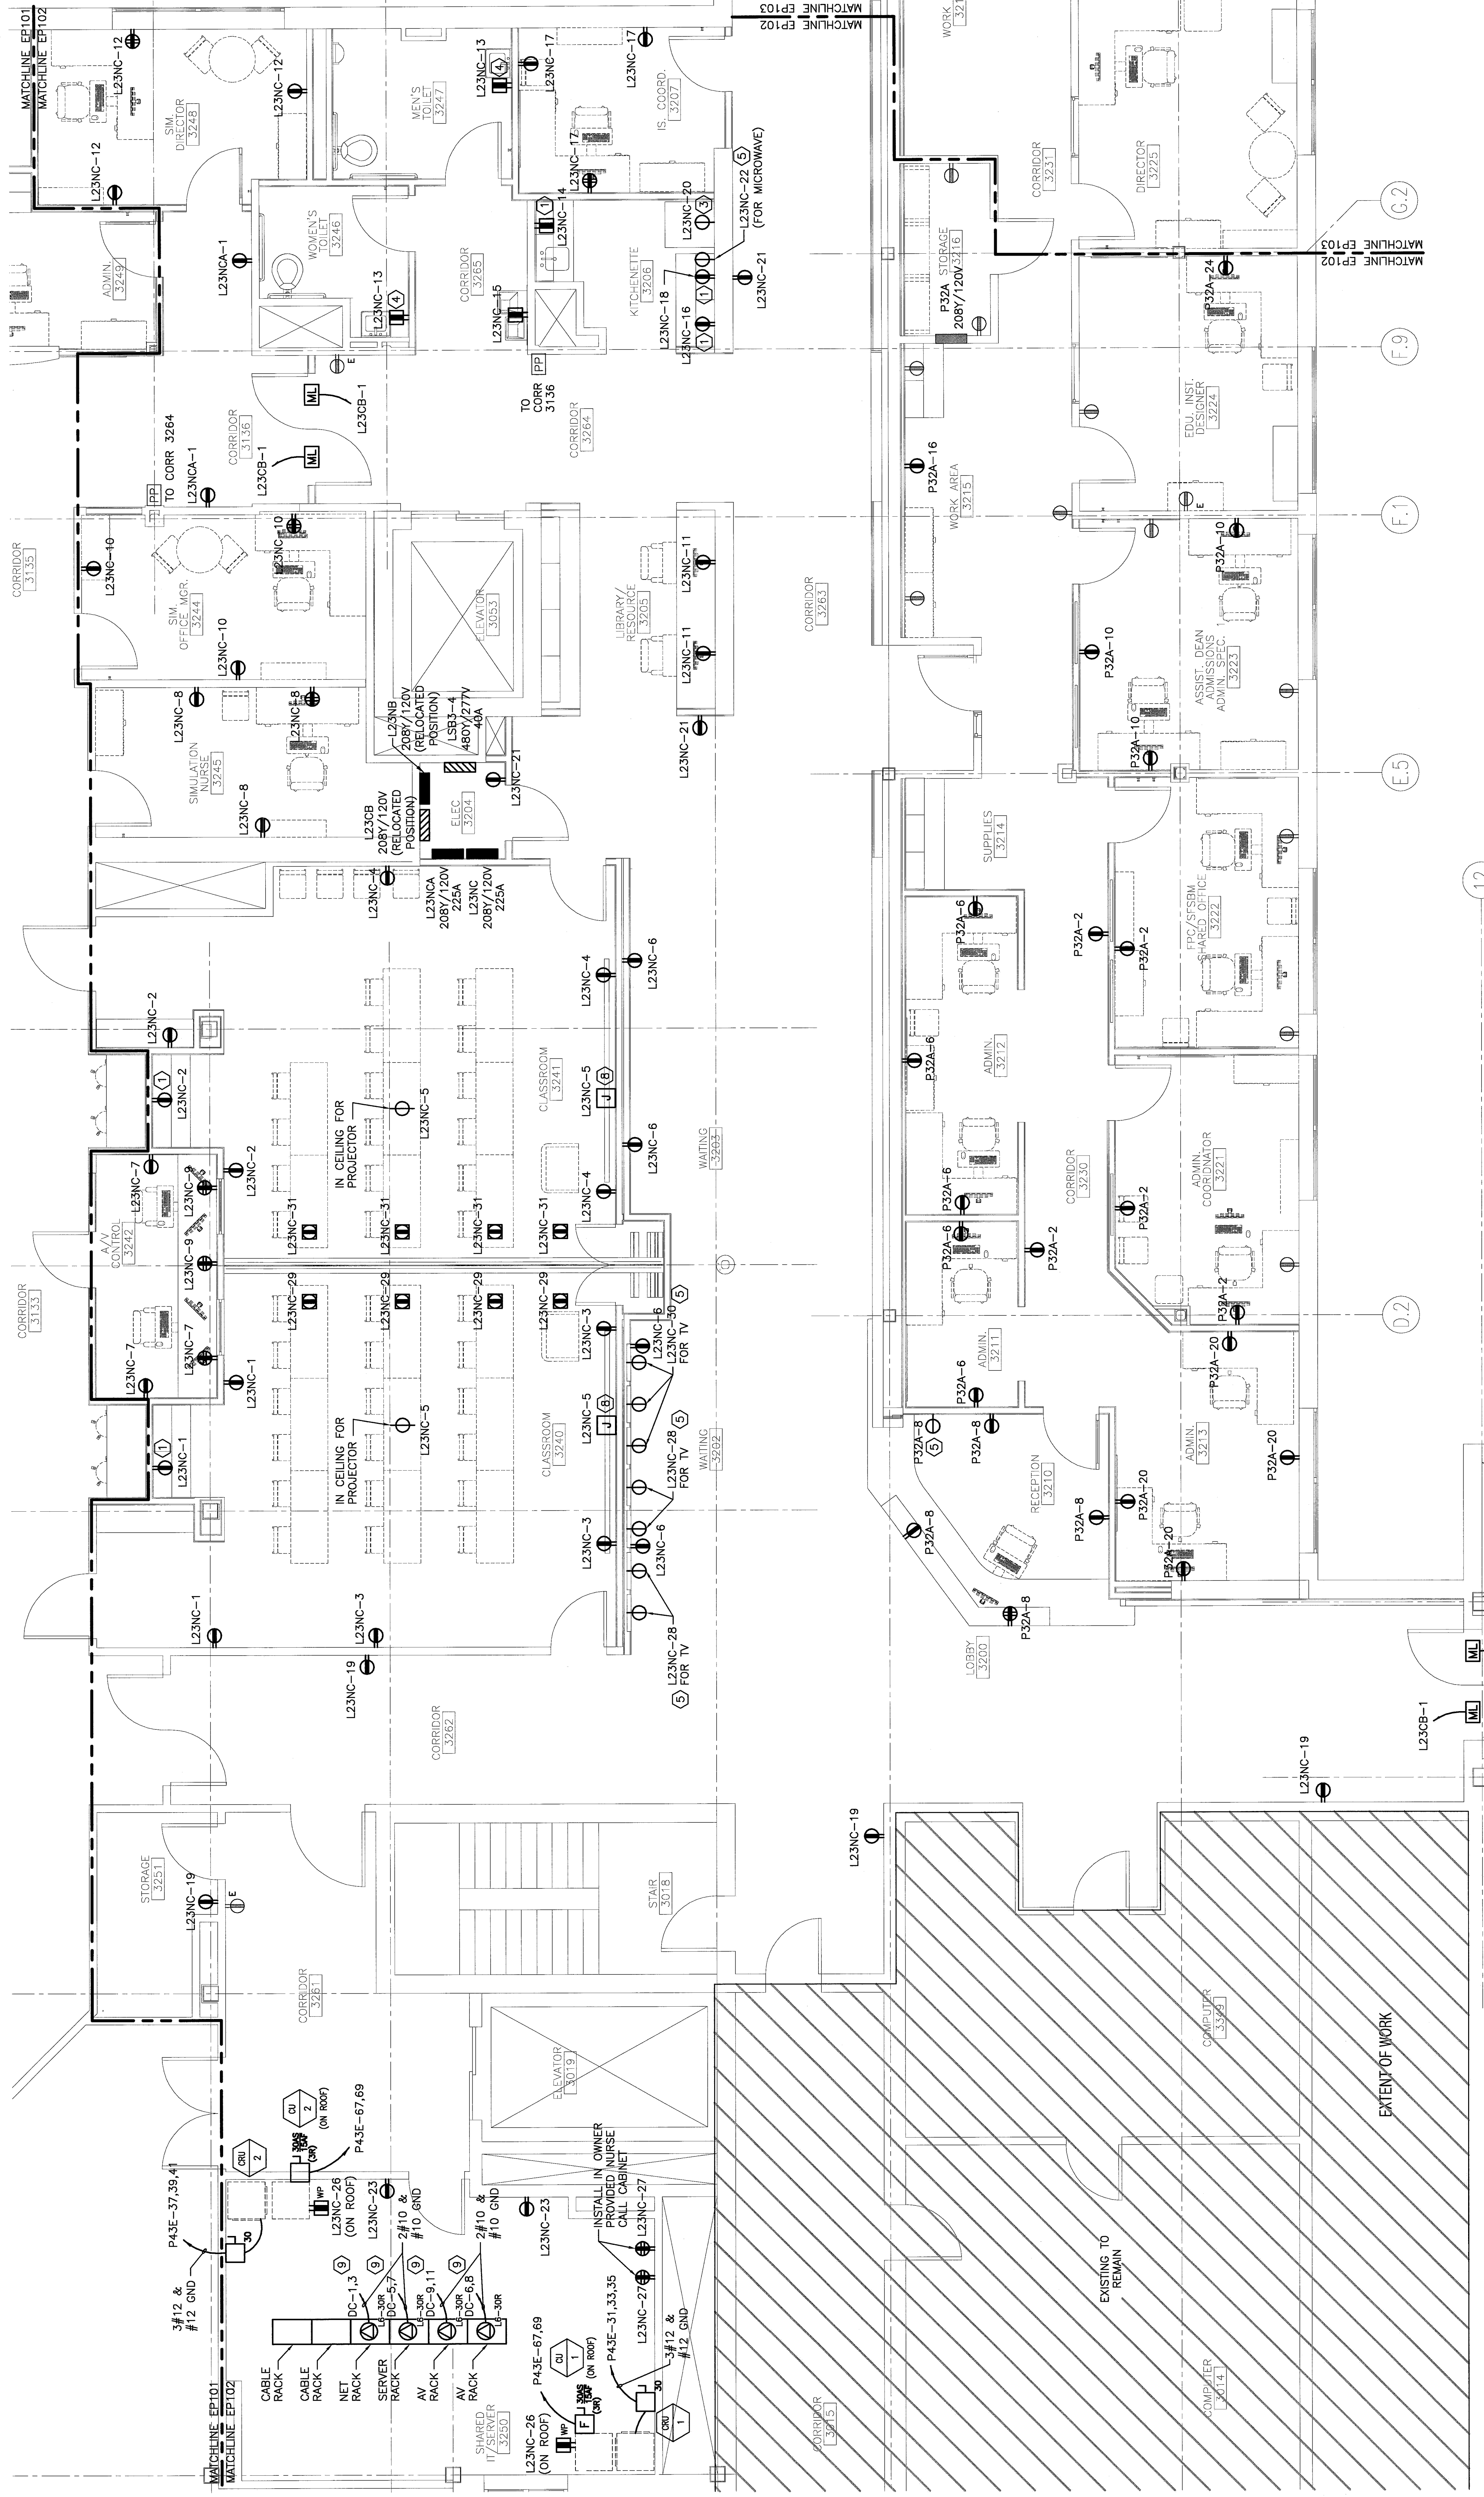

F18 KEY PLAN

REV.	ISSUED FOR CONSTRUCTION	DESCRIPTION	DATE
0			4-24-09

ISSUED FOR CONSTRUCTION
4-24-09

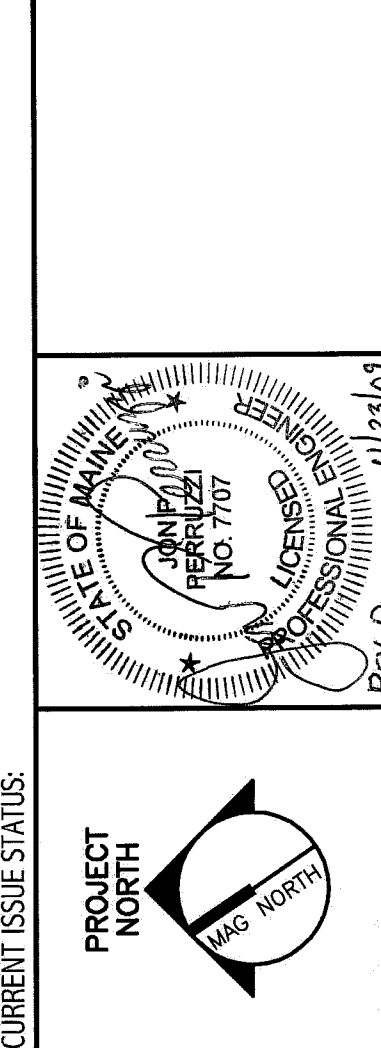

SMRT
ARCHITECTURE
ENGINEERING
PLANNING
INTERIOR DESIGN
COMMISSIONING

MAINE MEDICAL CENTER
OFFICE OF MEDICAL EDUCATION
PORTLAND, MAINE

THIRD FLOOR AREA B
POWER PLAN

SCALE:	1/4"=1'-0"	DATE:	4-24-09
SHEET TITLE:	THIRD FLOOR AREA B POWER PLAN		

PROJECT MANAGER:	CHUCKS	GRAPHIC SCALE:	0'
JOB SUPERVISOR:	CHUCKS	DATE:	4-24-09
DATE OF RECORD:	EP103-08593	SHEET No.:	EP102
PROJECT No.:	08593-00	SHEET No.:	EP102

A1 THIRD FLOOR PLAN

1/4"=1'-0"