
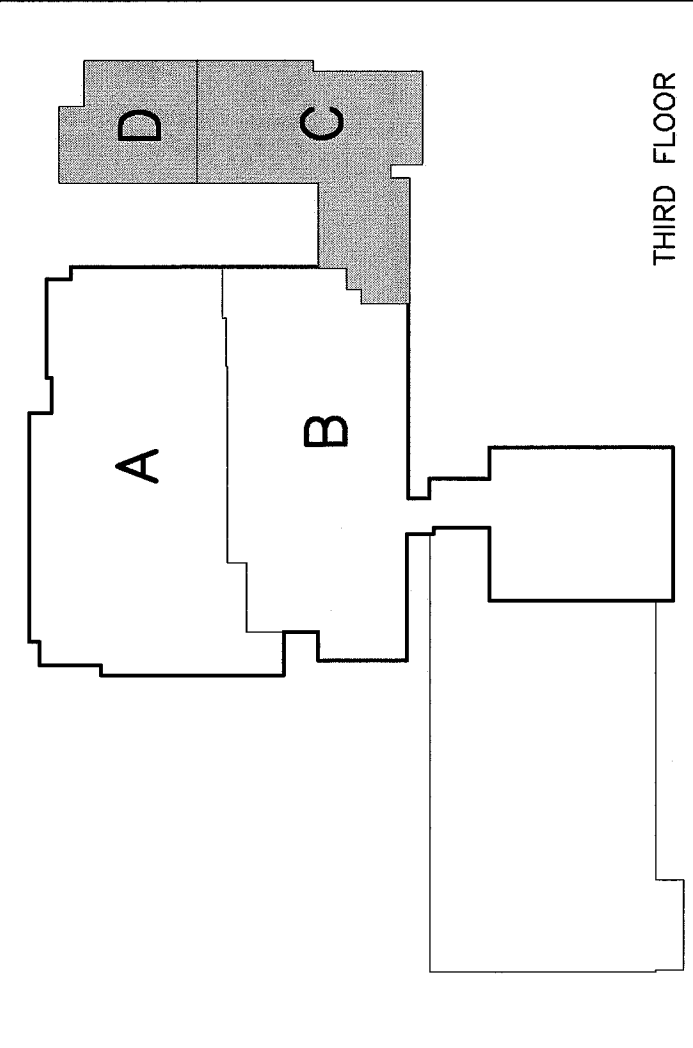


NOTES:

- SEE SHEET E-001 FOR LEGEND AND GENERAL NOTES.
- FOR LOCATION OF PANELBOARD P32A, SEE EP102.

KEYED NOTES:


- INSTALL 8" ABOVE COUNTER TO CENTER.
- INSTALL 24" AFF TO CENTER.
- INSTALL 36" AFF TO CENTER.
- INSTALL 48" AFF TO CENTER.
- INSTALL 60" AFF TO CENTER.
- INSTALL 72" AFF TO CENTER.
- INSTALL 84" AFF TO CENTER.
- PROVIDE CONNECTION TO PROJECTION SCREEN.
- RECEPTACLE INSTALLED IN CASEWORK.

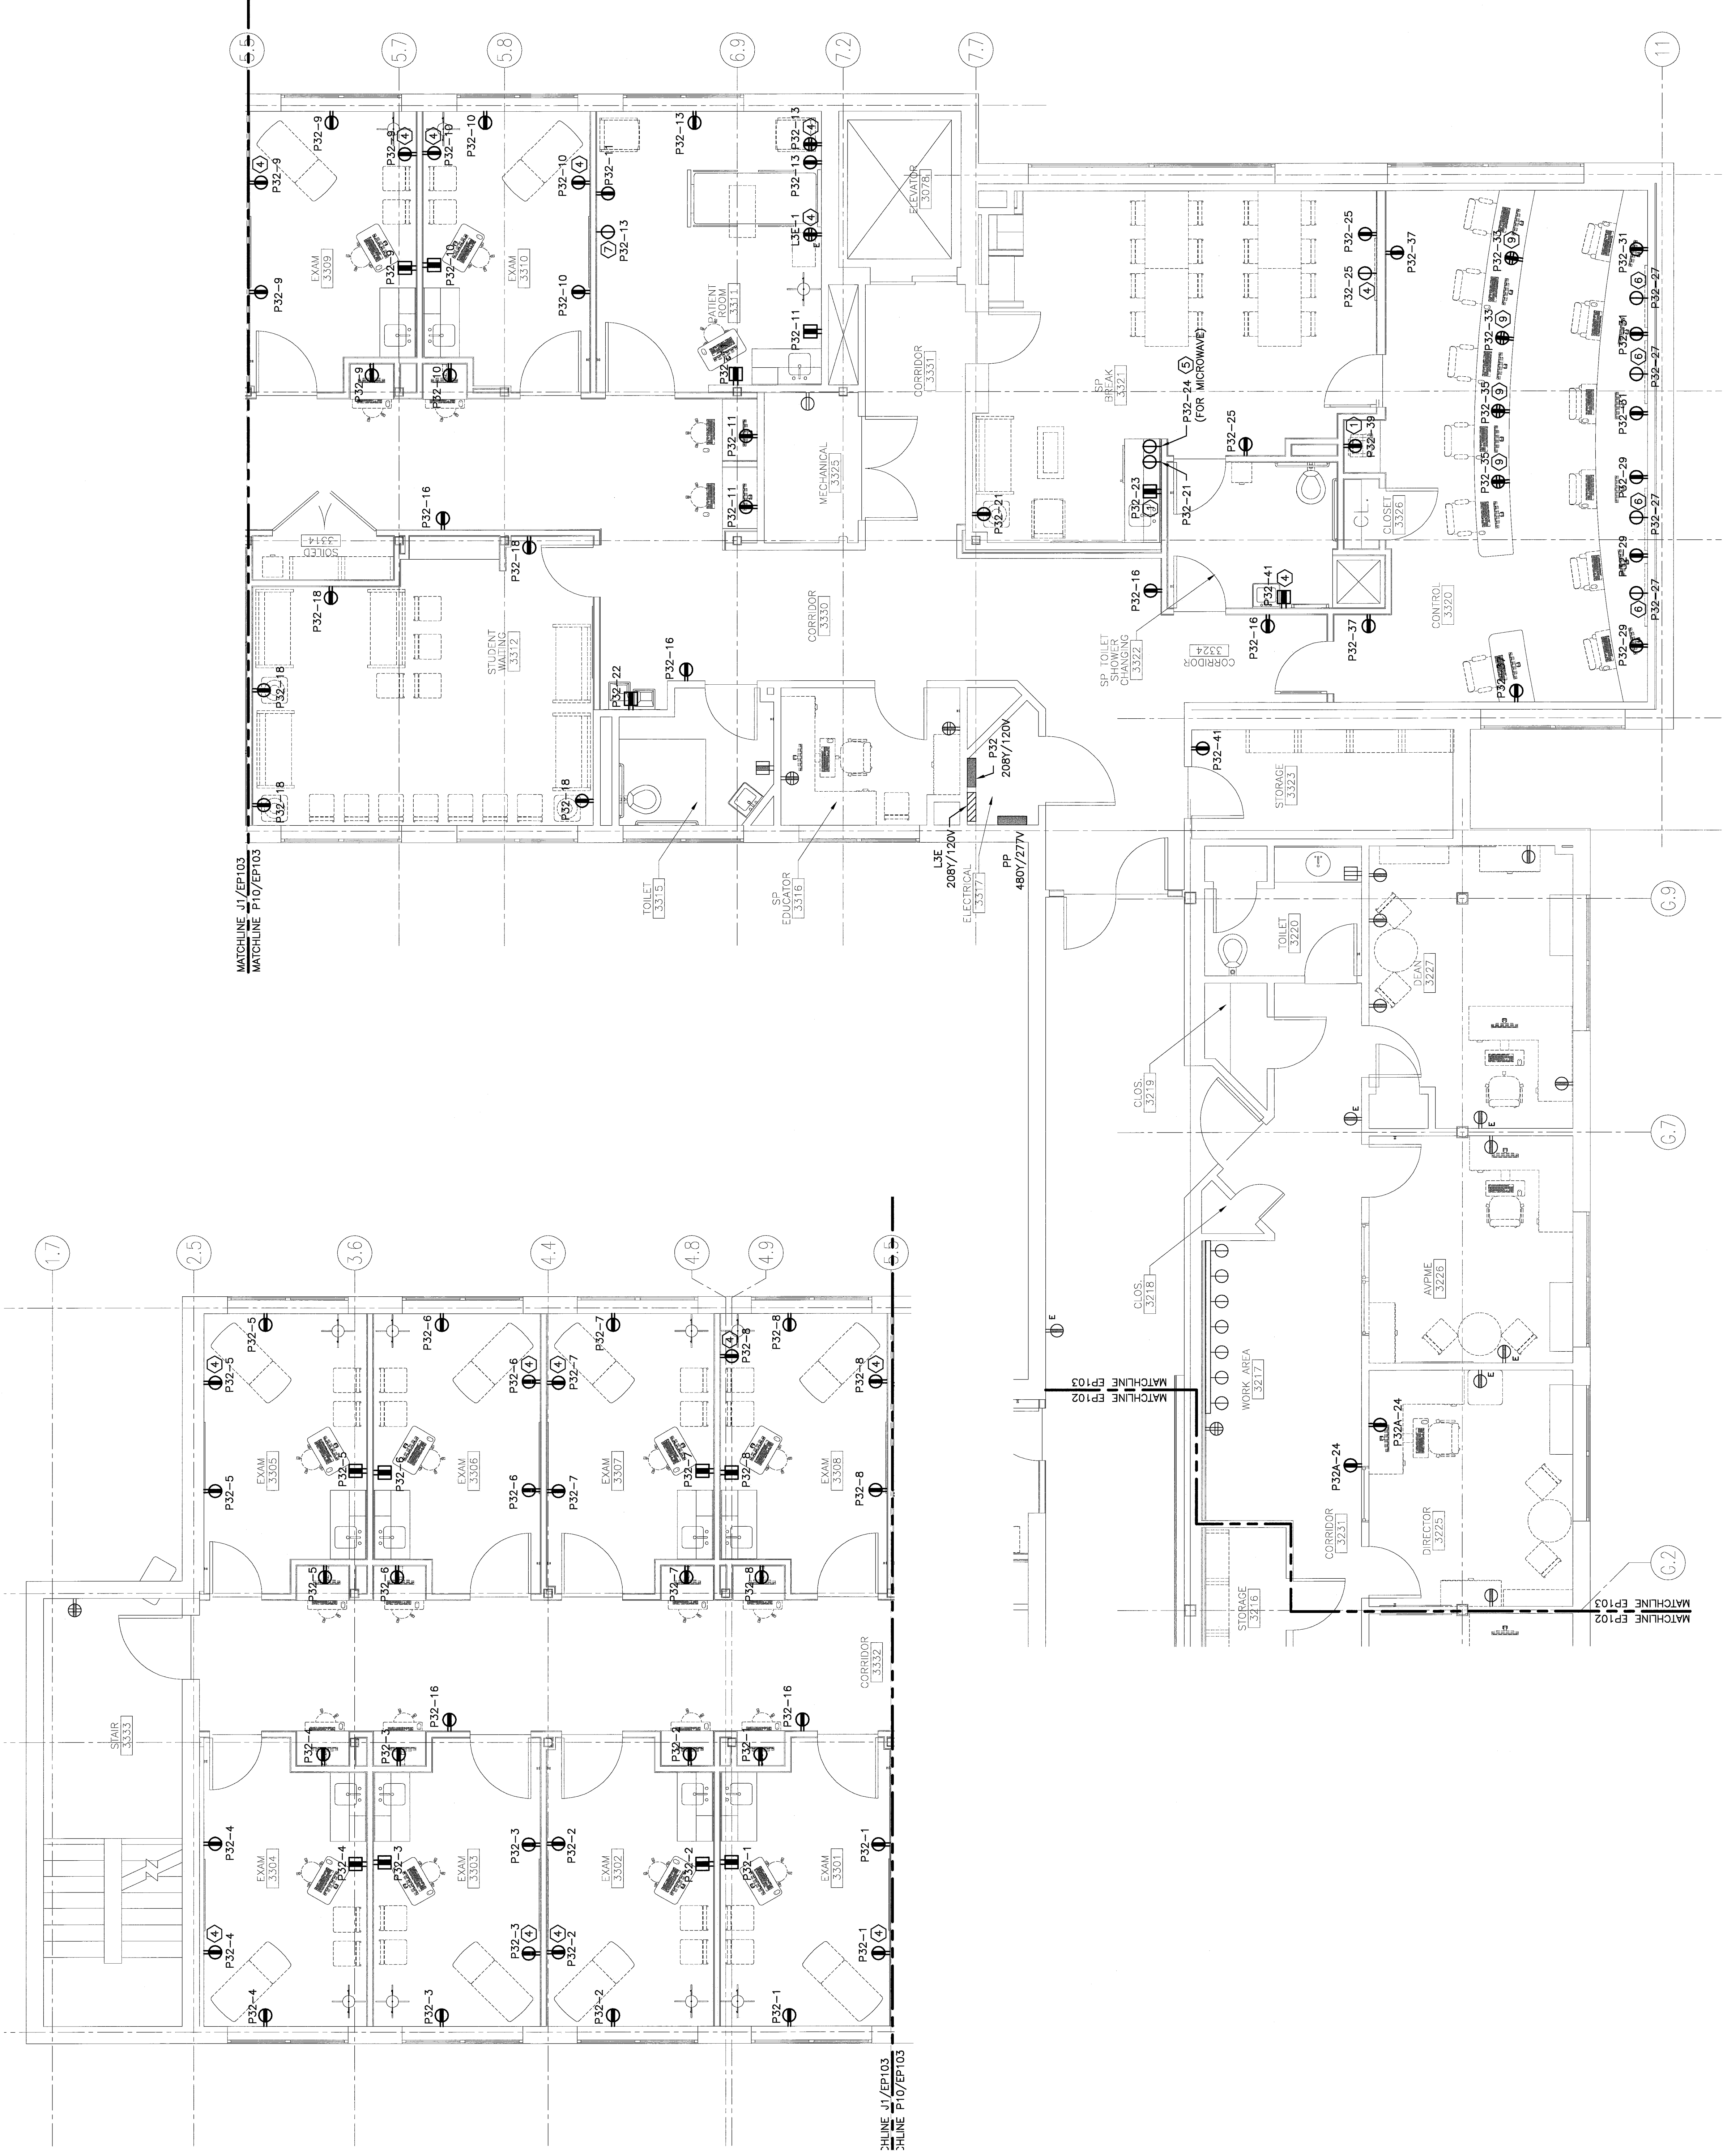

THIRD FLOOR
F18 KEY PLAN

REV.	ISSUED FOR CONSTRUCTION	DESCRIPTION	DATE
0			4-24-09

ISSUED FOR CONSTRUCTION
4-24-09

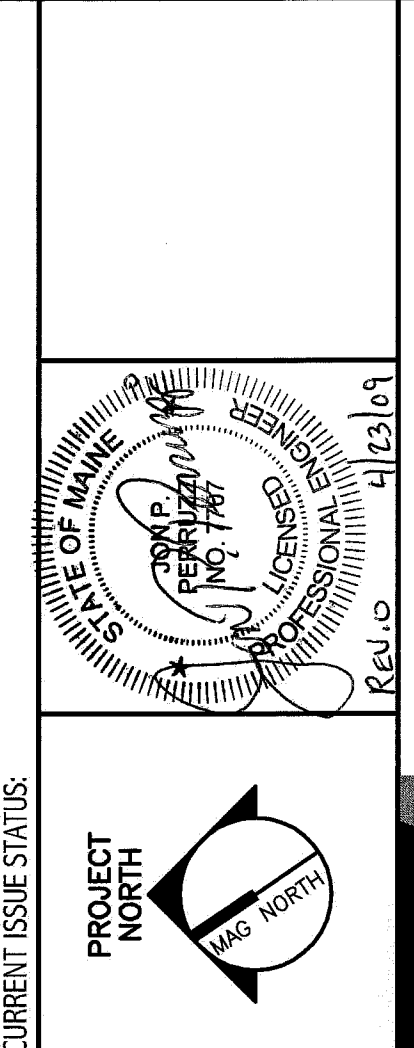

SMRT ARCHITECTS
141 East River St. Box 118
Portland, Maine 04104
Tel: (207) 732-8846
Fax: (207) 732-1075
www.smrt.com

MAINE MEDICAL CENTER
OFFICE OF MEDICAL EDUCATION
PORTLAND, MAINE

THIRD FLOOR AREA C & D
POWER PLAN

SHEET TITLE	SCALE	1/4"=1'-0"	DATE	4-24-09
PROJECT NUMBER	DATE FORWARDED	DATE OF RECORD	SMRT PROJECT FILE	PROJECT NO.
				EP103-28853
				08093100
				EP103

A1 THIRD FLOOR PLAN

1/4"=1'-0"