



PLUMBING FIXTURE CONNECTION SCHEDULE						
TAG	DESCRIPTION	SAN	VENT	CU	HU	GAS
P1	FLOOR MOUNTED FV UC	3"	2"	1"	-	
P2	ADA UNDERMOUNT COUNTERTOP LAV / FAUCET	1-1/2"	1-1/2"	1/2"	1/2"	
P3	24"x24" HOP BASIN	3"	2"	1/2"	1/2"	

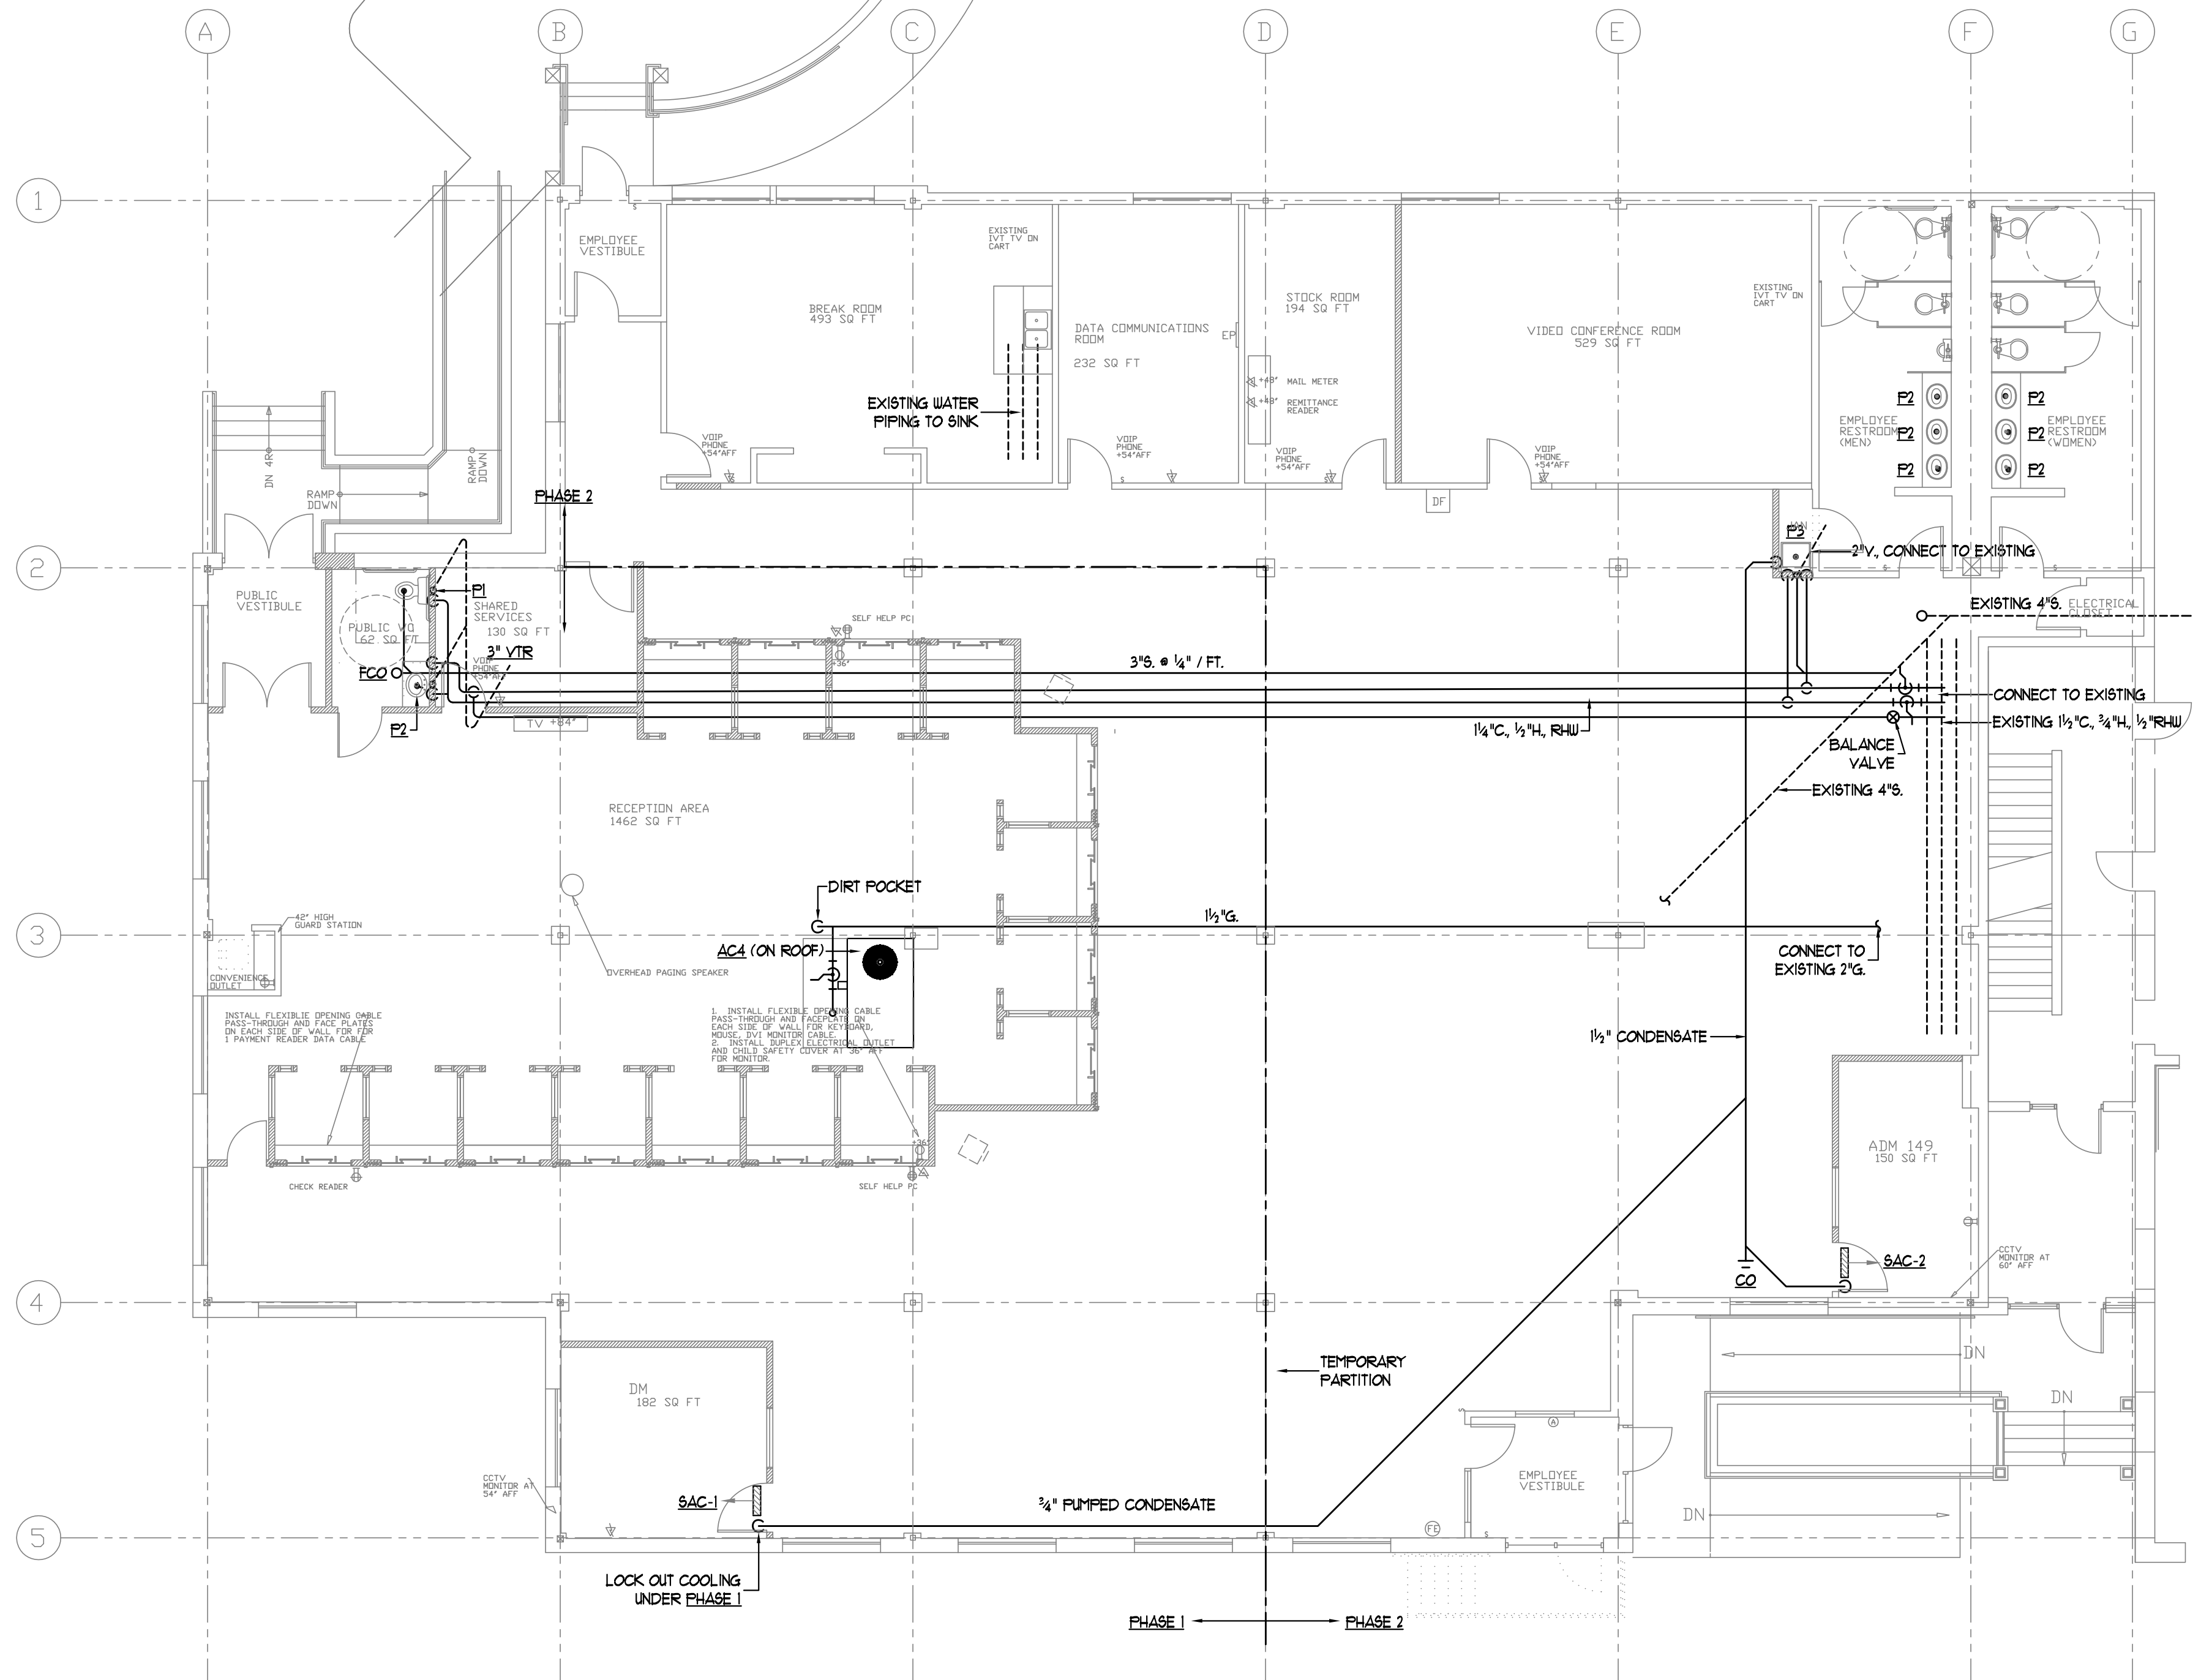


FLOOR PLAN
 Scale: 1/8" = 1' - 0"
 NOTES:
 REFER TO DWGS A 1.2, A 1.3 & A 1.4 FOR DIMENSIONS AND PHASING OF WORK
 REFER TO DWG A 2.1 FOR CEILING PLAN

General Plumbing Notes
 1. See the Architectural Phasing Drawings for the Sequence of Work.

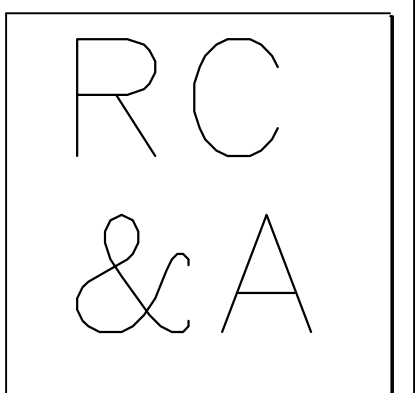

Richard Curtis & Associates

PO Box 9739-1150
 Portland, ME 04104-5039
 Phone: (207)797-6300
 Fax: (207)797-6303
 rcurtisassociates@maine.rr.com

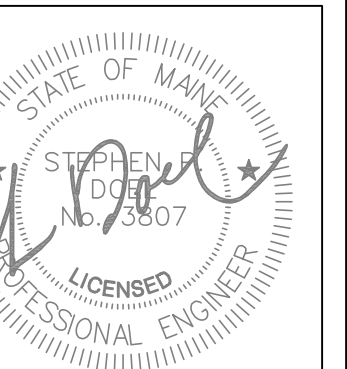

Owner:
 SSA REALTY LLC

One City Center
 Portland, ME 04103

Contractor:
 DMC PAINTING & REMOLDING
 59 Sanford St
 Portland, ME 04103
 207-856-1838

Project:
 RENOVATIONS TO SSA OFFICES
 550 Forest Avenue
 Portland, ME 04103

Project No: 10403

Drawing Title:
 PLUMBING FLOOR PLAN

Scale: 1/8"=1'-0"
 Date: 09 Dec 2016

Revision Dates:
 10/21/16-75% Progress
 12/09/16-Final Review
 1/04/17-For Permit

Drawing Number:

P1.1