
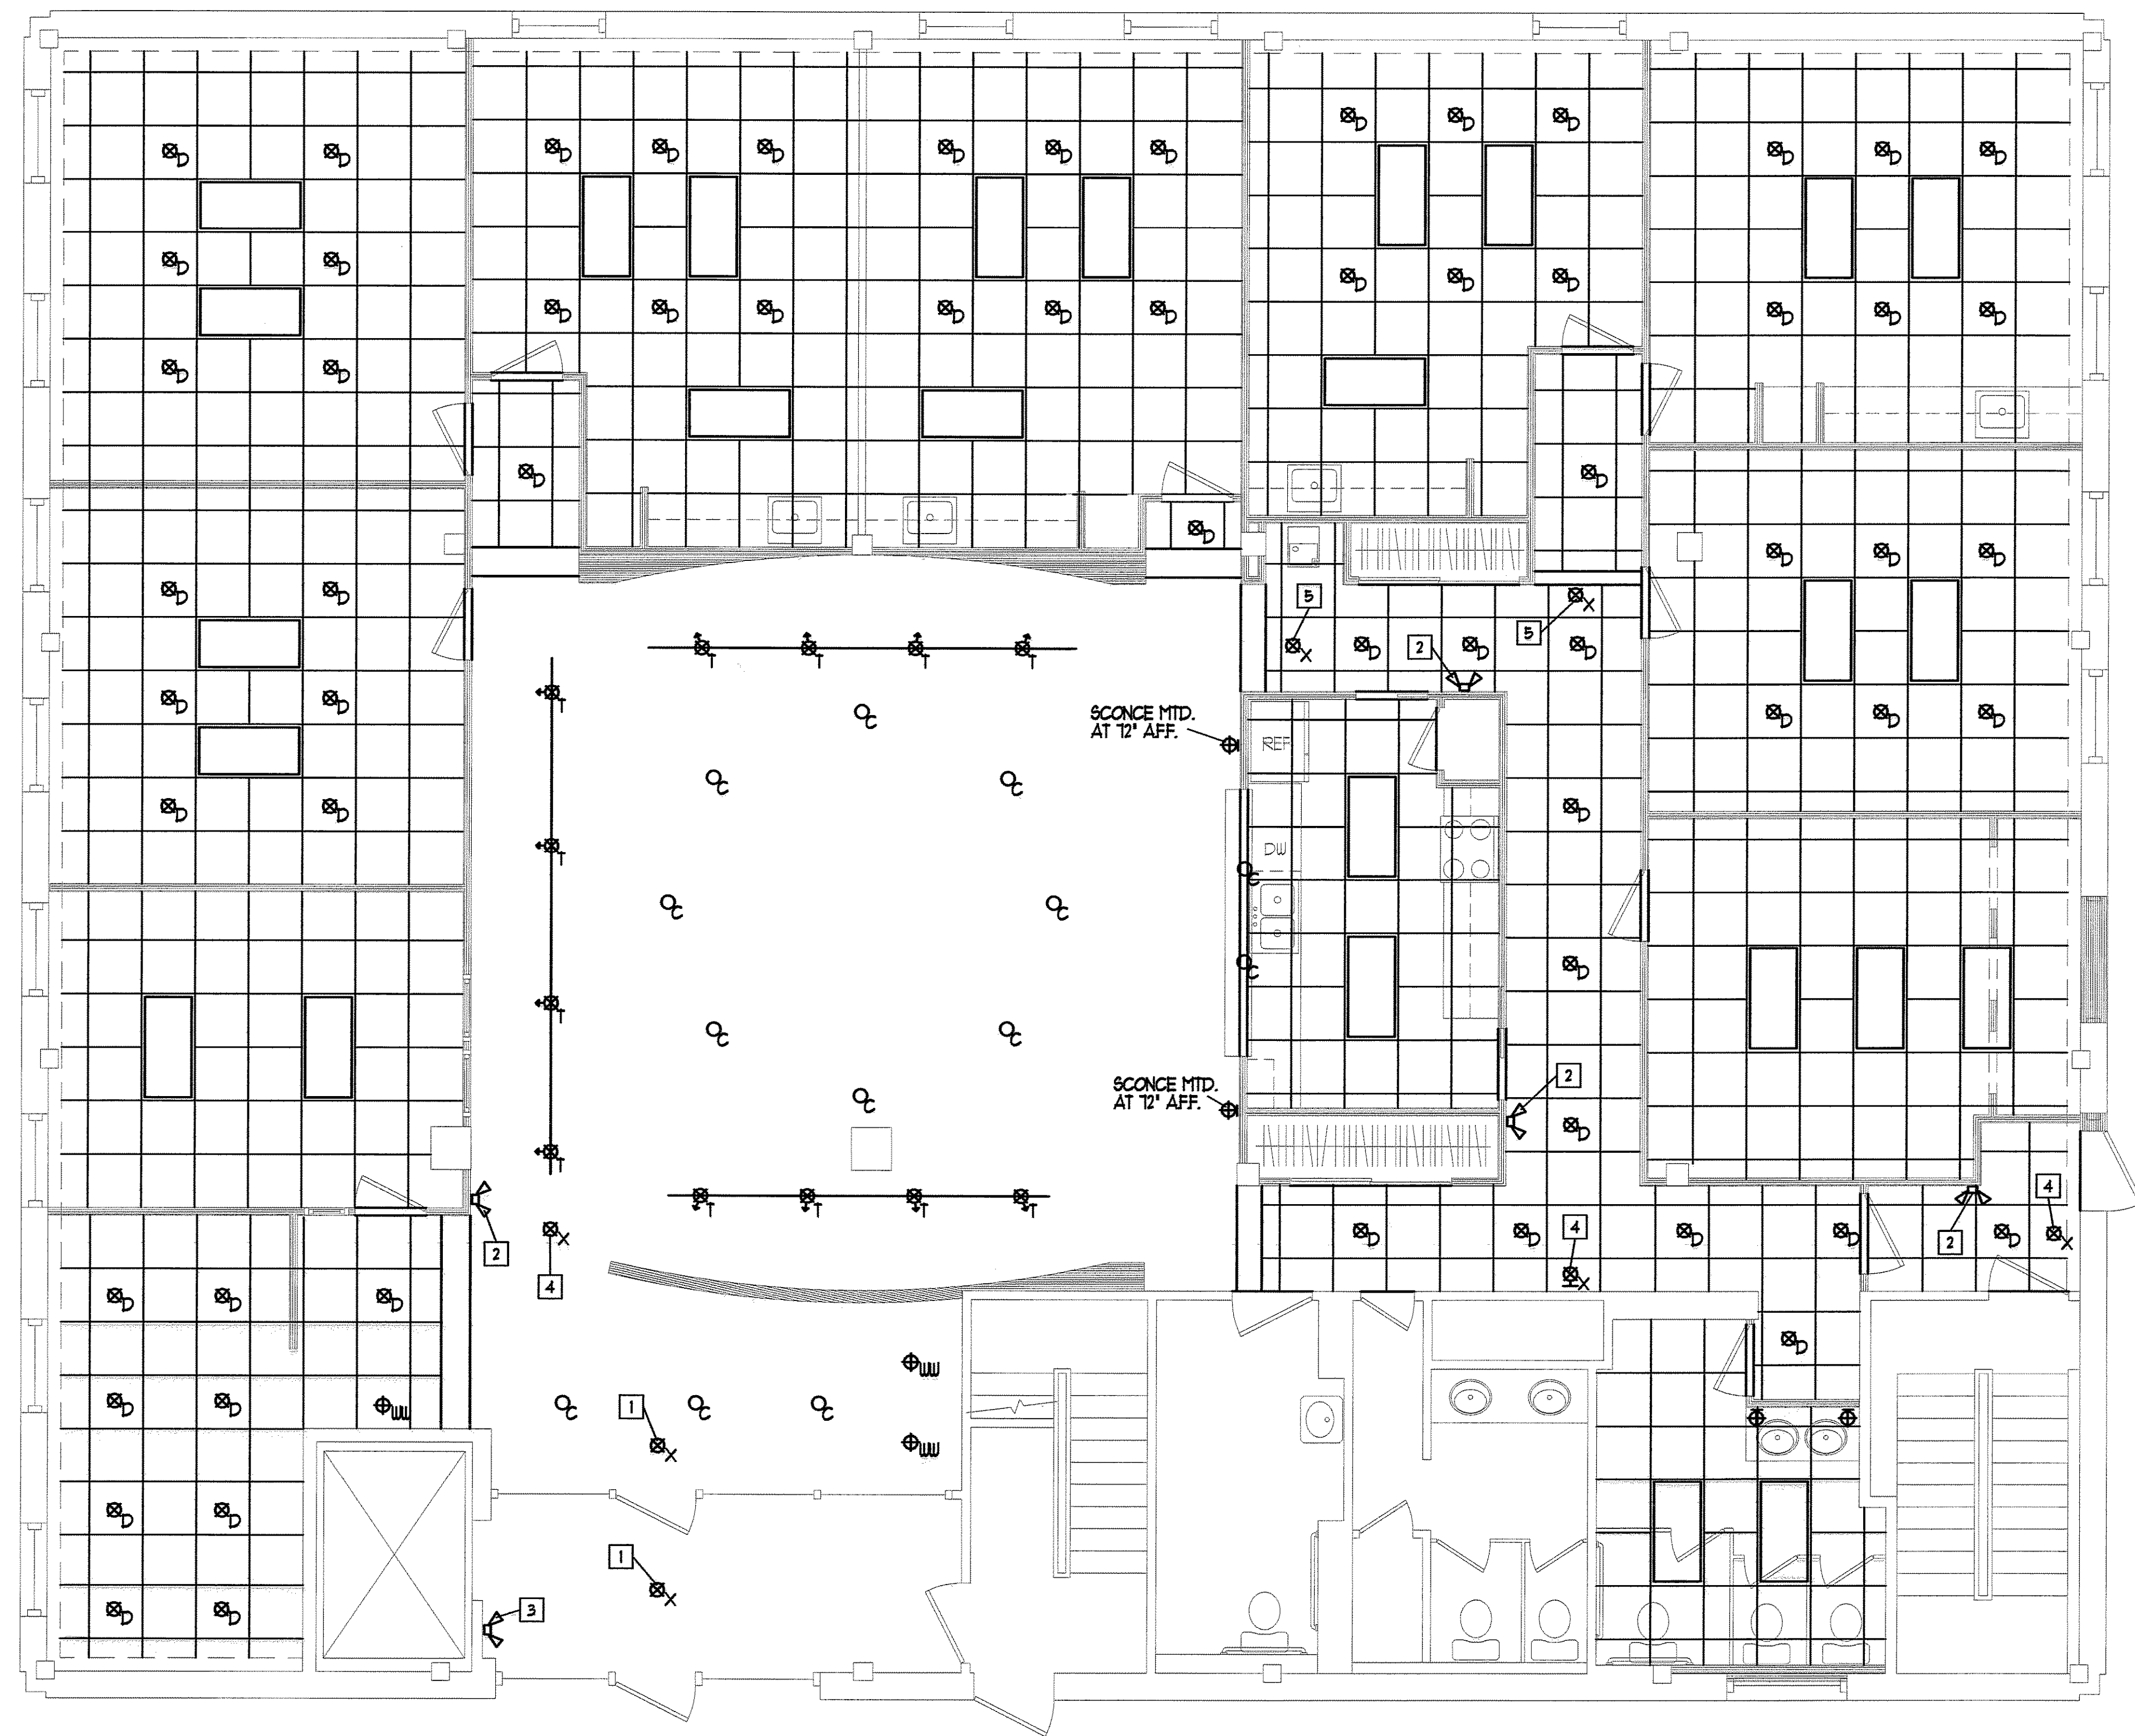


IF THIS SHEET IS NOT 24 X 36 IT IS A REDUCED SCALE PRINT - SCALE ACCORDINGLY

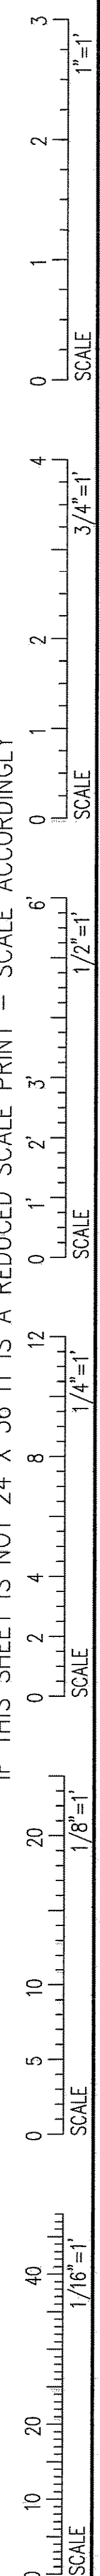

REFLECTED CEILING PLAN - 1st FLOOR
SCALE: 1/4" = 1'-0"

REFLECTED CEILING PLAN - GENERAL NOTES


- A. ALL DOWNLIGHTS, LOW-VOLTAGE TRACK LIGHTS, AND CABLE OR CORD MOUNTED FIXTURES TO BE ON DIMMER SWITCHES (SEE ELECT.)
- B. EXACT COUNT OF REUSED LIGHTING FIXTURES IS NOT SHOWN. CONTRACTOR TO FIELD VERIFY.

REFLECTED CEILING PLAN - KEYED NOTES

- 1 EXISTING EXIT SIGN TO REMAIN (PROTECT AS REQ'D.)
- 2 INSTALL SALVAGED EMERGENCY LIGHT AT 36" AFF.
- 3 EXISTING EMERGENCY LIGHT TO REMAIN (PROTECT AS REQ'D.)
- 4 INSTALL SALVAGED EXIT SIGN (IF WALL SIGN, INSTALL AT 36" AFF.)
- 5 PROVIDE AND INSTALL NEW EXIT SIGN.

LIGHTING FIXTURE KEY

- ⊗ SURFACE CEILING LIGHT - J BOX
- ⊗ IRIS DIRECTIONAL CEILING LIGHT (RECESSED)
- ⊗ LOW-VOLTAGE DIRECTIONAL TRACK LIGHT
- ⊗ WALL MOUNTED LIGHT
- ⊗ CABLE MTD FIXTURE
- ⊗ RECESSED DOWNLIGHT
- ⊗ IRIS RECESSED DOWNLIGHT
- ⊗ IRIS - A LAMP WALL WASH
- ⊗ IRIS-CORNER WALL WASH
- ⊗ IRIS-LENSED SHOWER LIGHT
- ⊗ IRIS-SLOTTED ACCENT
- ⊗ IRIS-PINHOLE
- ⊗ BASIC WALL WASHER - RECESSED
- ⊗ BASIC RECESSED SHOWER LIGHT
- ⊗ CEILING MOUNTED EXIT SIGN
- ⊗ WALL MOUNTED EXIT SIGN
- ⊗ WALL MOUNTED EMERGENCY LIGHT

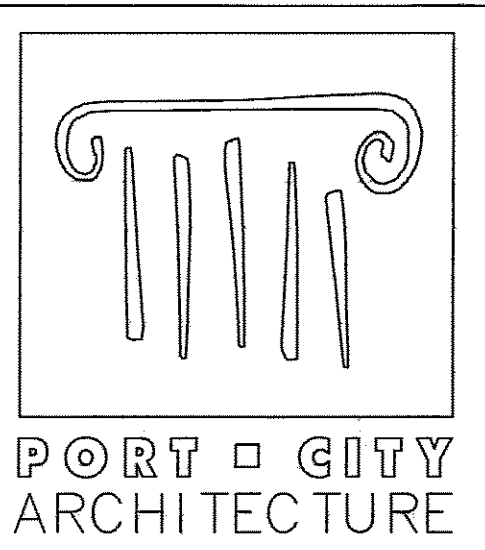

65 NEWBURY STREET
PORTLAND, ME 04101
207.761.9000
fax: 207.761.2010
info@portcityarch.com



FOR CONSTRUCTION

CONSULTANTS:
Allied / Cook Construction
John S. Brockington
Preconstruction Mgr.
P.O. Box 1396
Portland, Maine 04104
(207) 712-2888
(207) 885-5135 fax

Johnson and Jordan Mechanical Contractors
Mike Johnson P.E.
18 Mussey Road
Scarborough, ME 04074
(207) 883-8345
(207) 883-8619 fax

Seabee Electric
Charles Hascall, President
84 Pleasant Hill Road
Scarborough, ME 04074
(207) 883-5448

CENTER FOR GRIEVING CHILDREN

555 FOREST AVE
Portland, Maine 04103

DATE	DESCRIPTION
4-14-06	CONSTRUCTION SET
3-21-06	PERMIT SET
2-11-06	DESIGN DEVELOPMENT
1-4-06	SCHEMATIC DESIGN

REVISIONS

Date Issued: _____ Date: _____ Year: _____
Project Number: **05109**

Drawing Scale: _____ SHEET NAME: **REFLECTED CEILING PLAN 1st FLOOR**

Drawn By: _____ Checked By: **A3**