
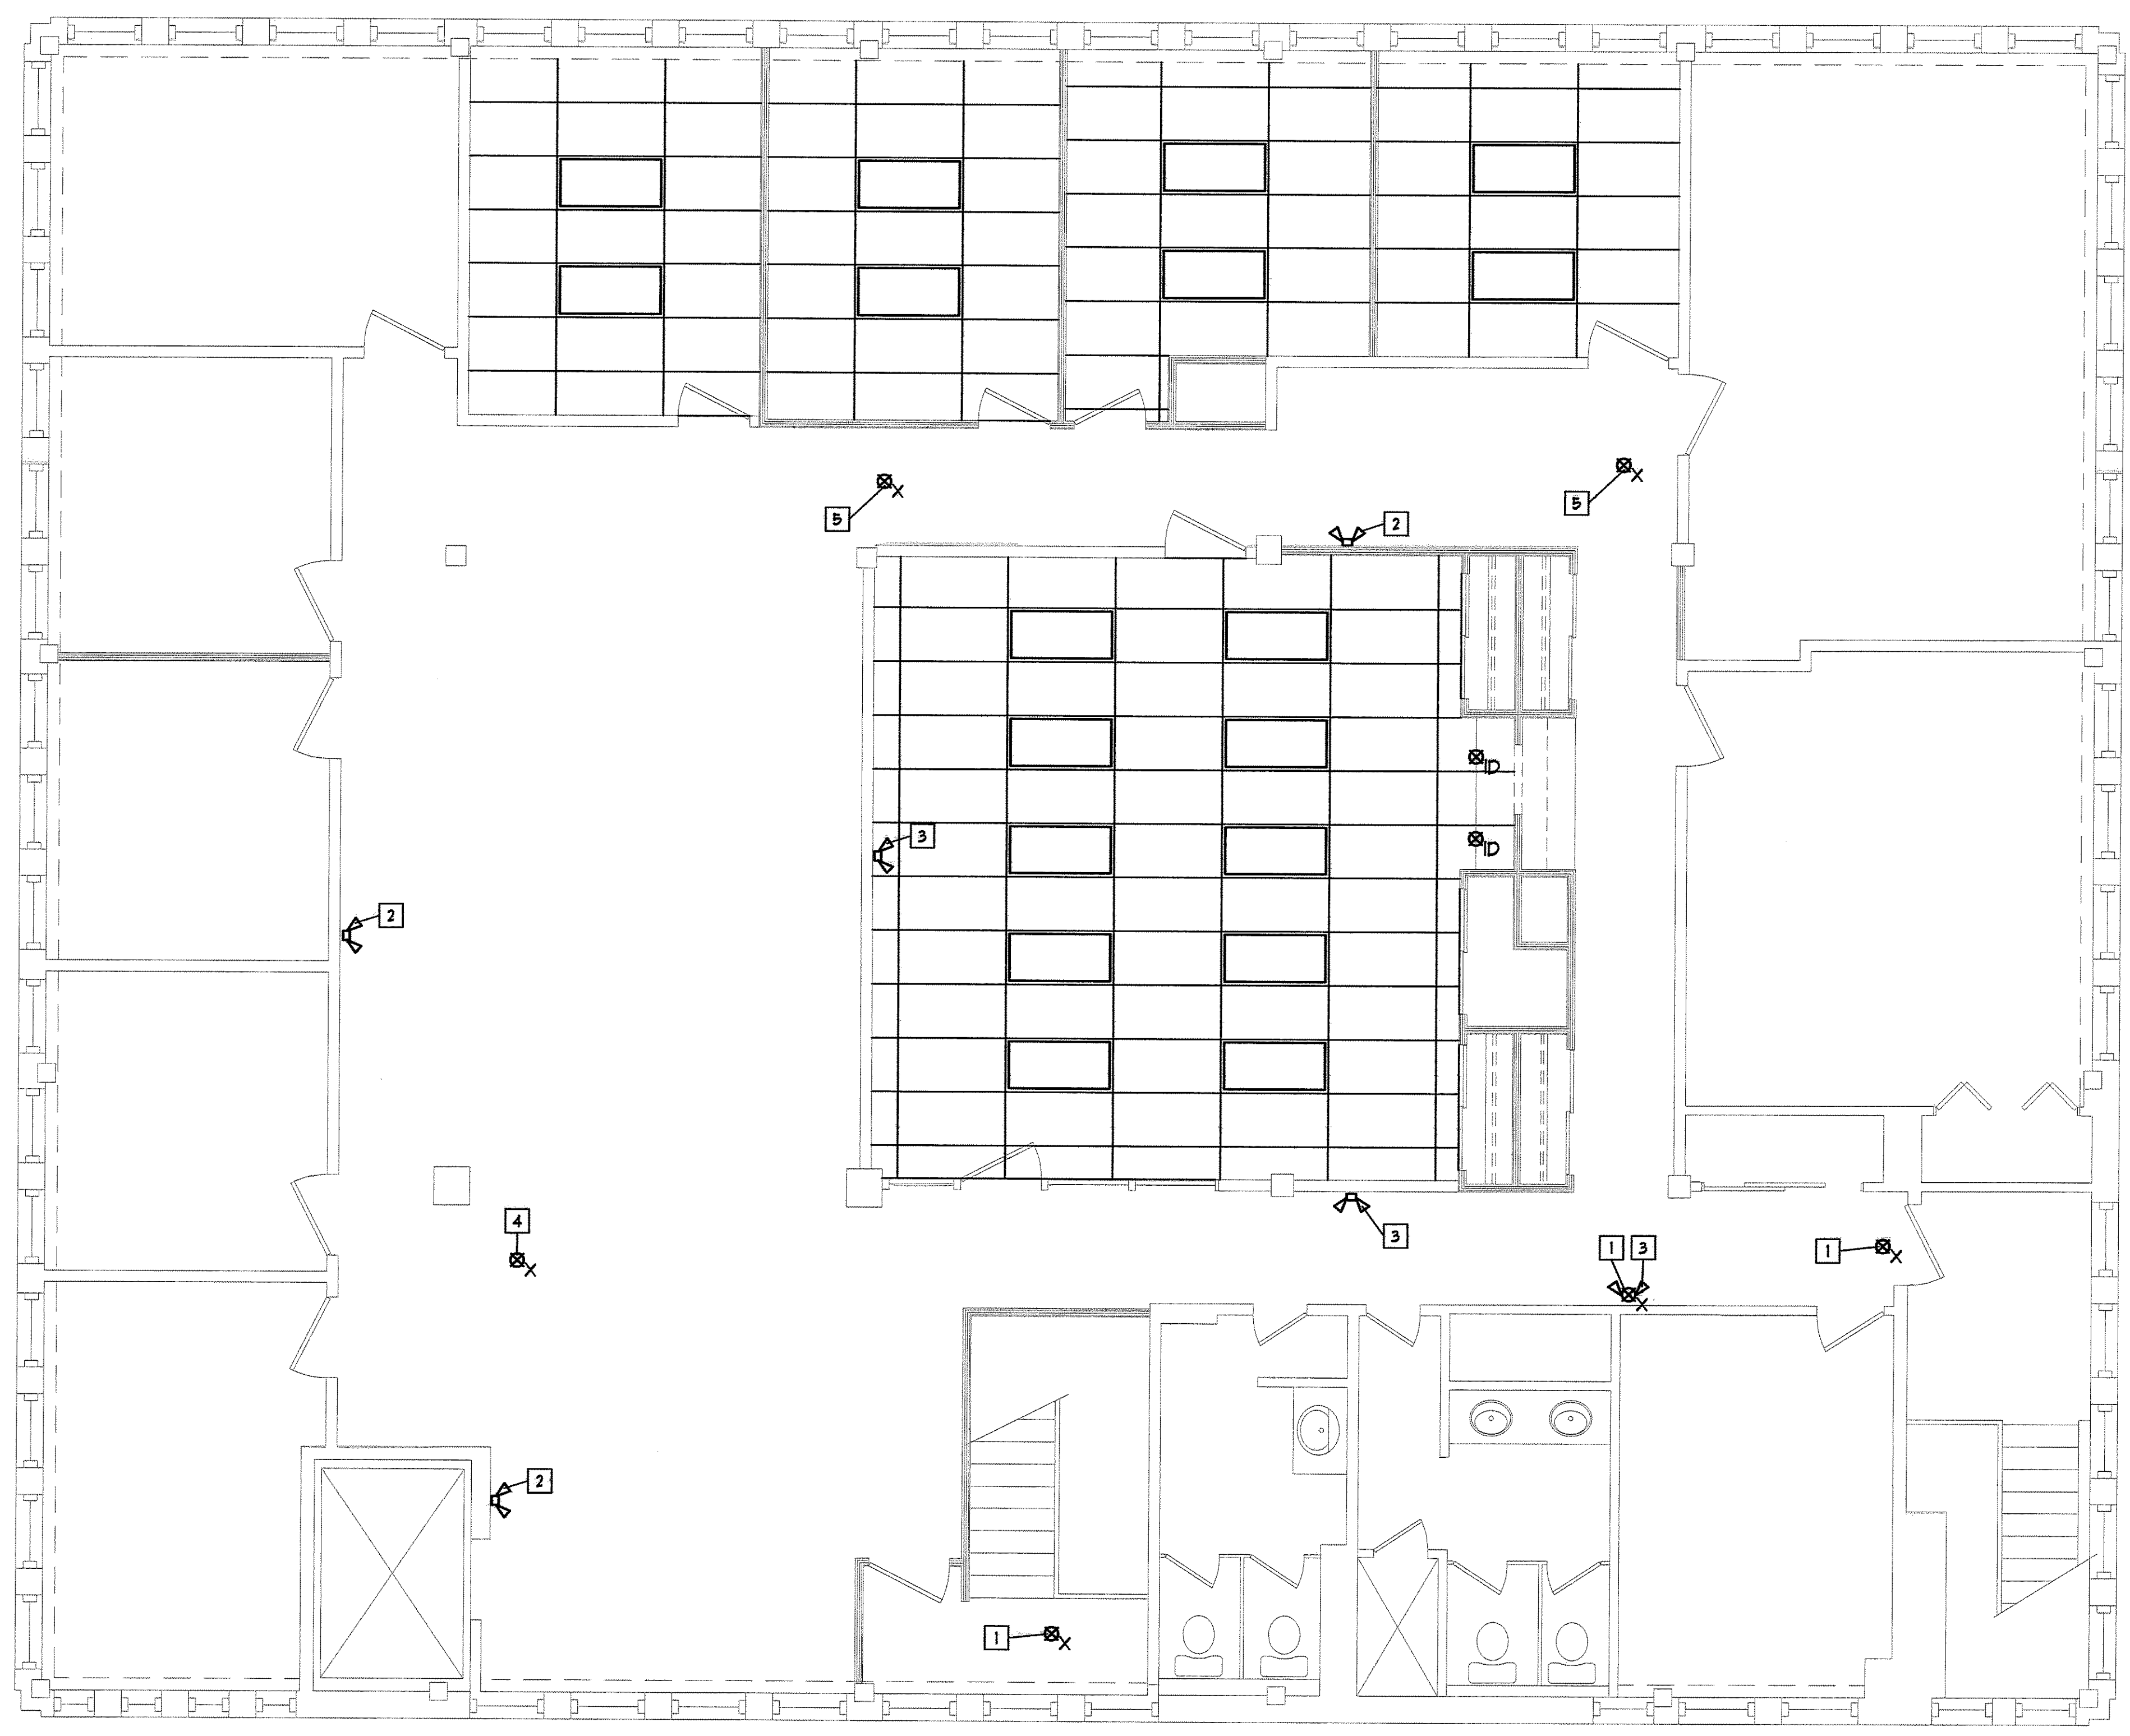


IF THIS SHEET IS NOT 24 X 36 IT IS A REDUCED SCALE PRINT -- SCALE ACCORDINGLY

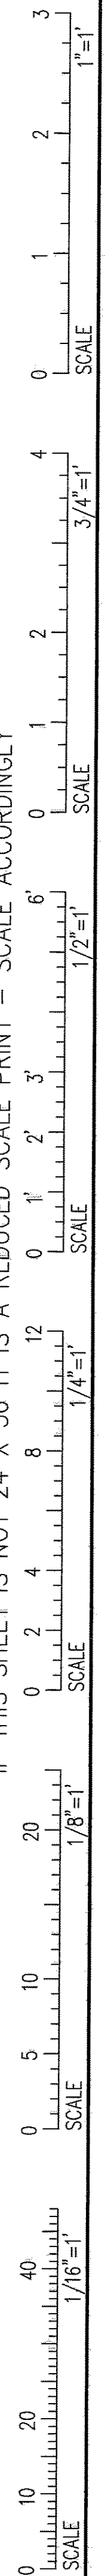


REFLECTED CEILING PLAN - 2nd FLOOR
 SCALE: 1/4" = 1'-0"

REFLECTED CEILING PLAN - GENERAL NOTES
 A. ALL DOWNLIGHTS, LOW-VOLTAGE TRACK LIGHTS, AND CABLE OR CORD MOUNTED FIXTURES TO BE ON DIMMER DIMMER SWITCHES (SEE ELECT.)
 B. EXACT COUNT OF REUSED LIGHTING FIXTURES IS NOT SHOW CONTRACTOR TO FIELD VERIFY.

REFLECTED CEILING PLAN - KEYED NOTES
 1 EXISTING EXIT SIGN TO REMAIN (PROTECT AS REQ'D.)
 2 INSTALL SALVAGED EMERGENCY LIGHT AT 96" AFF.
 3 EXISTING EMERGENCY LIGHT TO REMAIN (PROTECT AS REQ'D.)
 4 INSTALL SALVAGED EXIT SIGN (IF WALL SIGN, INSTALL AT 96" AFF.)
 5 PROVIDE AND INSTALL NEW EXIT SIGN.


LIGHTING FIXTURE KEY

⊗	SURFACE CEILING LIGHT - J BOX
⊗	IRIS DIRECTIONAL CEILING LIGHT (RECESSED)
A	IRIS - A LAMP WALL WASH
⊗	LOW-VOLTAGE DIRECTIONAL TRACK LIGHT
⊗	WALL MOUNTED LIGHT
C	CABLE MTD FIXTURE
⊗	RECESSED DOWNLIGHT
⊗	IRIS RECESSED DOWNLIGHT
⊗	IRIS - A LAMP WALL WASH
⊗	IRIS-CORNER WALL WASH
⊗	IRIS-LENGED SHOWER LIGHT
⊗	IRIS-SLOTTED ACCENT
⊗	IRIS-PINHOLE
⊗	BASIC WALL WASHER - RECESSED
⊗	BASIC RECESSED SHOWER LIGHT
⊗	CEILING MOUNTED EXIT SIGN
⊗	WALL MOUNTED EXIT SIGN
⊗	WALL MOUNTED EMERGENCY LIGHT

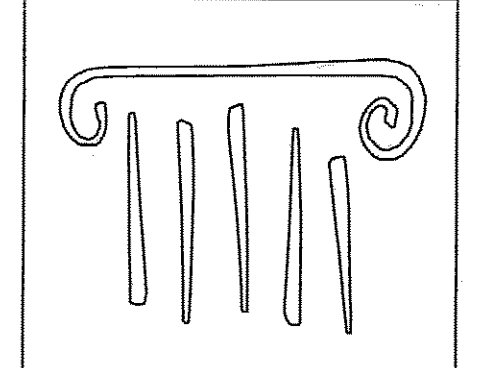

PORT CITY ARCHITECTURE

65 NEWBURY STREET
 PORTLAND, ME 04101
 207.761.9000
 fax: 207.761.2010
 info@portcityarch.com

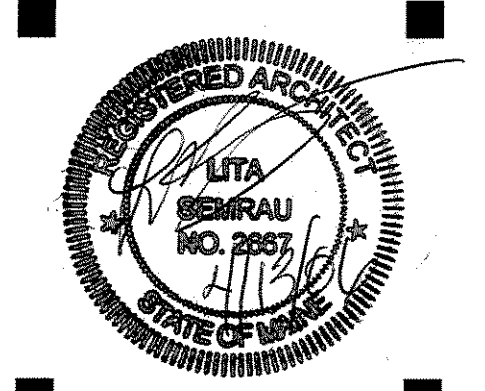

FOR CONSTRUCTION

CONSULTANTS:
Allied / Cook Construction
 John S. Brockington
 Preconstruction Mgr.
 P.O. Box 1396
 Portland, Maine 04104
 (207) 712-2888
 (207) 885-5135 fax

Johnson and Jordan Mechanical Contractors
 Mike Johnson P.E.
 18 Mussey Road
 Scarborough, ME 04074
 (207) 883-8345
 (207) 883-8619 fax

Seabee Electric
 Charles Hascall, President
 84 Pleasant Hill Road
 Scarborough, ME 04074
 (207) 883-5448

CENTER FOR GRIEVING CHILDREN

555 FOREST AVE
 Portland, Maine 04103

4	4-14-06	CONSTRUCTION SET
3	3-21-06	PERMIT SET
2	2-11-06	DESIGN DEVELOPMENT
1	1-4-06	SCHEMATIC DESIGN
*		DATE DESCRIPTION

REVISIONS

Date Issued	Date - Year
Project Number	05109
Drawing Scale	

SHEET NAME
REFLECTED CEILING PLAN
2nd FLOOR

Drawn By
 Checked By
A3.1