

REVISION	0	ISSUED FOR REVIEW & APPROVAL	4/4/2014
DESCRIPTION			
DATE			

RESERVED FOR CITY STAMP


CUNNINGHAM
 Security Systems
 10 Princes Point Road, Yarmouth, Maine 04096
 Office: 207.846.3350 • Fax: 207.846.6080

**ENDODONTIC ASSOCIATES
 563 FOREST AVENUE
 PORTLAND, MAINE 04101
 FIRE ALARM PLAN**

DRAWN	JPB UNICAD JOB #14177
CHECKED	WAYNE B. HAWES NCET # 90496
DATE	4/3/2014
REVISION	0
SCALE	1/4"=1'-0"

FA-2

UNICAD Inc.
 Fire Alarm Design & Drafting Services
 578 W. 40th St.
 Portland, ME 04102
 www.unicad.net

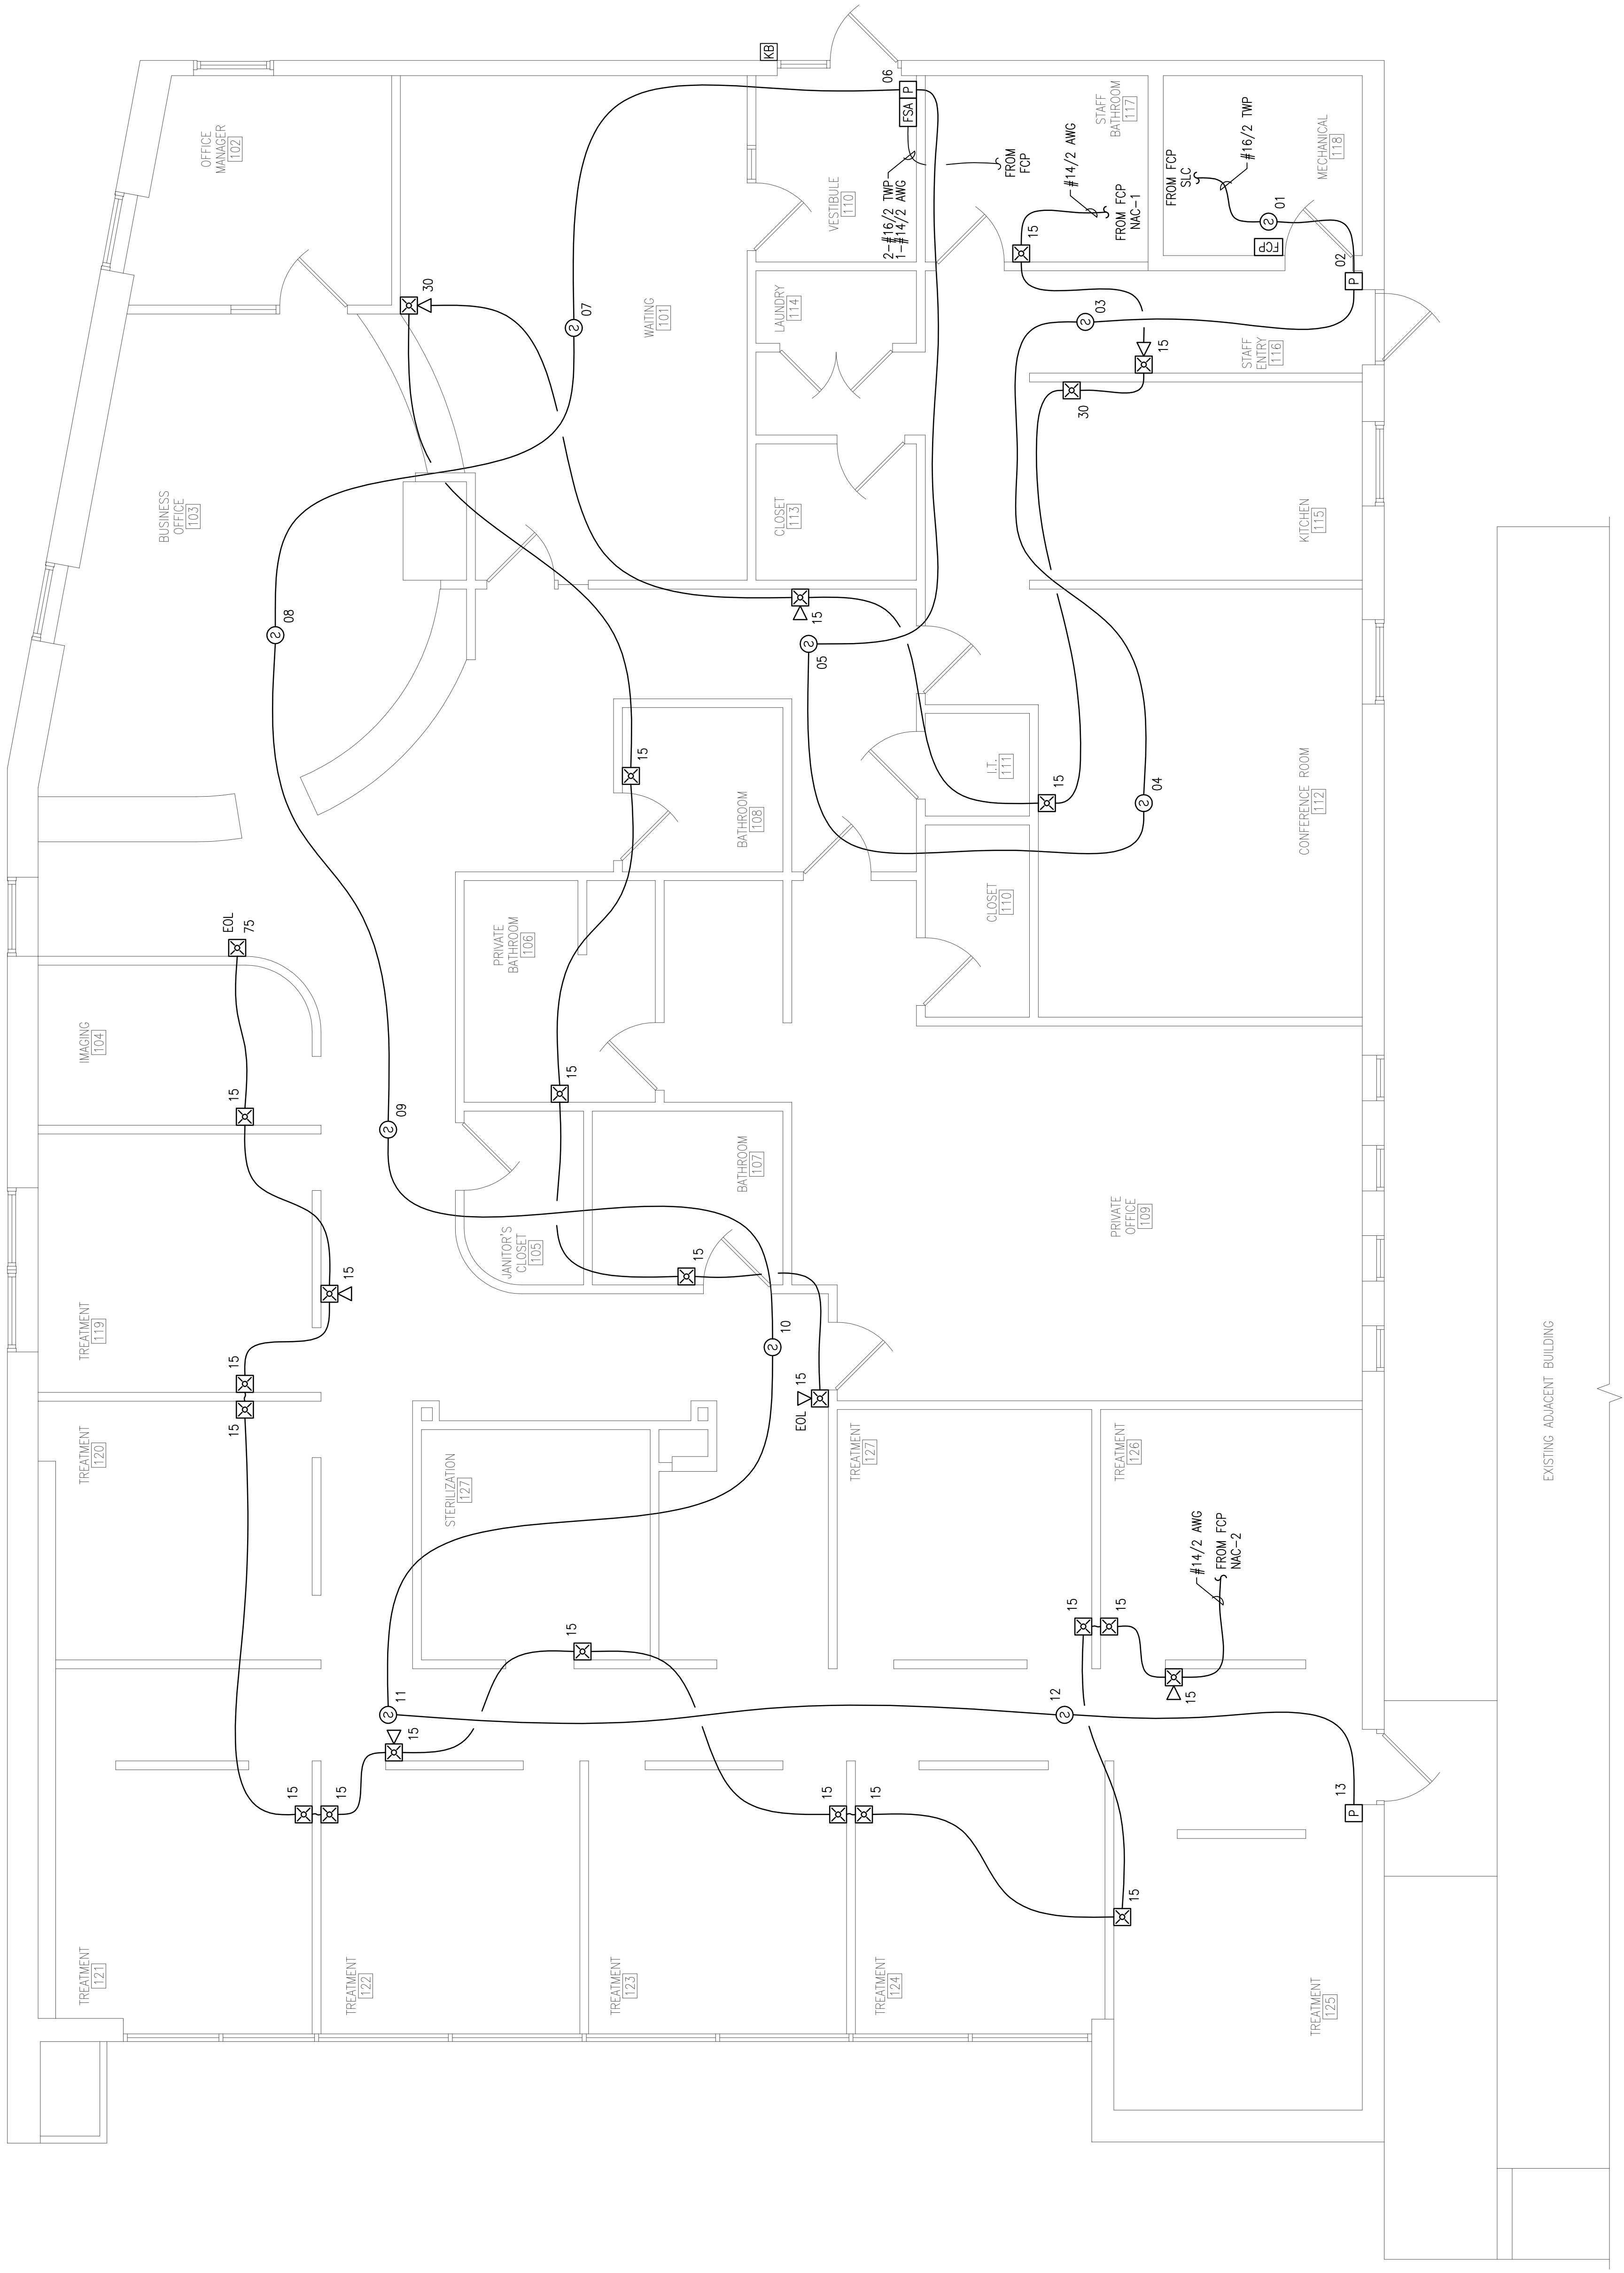

FIRE ALARM PLAN
 SCALE: 1/4"=1'-0"
 N