
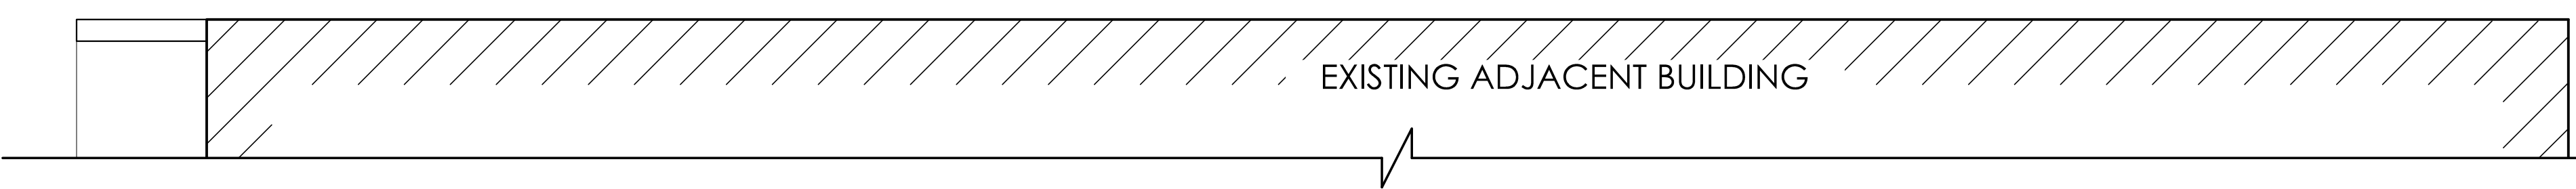


LIGHTING FIXTURE SCHEDULE									
DESIGNATION	DESCRIPTION	MANUFACTURER/MODEL NUMBER	LAMP TYPE	LAMP COLOR	LAMP NO.	BALLAST	ELECTRICAL VOLTAGE	WATTS	NOTES
A	2X2 SOFTTRACE W/DIFFUSER	DAY-BRITE 2STG2CF40-D-1/2-EB	CFL	4100	2	ELEC.	UNV	40	①
B	6" RECESSED LIGHT	PRESCOLITE CF1632HEB	CFL	4100	1	ELEC.	UNV	32	④
C	EDGE LIT EXIT LIGHT	GREEN TORCH CFT632HEB	LED	-	-	NONE	UNV	5	②

- ① FURNISH WITH ALL REQUIRED MOUNTING HARDWARE, REMOTE POWER SUPPLY AND CONNECTING CABLE.
- ② FURNISH W/BATTERY FOR 90 MINUTE EMERGENCY LIGHTING OPERATION.
- ③ PROVIDE W/ FEATURES & ACCESSORIES NECESSARY FOR UNIVERSAL (TOP, BACK & END) MOUNTING AND UNIVERSAL DIRECTIONAL ARROW KNOCKOUTS. ARROWS ON PLANS INDICATE DIRECTION OF CHEVRONS. SHADING INDICATES FIXTURE FACE. CHEVRON & LETTERING SHALL COMPLY WITH BUILDING CODE. COORDINATE NEED FOR CEILING MOUNT CANOPY PRIOR TO SUBMITTING. PROVIDE SELF-DIAGNOSTICS.
- ④ IF REQUIRED COORDINATE LOCATION OF RECESSED LIGHTS WITH EXISTING ROOF TRUSS BOTTOM CORD.

WATTAGE CALCULATION:
 106 TYPE "A" & FIXTURES @ 40w PER FIXTURE = 4,240 WATTS
 8 TYPE "B" FIXTURES @ 32w PER FIXTURE = 256 WATTS
 TOTAL WATTS = 4,496 WATTS

TOTAL ALLOWABLE POWER PER IECC 505.5.2 = 1.0W/S.F.
 TOTAL INTERIOR SQUARE FOOTAGE = 4,883 SQUARE FEET

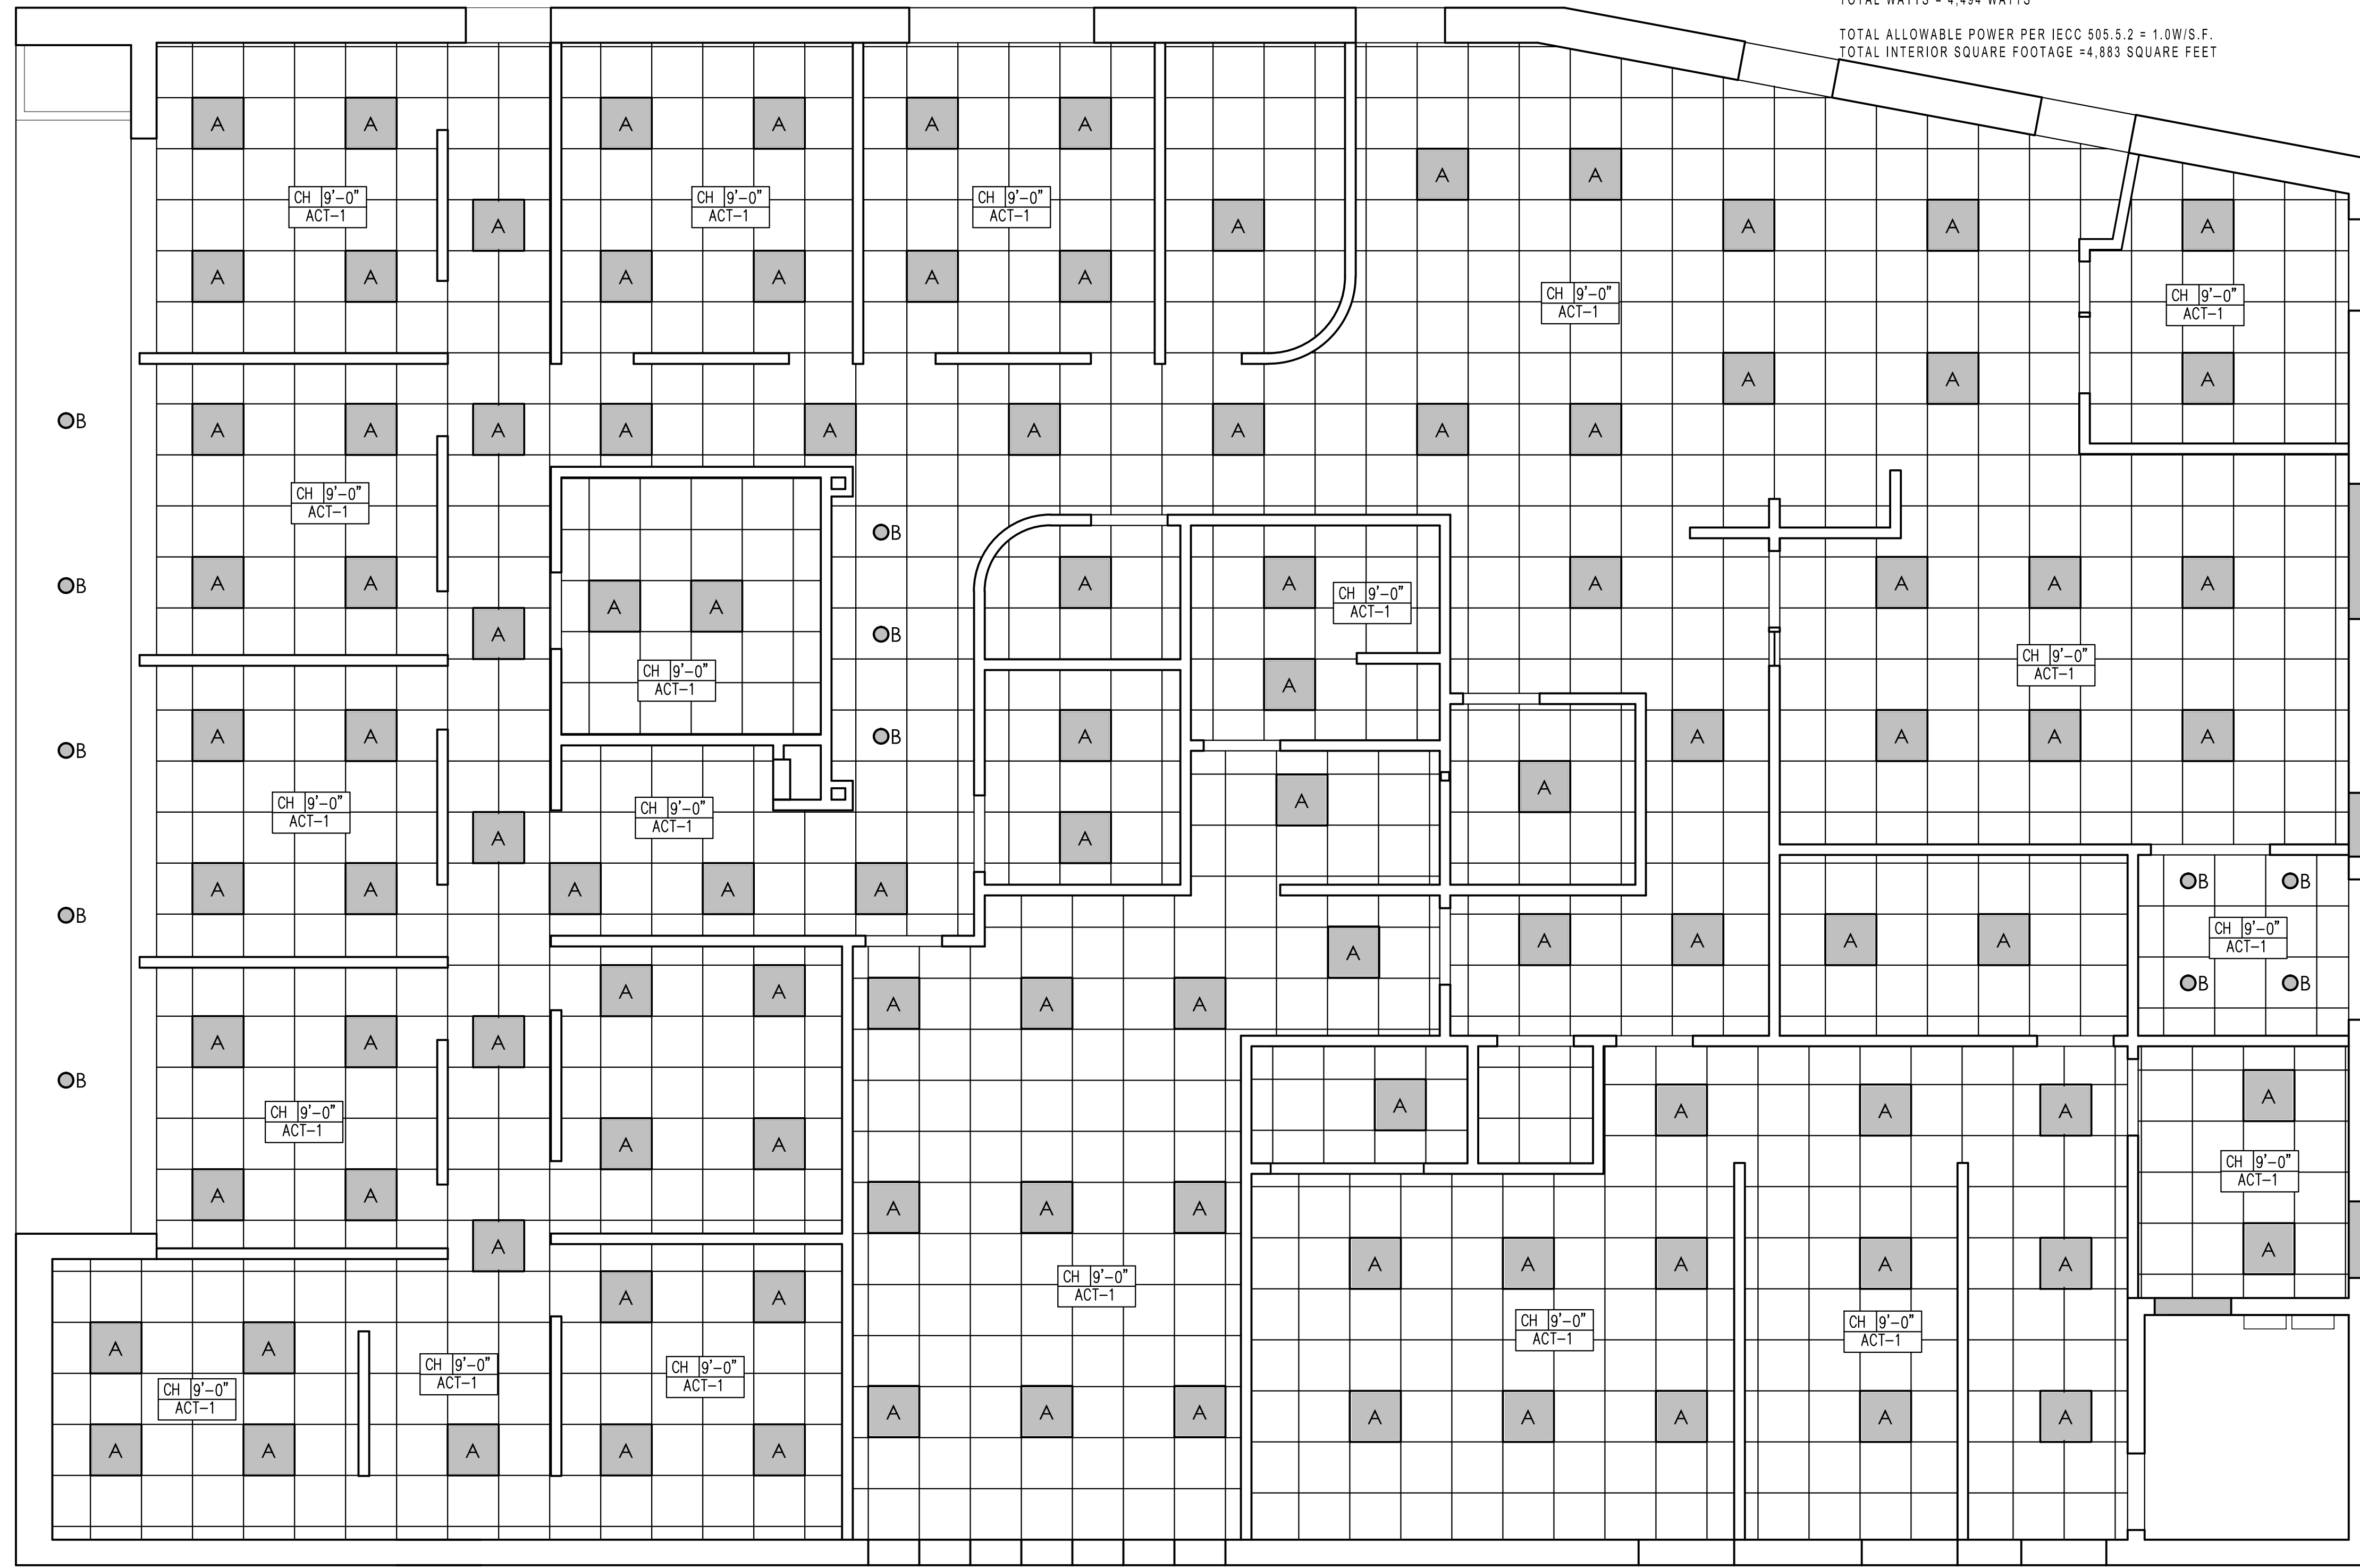

1 1/4"=1'-0" REFLECTED CEILING PLAN

DO NOT SCALE DRAWINGS

GENERAL CONTRACTOR
 STRUCTURAL ENGINEER
 MEP ENGINEER
 CLIENT
 Endodontic Associates, P.A.
 276 Conco Road
 Portland, ME 04103

PROJECT
New Office Renovation
 563 Forest Avenue
 Portland, ME 04101



ISSUED FOR PERMIT

INFORMATION
 Path: M:/boulos/endodontic
 Issue Date: 12/31/13
 Drawn By: dijg
 Checked By:
 Revision:
 1. 02.26.14 - RELOCATED EGRESS,
 NEW GLAZING REQUIREMENT AT ALLEY
 2.
 3.
 4.

TITLE
PROPOSED PLAN

SCALE
 1/4"=1'-0"

© 2014 Graham Architects. All rights reserved. Information, material, and designs in this document are proprietary to and owned by Endodontic Associates, and may not be disclosed to any third party, reproduced, posted on a global computer information network, or distributed in any way without the written consent from Graham Architects.