


FIRST FLOOR HVAC PLAN
SCALE: 1/8" = 1'-0"

- ▲ DUCT SMOKE. FURNISHED AND INSTALLED BY ELECTRICAL CONTRACTOR
- ▲ DEMAND CONTROL FOD COING IN LOADING AREA

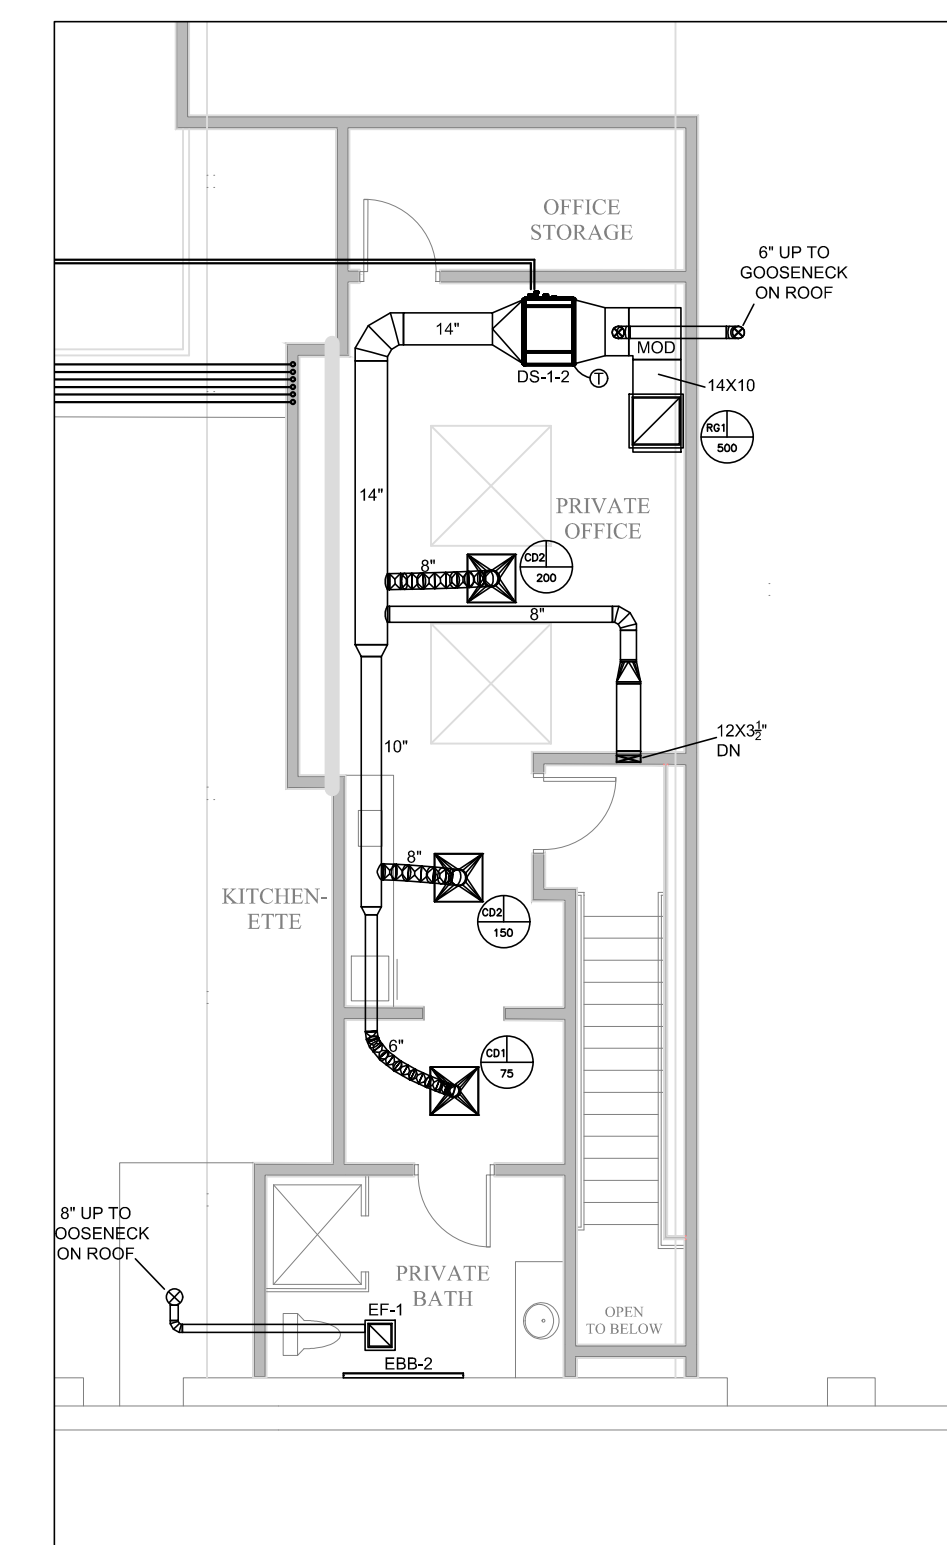


SECOND FLOOR HVAC PLAN
SCALE: 1/8" = 1'-0"

COMPLIANCE:

The HVAC systems shown on this plan comply with the 2009 Maine Uniform Building and Energy Code, including but not limited to the 2009 IMC, the 2009 IECC, ASHRAE 62, and NFPA 54.

01	ISSUED FOR REVIEW 08-02-17

AirTemp Inc.
20 Thomas Drive
Westbrook, Maine

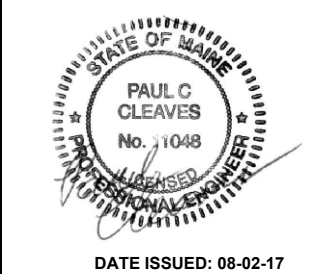

ALTA VISTA LLC
495 FOREST AVE
PORTLAND, MAINE

CLIENT
DATE
DRWN BY BRL
CHKD BY PCC
DATE AUG. 2, 2017

SHEET TITLE
HVAC FLOOR PLANS

SCALE
1/8" = 1'

DRAWING
M-1