





FIRST FLOOR PIPING PLAN  
SCALE: 1/8" = 1'-0"

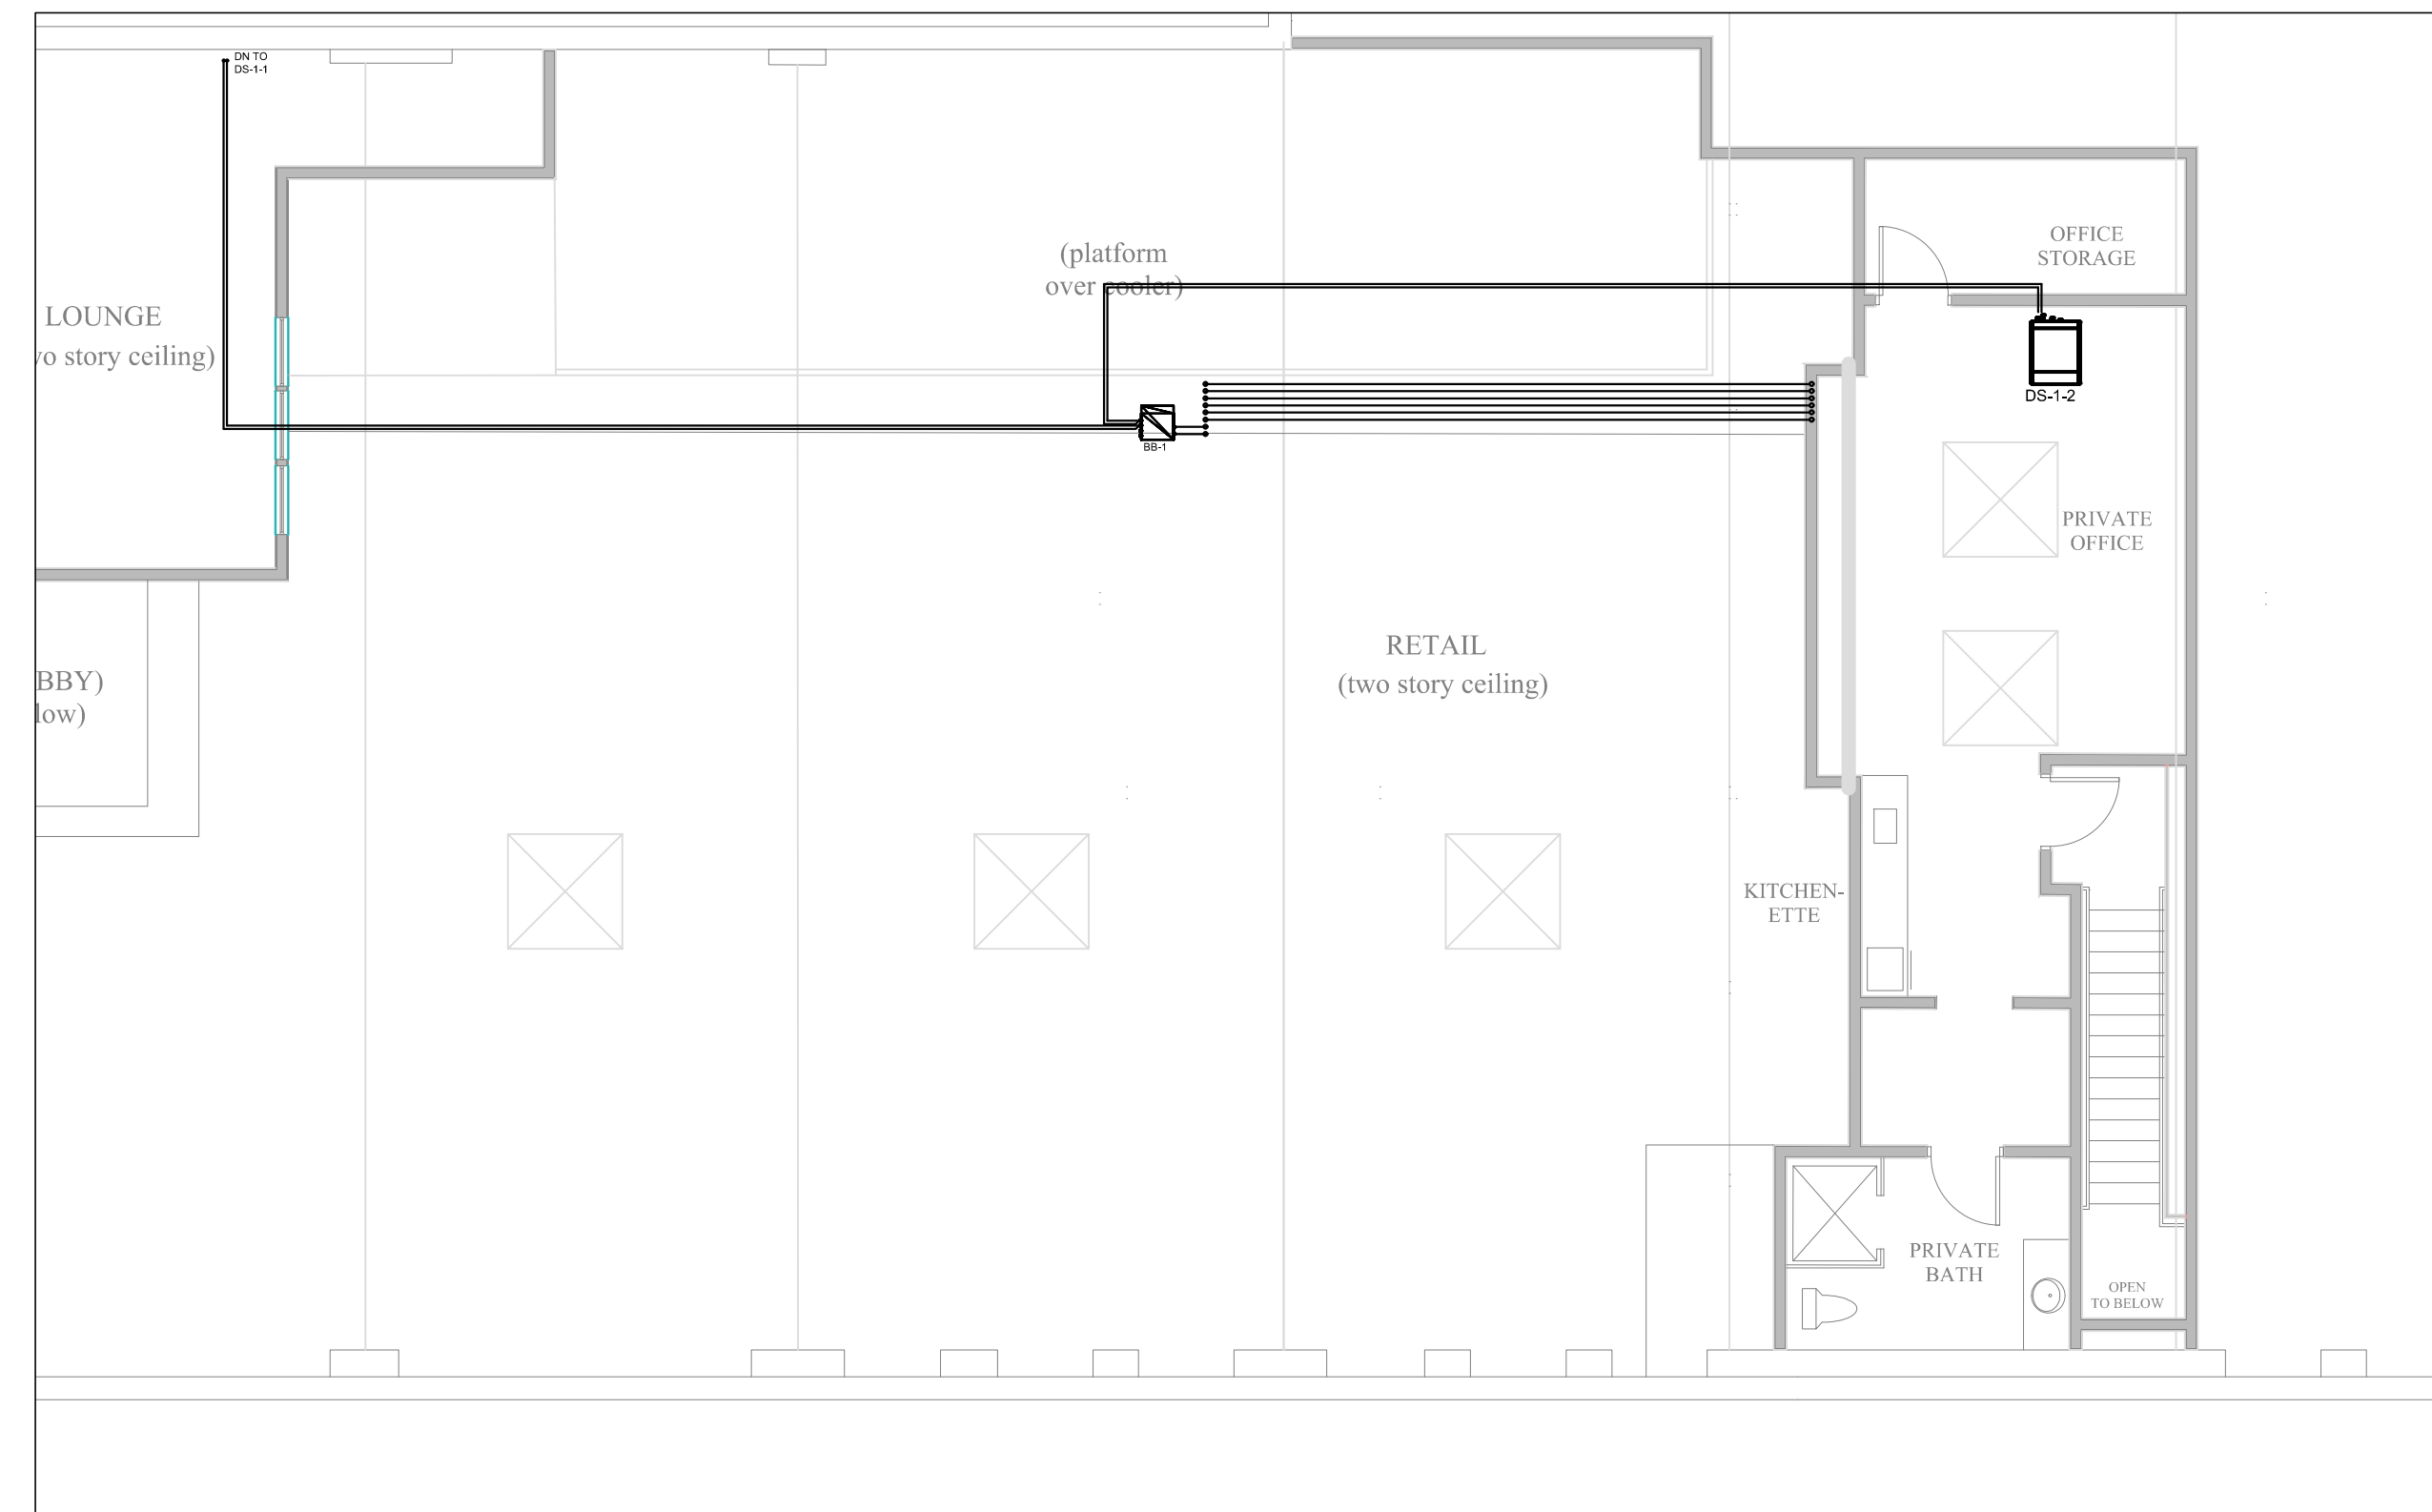

SECOND FLOOR PIPING PLAN  
SCALE: 1/8" = 1'-0"

01	ISSUED FOR REVIEW 08-02-17

AirTemp Inc.  
20 Thomas Drive  
Westbrook, Maine

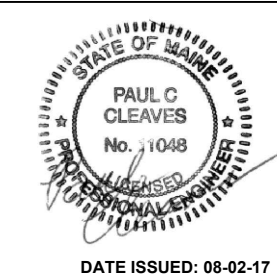

ALTA VISTA LLC  
495 FOREST AVE  
PORTLAND, MAINE

CLIENT	
DATE	
DRWN BY	BRL
CHKD BY	PCC
DATE	AUG. 02, 2017

SHEET TITLE  
MECHANICAL PIPING PLANS

SCALE  
1/8" = 1'

DRAWING  
M-2